

Hamden Middle School
Dixwell Avenue
Hamden, Connecticut



Project Status

KEY PLAN


DRAWING TITLE

LOWER LEVEL

STATE PROJ. NO.	
PROJ. NO.	191301
SCALE	1" = 20'-0"
DATE	Issue Date
DRAWN BY	Author
APPROVED BY	Approver

[illegible]

A1.00

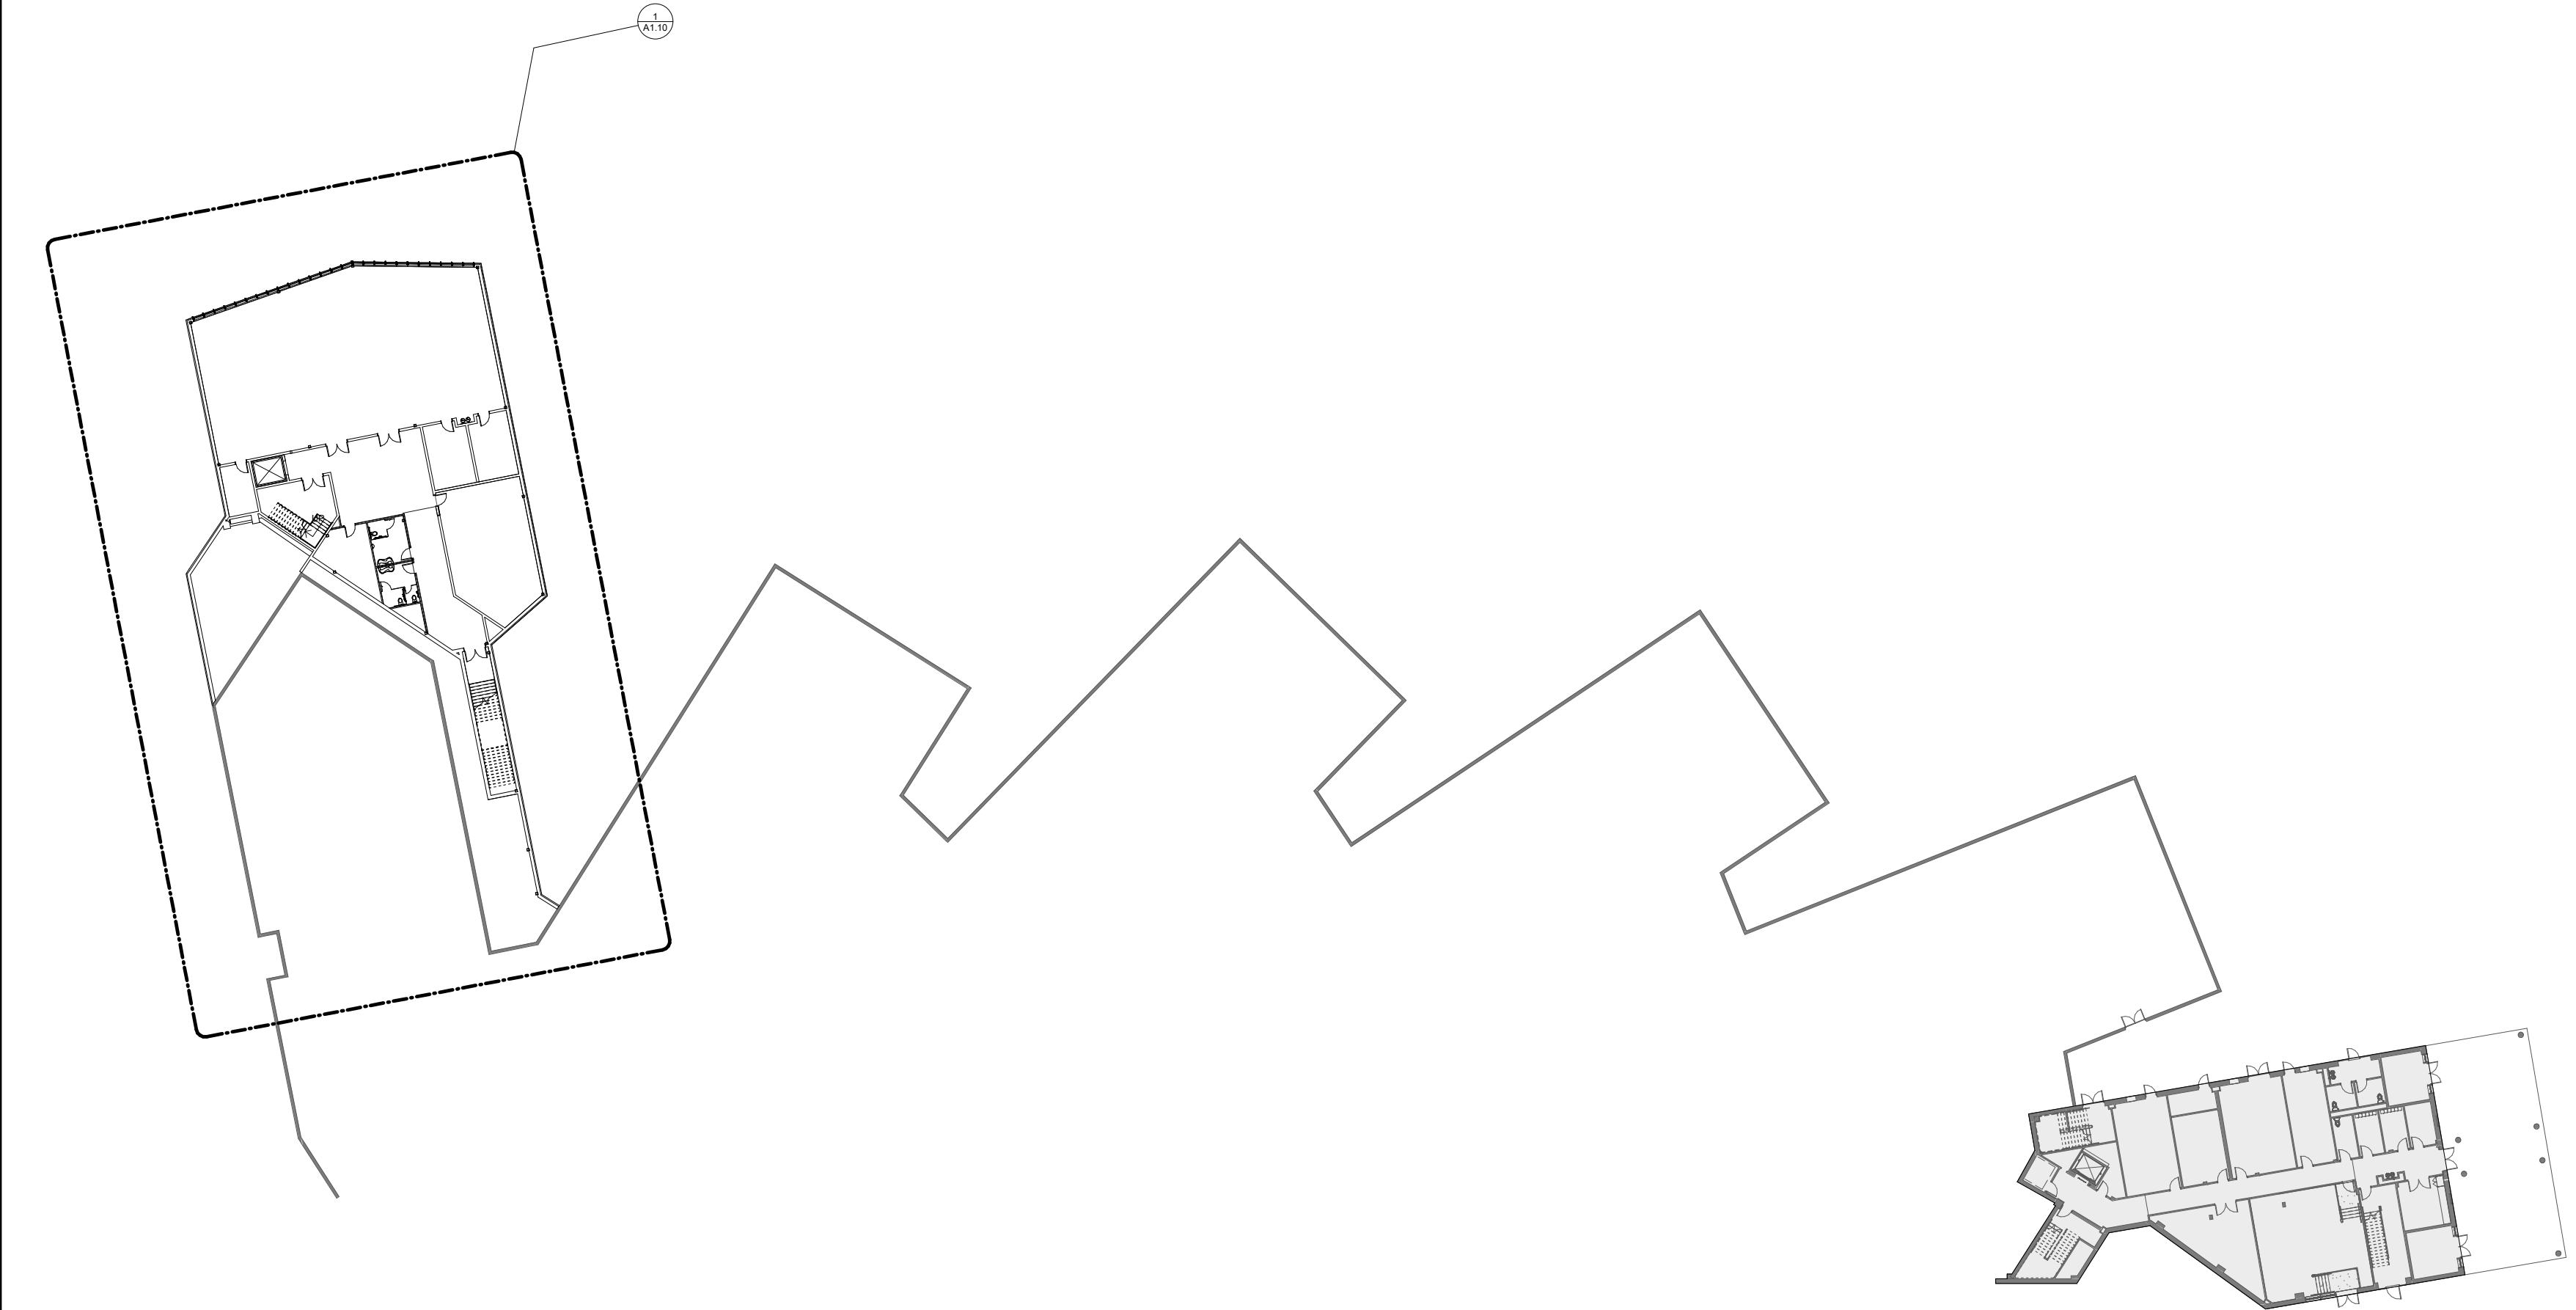

1 LOWER LEVEL
1" = 20'-0"

Hamden Middle School
Dixwell Avenue
Hamden, Connecticut



Project Status

KEY PLAN


DRAWING TITLE

FIRST FLOOR PLAN

STATE PROJ. NO.	
PROJ. NO.	191301
SCALE	1" = 20'-0"
DATE	Issue Date
DRAWN BY	Author
APPROVED BY	Approver

ISSUE DATES		
NO.	DATE	PURPOSE

A1.01

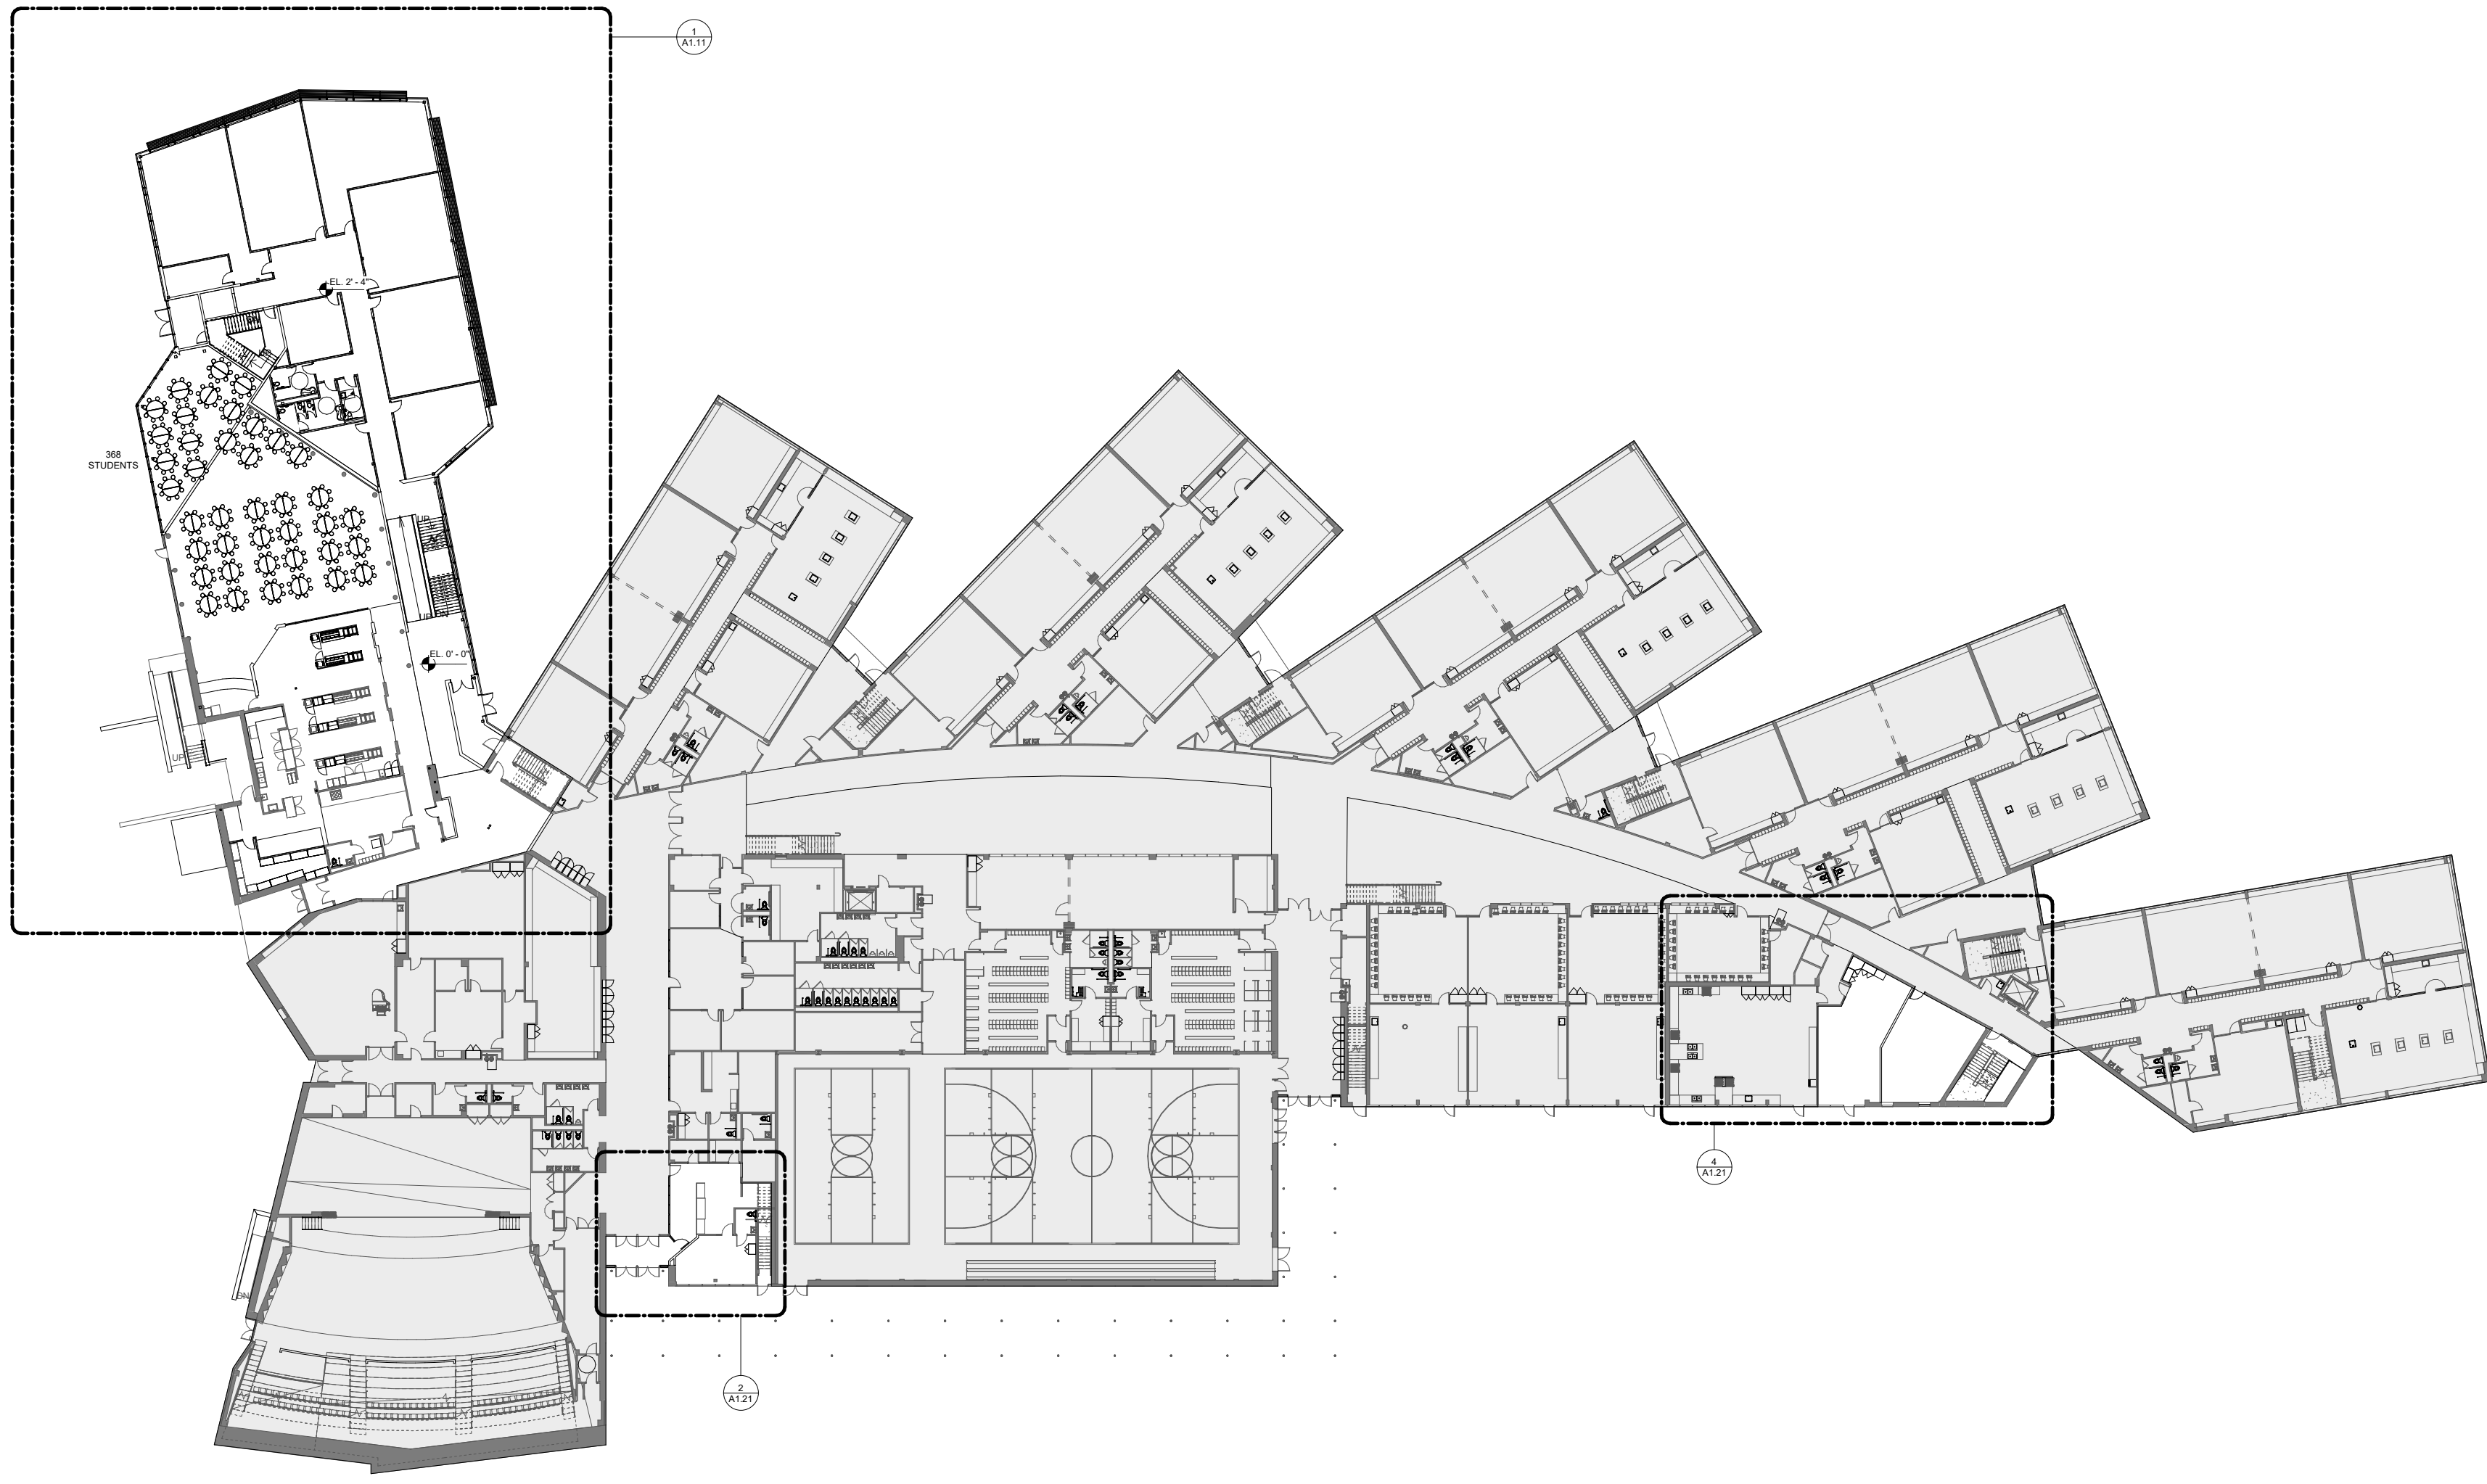

1 FIRST FLOOR PLAN 30X42
1" = 20'-0"

Hamden Middle School

Dixwell Avenue

Hamden, Connecticut



Project Status

KEY PLAN


DRAWING TITLE

SECOND FLOOR PLAN

STATE PROJ. NO.	
PROJ. NO.	191301
SCALE	1" = 20'-0"
DATE	Issue Date
DRAWN BY	Author
APPROVED BY	Approver

ISSUE DATES		
NO.	DATE	PURPOSE

A1.02

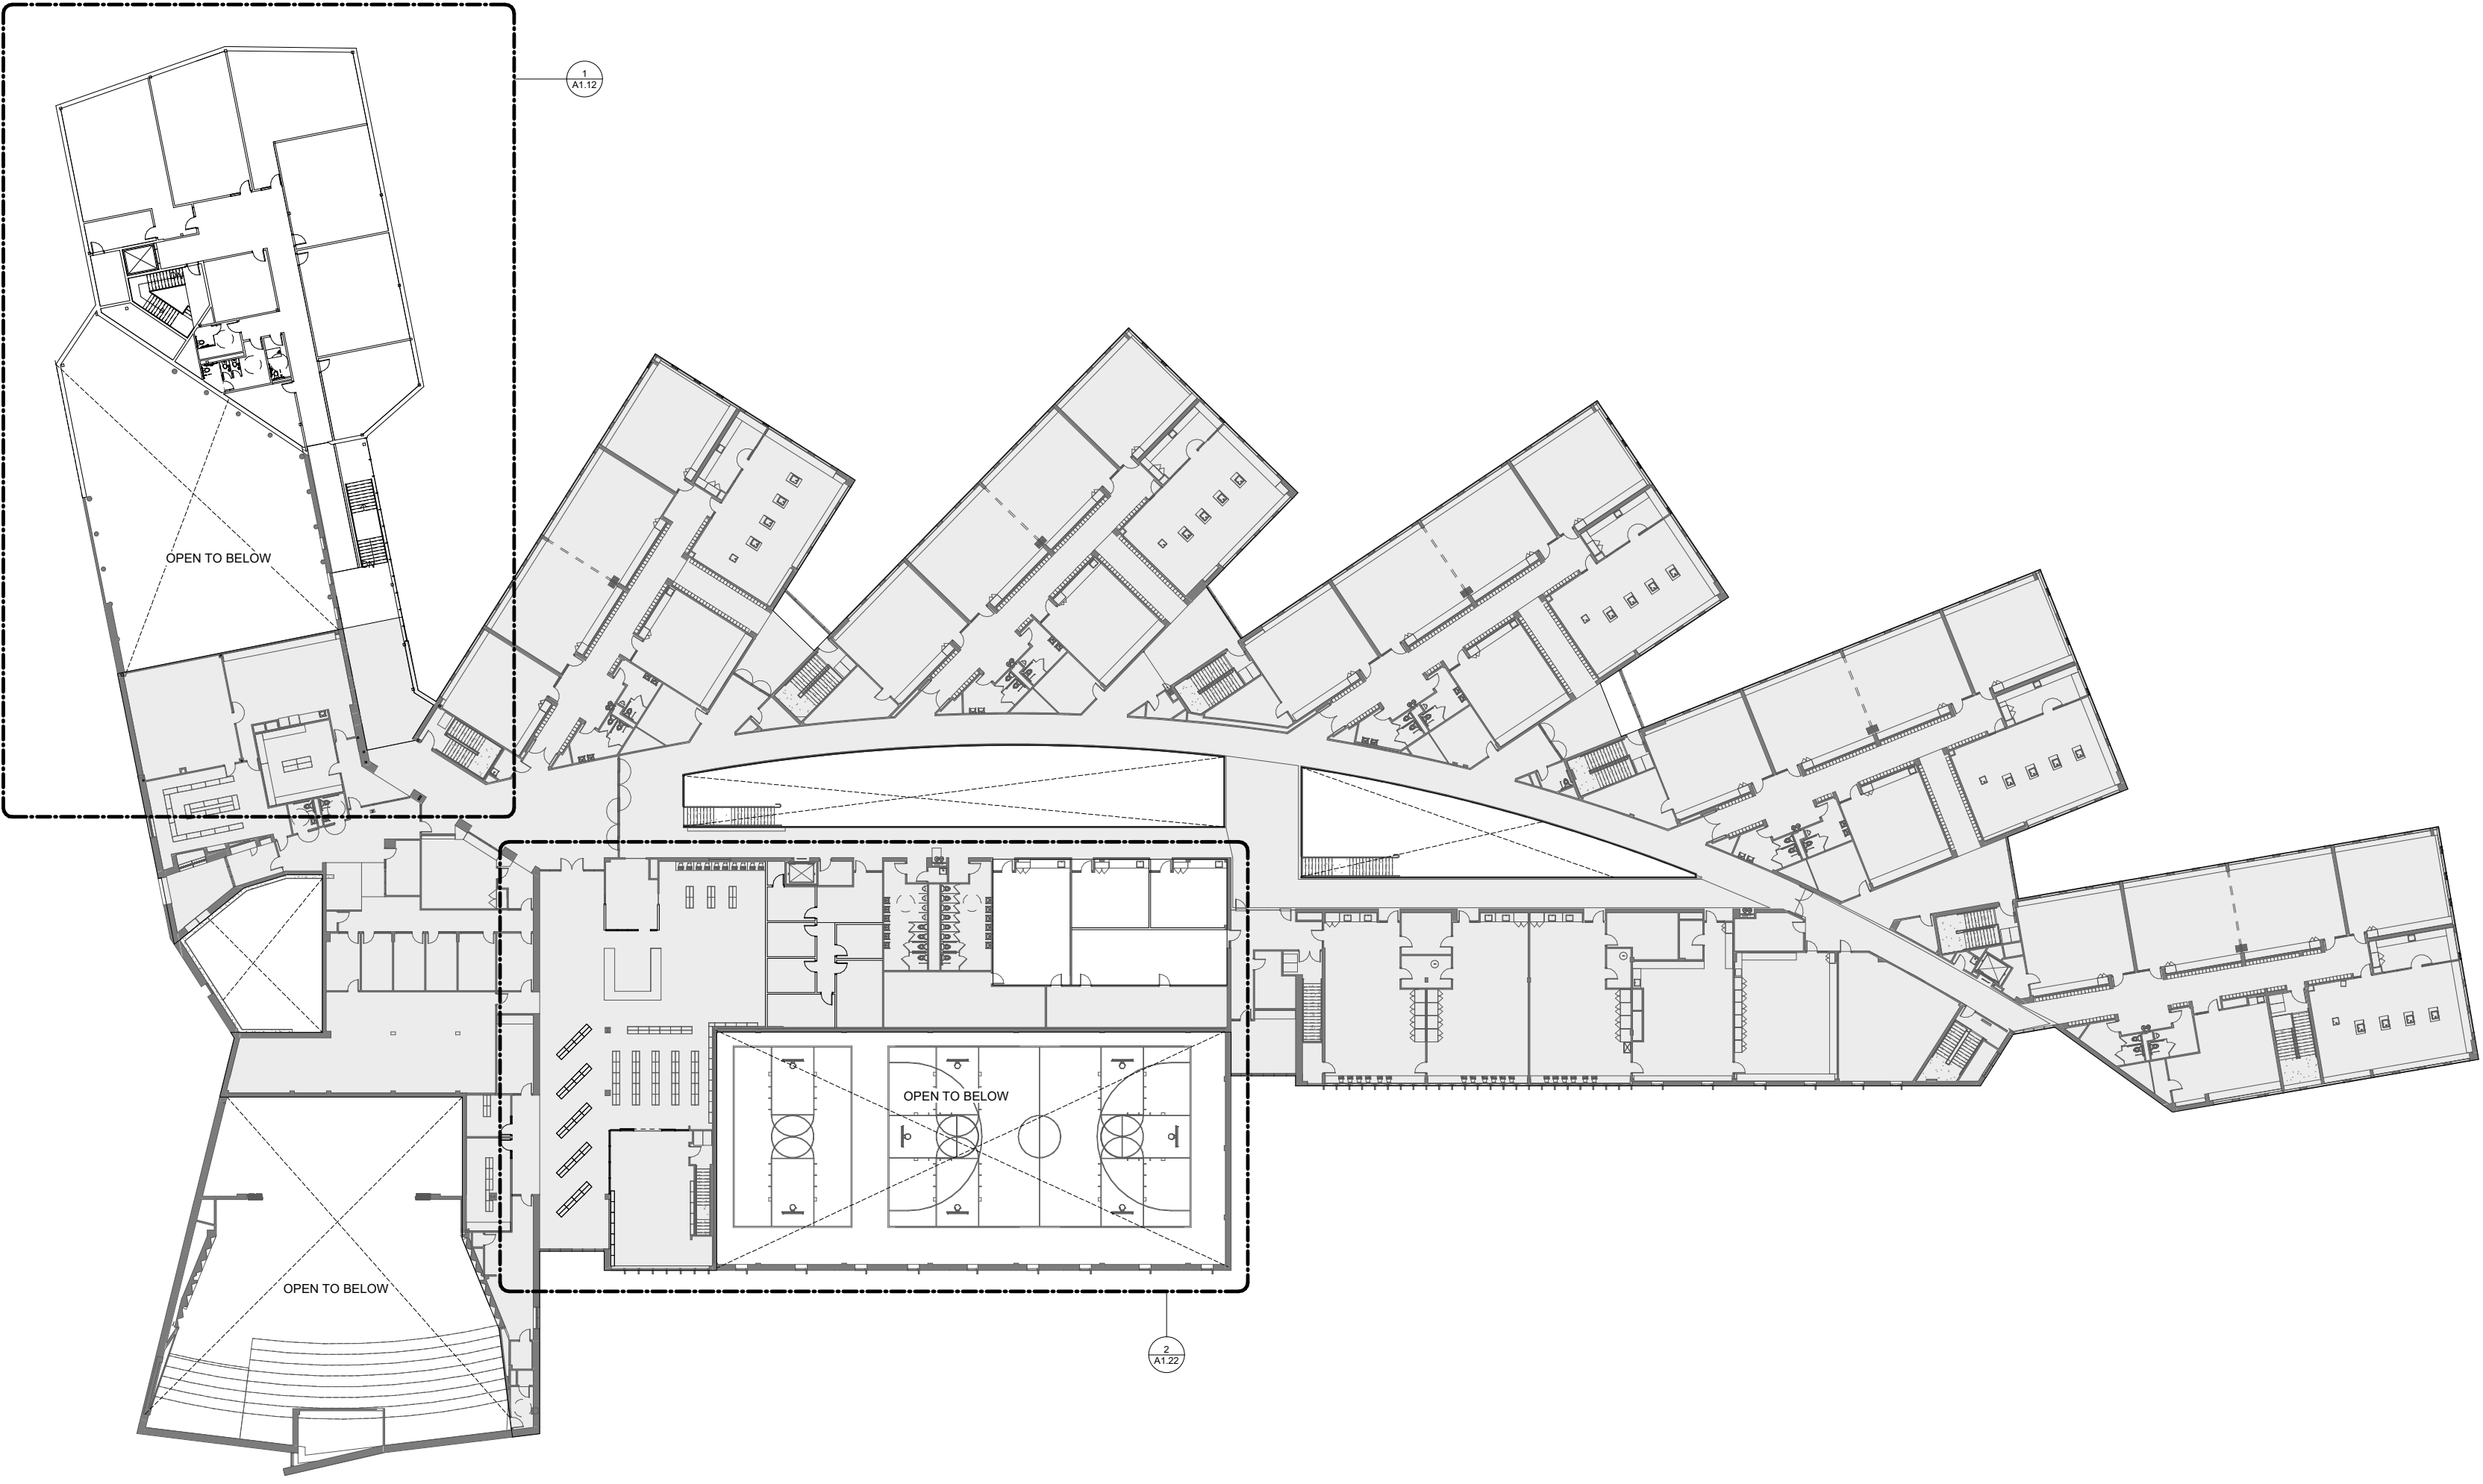

1 SECOND FLOOR PLAN 30X42
1" = 20'-0"

Hamden Middle School

Dixwell Avenue

Hamden, Connecticut



Project Status

KEY PLAN


DRAWING TITLE

ENLARGED LOWER LEVEL

STATE PROJ. NO.	
PROJ. NO.	191301
SCALE	1/8" = 1'-0"
DATE	Issue Date
DRAWN BY	Author
APPROVED BY	Approver

ISSUE DATES		
NO.	DATE	PURPOSE

A1.10

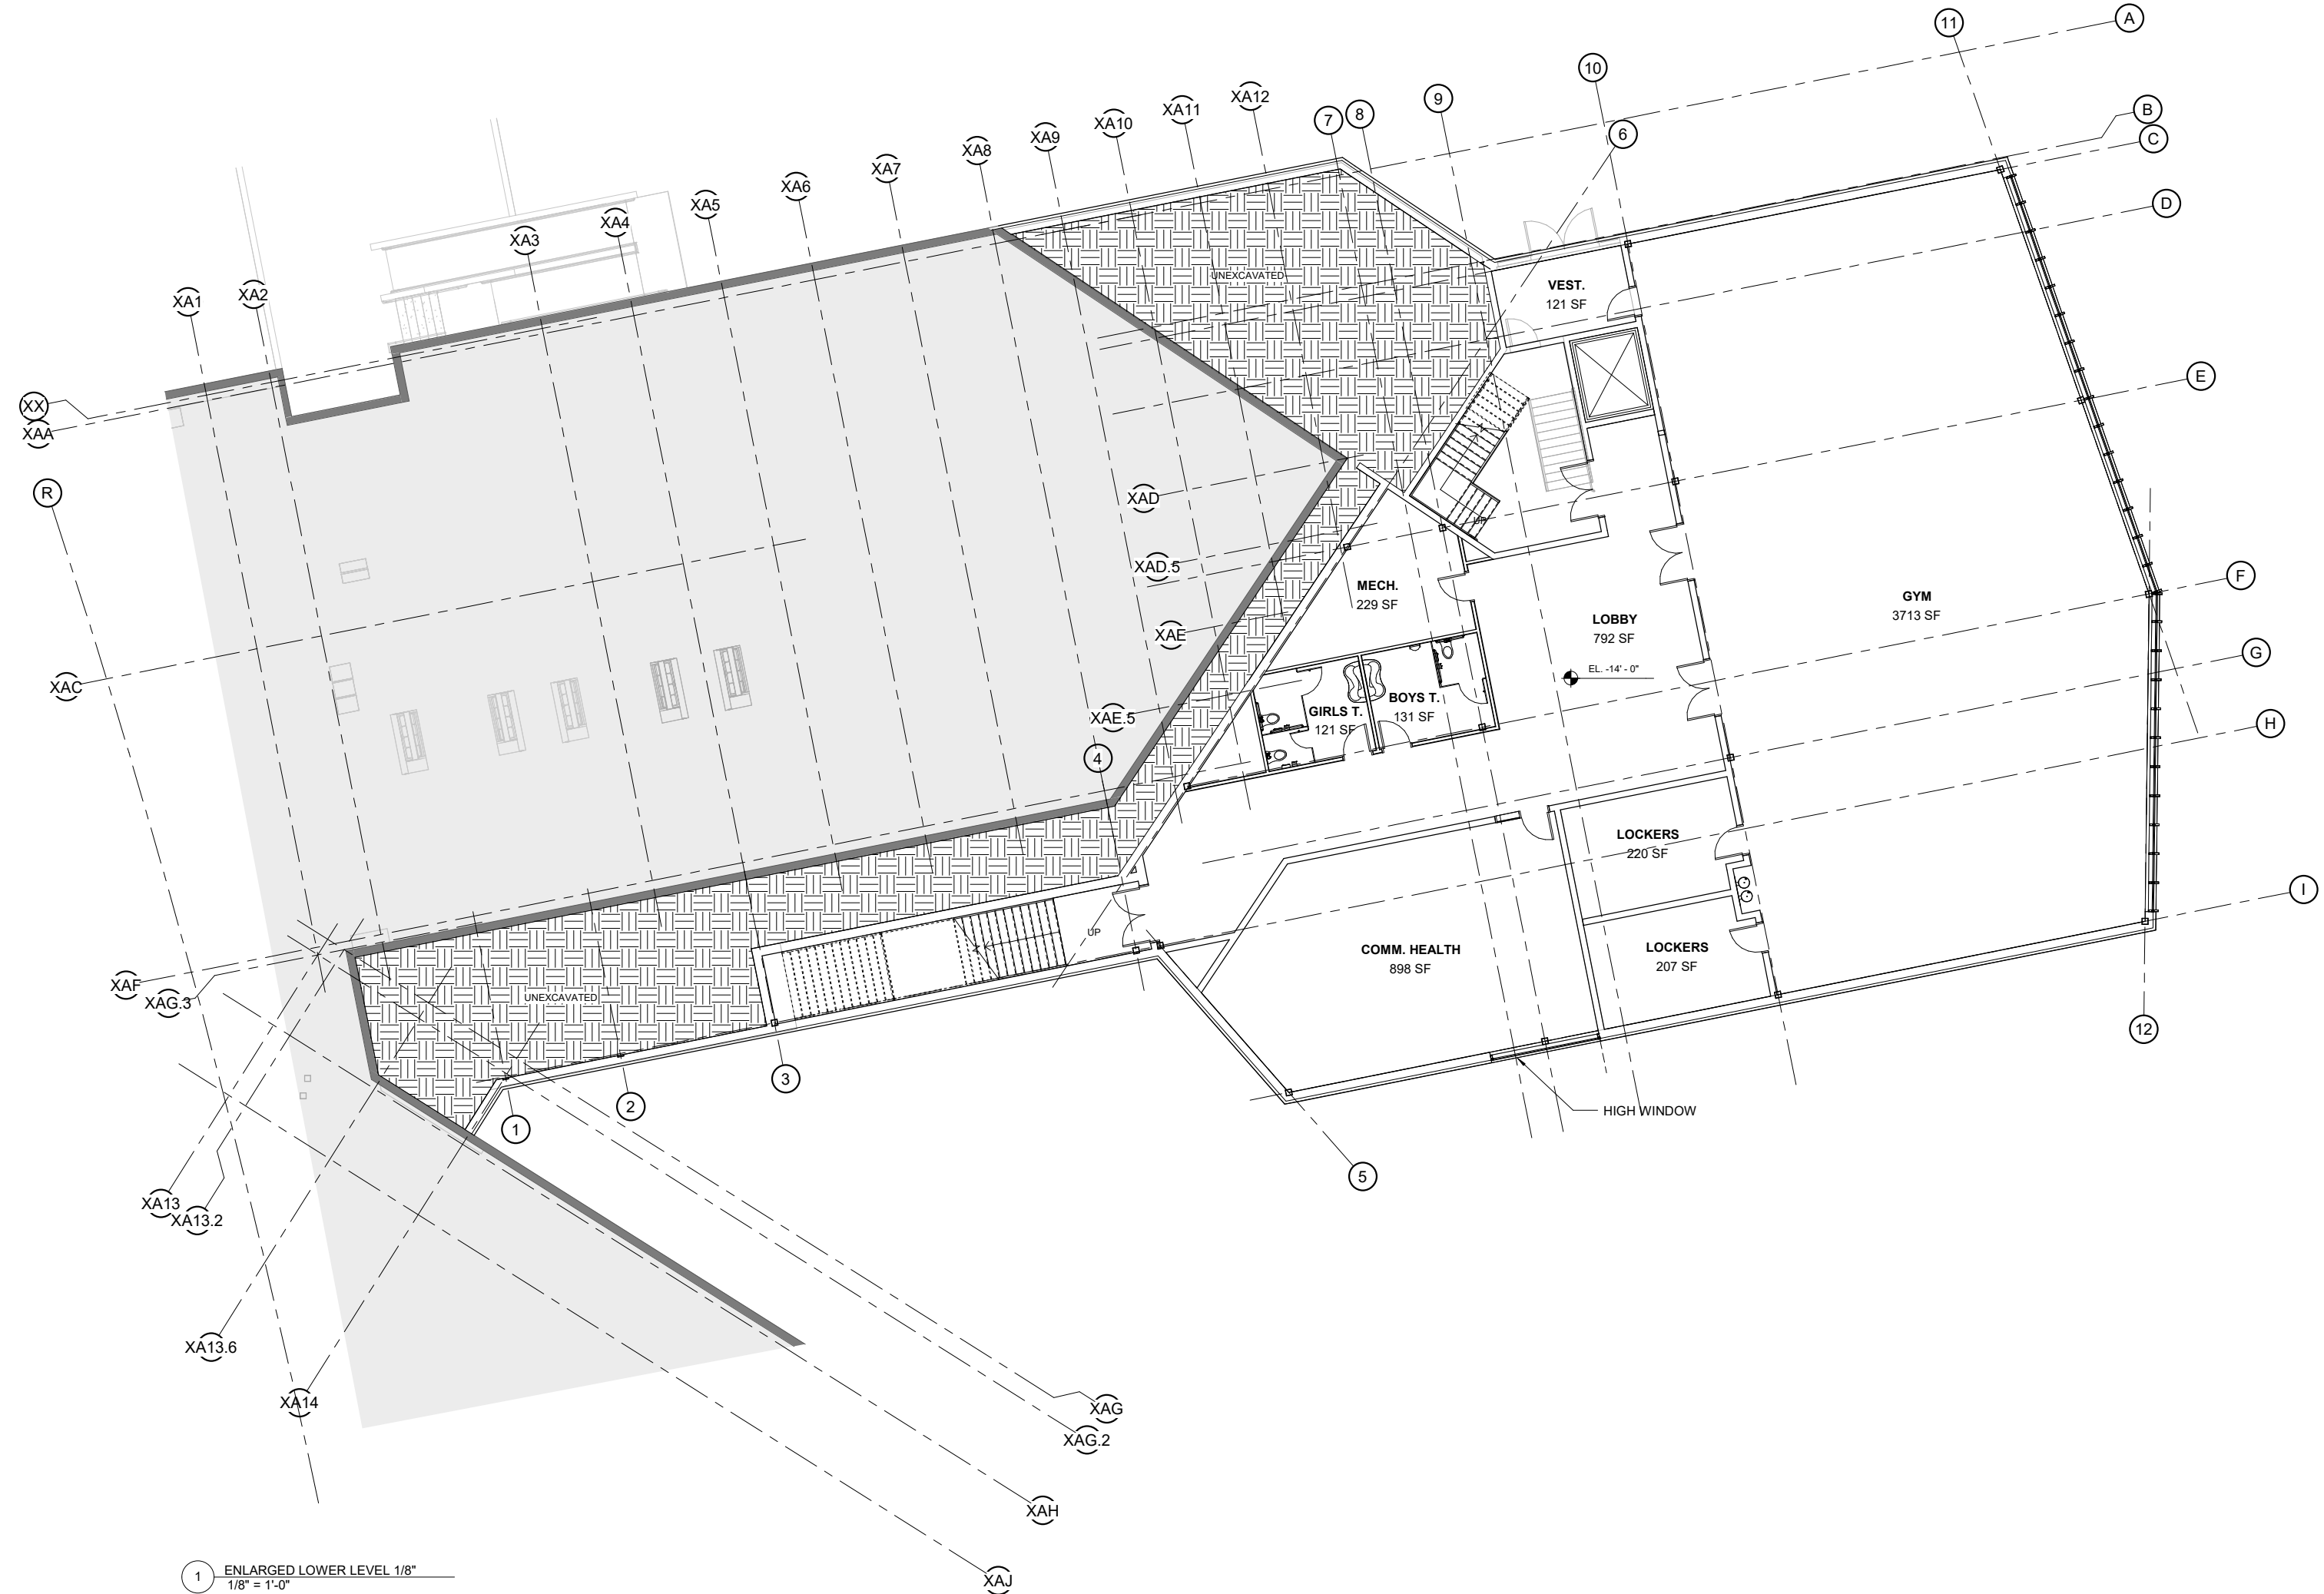

1 ENLARGED LOWER LEVEL 1/8"
1/8" = 1'-0"

Hamden Middle School
Dixwell Avenue
Hamden, Connecticut



Project Status

KEY PLAN


DRAWING TITLE

ENLARGED FIRST FLOOR

STATE PROJ. NO.	
PROJ. NO.	191301
SCALE	1/8" = 1'-0"
DATE	Issue Date
DRAWN BY	Author
APPROVED BY	Approver

ISSUE DATES		
NO.	DATE	PURPOSE

A1.11

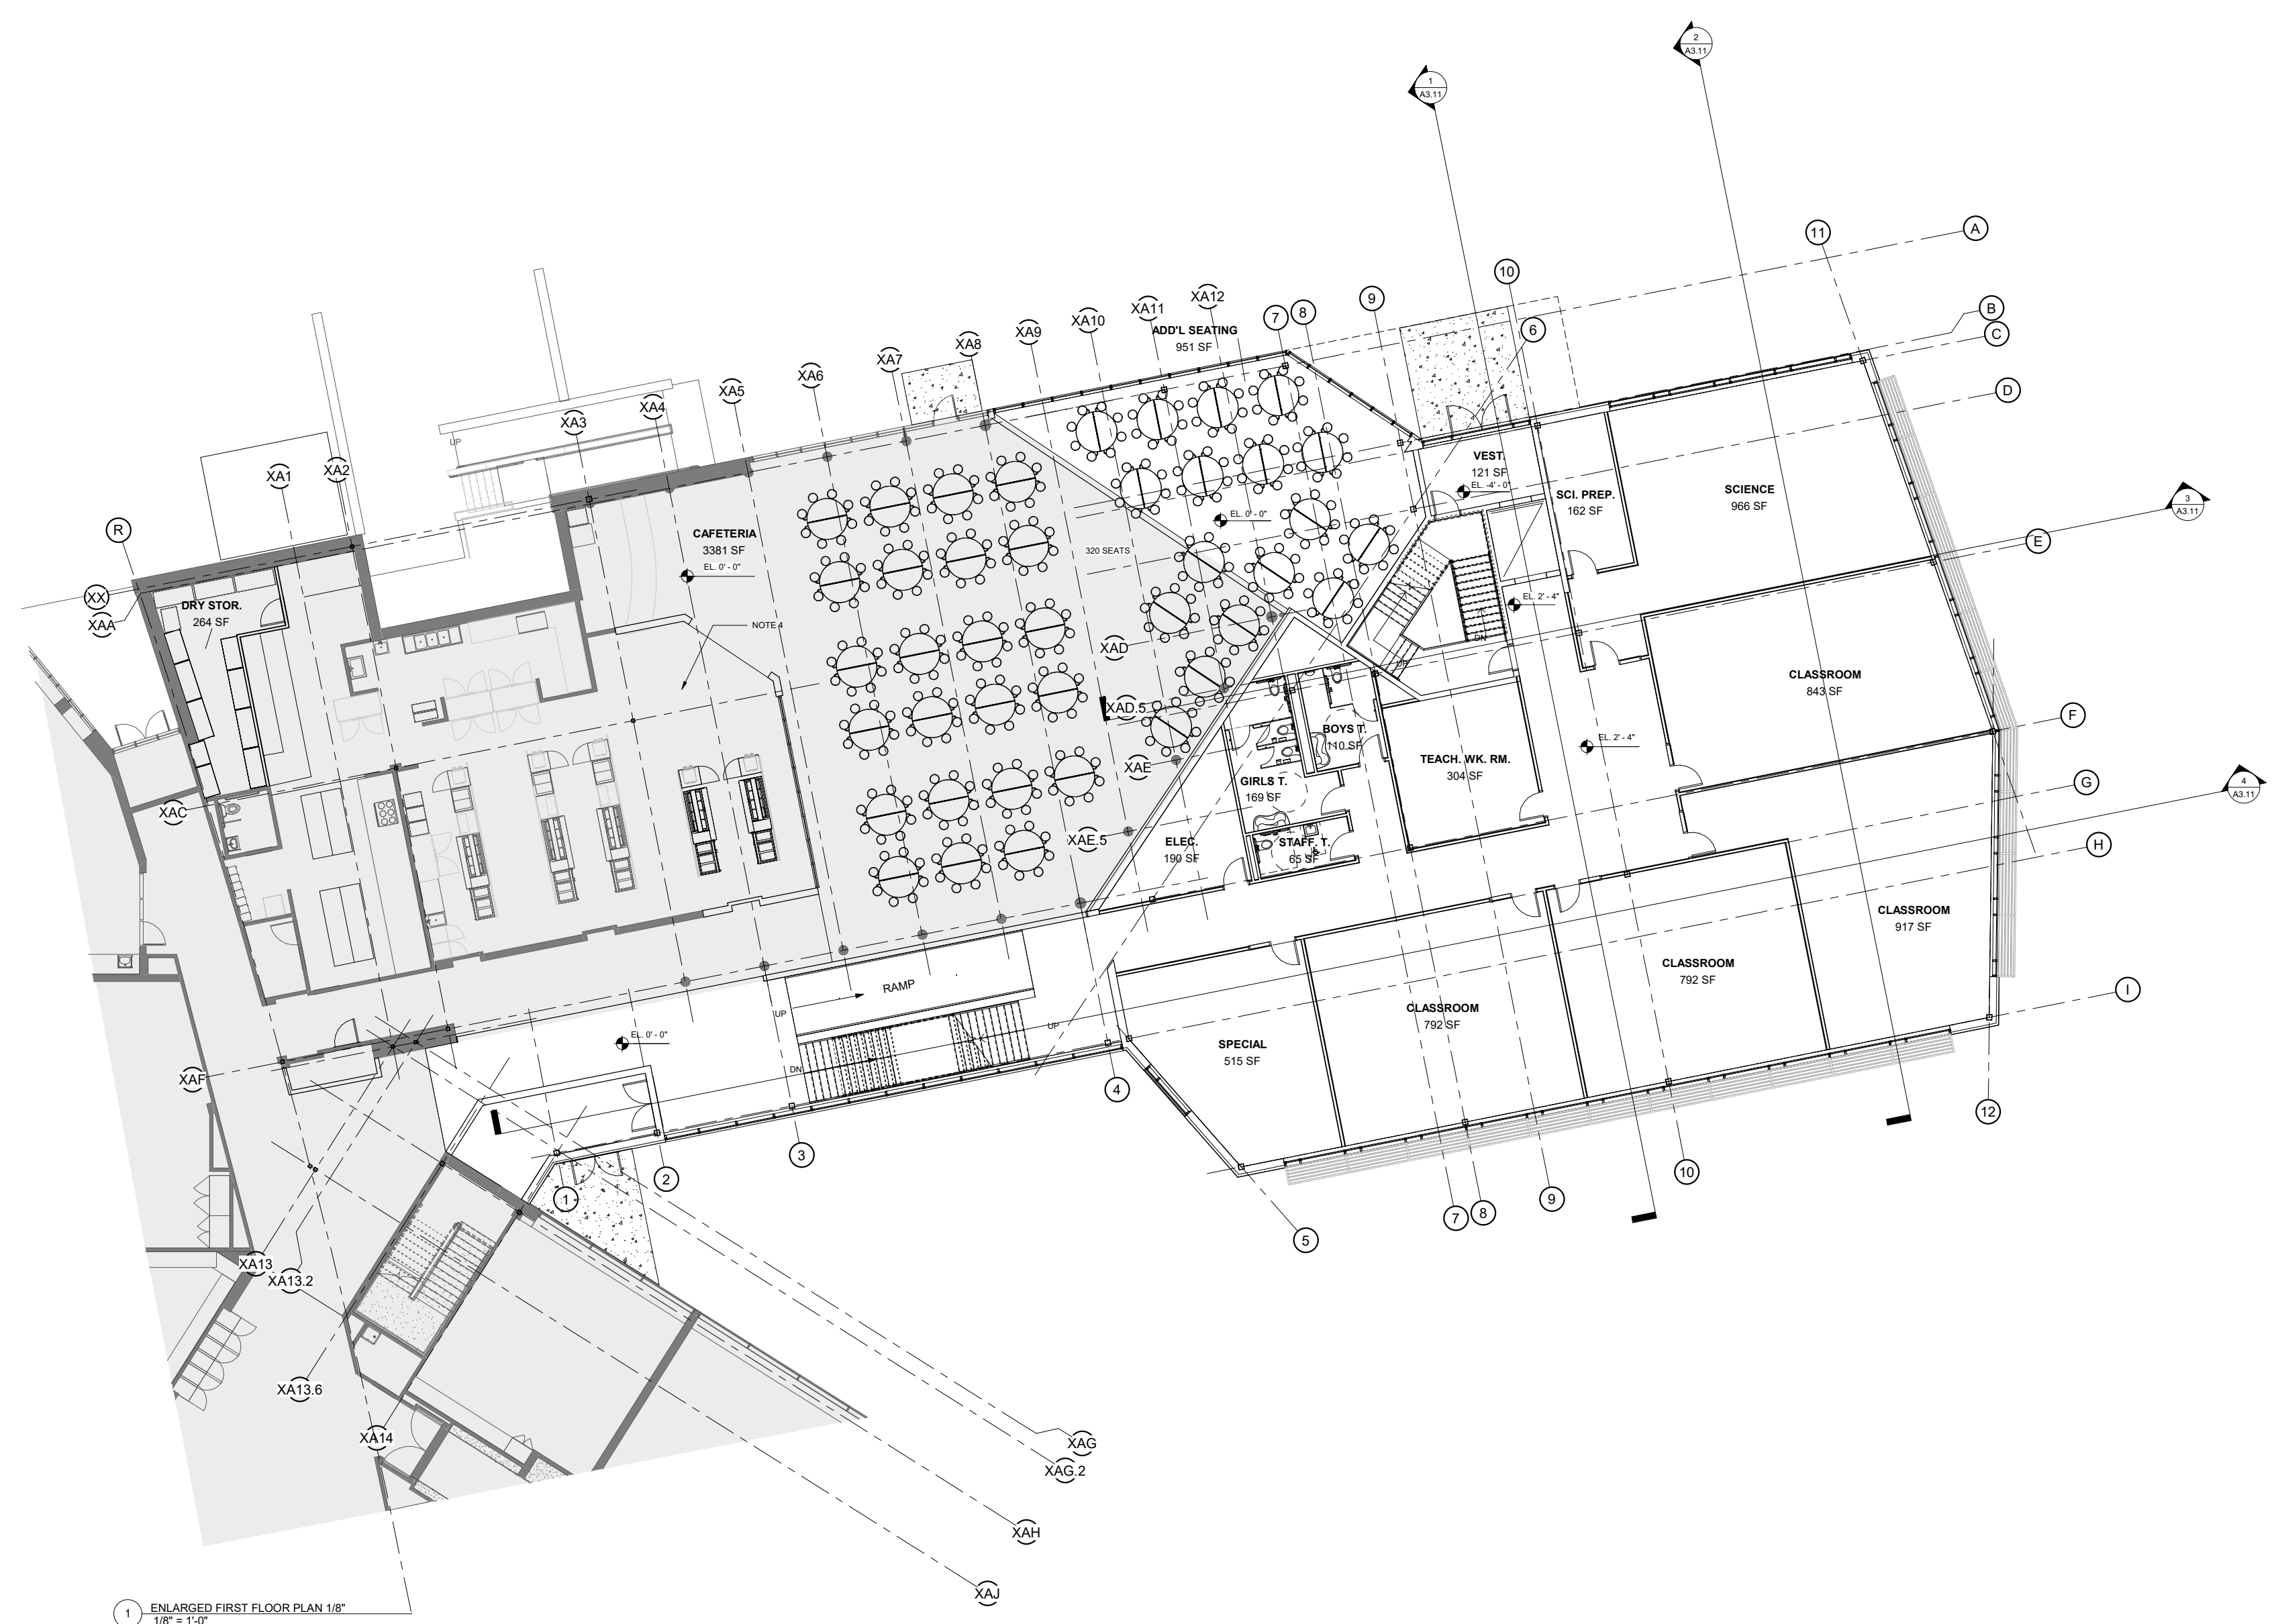

1 ENLARGED FIRST FLOOR PLAN 1/8"
1/8" = 1'-0"

Hamden Middle School

Dixwell Avenue

Hamden, Connecticut



Project Status

KEY PLAN


DRAWING TITLE

ENLARGED SECOND FLOOR

STATE PROJ. NO.	
PROJ. NO.	191301
SCALE	1/8" = 1'-0"
DATE	Issue Date
DRAWN BY	Author
APPROVED BY	Approver

ISSUE DATES		
NO.	DATE	PURPOSE

A1.12

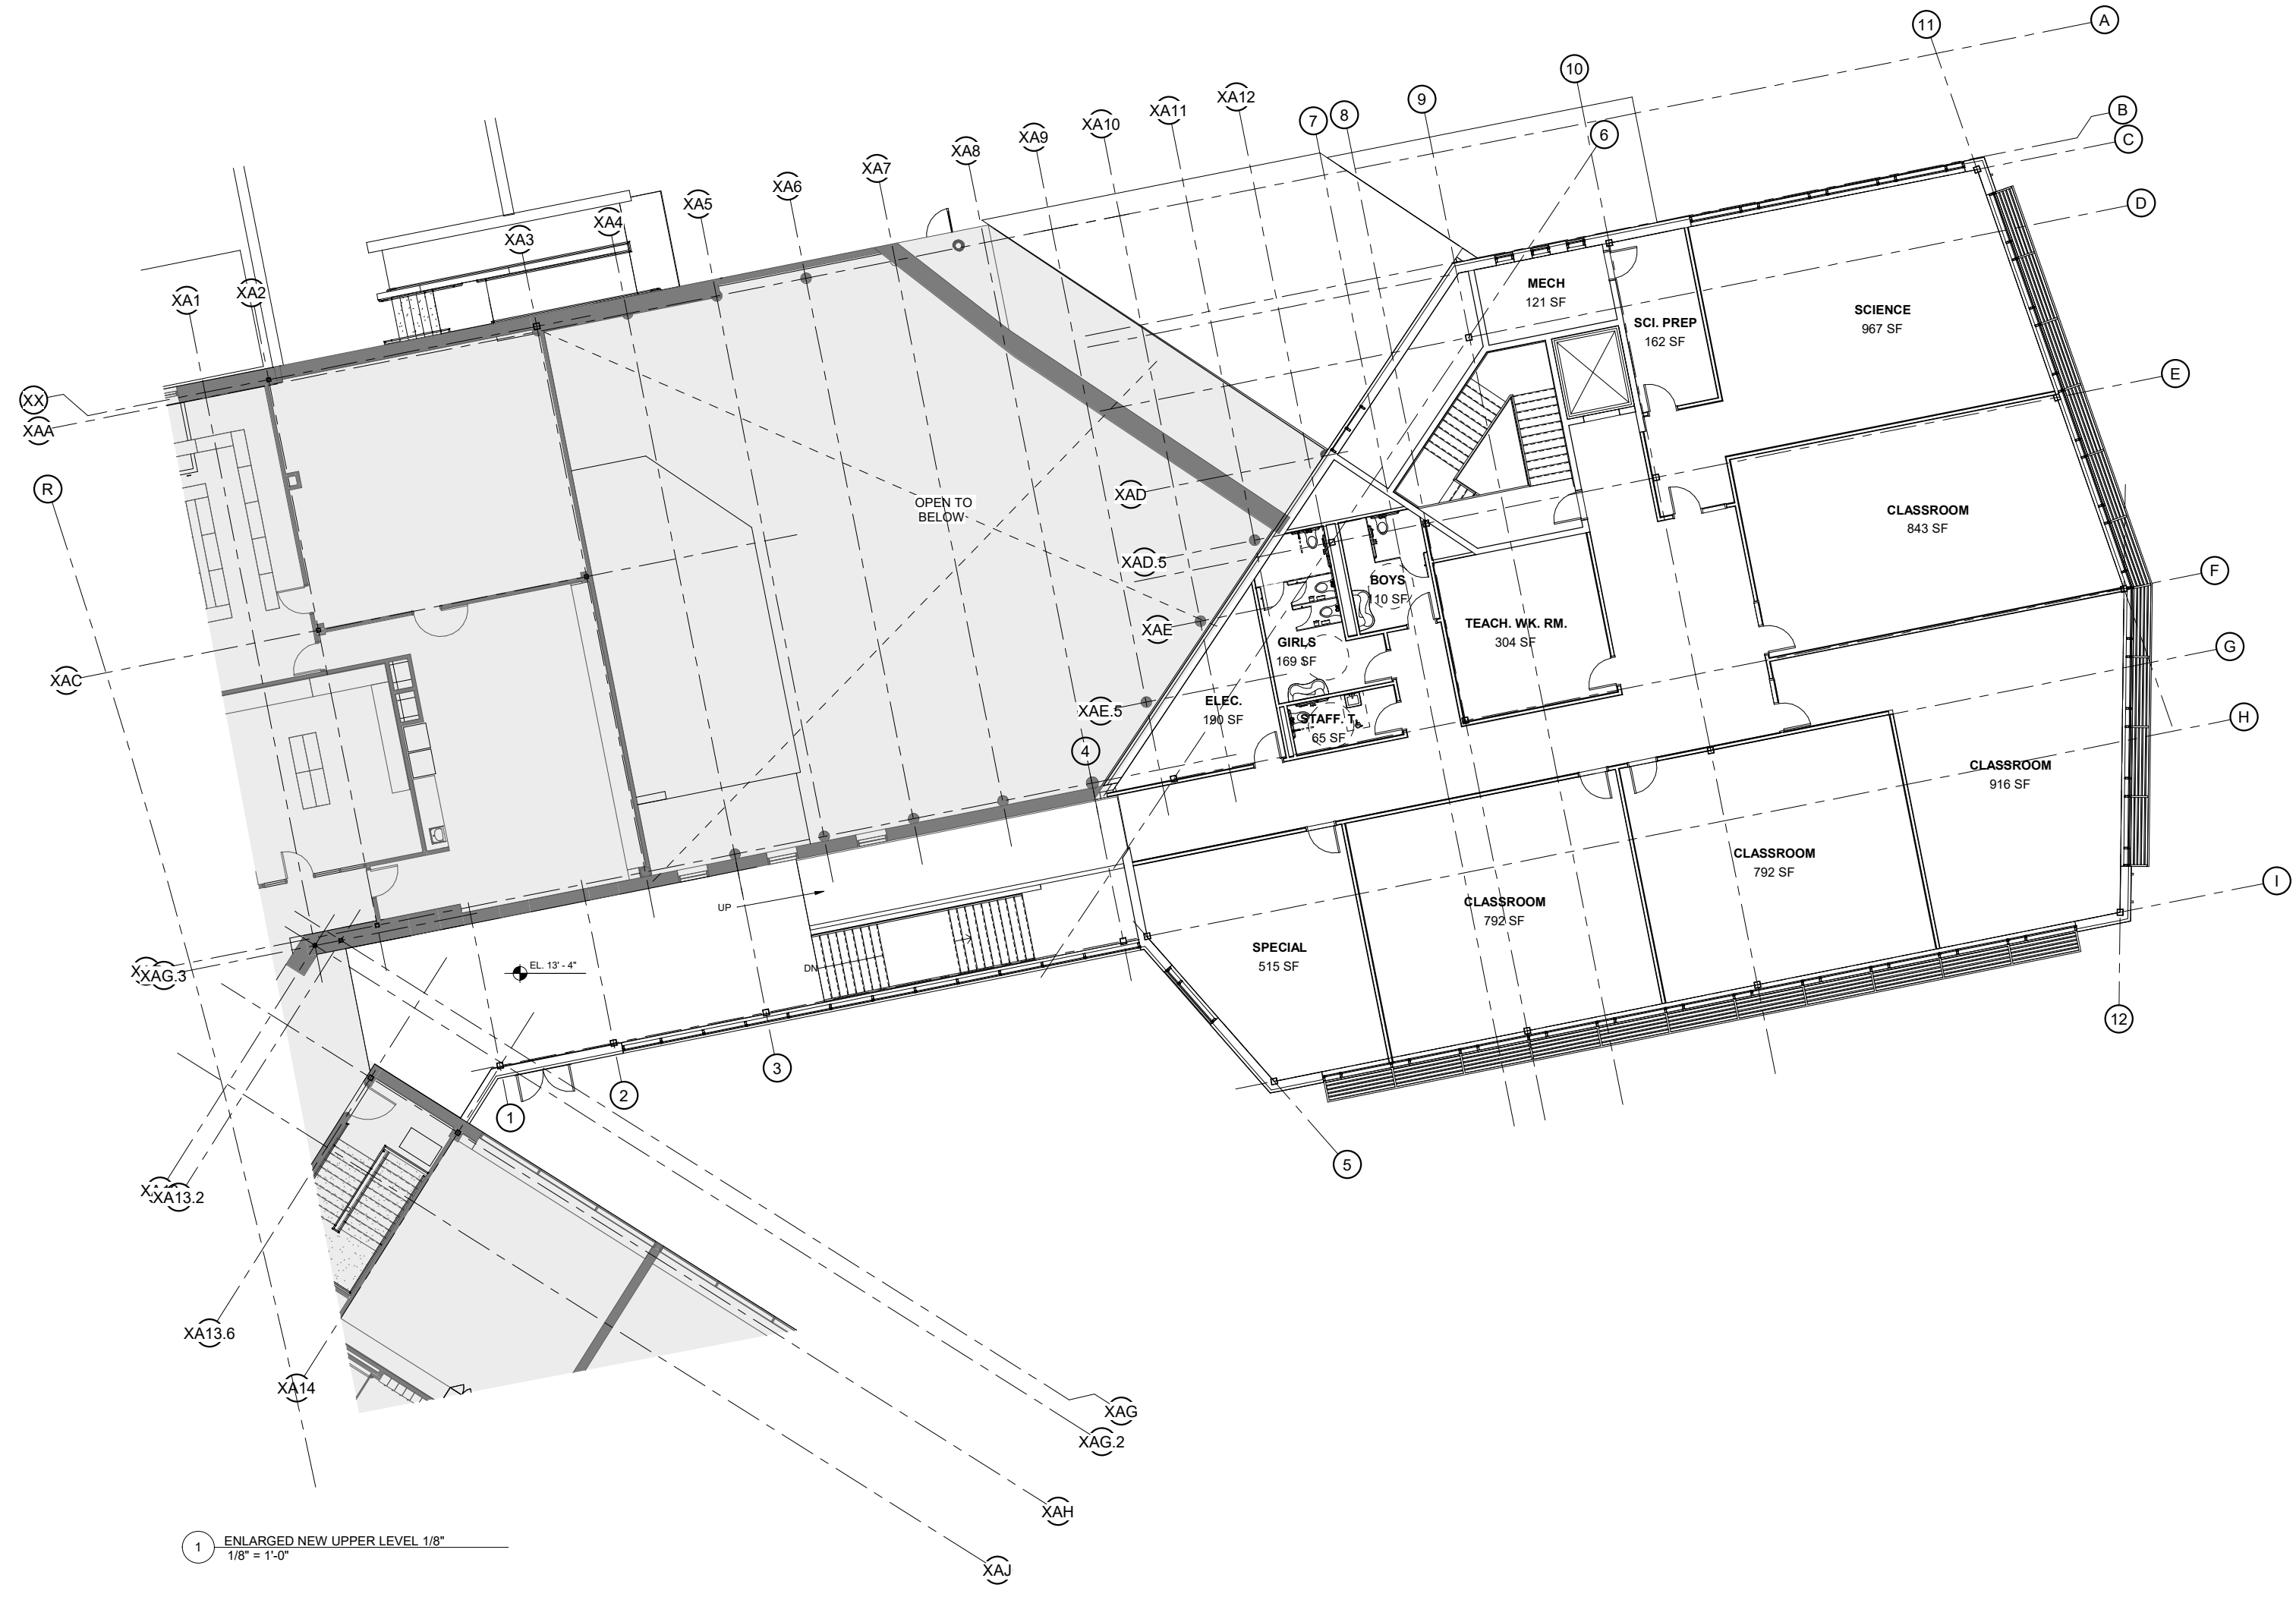


1 ENLARGED NEW UPPER LEVEL 1/8"
1/8" = 1'-0"

4/6/2020 12:32:15 PM C:\Users\mscott\Documents\19018.02 Hamden Middle School-Central\2019_mscott.rvt



Hamden Middle School
Dixwell Avenue
Hamden, Connecticut

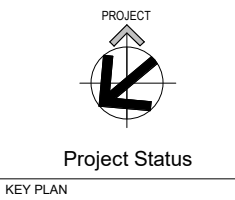

DRAWING TITLE

FIRST FLOOR
RENOVATION PLANS

STATE PROJ. NO.	
PROJ. NO.	191301
SCALE	1/8" = 1'-0"
DATE	Issue Date
DRAWN BY	Author
APPROVED BY	Approver


ISSUE DATES		
NO.	DATE	PURPOSE

KEY PLAN

DATE PROJ. NO.	
PROJ. NO.	191301
SCALE	1/8" = 1'-0"
DATE	Issue Date
DRAWN BY	Author
APPROVED BY	Approver

ISSUE DATES

A1.22

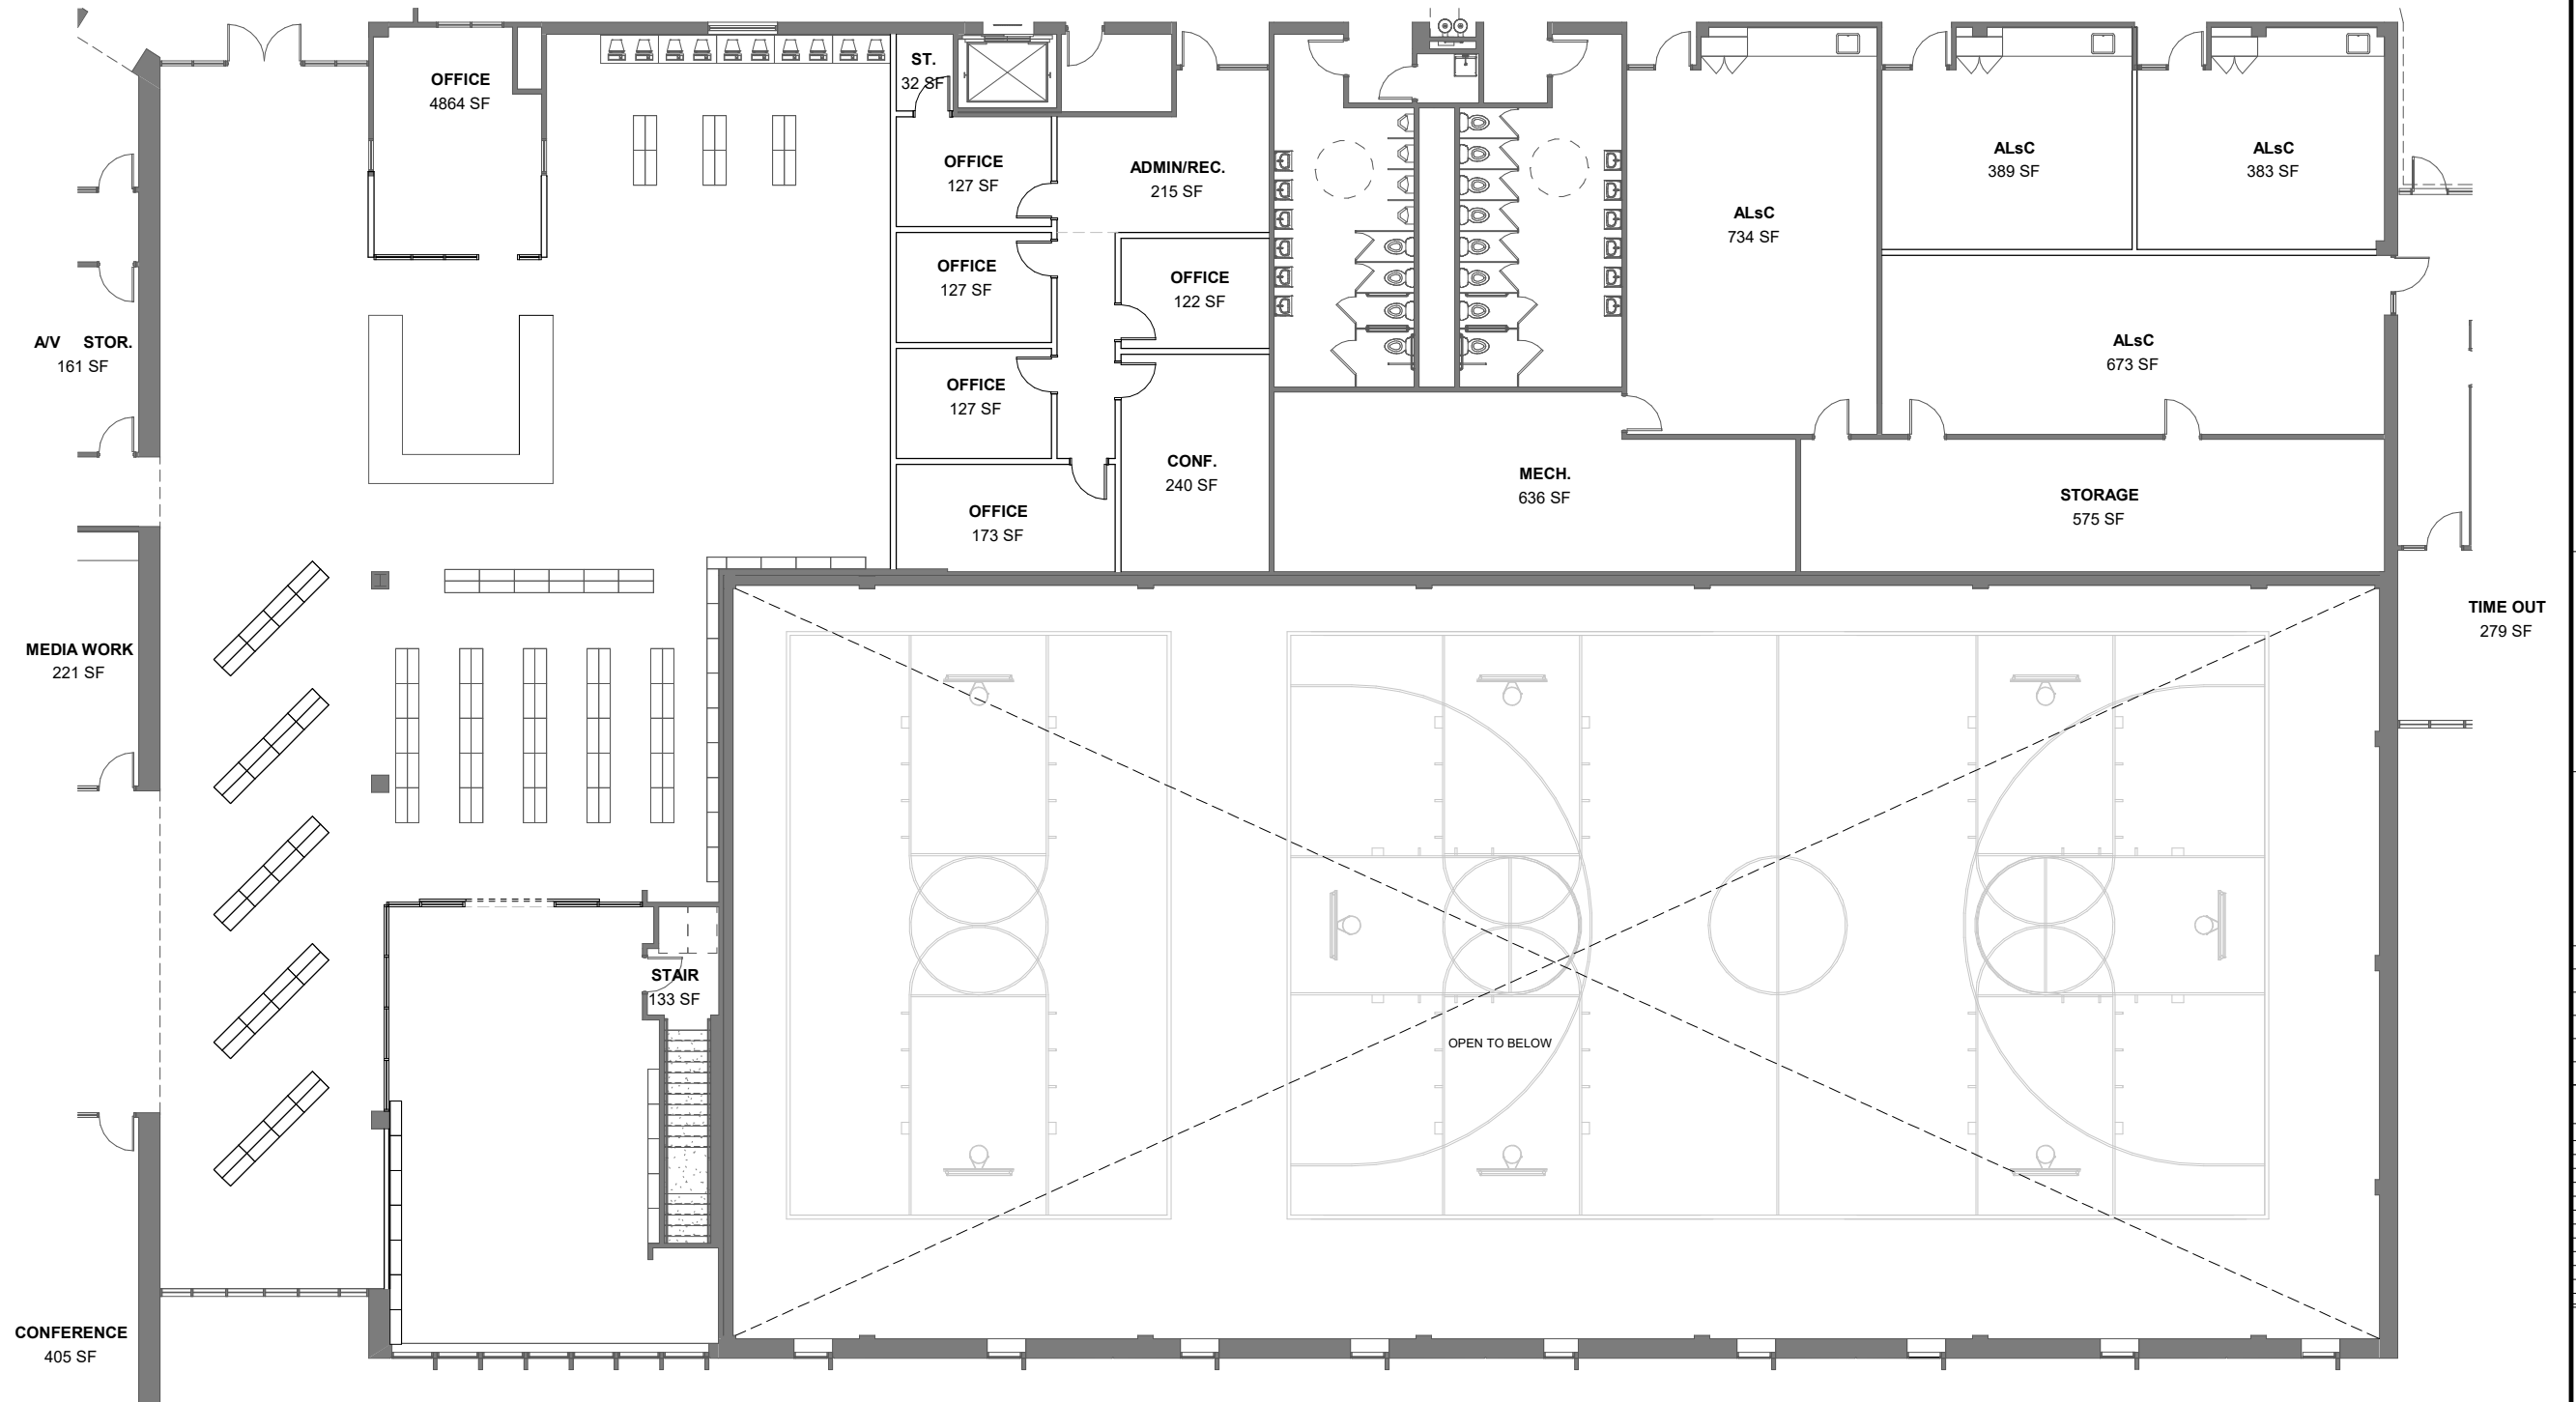

2 MEDIA CENTER - PROPOSED CD
1/8" = 1'-0"

Hamden Middle School
Dixwell Avenue
Hamden, Connecticut



Project Status

KEY PLAN


DRAWING TITLE

ENLARGED ROOF LEVEL


STATE PROJ. NO.	
PROJ. NO.	191301
SCALE	1/8" = 1'-0"
DATE	Issue Date
DRAWN BY	Author
APPROVED BY	Approver

[illegible]


A1.40

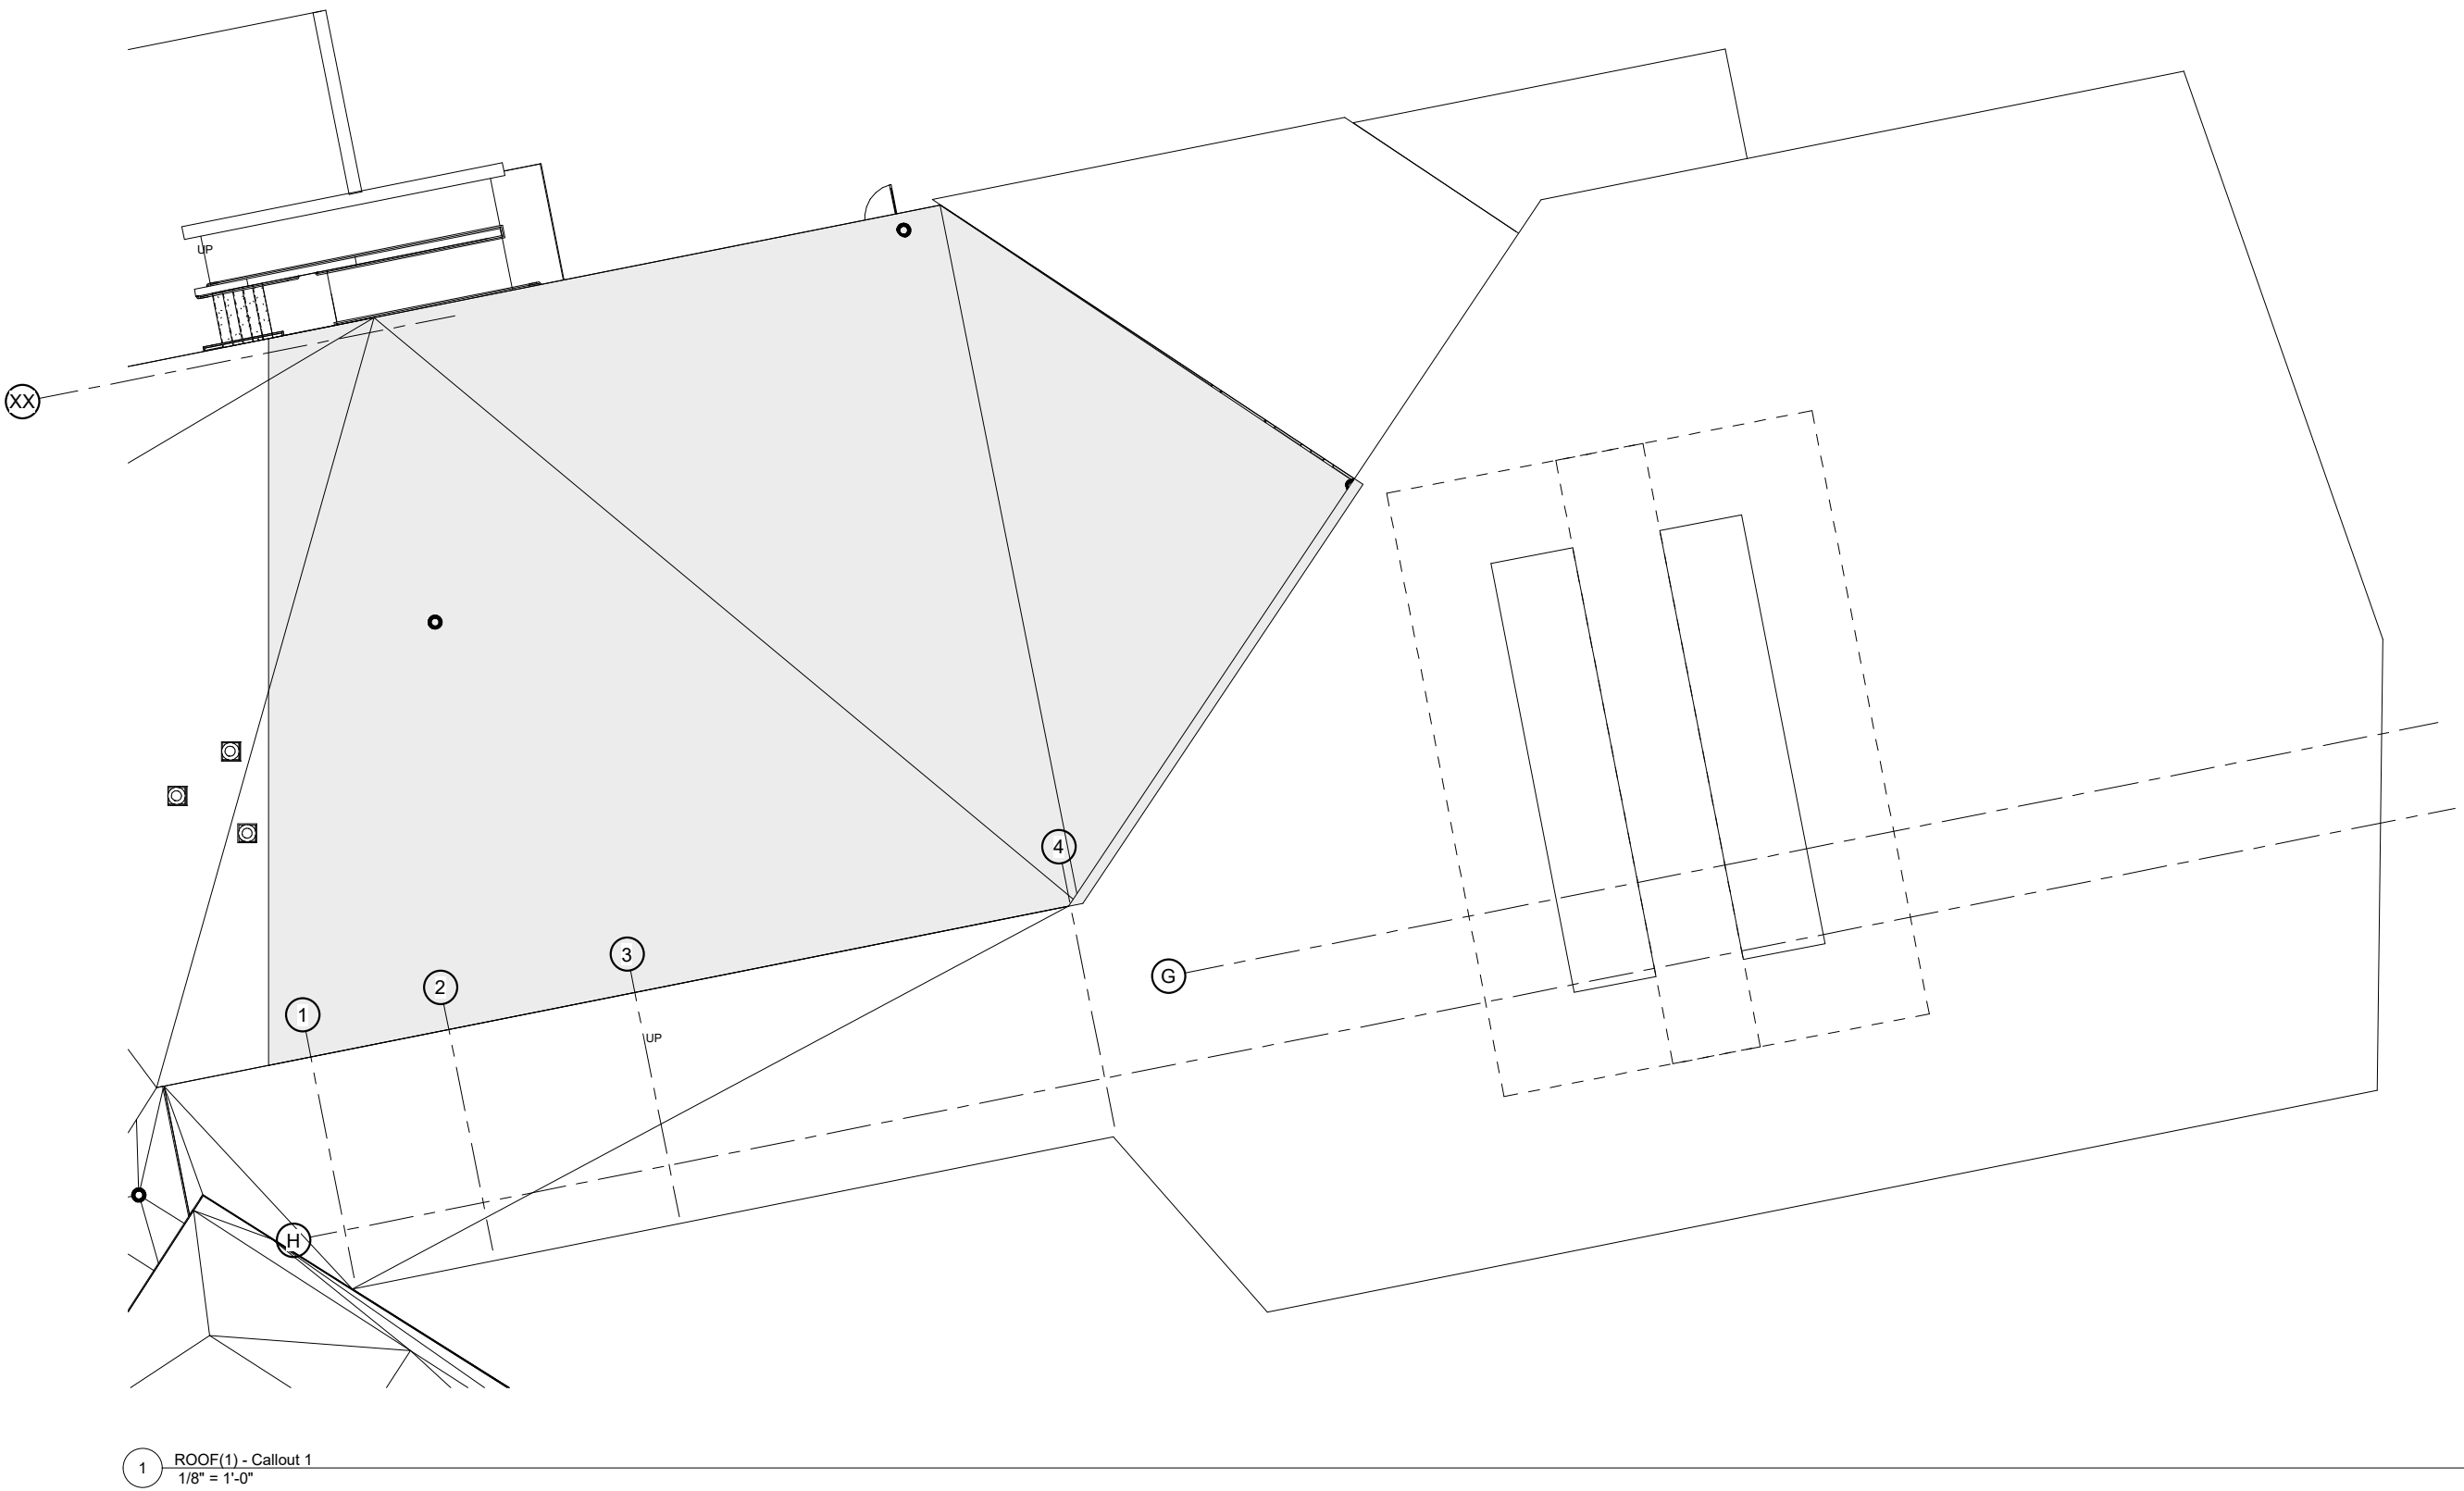


C:\Users\mscott\Documents\19018.02 Hamden Middle School\Central\2019_mscott.rvt 4/8/2020 12:32:24 PM

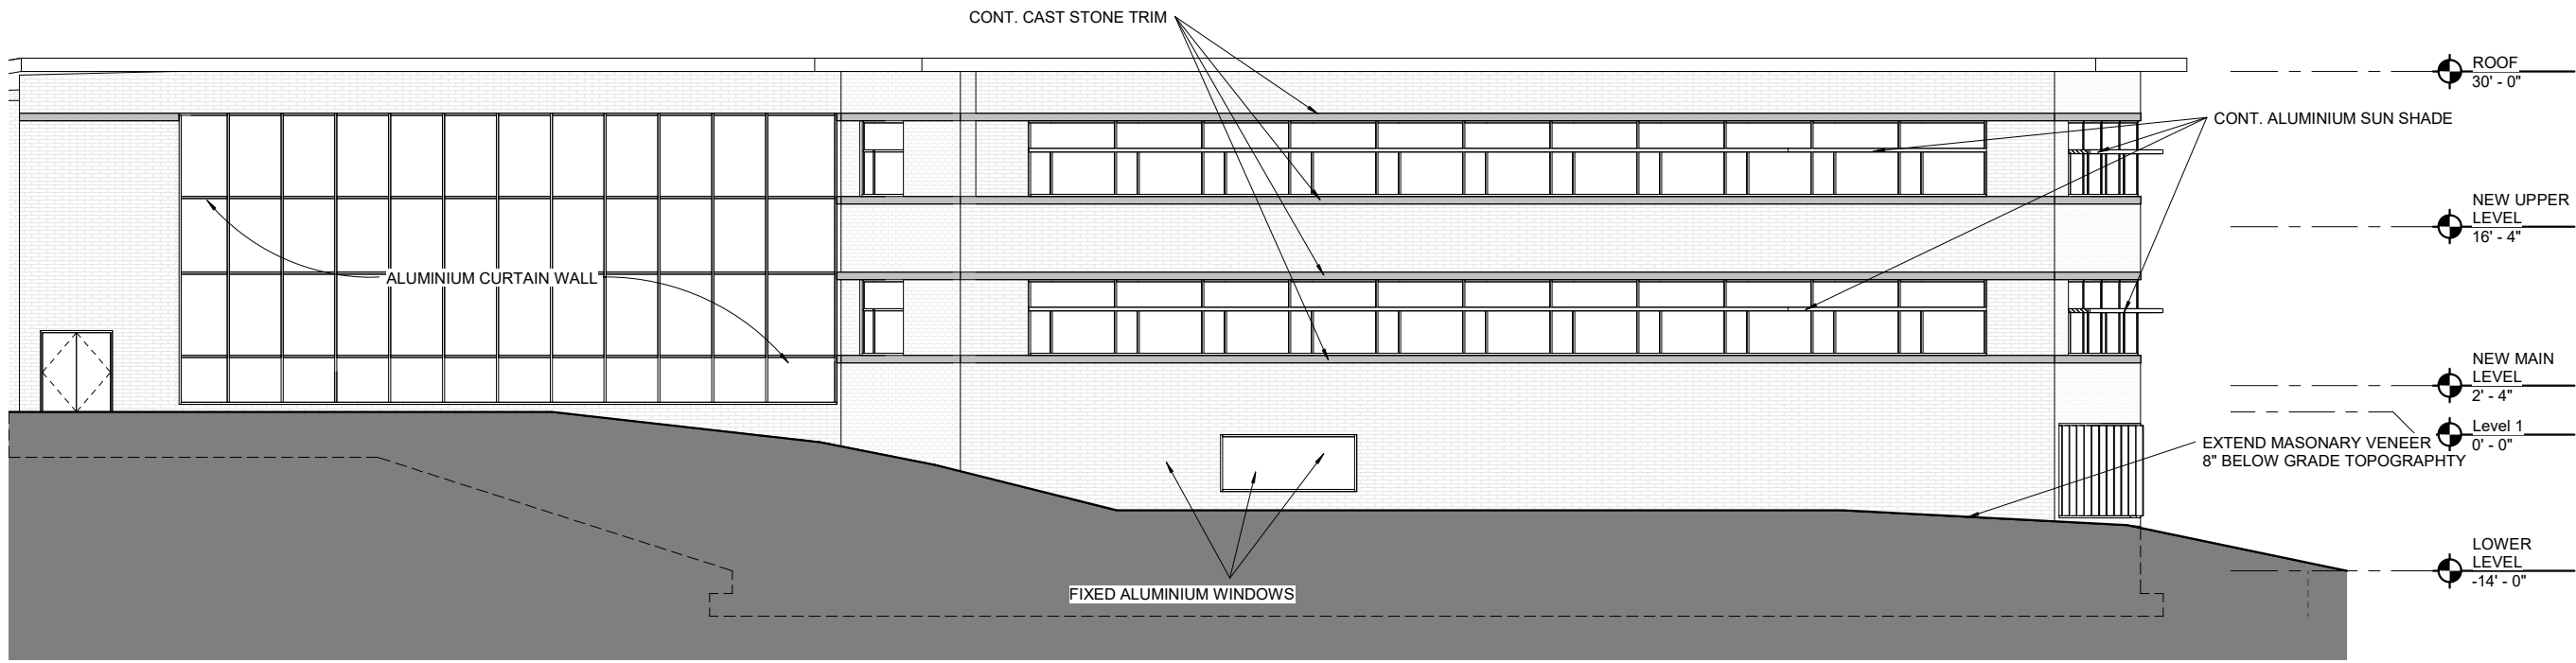

2 Building Elevation South Presentation
1/8" = 1'-0"

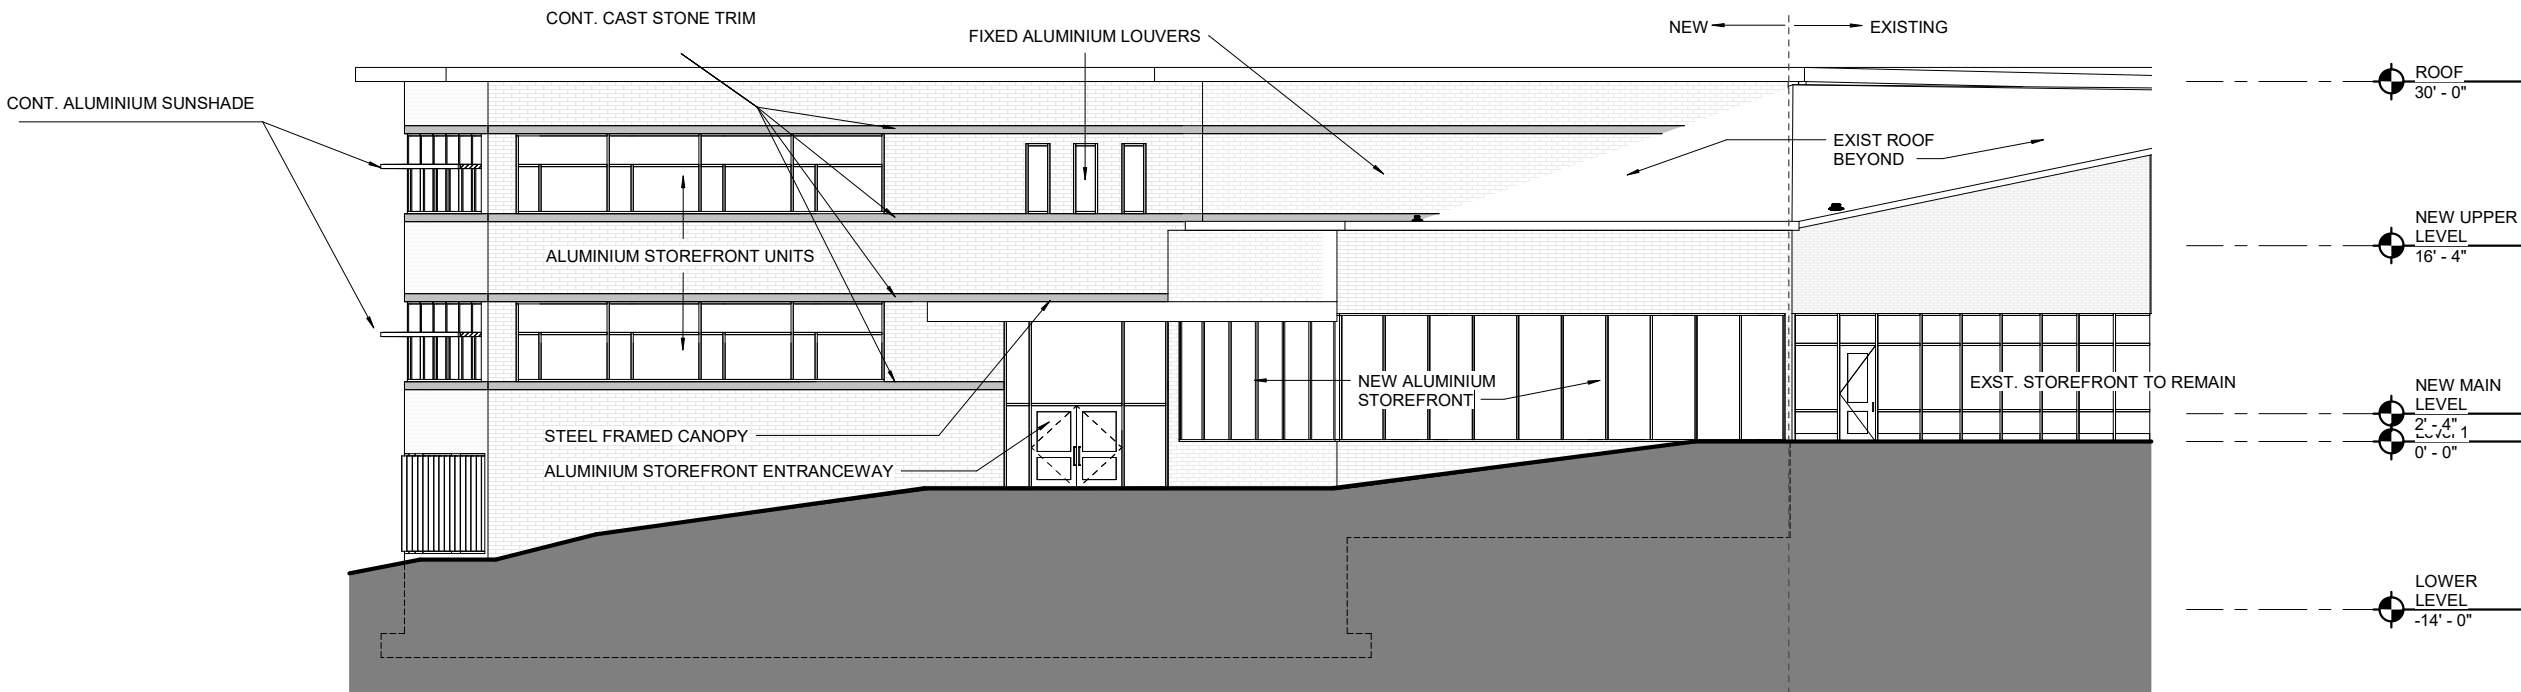

3 Building Elevation North Presentation
1/8" = 1'-0"

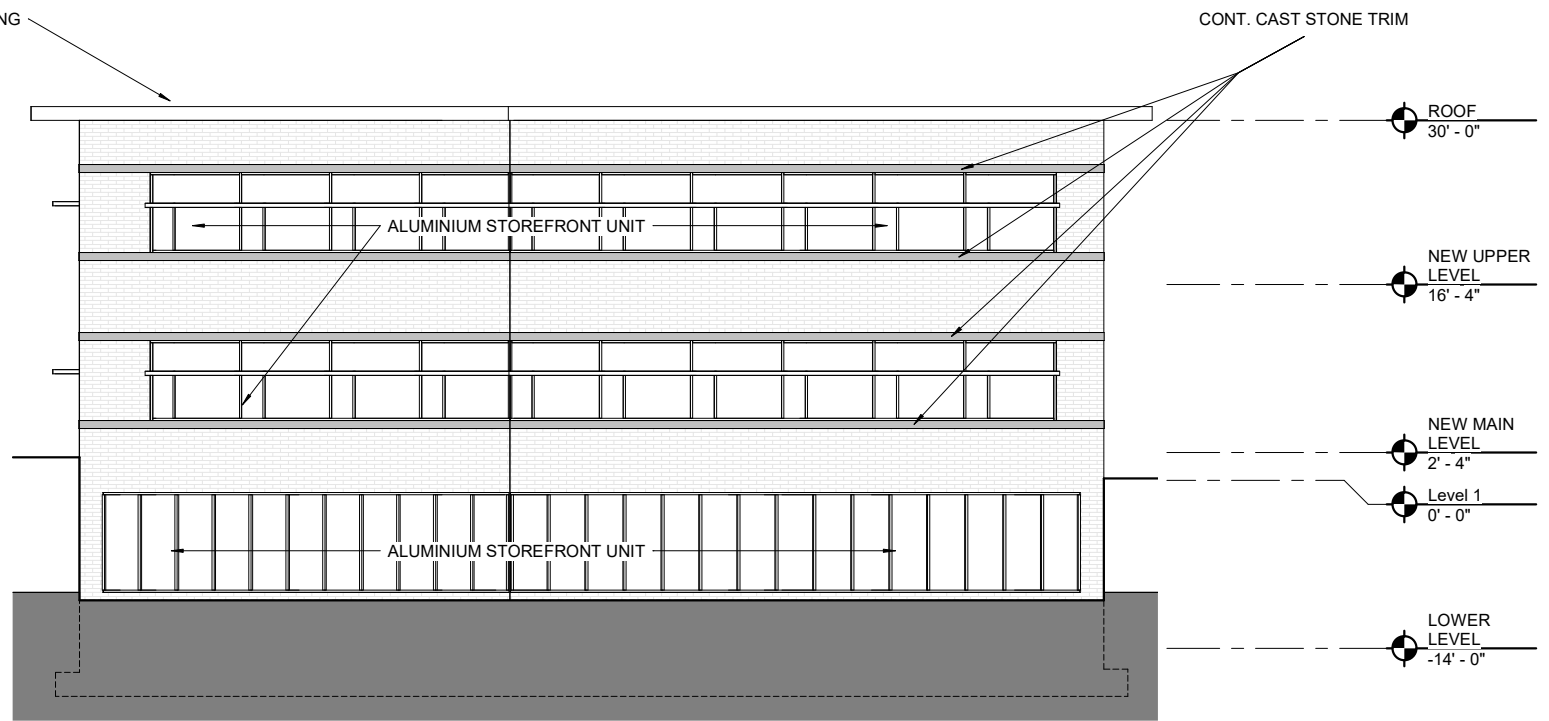

1 Building Elevation East Presentation
1/8" = 1'-0"

Hamden Middle School
Dixwell Avenue
Hamden, Connecticut



Project Status

KEY PLAN

DRAWING TITLE

EXTERIOR ELEVATIONS

STATE PROJ. NO.	
PROJ. NO.	191301
SCALE	1/8" = 1'-0"
DATE	Issue Date
DRAWN BY	Author
APPROVED BY	Approver

ISSUE DATES

NO.	DATE	PURPOSE

A3.01

Hamden Middle School
Dixwell Avenue
Hamden, Connecticut



Project Status

KEY PLAN


DRAWING TITLE

BUILDING SECTIONS


STATE PROJ. NO.	
PROJ. NO.	191301
SCALE	1/8" = 1'-0"
DATE	Issue Date
DRAWN BY	Author
APPROVED BY	Approver

ISSUE DATES		
NO.	DATE	PURPOSE


A3.11

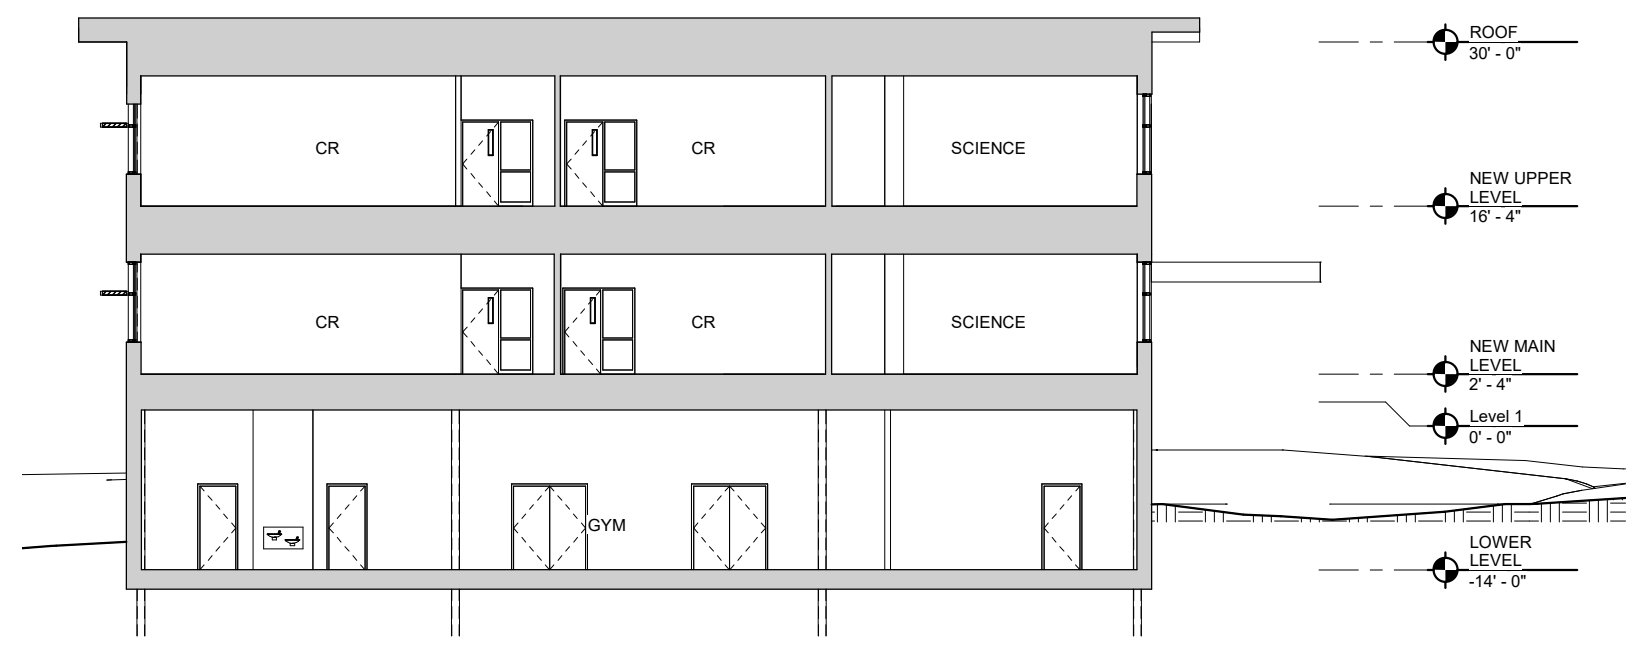


2 Section B
1/8" = 1'-0"

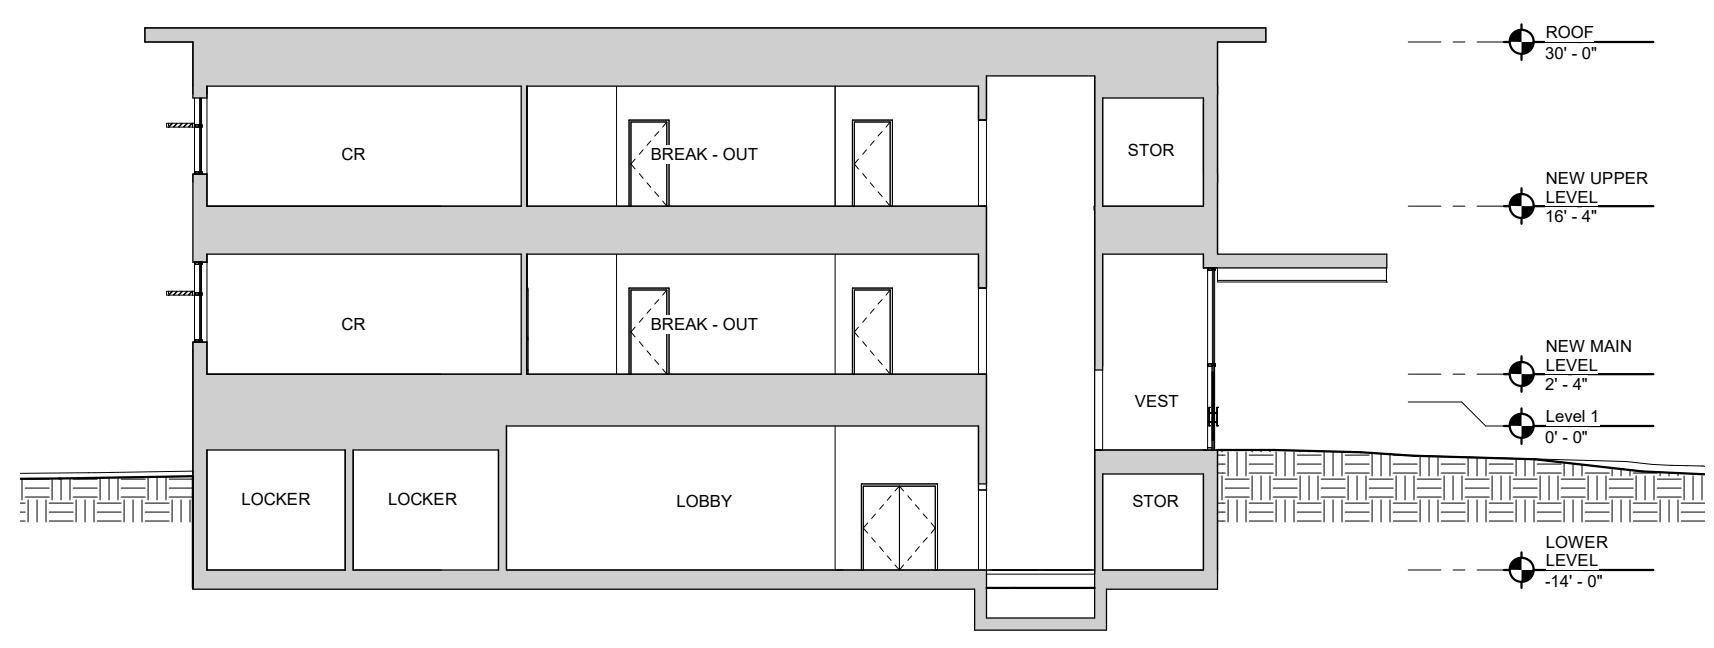

1 Section A
1/8" = 1'-0"

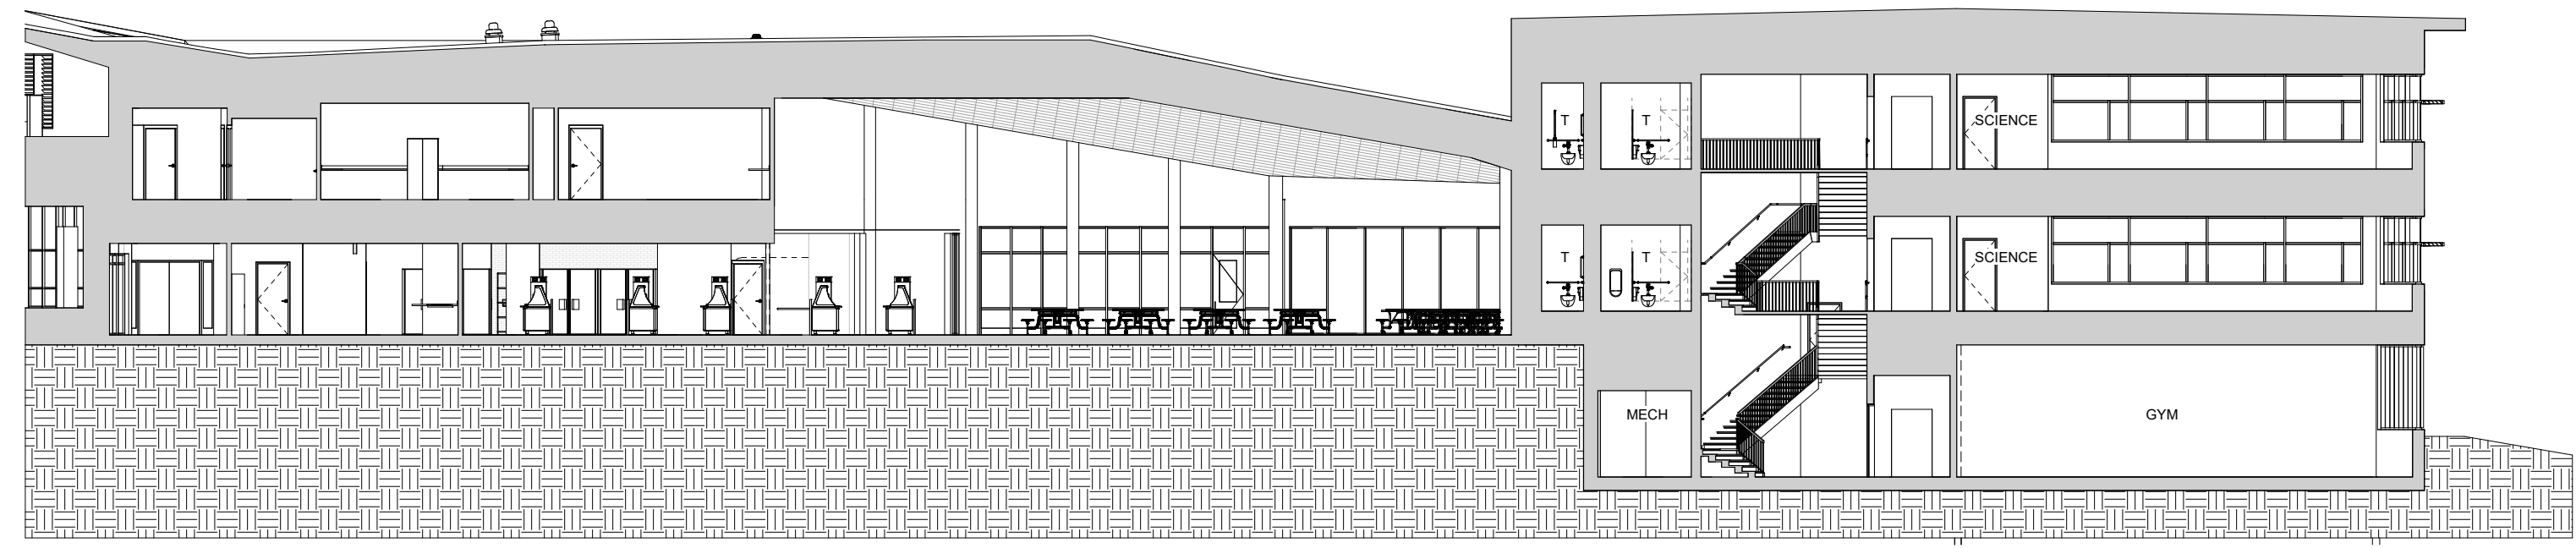

3 Section C
1/8" = 1'-0"

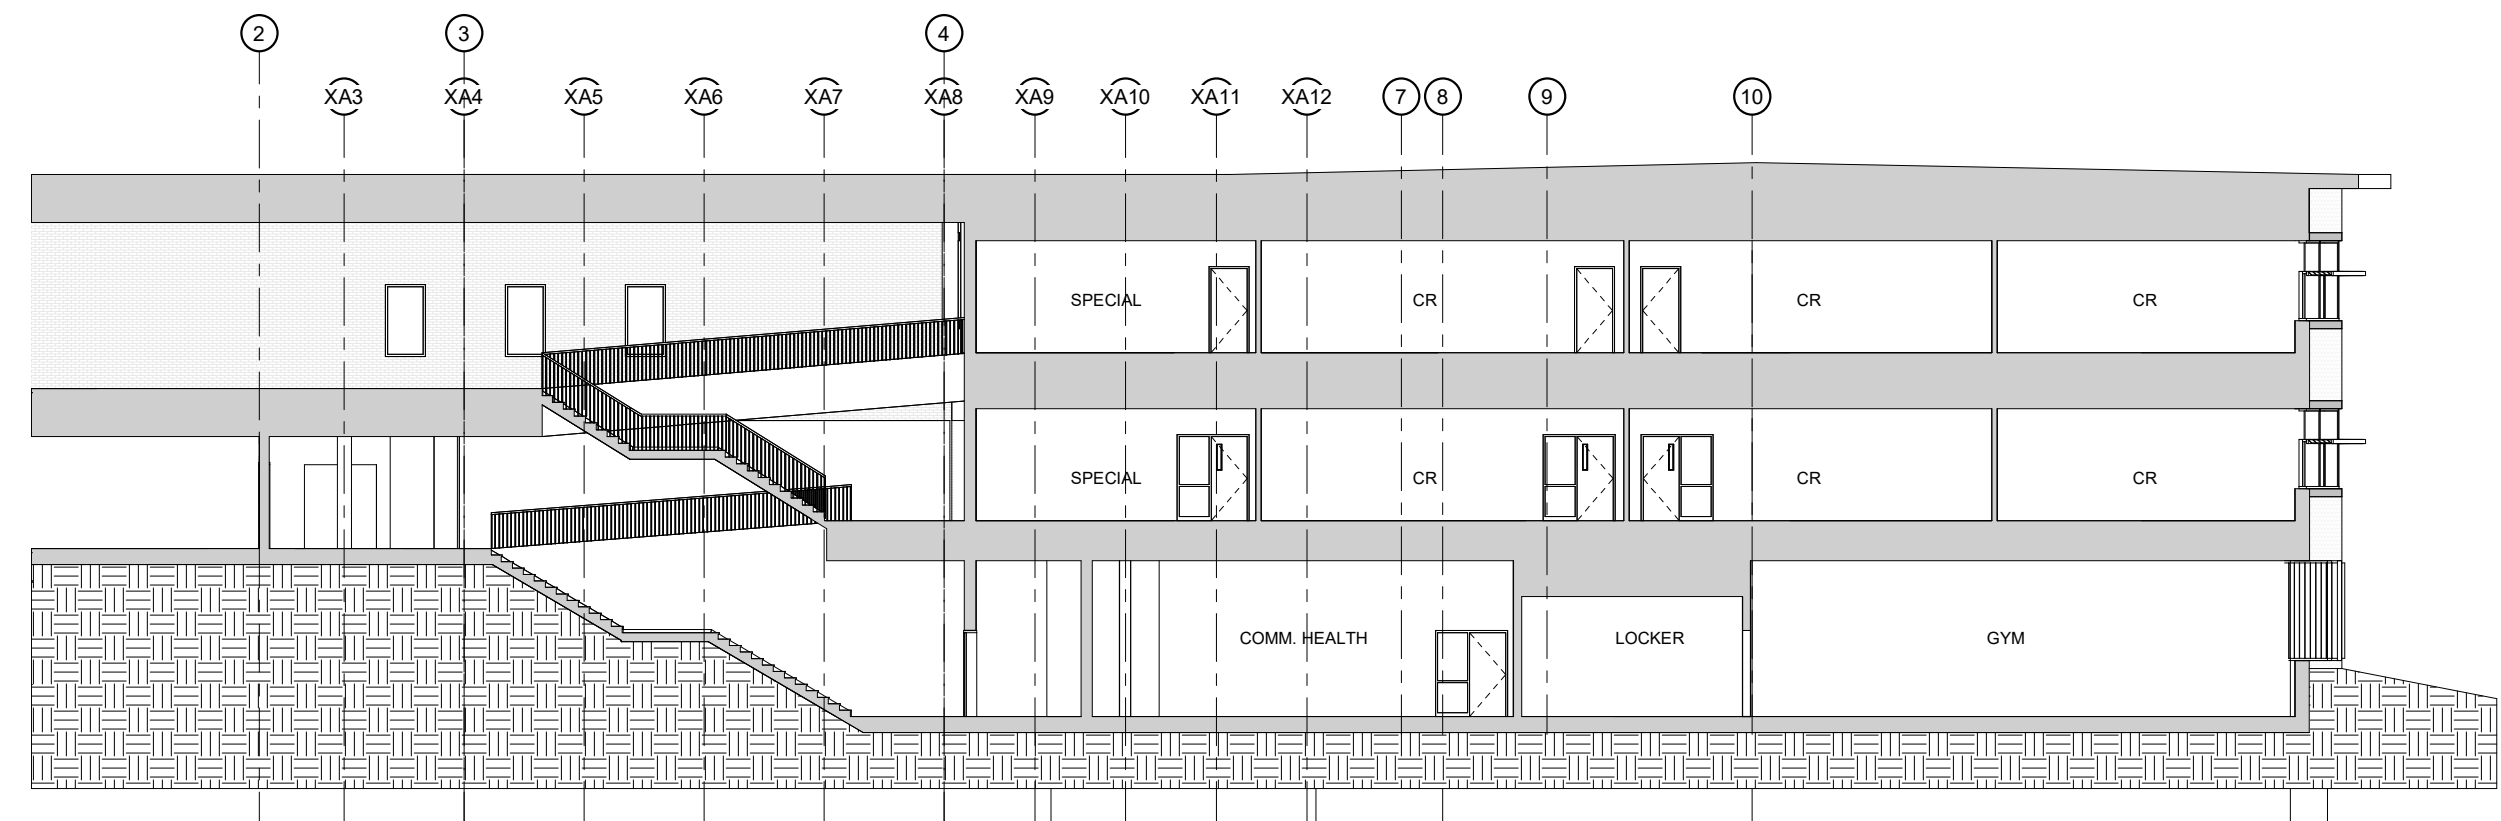

4 Section D
1/8" = 1'-0"

4/6/2020 12:35:55 PM C:\Users\mscott\Documents\19018.02 Hamden Middle School-Central\2019_mscott.rvt

A

B

C

D

E


F

G

H

I

J

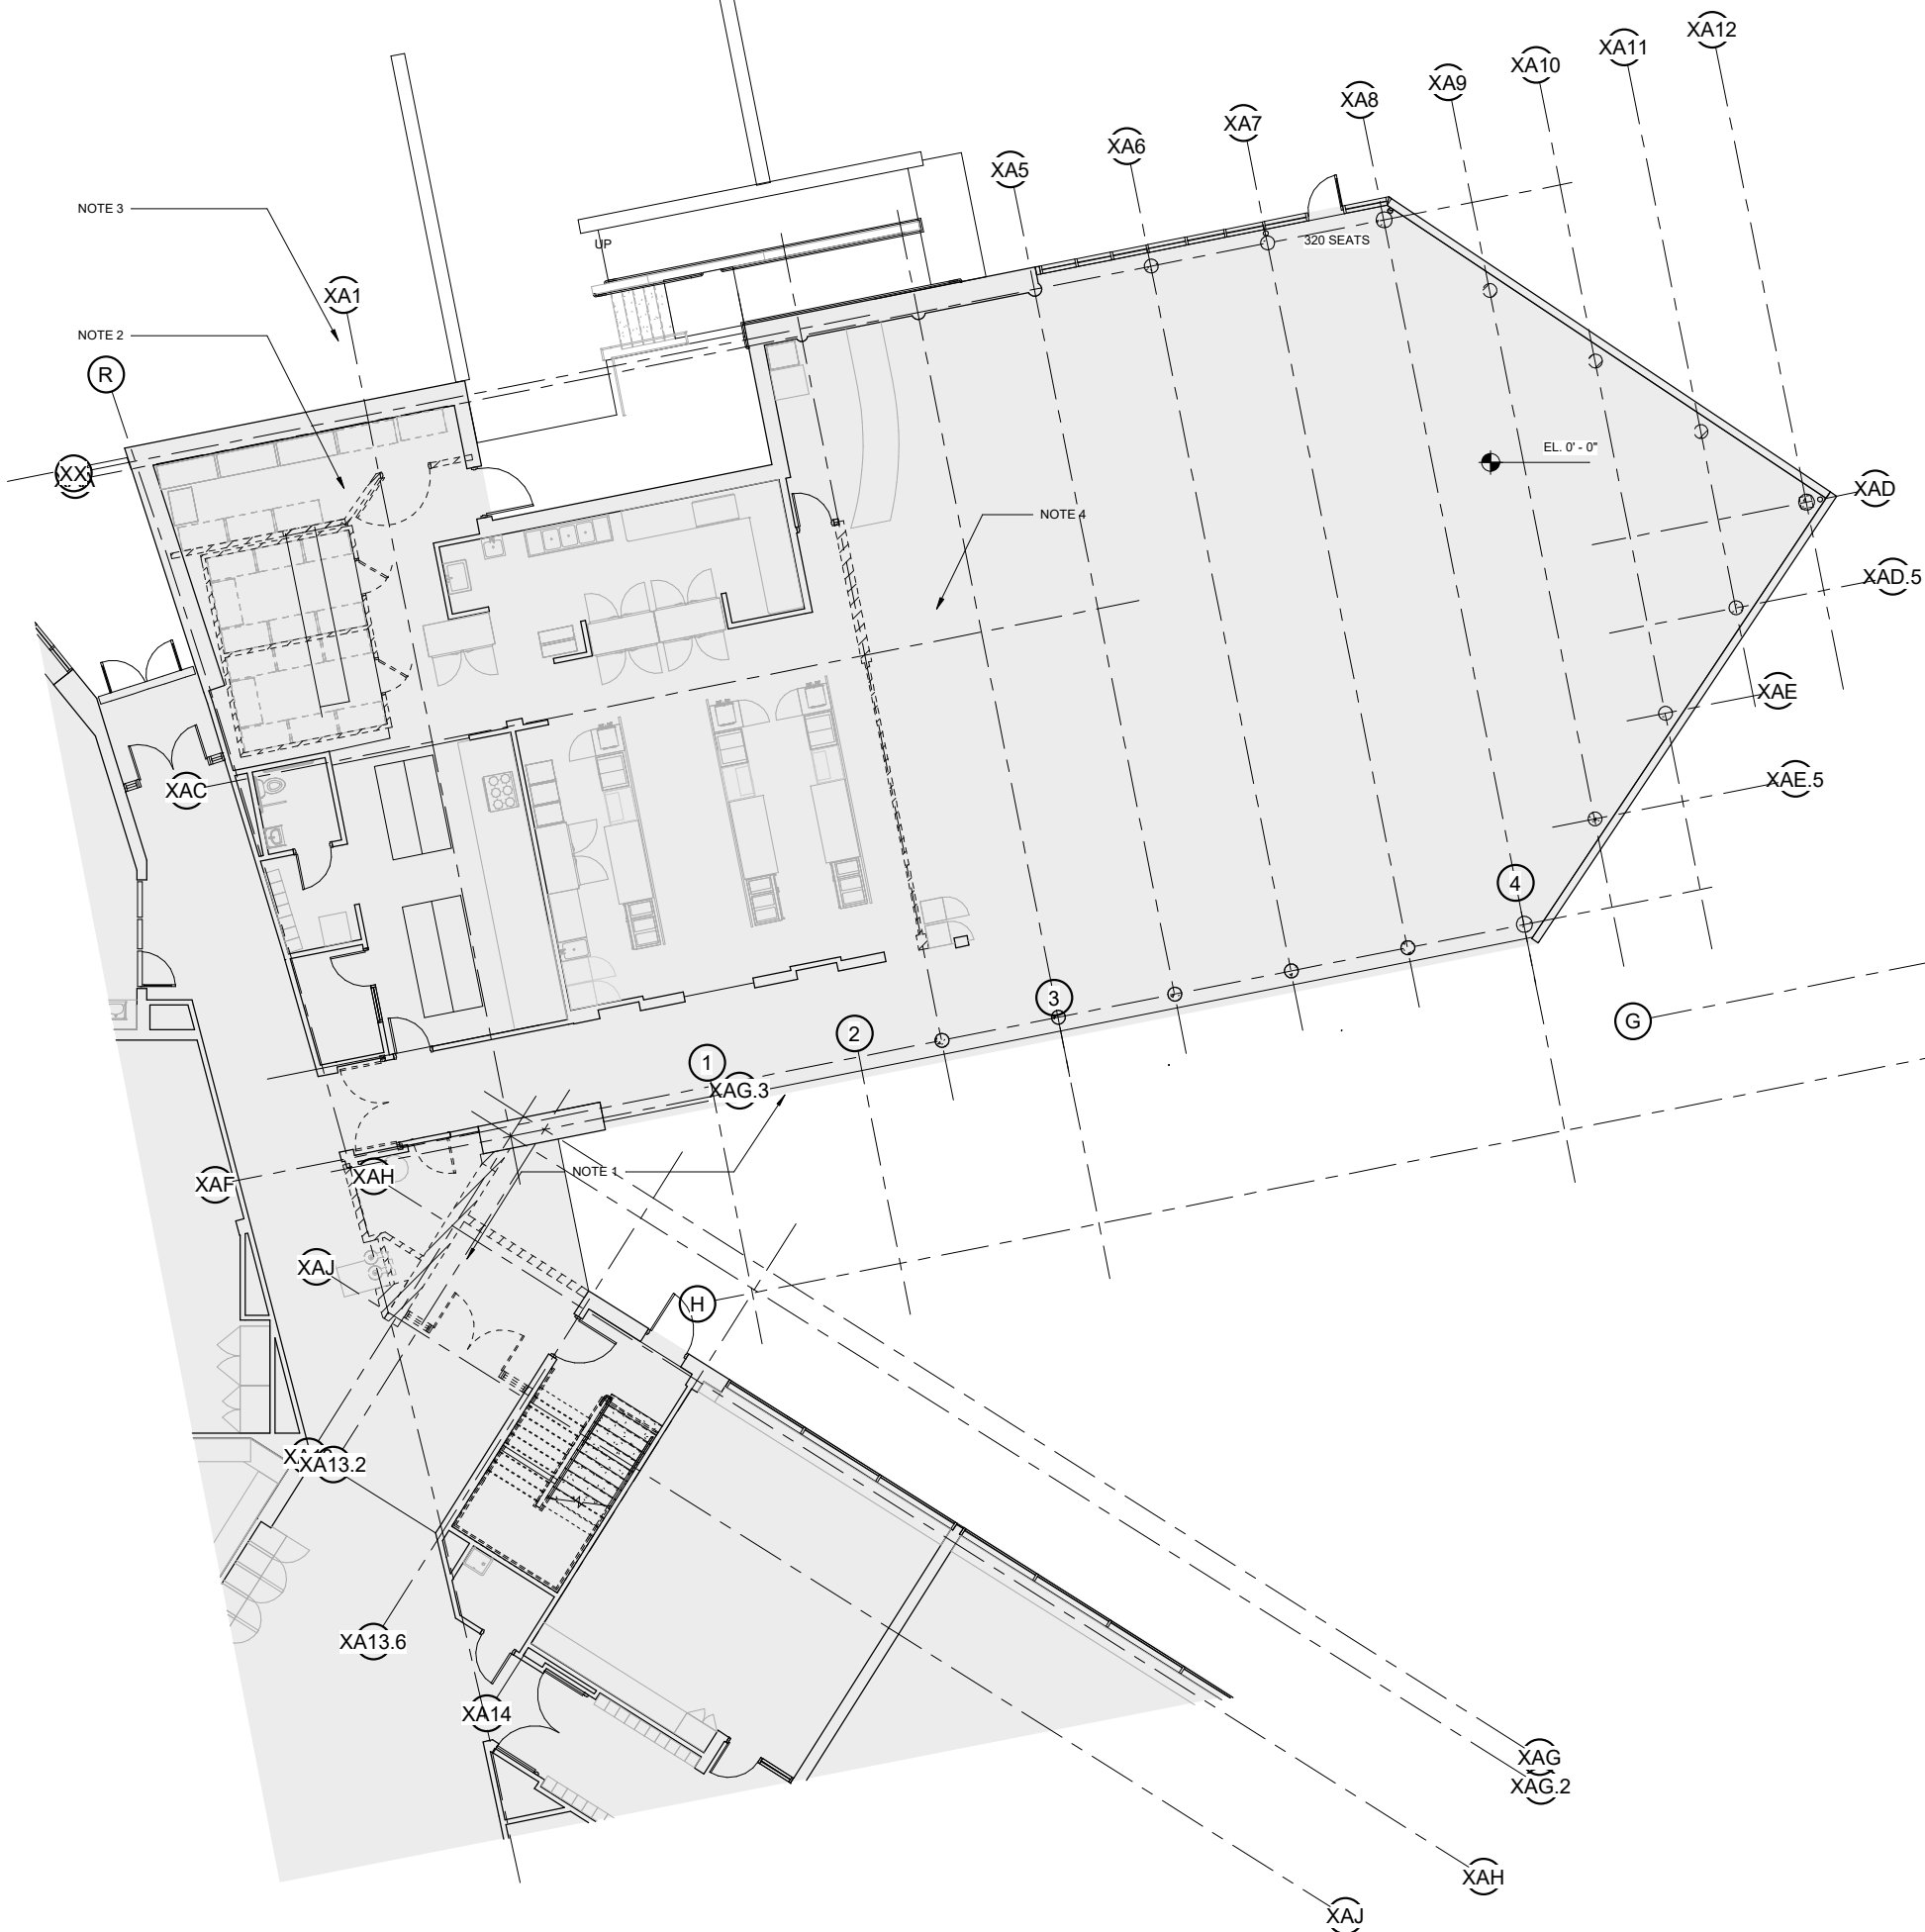

1 ENLARGED FIRST FLOOR PLAN -
DEMOLITION
1/8" = 1'-0"

GENERAL DEMO NOTES

1. SEE MECH. / ELEC. / PLUMBING / ABATEMENT DRAWINGS FOR ADDITIONAL DEMOLITION INFORMATION, TRENCHING, AND CUTTING RELATED TO NEW M.E.P. SYSTEMS.
2. ALL INFORMATION ON DEMOLITION PLANS HAVE BEEN COMPLETED FROM EXISTING DRAWINGS AND LIMITED FIELD OBSERVATIONS. THE CONTRACTOR SHALL VERIFY ALL EXISTING CONDITIONS AND COORDINATE DEMOLITION WITH ALL NEW CONSTRUCTION AND WITH ALL TRADES. NO ATTEMPT HAS BEEN MADE TO ILLUSTRATE ALL REQUIRED DEMOLITION. THE CONTRACTOR IS ULTIMATELY RESPONSIBLE FOR ALL DEMOLITION NECESSARY TO COMPLETE THE WORK.
3. PROVIDE STEEL LINTELS PER STRUCTURAL DWGS AT NEW OPENINGS IN EXISTING MASONRY WALLS AS REQUIRED.
4. THE CONTRACTOR SHALL BE RESPONSIBLE TO PATCH & REPAIR ALL EXISTING WORK DISTURBED BY DEMOLITION ACTIVITIES IN A MANNER THAT RESULT IN A COMPLETE AND FINISHED PRODUCT. THIS PATCH & REPAIR INCLUDES ALL FINISHES NEEDED TO MATCH ADJACENT SURFACES.
5. IF A WALL OR SURFACE HAS BEEN WORKED ON, THAT WALL OR SURFACE SHALL BE PATCHED & REPAIRED WITH A COMPLETE FINISH, TO THE NEAREST CORNER, CHANGE OF PLANE OR OTHER JUNCTURE WHICH ALLOWS FOR SMOOTH & CLEAN TRANSITION FROM NEWLY FINISHED SURFACE TO THE SURROUNDING EXISTING SURFACE. I.E., THE INTENT IS TO ELIMINATE THE APPEARANCE OF A PATCHED CONDITION.
6. IT IS NOT THE INTENT TO SHOW EVERY PIECE OR ITEM TO BE REMOVED IN DEMOLITION WORK. MECHANICAL, ELECTRICAL, AND OTHER WORK RELATED TO A WALL OR AREA SCHEDULED FOR DEMOLITION AND REMOVAL SHALL BE PERFORMED WHETHER SO NOTED OR NOT.
7. PATCH AND REPAIR ANY EXISTING CEILING, FLOORING AND/OR WALL FINISHES DAMAGED DURING THE INSTALLATION OF NEW WALL, PIPING, DUCTS.

DEMOLITION KEYNOTES: CT.

- 1 REMOVE WALL AS INDICATED
- 2 REMOVE DOOR AND FRAME
- 3 REMOVE WINDOW
- 4 REMOVE CASEWORK
- 5 REMOVE FLOORING DOWN TO CONCRETE SLAB REMOVE BASE
- 6 REMOVE PLUMBING FIXTURE, CAP ASSOCIATED PIPING AT NEAREST MAIN, SEE PLUMBING DEMO DWGS
- 7 REMOVE SLAB WHERE REQUIRED FOR PLUMBING WORK OR OTHER UNDERSLAB WORK
- 8 REMOVE OVERHEAD COILING DOOR AND FRAME
- 9 REMOVE MARKER BOARD AND TURN OVER TO THE OWNER
- 10 REMOVE BULLETIN BOARD AND TURN IT OVER TO THE OWNER
- 11 REMOVE SMART BOARD AND TURN IT OVER TO THE OWNER
- 12 REMOVE TV AND TV MOUNT, AND TURN IT OVER TO THE OWNER
- 13 REMOVE THRESHOLD METAL PLATE
- 14 REMOVE DISPLAY CASE AND TURN IT OVER TO THE OWNER
- 15 REMOVE CURTAIN WALL FRAME AND GLASS
- 16 REMOVE LOCKERS
- 17 REMOVE CEILING
- 18 REMOVE PROJECTOR AND TURN IT OVER TO THE OWNER
- 19 REMOVE LIGHT FIXTURE
- 20 REMOVE EXISTING EXTERIOR SLAB

REMOVE KITCHEN EQUIPMENTS

DEMOLITION PLAN LEGEND

- 1 KEYED DEMOLITION NOTE SYMBOL
- EXISTING CONSTRUCTION TO BE REMOVED
- EXISTING CONSTRUCTION TO REMAIN
- EXISTING AREAS WHERE DEMOLITION WORK TO BE DONE

tskstudio.com

TSKP
STUDIO

One Hartford Square West
146 Wyllys Street, Bldg 1-203
Hartford, CT 06106
860.347.1510

ARCHITECTURE | PLANNING | INTERIORS

Hamden Middle School

Dixwell Avenue
Hamden, Connecticut



Project Status

KEY PLAN

DRAWING TITLE

FIRST FLOOR DEMO

STATE PROJ. NO.

PROJ. NO. 191301

SCALE As indicated

DATE Issue Date

DRAWN BY Author

APPROVED BY Approver

ISSUE DATES

NO.	DATE	PURPOSE

D1.11

Hamden Middle School
Dixwell Avenue
Hamden, Connecticut



Project Status

KEY PLAN


DRAWING TITLE

SECOND FLOOR
DEMOLITION

STATE PROJ. NO.	
PROJ. NO.	191301
SCALE	1/8" = 1'-0"
DATE	Issue Date
DRAWN BY	Author
APPROVED BY	Approver

ISSUE DATES		
NO.	DATE	PURPOSE

D1.12

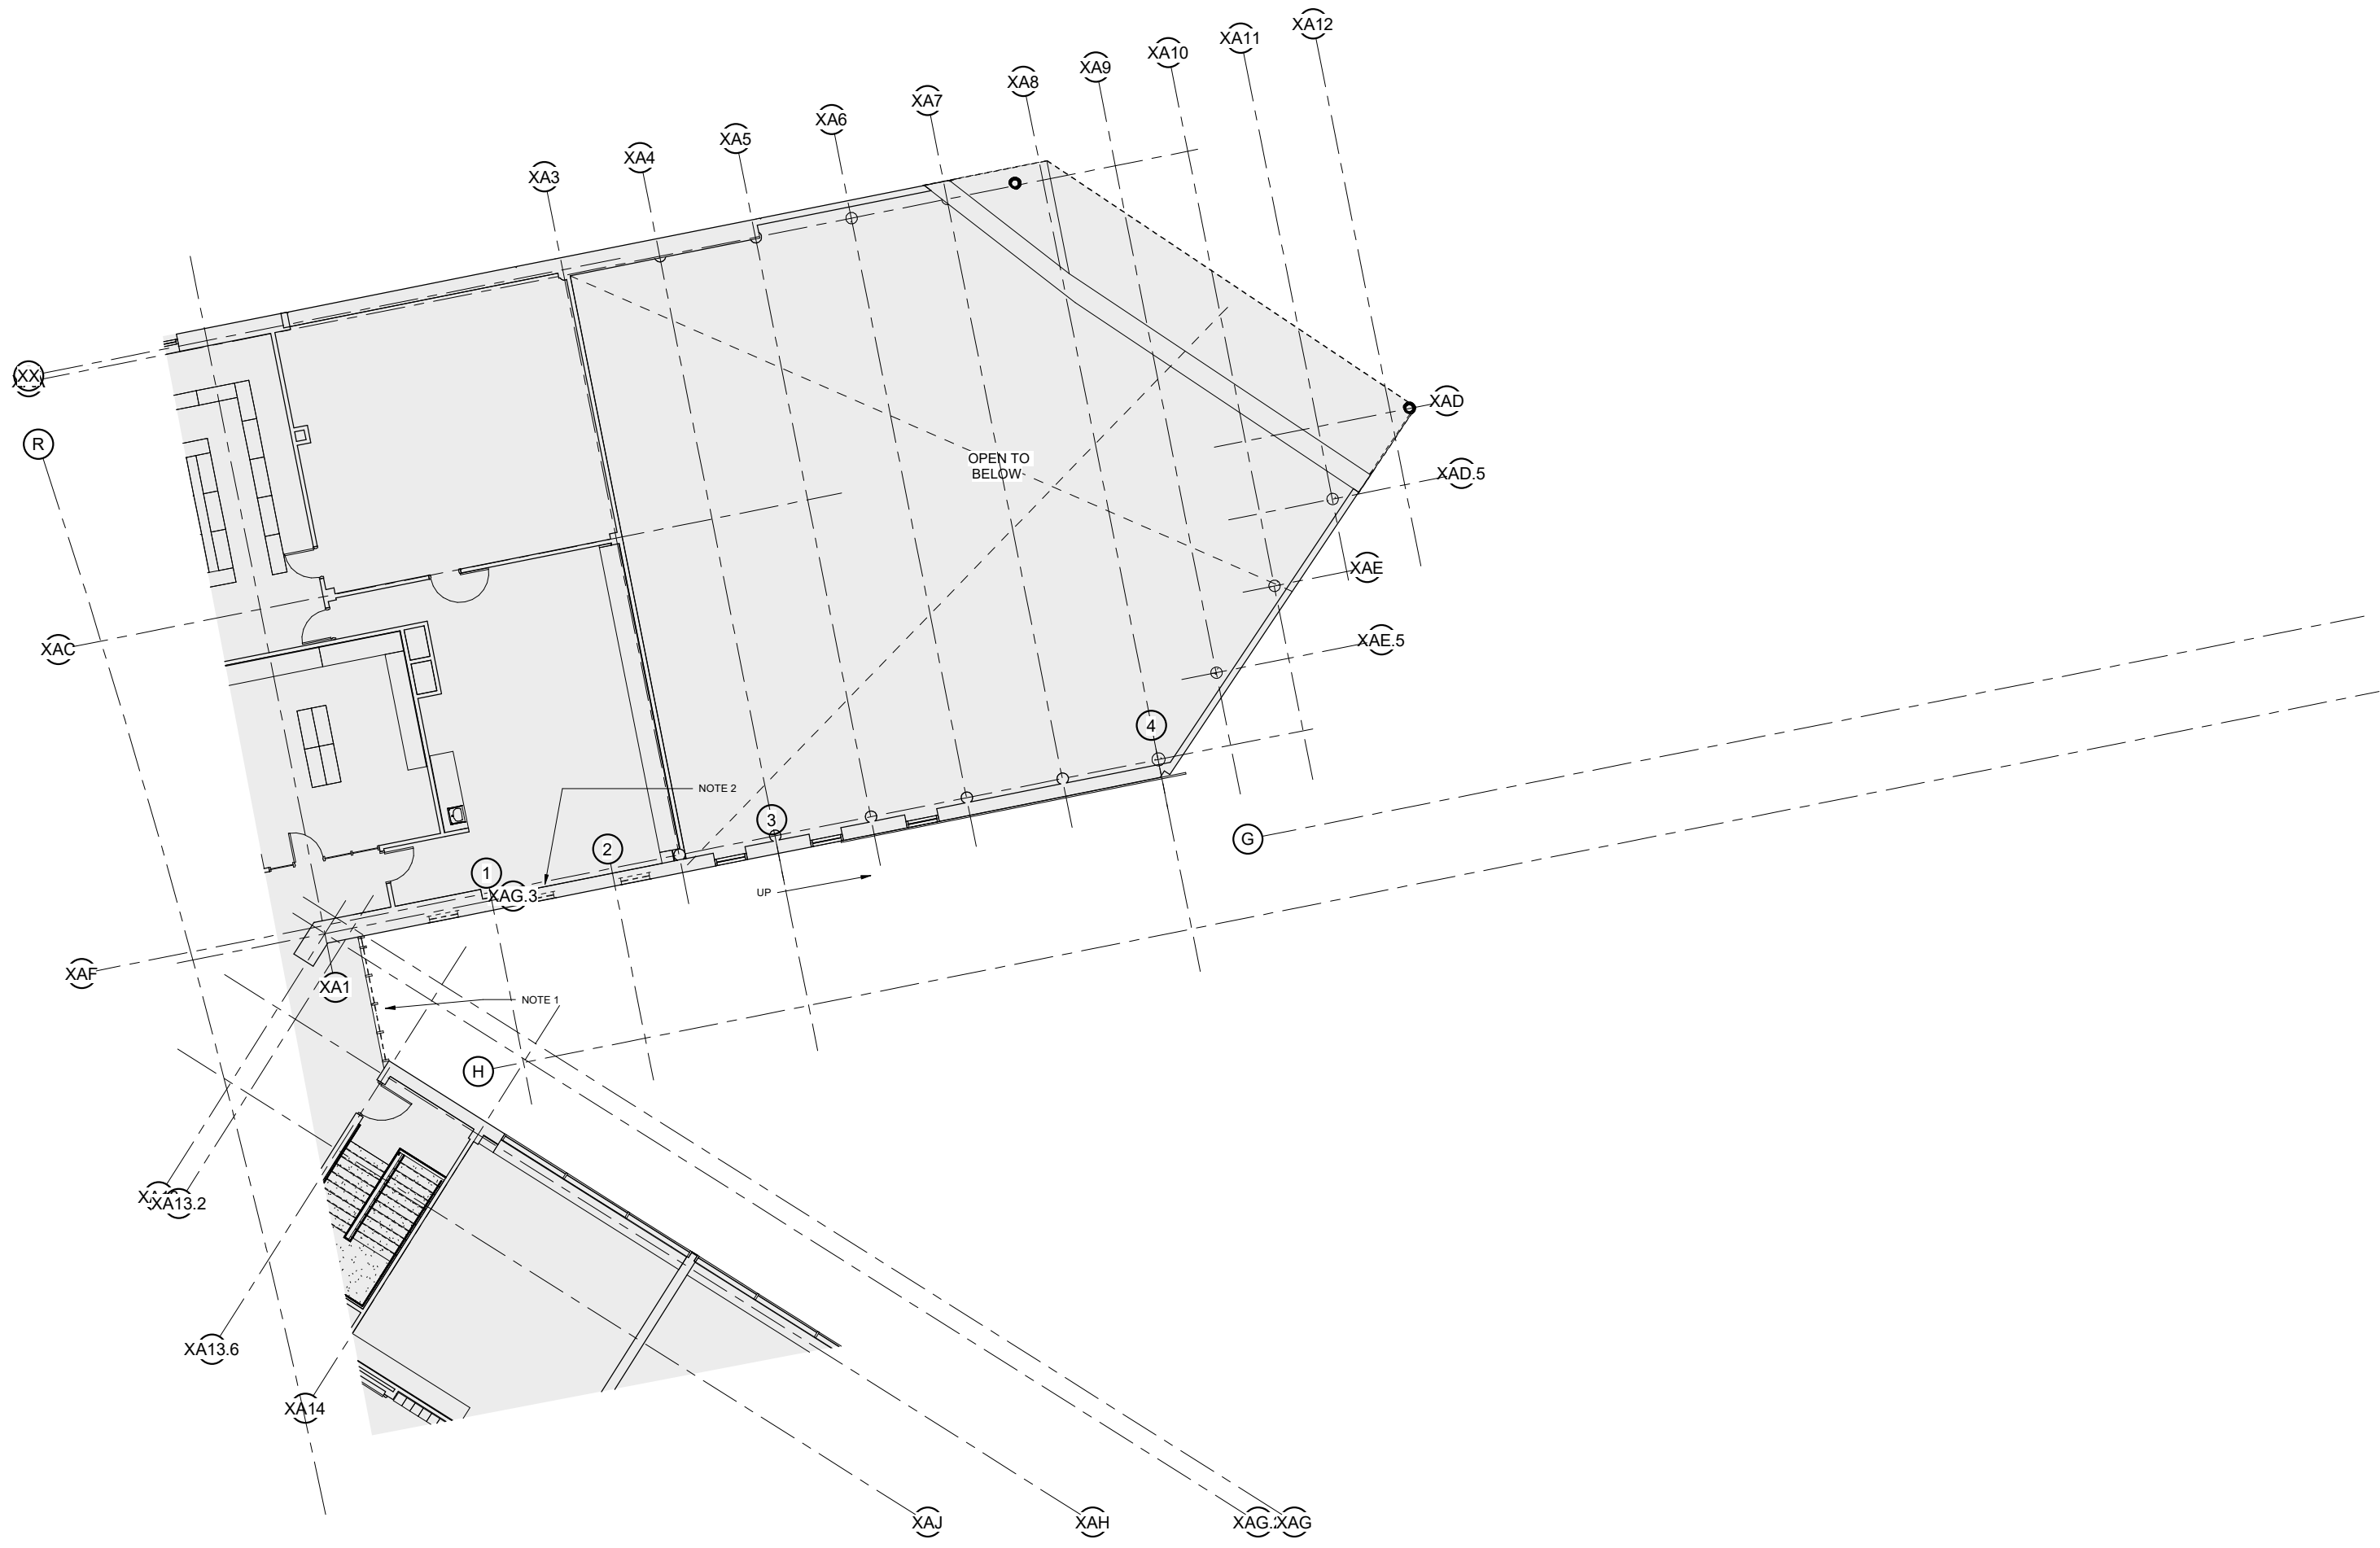

1 ENLARGED NEW UPPER LEVEL
DEMOLITION
1/8" = 1'-0"

4/6/2020 12:36:00 PM C:\Users\mscott\Documents\19018.02 Hamden Middle School\Central\2019_mscott.rvt

A

B

C

D

E

F

G

H

I

J

11

10

9

8

7

6


5

4


3

2


1

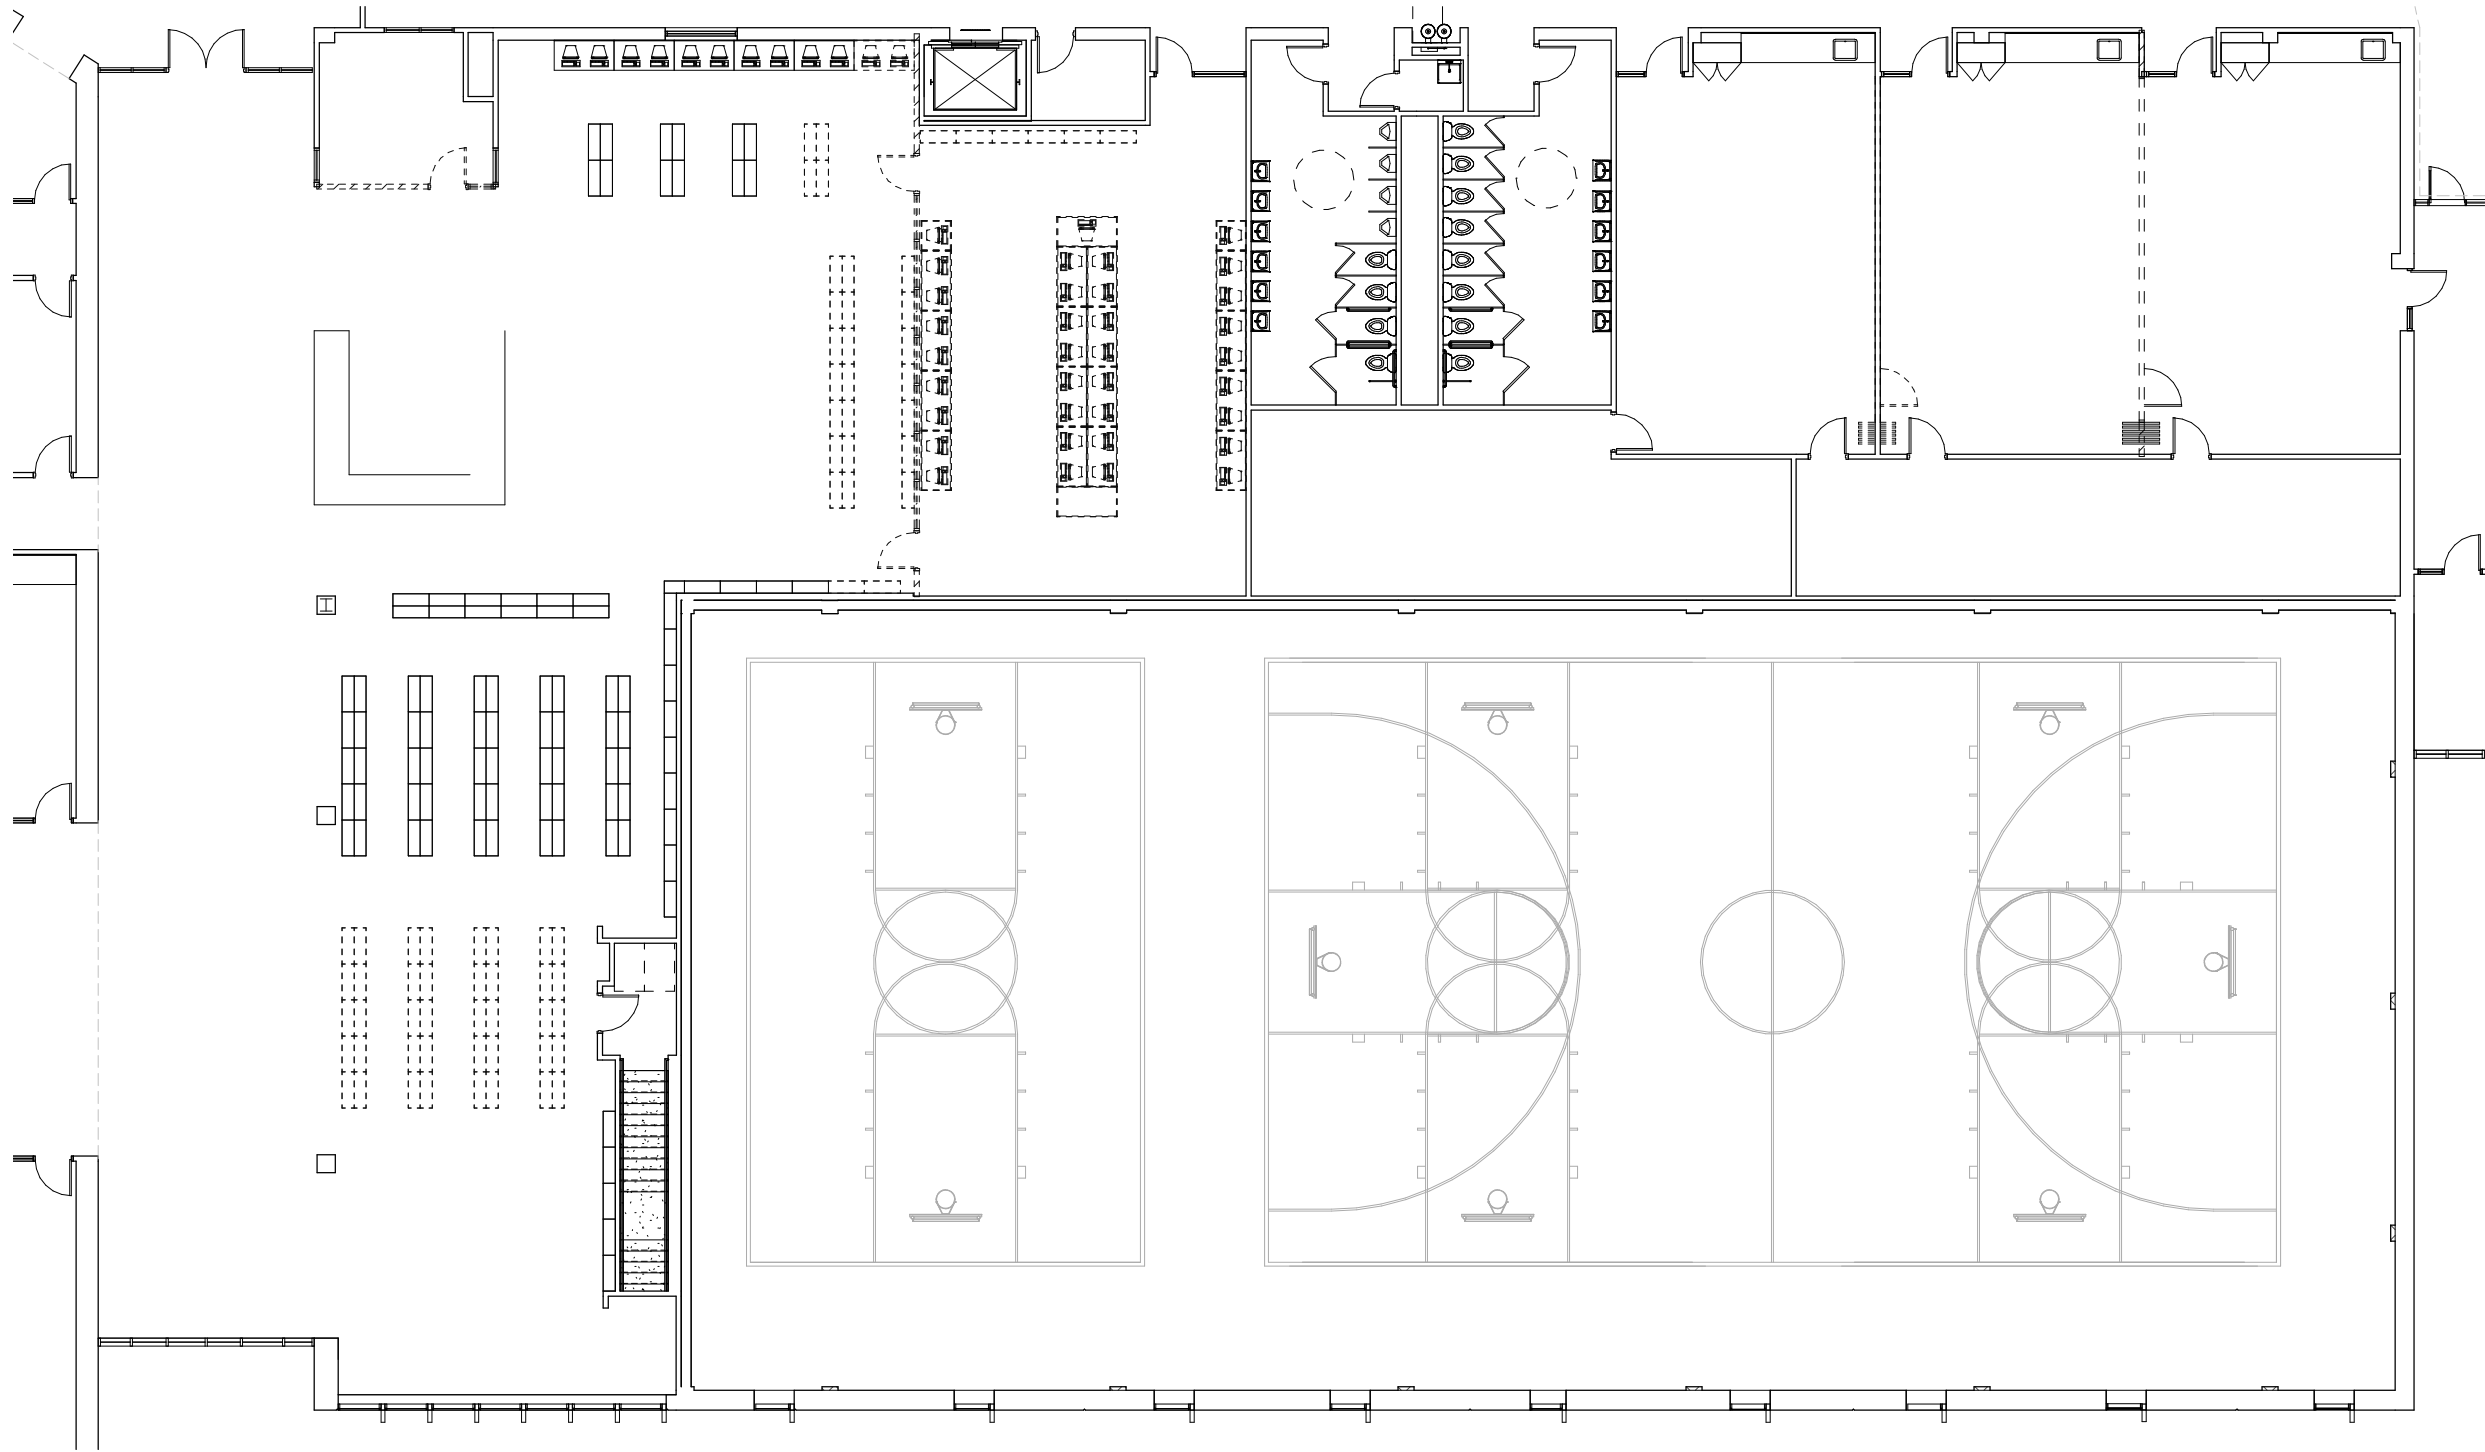

3 MEDIA CENTER - EXISTING CD
1/8" = 1'-0"

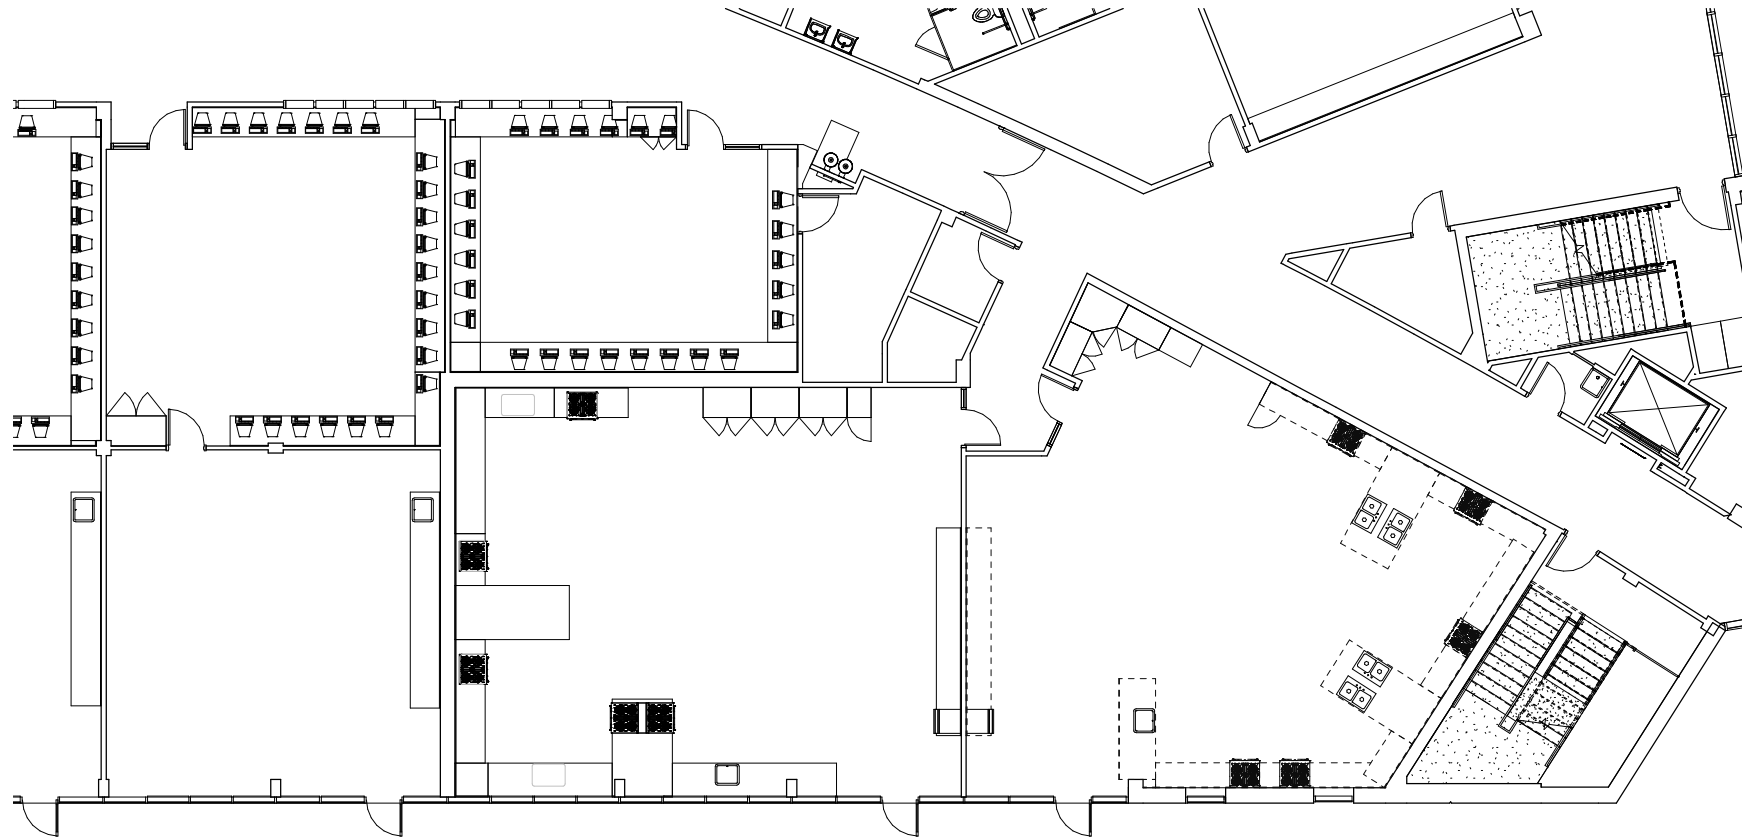

1 CULINARY - EXISTING CD
1/8" = 1'-0"

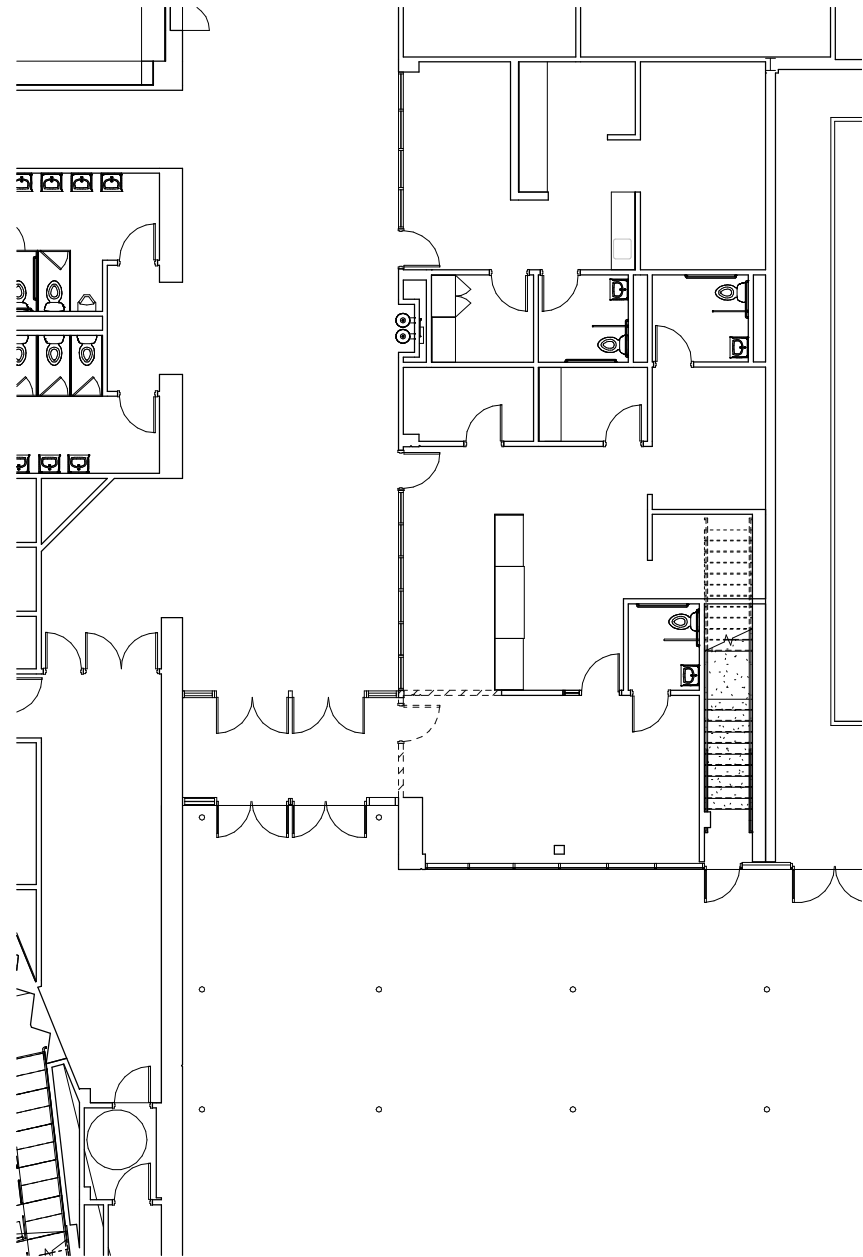

2 ENTRY - DEMO CD
1/8" = 1'-0"

tskpatudio.com

TSKP
STUDIO

One Hartford Square West
146 Wyllys Street, Bldg 1-203
Hartford, CT 06106
860.347.1510

ARCHITECTURE | PLANNING | INTERIORS

Hamden Middle School
Dixwell Avenue
Hamden, Connecticut



Project Status

KEY PLAN

DRAWING TITLE

RENOVATION AREA
DEMOLITION PLANS

STATE PROJ. NO.	
PROJ. NO.	191301
SCALE	1/8" = 1'-0"
DATE	Issue Date
DRAWN BY	Author
APPROVED BY	Approver

ISSUE DATES

NO.	DATE	PURPOSE

D1.21