

LONGVIEW SCHOOL DISTRICT
SECURITY VESTIBULE PROJECT - REBID
LONGVIEW, WA



INDEX OF DRAWINGS

GENERAL		MINT VALLEY ELEMENTARY SCHOOL	
A0.0	COVER SHEET & INDEX	A10.1	OVERALL PLAN
A0.0	VICINITY MAP & SITE LOCATIONS	A10.2	VESTIBULE SECURITY PLAN
OLYMPIC ELEMENTARY SCHOOL		A10.3	SCHEDULE, ELEVATIONS, & DETAILS
A3.1	OVERALL PLAN	KESSLER ELEMENTARY SCHOOL	
A3.2	VESTIBULE SECURITY PLAN	A11.1	OVERALL PLAN
A3.3	SCHEDULE, ELEVATIONS, & DETAILS	A11.2	VESTIBULE SECURITY PLAN
ST. HELENS ELEMENTARY SCHOOL		A11.3	SCHEDULE, ELEVATIONS, & DETAILS
A4.1	OVERALL PLAN	MARK MORRIS HIGH SCHOOL	
A4.2	VESTIBULE SECURITY PLAN	A12.1	OVERALL PLAN
A4.3	SCHEDULE, ELEVATIONS, & DETAILS	A12.2	VESTIBULE SECURITY PLAN
ROBERT GRAY ELEMENTARY SCHOOL		A12.3	SCHEDULE, ELEVATIONS, & DETAILS
A8.1	OVERALL PLAN	DISCOVERY HIGH SCHOOL	
A8.2	VESTIBULE SECURITY PLAN	A14.1	OVERALL PLAN
A8.3	SCHEDULE, ELEVATIONS, & DETAILS	A14.2	VESTIBULE SECURITY PLAN
		A14.3	SCHEDULE, ELEVATIONS, & DETAILS

PROJECT SUMMARY

RENOVATION OF EXISTING FACILITY SECURITY ACCESS CONTROLS. NEW VESTIBULE PARTITIONS, DOOR HARDWARE, AND SECURITY MONITORING SYSTEMS

PROJECT TEAM

OWNER	ARCHITECT
LONGVIEW SCHOOL DISTRICT	COLLINS ARCHITECTURAL GROUP PS
2715 LILAC STREET	950 12th AVE STE 200
LONGVIEW, WA 98632	LONGVIEW WA 98632
PHONE: (360) 575-7019	PHONE: (360) 425-0000
CONTACT: JASON REETZ	CONTACT: JOSEPH BEER
E-MAIL: jreetz@longview.k12.wa.us	E-MAIL: joebe@collinsarchgroup.com

4331
REGISTERED ARCHITECT
CRAIG M. COLLINS
STATE OF WASHINGTON

Scale

Date
2/14/2021

Project #
2021-18

COLLINS
ARCHITECTURAL GROUP, P.S.
950 12th AVE., SUITE 200
LONGVIEW, WA 98632
PHONE: 360-425-0000

COVER SHEET & INDEX

LONGVIEW SCHOOL DISTRICT
VESTIBULE SECURITY PROJECT

A0.0

LONGVIEW, WASHINGTON

VICINITY MAP



SITE LOCATIONS

- 3 OLYMPIC ELEMENTARY SCHOOL
1324 30TH AVENUE, LONGVIEW, WA
- 4 ST. HELENS ELEMENTARY SCHOOL
5300 MT SOLO ROAD, LONGVIEW, WA
- 8 ROBERT GRAY ELEMENTARY SCHOOL
4622 OHIO STREET, LONGVIEW, WA
- 10 MINT VALLEY ELEMENTARY SCHOOL
2745 38th AVENUE, LONGVIEW, WA
- 11 KESSLER ELEMENTARY SCHOOL
1902 E KESSLER BOULEVARD, LONGVIEW, WA
- 12 MARK MORRIS HIGH SCHOOL
1602 MARK MORRIS COURT, LONGVIEW, WA
- 14 DISCOVERY HIGH SCHOOL
2742 HARDING STREET, LONGVIEW, WA

4331

REGISTERED
ARCHITECT

CRAIG M. COLLINS
STATE OF WASHINGTON

Scale

Date

2/14/2021

Project #

2021-18



950 12th AVE., SUITE 200
LONGVIEW, WA 98632
PHONE: 360-425-0000

VICINITY MAP & SITE LOCATIONS

LONGVIEW SCHOOL DISTRICT

VESTIBULE SECURITY PROJECT

A0.1

Olympic Elementary


1324 30th Ave

Main

0204080

Scale in Feet

NOTE: ROUTE NEW DATA CABLING FOR ACCESS CONTROL AND MONITORING TO IDF, ROUTE THROUGH CONCEALED SPACES WHERE POSSIBLE, USE WIREMOLD WHERE CABLING MUST BE EXPOSED. IT IS ASSUMED THAT 120V POWER IS AVAILABLE FROM AN ELECTRICAL PANEL WITHIN 50 FEET OF THE POINT OF USE. ANY CONDUIT/WIRING BEYOND 50FT WILL BE PROCESSED AS A CHANGE ORDER.

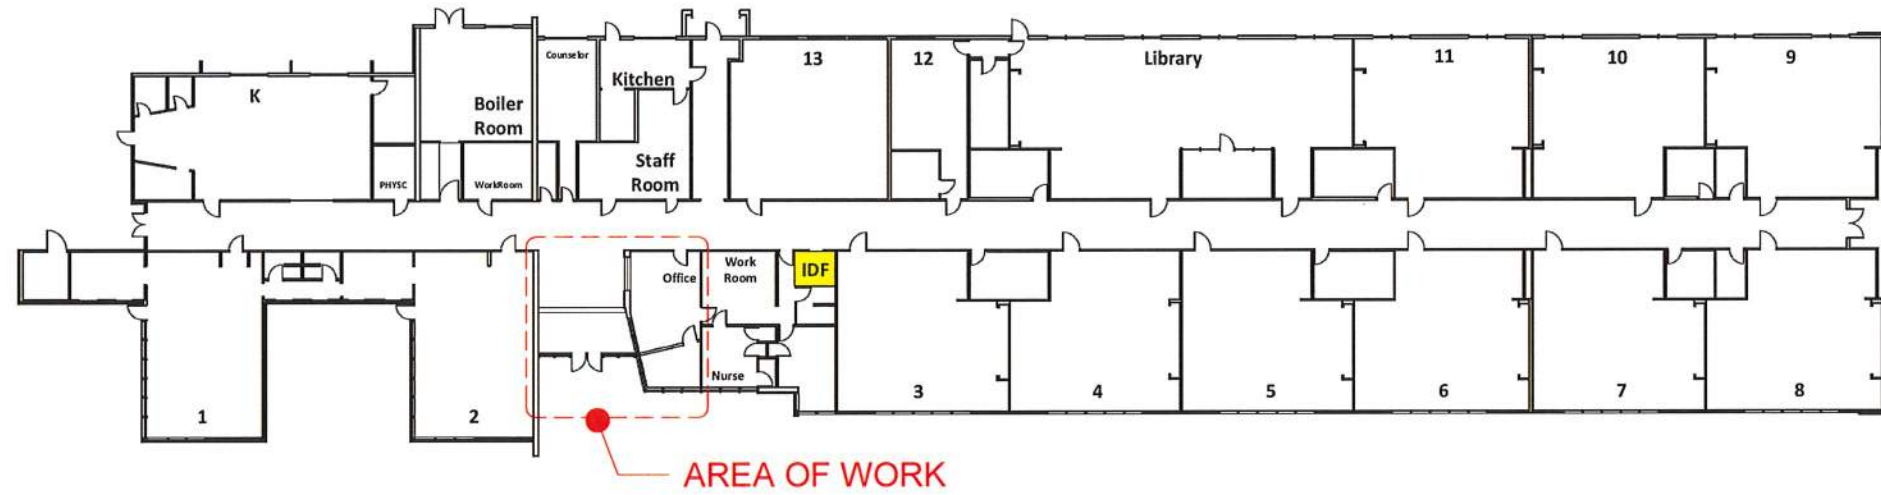

A

A3.1

OVERALL PLAN

1" = 40'-0"

N

4331

REGISTERED ARCHITECT

CRAIG M. COLLINS

STATE OF WASHINGTON

Scale

1" = 40'-0"

Date

2/14/2022

Project #

2021-18

COLLINS

ARCHITECTURAL GROUP, P.S.

950 12th AVE., SUITE 200

LONGVIEW, WA 98632


PHONE: 360-425-0000

OVERALL PLAN


LONGVIEW SCHOOL DISTRICT

OLYMPIC ELEMENTARY SCHOOL

A3.1

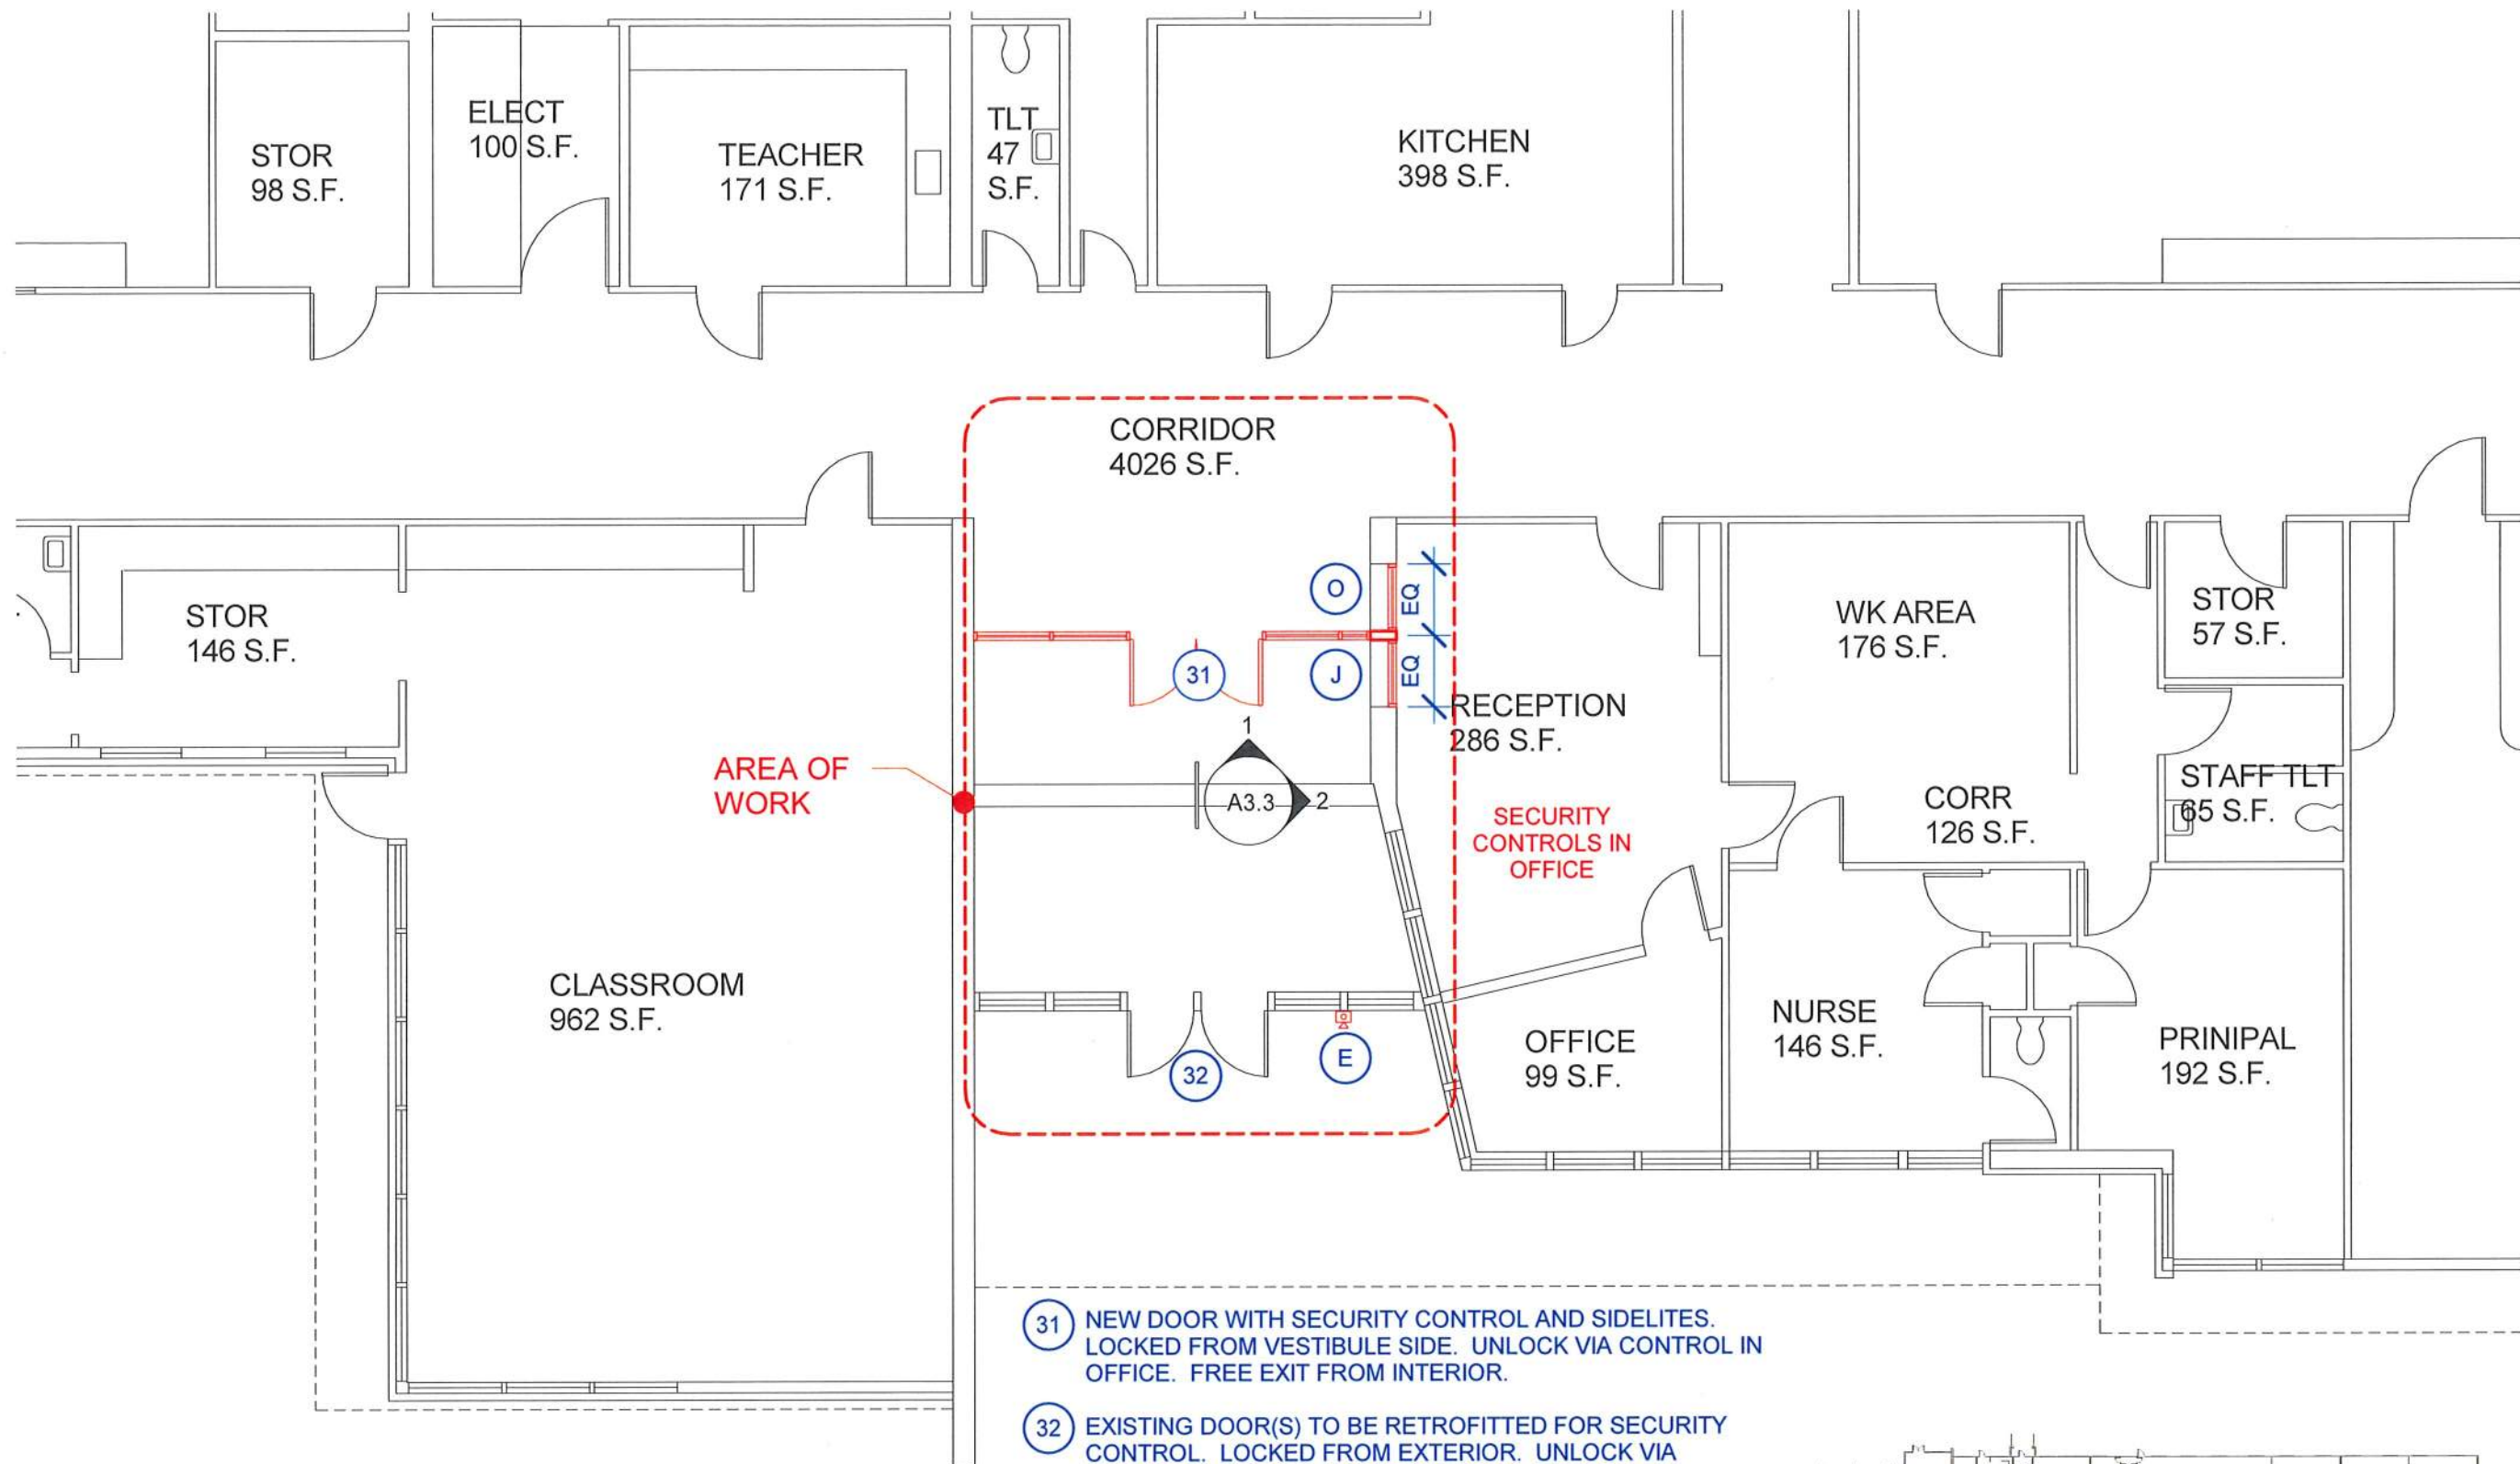

- 31 NEW DOOR WITH SECURITY CONTROL AND SIDELITES. LOCKED FROM VESTIBULE SIDE. UNLOCK VIA CONTROL IN OFFICE. FREE EXIT FROM INTERIOR.
- 32 EXISTING DOOR(S) TO BE RETROFITTED FOR SECURITY CONTROL. LOCKED FROM EXTERIOR. UNLOCK VIA CONTROL IN OFFICE. FREE EXIT FROM INTERIOR.
- E INTERCOM/CAMERA WITH COMMUNICATION TO OFFICE
- J NEW SECURE WINDOW WITH SPEAK HOLE AND DOCUMENT PASS-THROUGH
- O NEW RELITE FOR STUDENT SERVICE WINDOW. FIELD VERIFY EXISTING OPENING DIMENSIONS, SEE ELEVATION 2/A3.3. BASIS OF DESIGN: CRL SW1014A. SUBSTITUTIONS: SEE SECTION 01 6000 - PRODUCT REQUIREMENTS

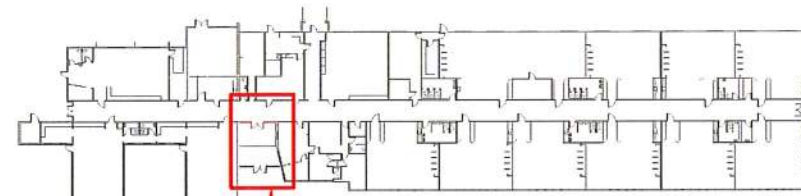

AREA OF WORK

KEYPLAN



A FLOOR PLAN
A3.2 1/8" = 1'-0"

ADD1 12/22/2021

4331
REGISTERED ARCHITECT
CRAIG M. COLLINS
STATE OF WASHINGTON

Scale 1/8" = 1'-0"
Date 2/14/2022
Project # 2021-18

COLLINS
ARCHITECTURAL GROUP, P.S.
950 12th AVE., SUITE 200
LONGVIEW, WA 98632
PHONE: 360-425-0000

VESTIBULE SECURITY PLAN

LONGVIEW SCHOOL DISTRICT

OLYMPIC ELEMENTARY SCHOOL




A3.2

DOOR SCHEDULE

DOOR NO.	SIZE WxHxT	DOOR					FRAME			HARDWARE GROUP	REMARKS
		GLAZING	TYPE	MAT	FINISH	LABEL	TYPE	MAT	FIN		
31	PR 6'-0"x7'-0"x1 3/4"	TEMP	1/A3.5	ALUM	-	-	1/A3.3	ALUM	-	08	1, 2
32	PR 6'-0"x7'-0"x1 3/4"	temp	exist.	alum	-	-	exist.	alum	-	09	1, 2

UPPERCASE = NEW MATERIAL lowercase = existing material

- REMARKS:
- 1. DOOR HAS ELECTRONIC ACCESS CONTROL OR MONITORING
 - 2. POWER SUPPLY REQUIRES 120V AC


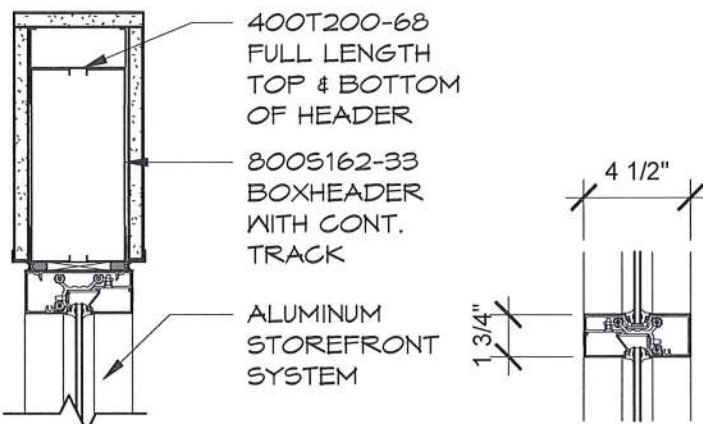
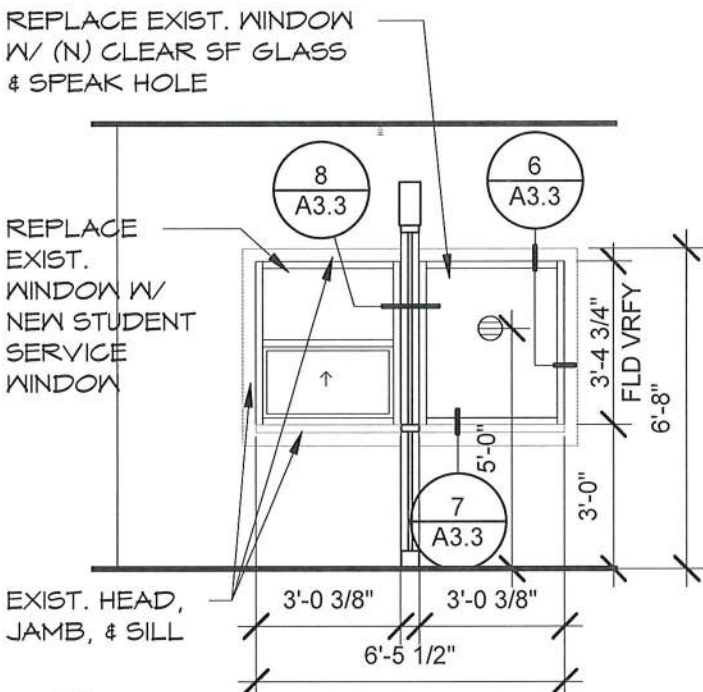
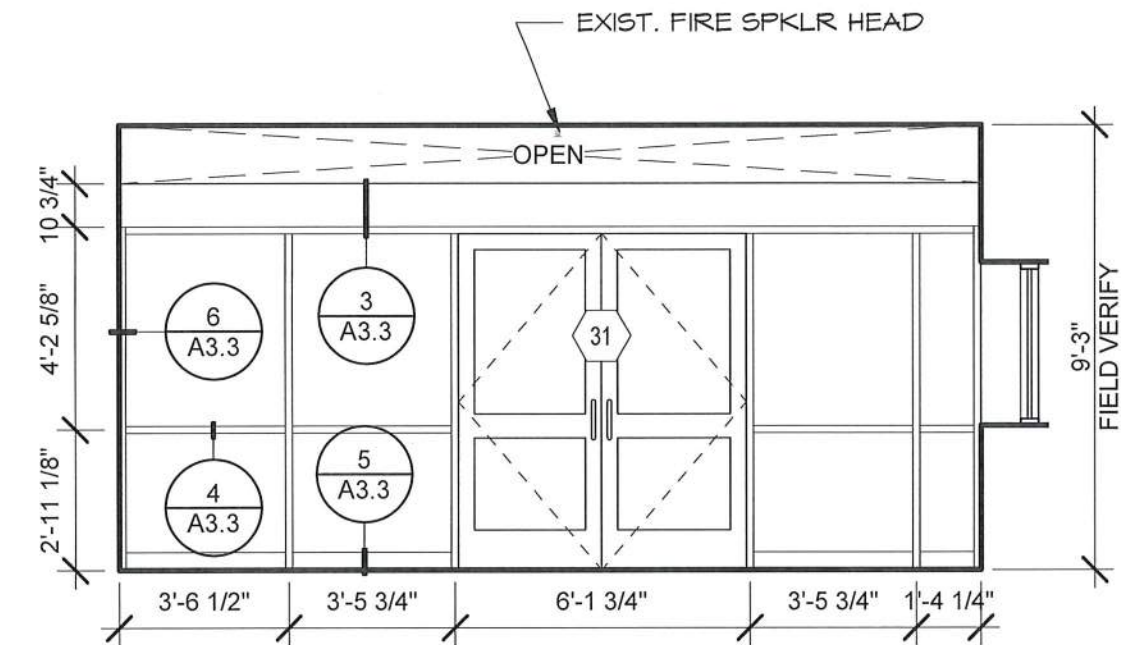


1 EAST INT. STOREFRONT PARTITION
A3.3 1/4" = 1'-0"

2 SERVICE WINDOWS
A3.3 1/4" = 1'-0"

3 SF HEAD
A3.3 1 1/2" = 1'-0"

4 SF MULLION
A3.3 1 1/2" = 1'-0"

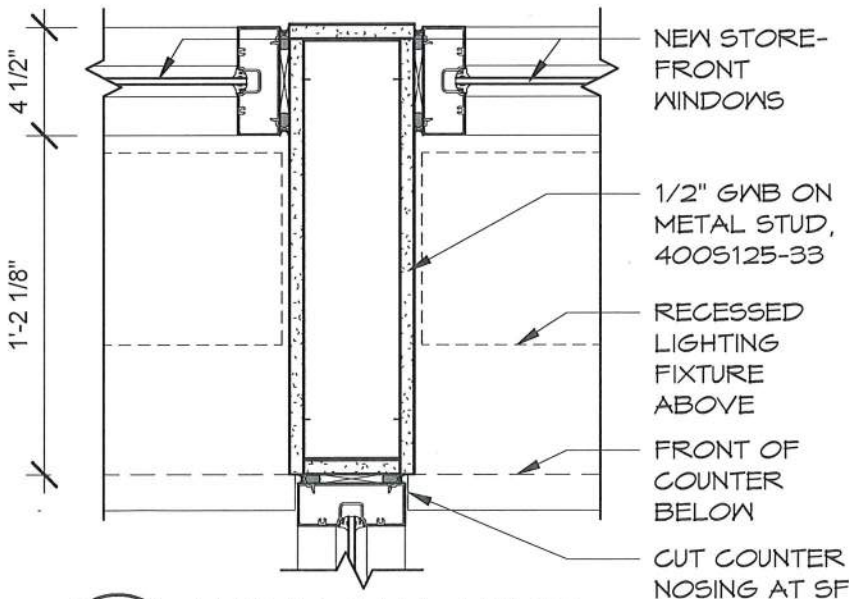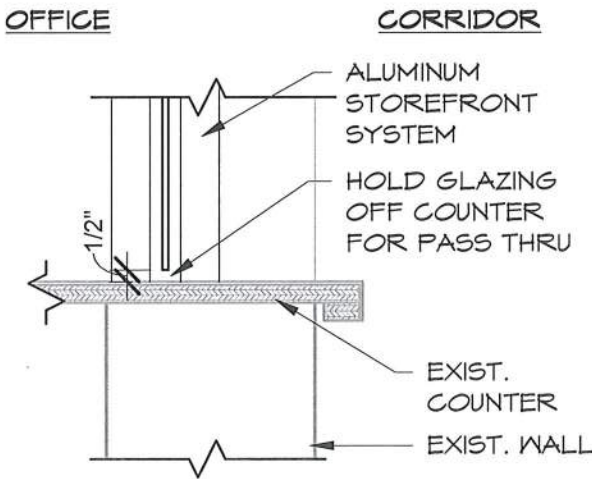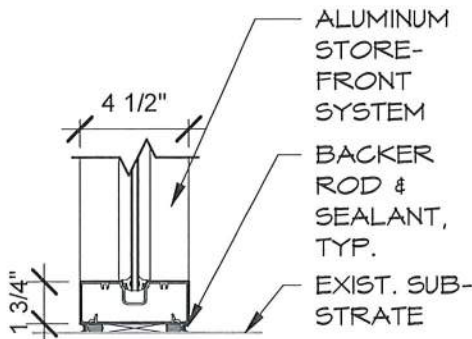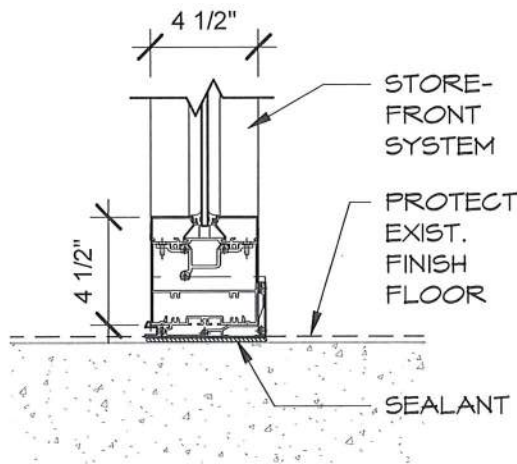

5 SF SILL
A3.3 1 1/2" = 1'-0"

6 SF JAMB
A3.3 1 1/2" = 1'-0"

7 PASS THRU SILL
A3.3 1 1/2" = 1'-0"

8 WINDOW JAMB
A3.3 1 1/2" = 1'-0"

4331
REGISTERED ARCHITECT
CRAIG M. COLLINS
STATE OF WASHINGTON

Scale	As indicated
Date	2/14/2022
Project #	2021-18

COLLINS
ARCHITECTURAL GROUP, P.S.
950 12th AVE., SUITE 200
LONGVIEW, WA 98632
PHONE: 360-425-0000

SCHEDULE, ELEVATIONS, & DETAILS

LONGVIEW SCHOOL DISTRICT

OLYMPIC ELEMENTARY SCHOOL

A3.3


St Helens

Elementary School

431 27th Ave

0204080

Scale in Feet

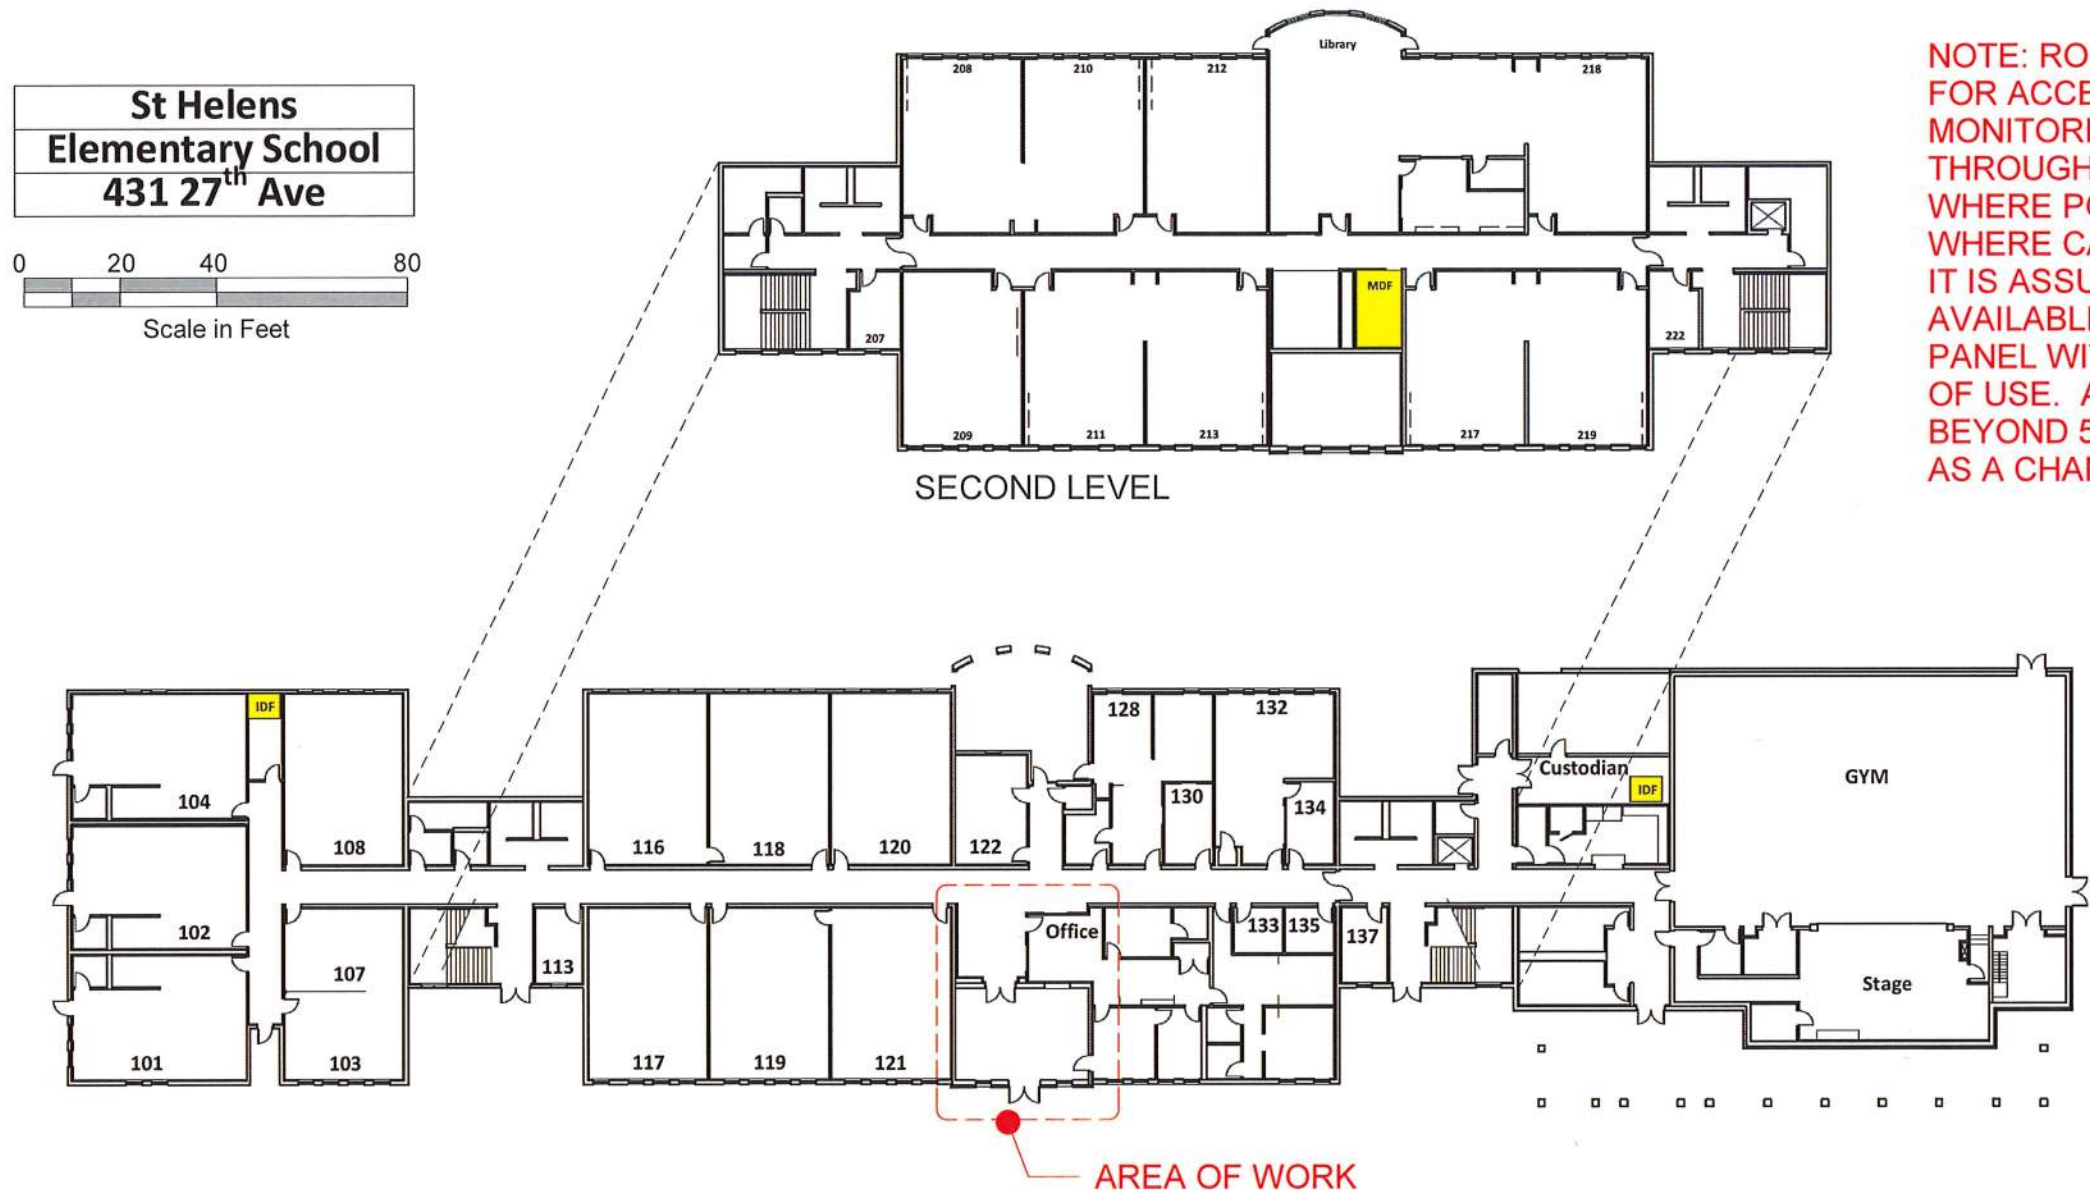

A

OVERALL PLAN

A4.1

1" = 40'-0"



4331

REGISTERED ARCHITECT

CRAIG M. COLLINS

STATE OF WASHINGTON

Scale

1" = 40'-0"

Date

2/14/2021

Project #

2021-18

COLLINS

ARCHITECTURAL GROUP, P.S.

950 12th AVE., SUITE 200

LONGVIEW, WA 98632


PHONE: 360-425-0000

OVERALL PLAN

LONGVIEW SCHOOL DISTRICT

ST. HELENS ELEMENTARY SCHOOL

A4.1

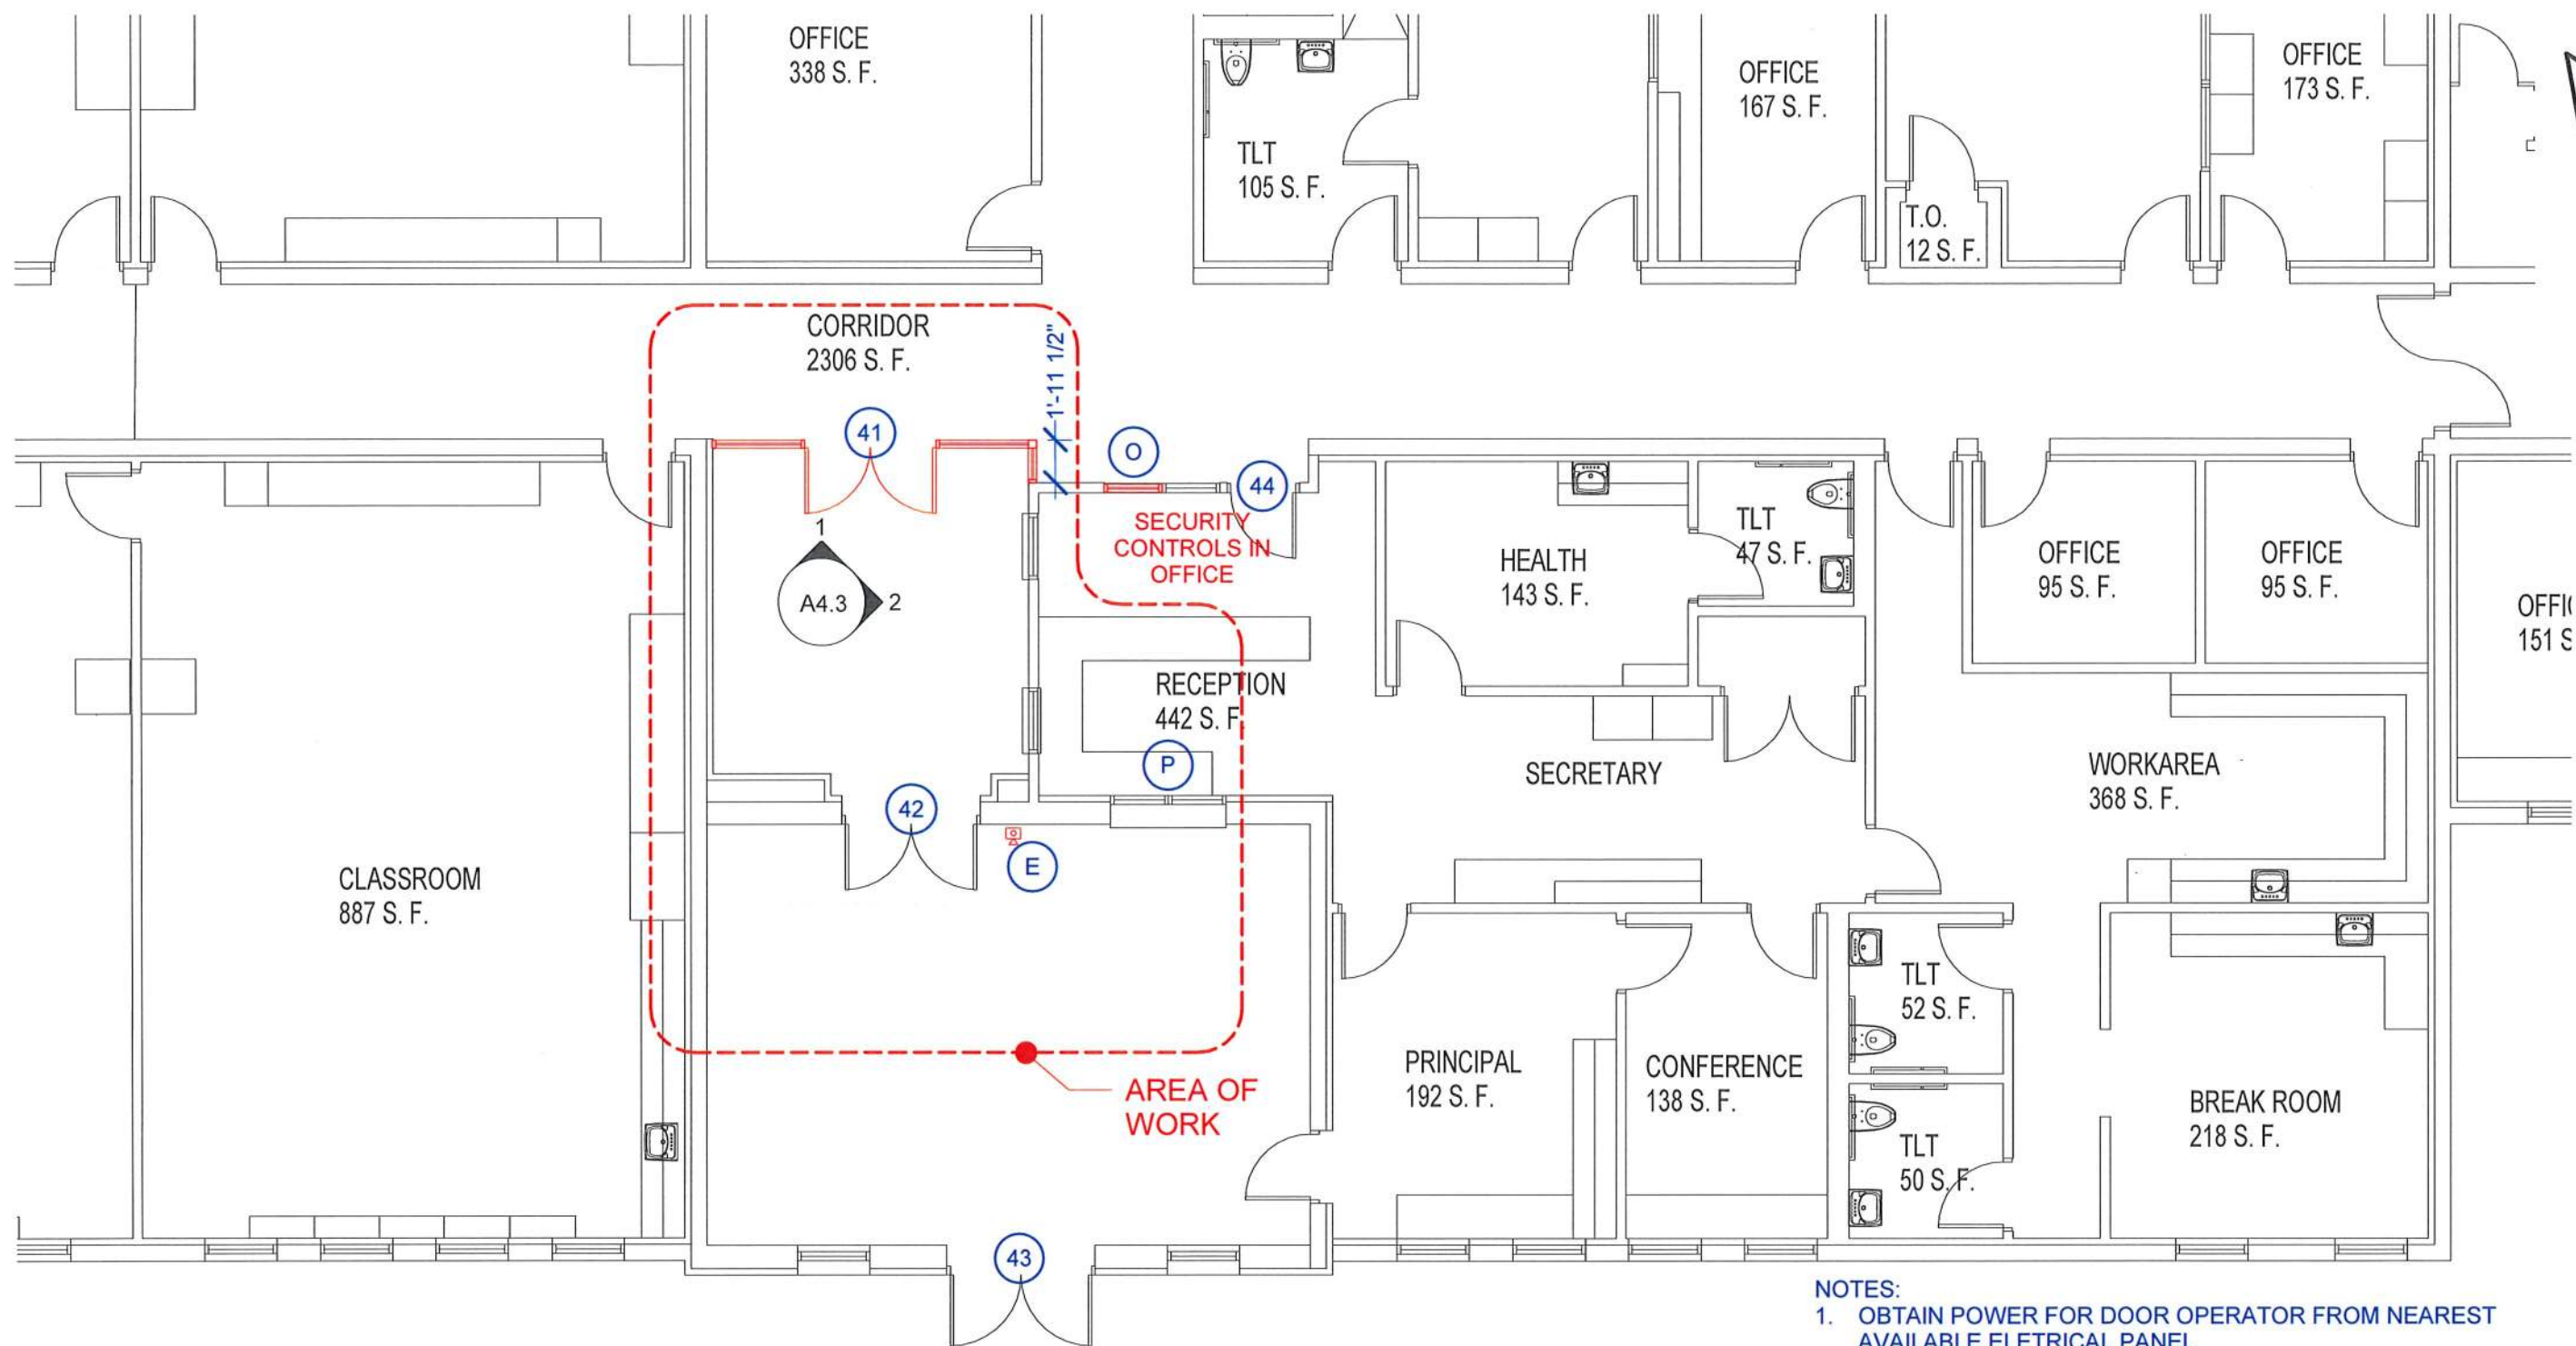

- 41 NEW DOOR WITH SECURITY CONTROL AND SIDELITES. LOCKED FROM VESTIBULE SIDE, UNLOCK VIA CONTROL IN OFFICE. FREE EXIT FROM INTERIOR
- 42 EXISTING DOOR(S) TO BE RETROFITTED FOR SECURITY CONTROL, LOCKED FROM EXTERIOR, UNLOCK VIA CONTROL IN OFFICE. FREE EXIT FROM INTERIOR
- 43 EXISTING GATE, OPEN DURING OCCUPIED TIMES, LOCKED AFTER HOURS, FREE EXIT FROM INTERIOR
- 44 EXISTING DOOR(S), NO REVISION
- E INTERCOM/CAMERA WITH COMMUNICATION TO OFFICE
- O NEW RELITE FOR STUDENT SERVICE WINDOW. FIELD VERIFY EXISTING OPENING DIMENSIONS. REPLACE EXISTING GLAZING AND HM STOP. BASIS OF DESIGN: CRL SW1014A. SUBSTITUTIONS: SEE SECTION 01 6000 - PRODUCT REQUIREMENTS.
- P PROVIDE 3M MIRROR FILM FOR PRIVACY ON INTERIOR OF EXISTING GLAZING

NOTES:
1. OBTAIN POWER FOR DOOR OPERATOR FROM NEAREST AVAILABLE ELECTRICAL PANEL



AREA OF WORK

KEYPLAN

A FLOOR PLAN
A4.2 1/8" = 1'-0"

ADD1 12/22/2021




4331 REGISTERED ARCHITECT CRAIG M. COLLINS STATE OF WASHINGTON		
Scale 1/8" = 1'-0"	Date 2/14/2021	Project # 2021-18
COLLINS ARCHITECTURAL GROUP, P.S. 950 12th AVE., SUITE 200 LONGVIEW, WA 98632 PHONE: 360-425-0000		
VESTIBULE SECURITY PLAN LONGVIEW SCHOOL DISTRICT ST. HELENS ELEMENTARY SCHOOL		
A4.2		


DOOR SCHEDULE											
DOOR NO.	SIZE WxHxT	DOOR					FRAME			HARDWARE GROUP	REMARKS
		GLAZING	TYPE	MAT	FINISH	LABEL	TYPE	MAT	FIN		
41	PR 6'-0"x7'-0"x1 3/4"	TEMP	1/A4.5	ALUM	-	-	1/A4.3	ALUM	-	08	1, 2
42	PR 6'-0"x7'-0"x1 3/4"	temp	exist.	alum	-	-	exist.	alum	-	09	1, 2

REMARKS:
 1. DOOR HAS ELECTRONIC ACCESS CONTROL OR MONITORING
 2. POWER SUPPLY REQUIRES 120V AC


UPPERCASE = NEW MATERIAL lowercase = existing material

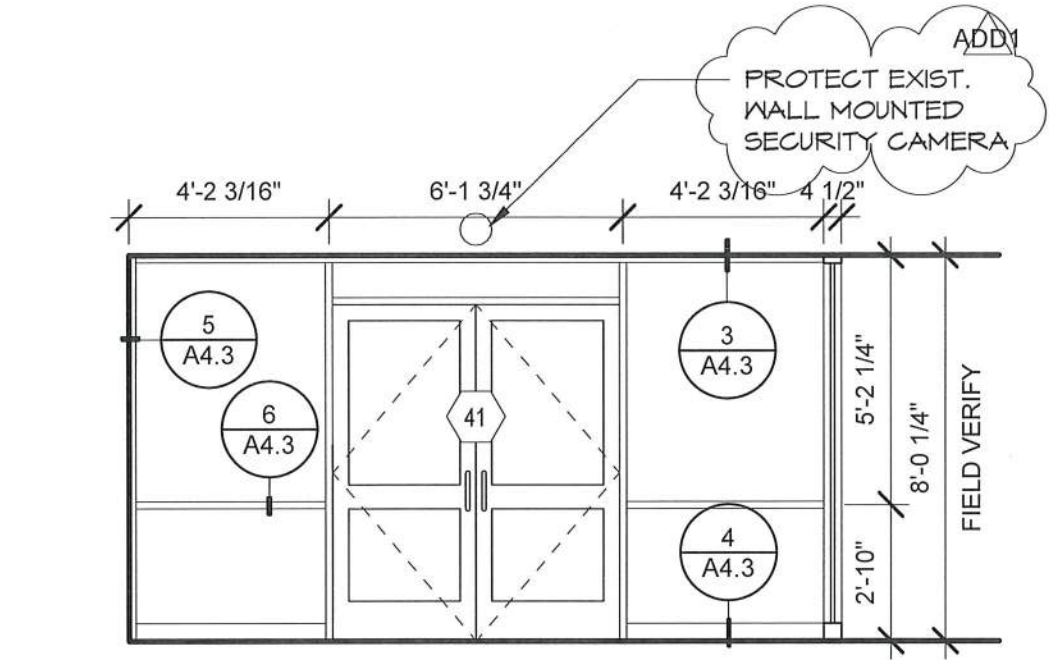


1 STOREFRONT N. WEST ELEVATION
 A4.3 1/4" = 1'-0" ADD1 12/22/2021

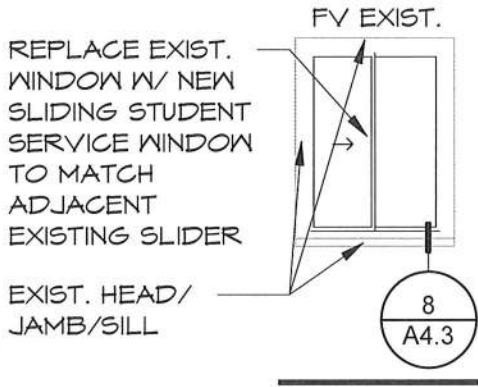


2 SF WINDOW
 A4.3 1/4" = 1'-0"

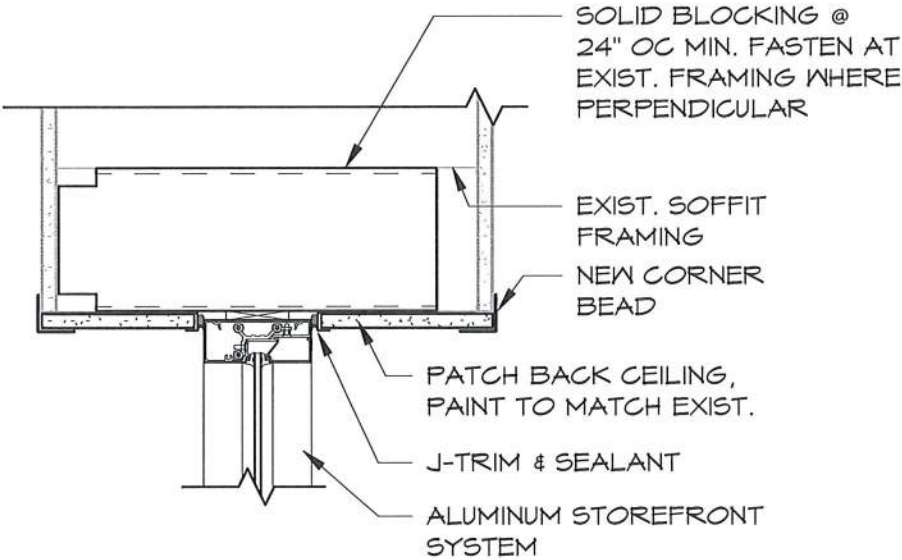


3 STOREFRONT HEAD
 A4.3 1 1/2" = 1'-0"

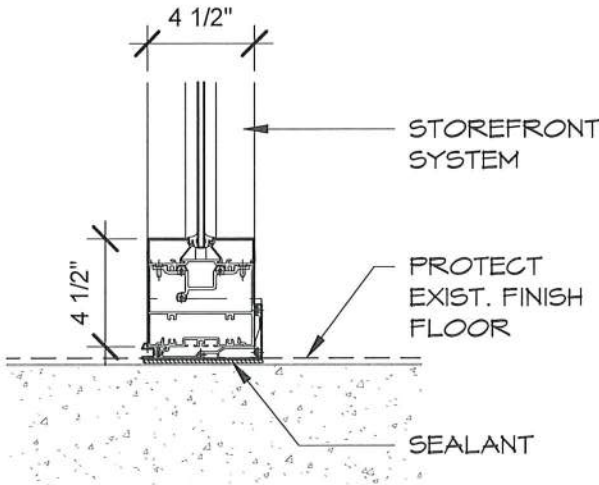


4 STOREFRONT SILL
 A4.3 1 1/2" = 1'-0"

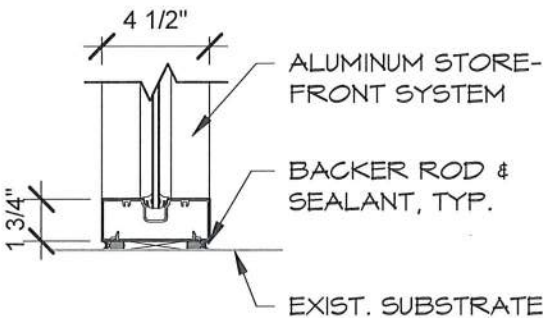


5 SF JAMB
 A4.3 1 1/2" = 1'-0"

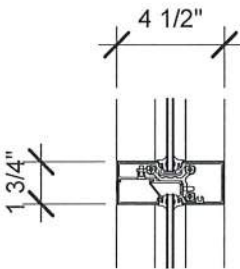

6 SF MULLION
 A4.3 1 1/2" = 1'-0"

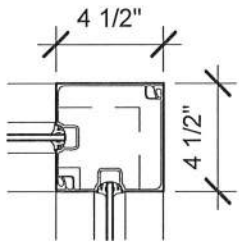

7 SF CORNER
 A4.3 1 1/2" = 1'-0"

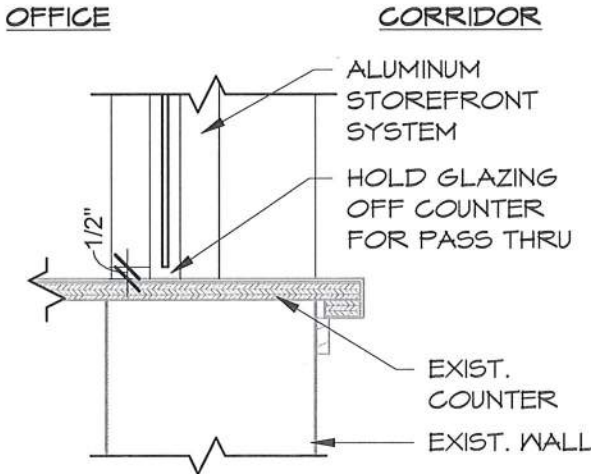

8 PASS THRU SILL
 A4.3 1 1/2" = 1'-0"

4331

REGISTERED ARCHITECT

CRAIG M. COLLINS

STATE OF WASHINGTON

Scale	As indicated
Date	2/14/2021
Project #	2021-18

COLLINS

ARCHITECTURAL GROUP, P.S.

950 12th AVE., SUITE 200

LONGVIEW, WA 98632

PHONE: 360-425-0000

 
SCHEDULE, ELEVATIONS, & DETAILS

LONGVIEW SCHOOL DISTRICT


ST. HELENS ELEMENTARY SCHOOL

A4.3

**Robert Gray
Elementary
4622 Ohio**



NOTE: ROUTE NEW DATA CABLING FOR ACCESS CONTROL AND MONITORING TO IDF, ROUTE THROUGH CONCEALED SPACES WHERE POSSIBLE, USE WIREMOLD WHERE CABLING MUST BE EXPOSED. IT IS ASSUMED THAT 120V POWER IS AVAILABLE FROM AN ELECTRICAL PANEL WITHIN 50 FEET OF THE POINT OF USE. ANY CONDUIT/WIRING BEYOND 50FT WILL BE PROCESSED AS A CHANGE ORDER.

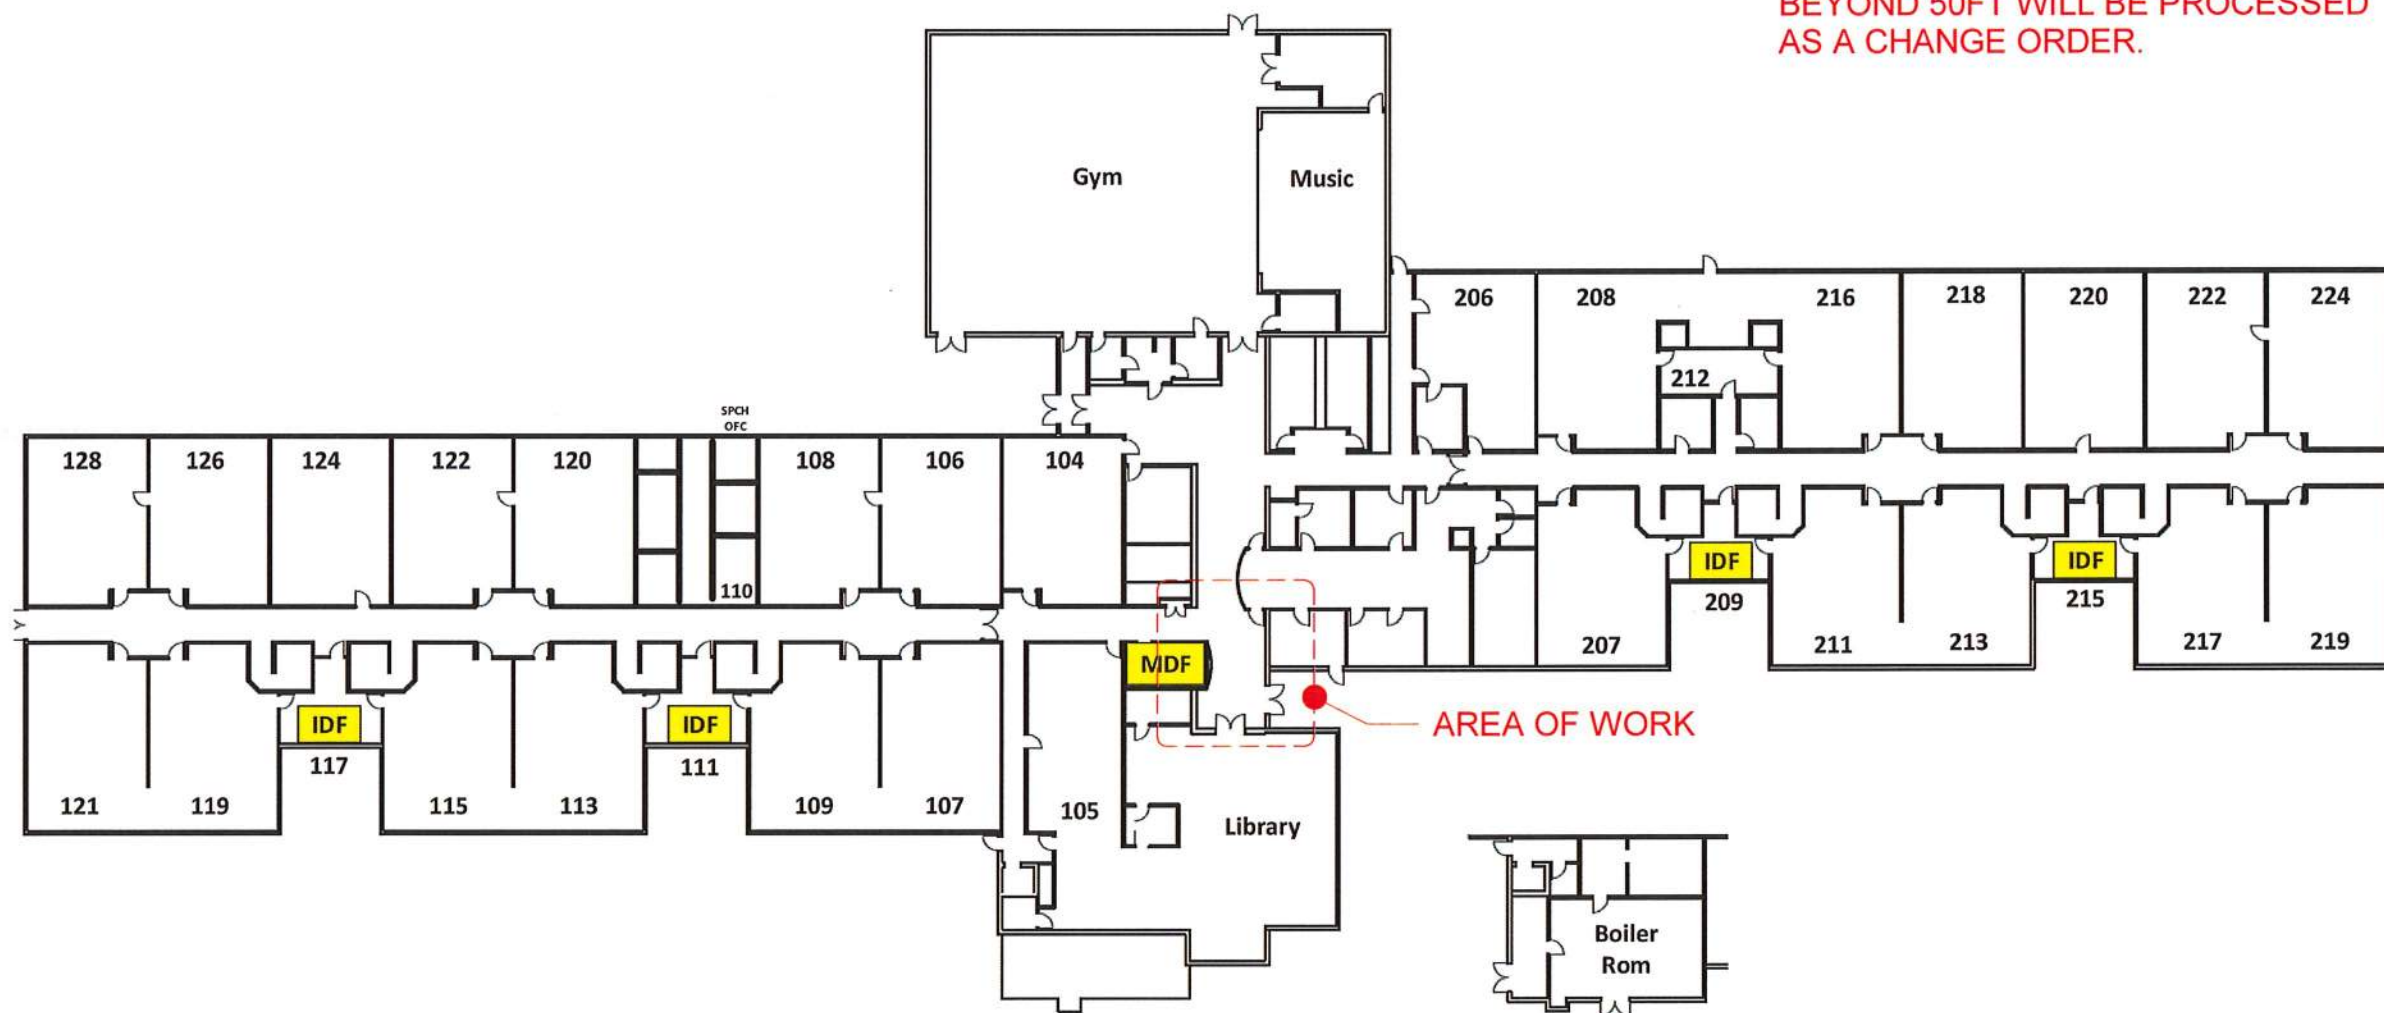

4331
REGISTERED ARCHITECT
CRAIG M. COLLINS
STATE OF WASHINGTON

Scale
1" = 40'-0"
Date
2/14/2022
Project #
2021-18



COLLINS
ARCHITECTURAL GROUP, P.S.
950 12th AVE., SUITE 200
LONGVIEW, WA 98632
PHONE: 360-425-0000

OVERALL PLAN
LONGVIEW SCHOOL DISTRICT
ROBERT GRAY ELEMENTARY SCHOOL


A OVERALL PLAN
A8.1 1" = 40'-0"



A8.1

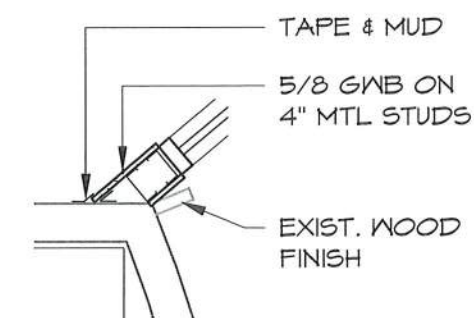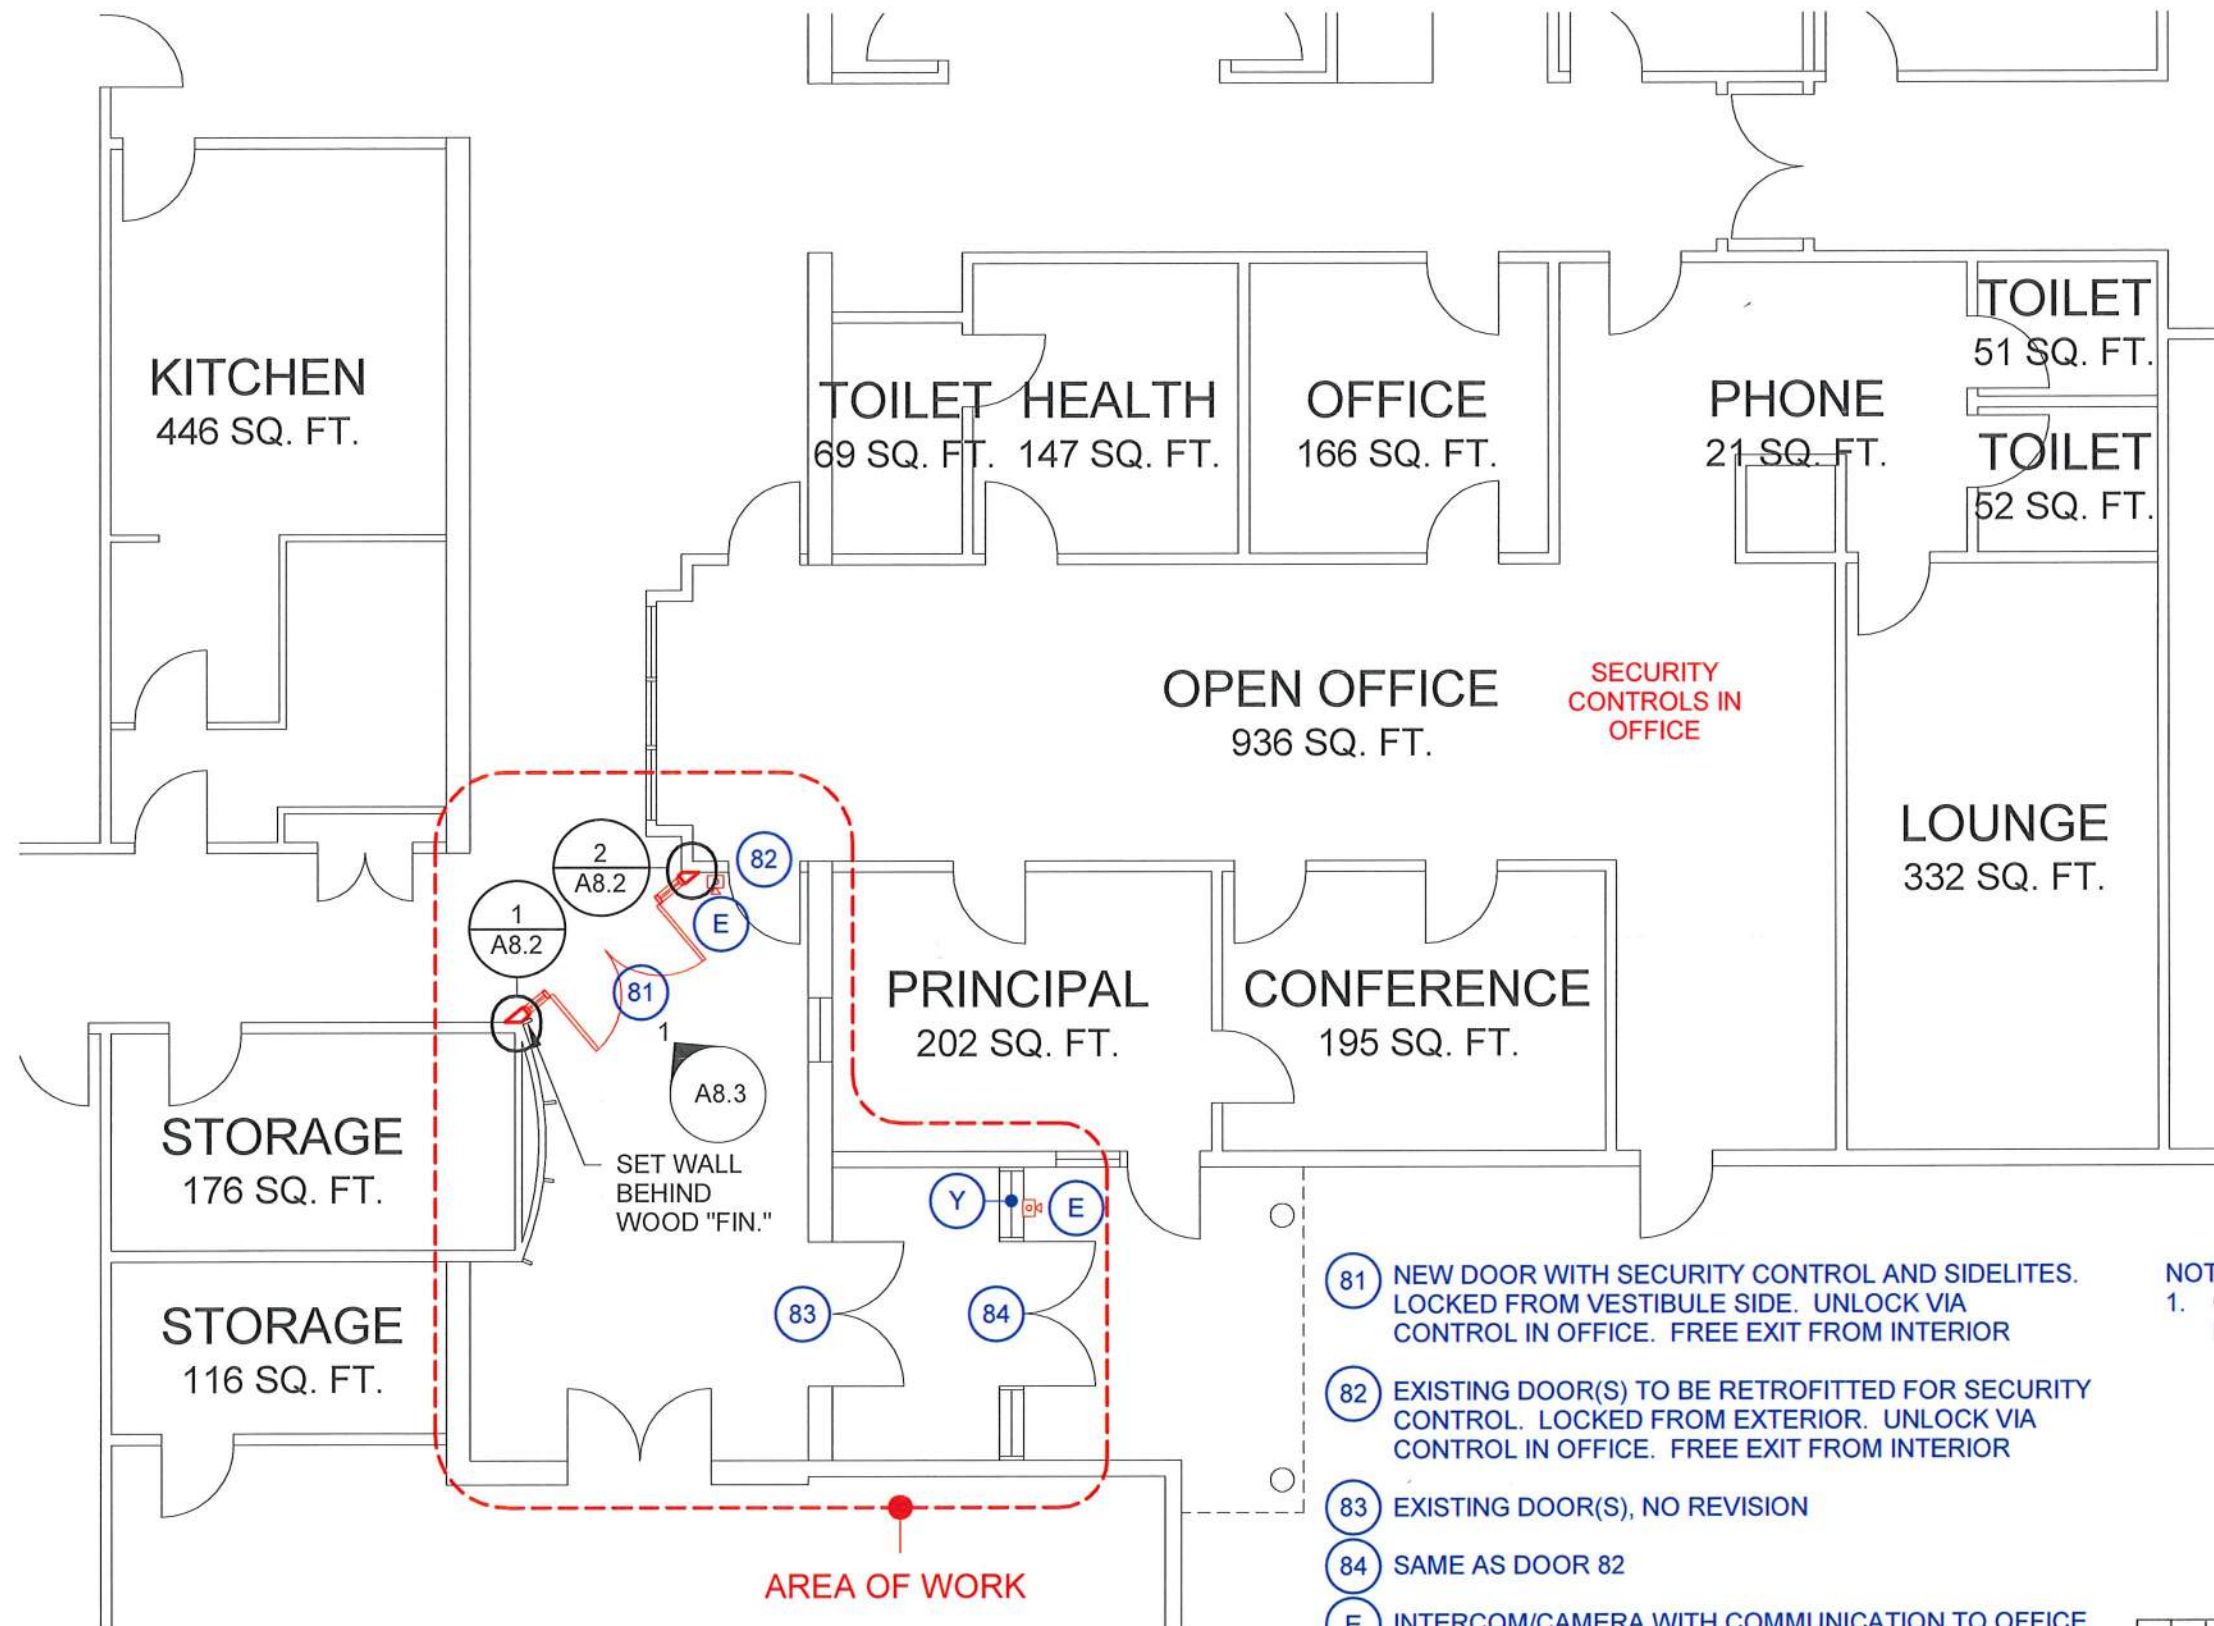


1 WALL DETAIL
A8.2 1/2" = 1'-0"

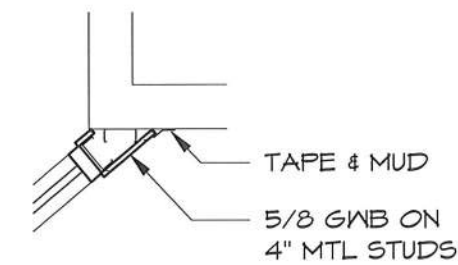

2 WALL DETAIL
A8.2 1/2" = 1'-0"

- (81) NEW DOOR WITH SECURITY CONTROL AND SIDELITES. LOCKED FROM VESTIBULE SIDE. UNLOCK VIA CONTROL IN OFFICE. FREE EXIT FROM INTERIOR
- (82) EXISTING DOOR(S) TO BE RETROFITTED FOR SECURITY CONTROL. LOCKED FROM EXTERIOR. UNLOCK VIA CONTROL IN OFFICE. FREE EXIT FROM INTERIOR
- (83) EXISTING DOOR(S), NO REVISION
- (84) SAME AS DOOR 82
- (E) INTERCOM/CAMERA WITH COMMUNICATION TO OFFICE
- (Y) REPLACE UPPER SIDELITE GLAZING WITH SPANDREL PANEL FOR MOUNTING INTERCOM AT DOOR 84.


NOTES:
1. OBTAIN POWER FOR DOOR OPERATOR FROM NEAREST AVAILABLE ELETRICAL PANEL

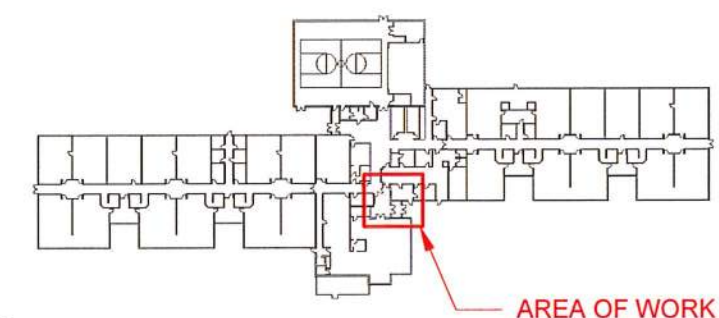

KEYPLAN

A FLOOR PLAN
A8.2 1/8" = 1'-0"

ADD1 12/22/2021

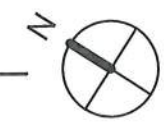

4331
REGISTERED ARCHITECT
CRAIG M. COLLINS
STATE OF WASHINGTON

Scale As indicated	Date 2/14/2022	Project # 2021-18
-----------------------	-------------------	----------------------

COLLINS
ARCHITECTURAL GROUP, P.S.
950 12th AVE., SUITE 200
LONGVIEW, WA 98632
PHONE: 360-425-0000

VESTIBULE SECURITY PLAN
LONGVIEW SCHOOL DISTRICT
ROBERT GRAY ELEMENTARY SCHOOL


A8.2

DOOR SCHEDULE

DOOR NO.	SIZE WxHxT	DOOR					FRAME			HARDWARE GROUP	REMARKS
		GLAZING	TYPE	MAT	FINISH	LABEL	TYPE	MAT	FIN		
81	PR 6'-0"x7'-0"x1 3/4"	TEMP	1/A8.3	ALUM	-	-	1/A8.3	ALUM	-	08	1, 2
82	3'-0"x7'-0"x1 3/4"	temp	exist.	wd	-	-	exist.	hm	-	15	1
84	PR 6'-0"x7'-0"x1 3/4"	temp	exist.	alum	paint	-	exist.	alum	paint	2	1, 2


UPPERCASE = NEW MATERIAL lowercase = existing material

REMARKS:
1. DOOR HAS ELECTRONIC ACCESS CONTROL OR MONITORING
2. POWER SUPPLY REQUIRES 120V AC

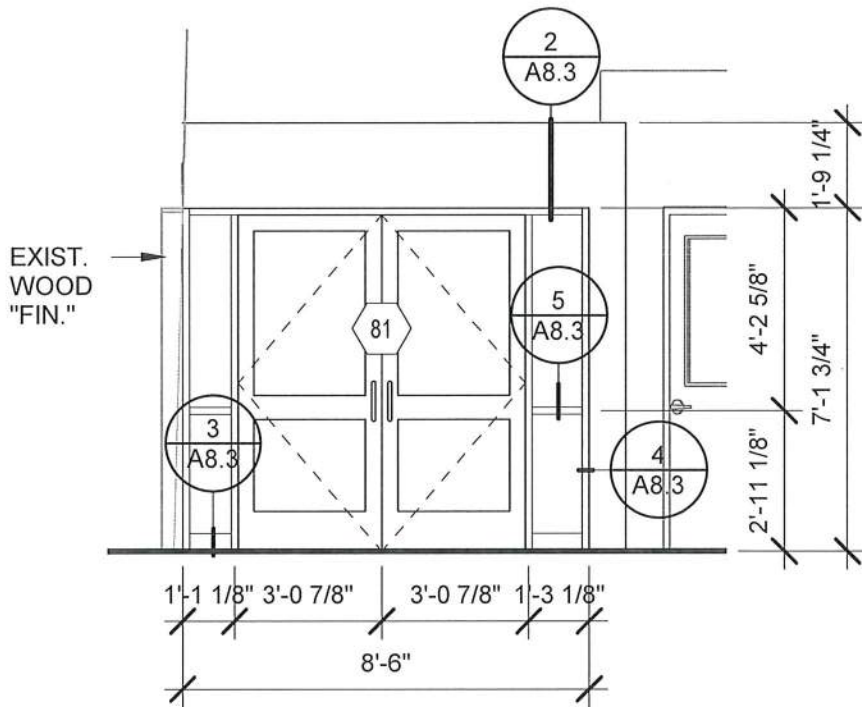


STOREFRONT NORTH ELEVATION

1
A8.3 1/4" = 1'-0"

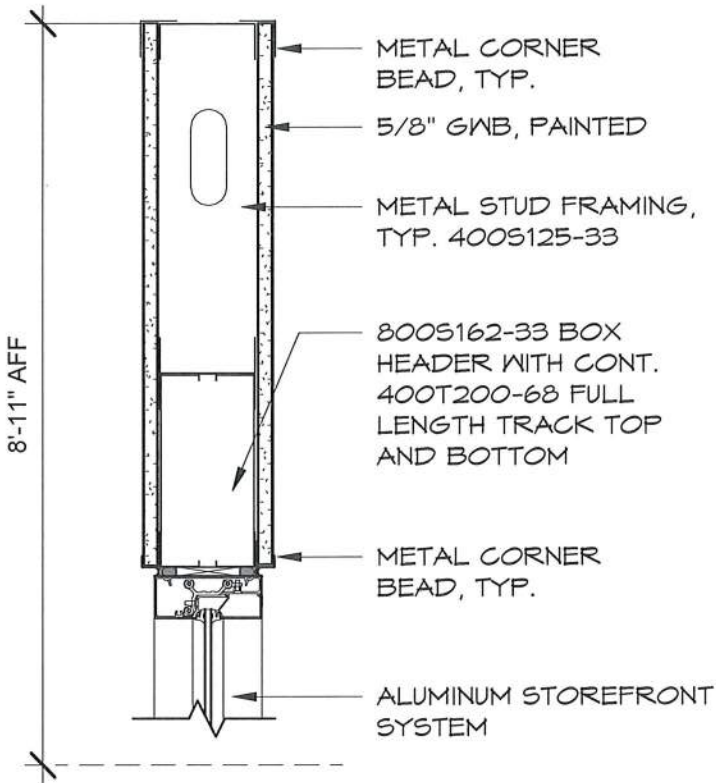


STOREFRONT HEAD

2
A8.3 1 1/2" = 1'-0"

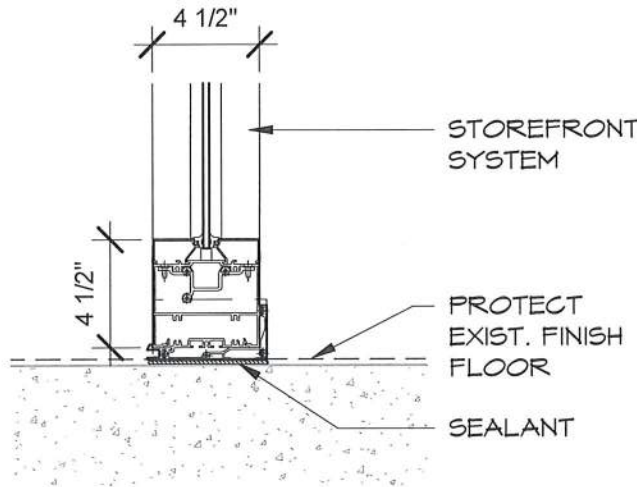


STOREFRONT SILL

3
A8.3 1 1/2" = 1'-0"

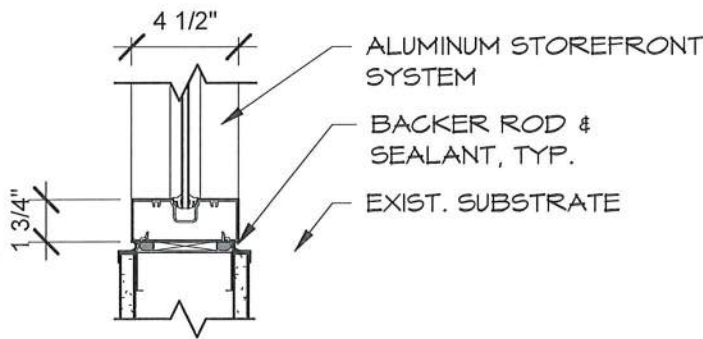

STOREFRONT JAMB

4
A8.3 1 1/2" = 1'-0"

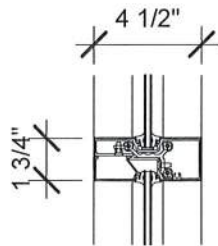

SF MULLION

5
A8.3 1 1/2" = 1'-0"

SCHEDULE, ELEVATIONS, & DETAILS

LONGVIEW SCHOOL DISTRICT

ROBERT GRAY ELEMENTARY SCHOOL

A8.3

4331

REGISTERED ARCHITECT

CRAIG M. COLLINS
STATE OF WASHINGTON

Scale
As indicated





 
Date
2/14/2022

Project #
2021-18

COLLINS
ARCHITECTURAL GROUP, P.S.



950 12th AVE., SUITE 200
LONGVIEW, WA 98632
PHONE: 360-425-0000

Mint Valley
Elementary
2745 38th Ave

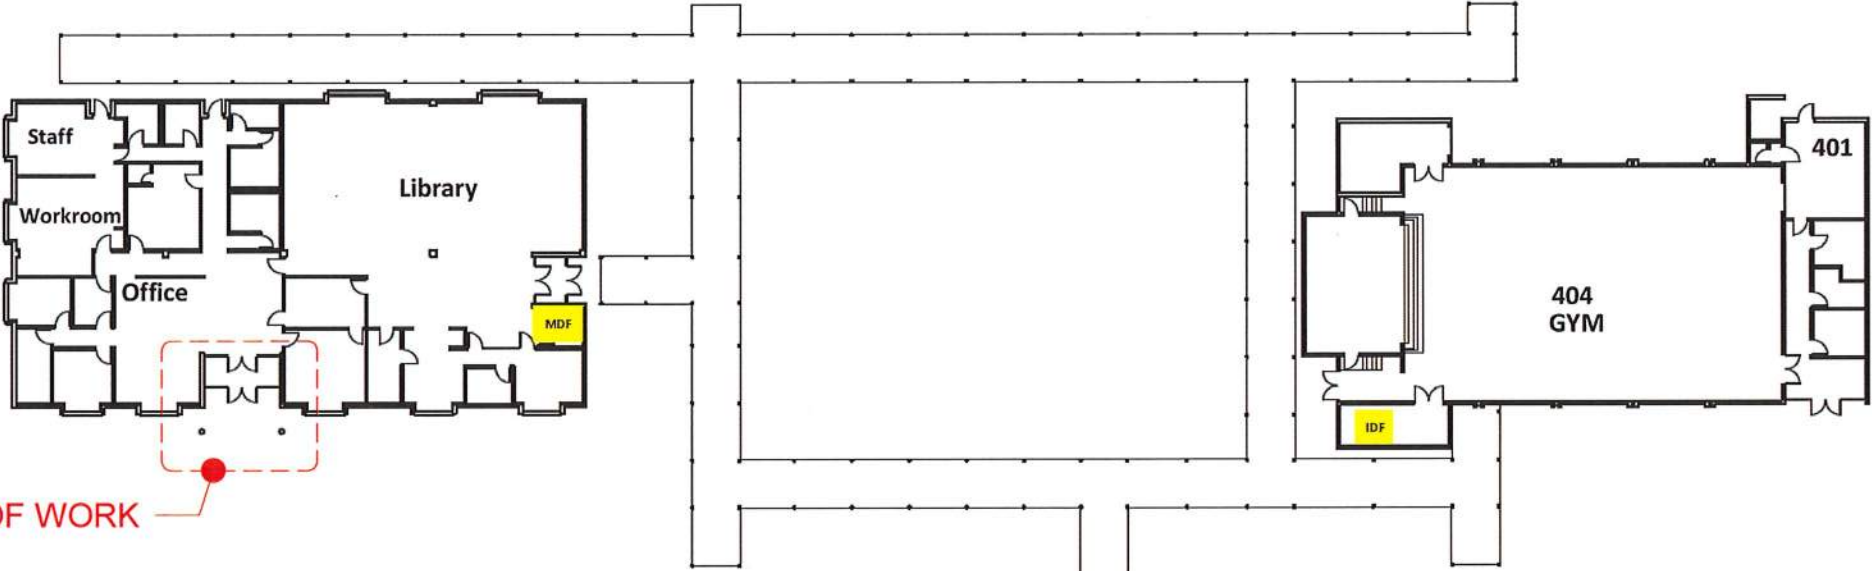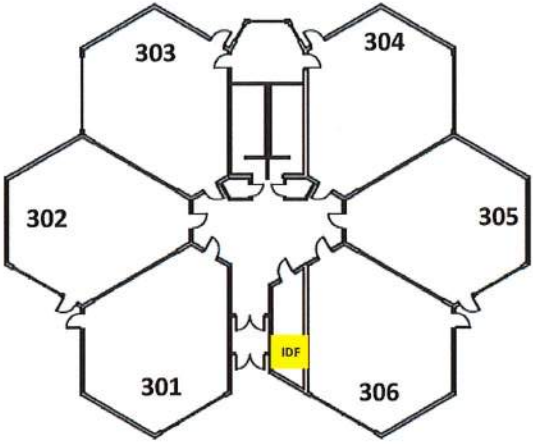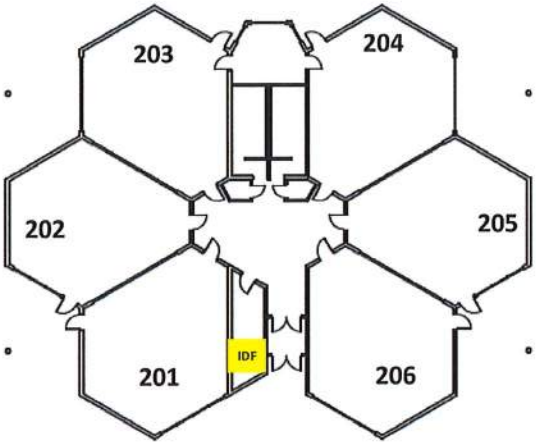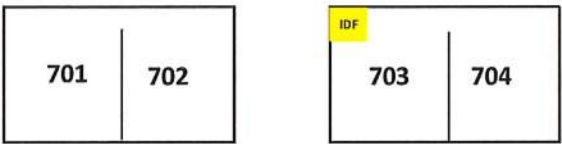

AREA OF WORK

NOTE: ROUTE NEW DATA CABLING FOR ACCESS CONTROL AND MONITORING TO IDF, ROUTE THROUGH CONCEALED SPACES WHERE POSSIBLE, USE WIREMOLD WHERE CABLING MUST BE EXPOSED. IT IS ASSUMED THAT 120V POWER IS AVAILABLE FROM AN ELECTRICAL PANEL WITHIN 50 FEET OF THE POINT OF USE. ANY CONDUIT/WIRING BEYOND 50FT WILL BE PROCESSED AS A CHANGE ORDER.

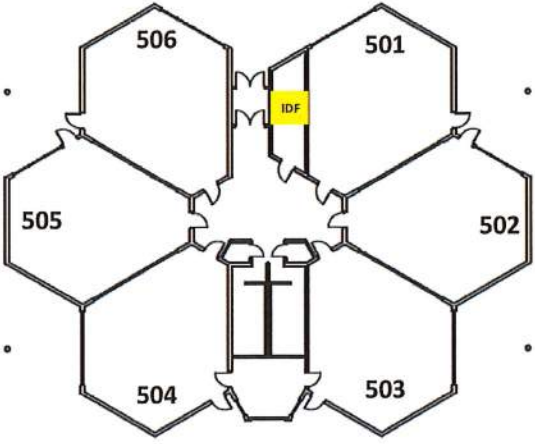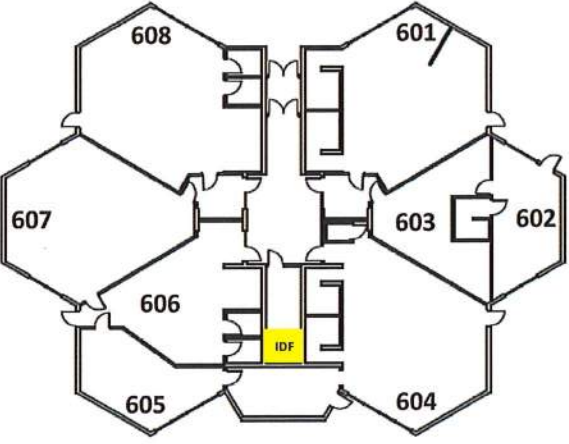

A OVERALL PLAN
A10.1 1" = 40'-0"




4331
REGISTERED
ARCHITECT
CRAIG M. COLLINS
STATE OF WASHINGTON

Scale 1" = 40'-0"
Date 2/14/2022
Project # 2021-18


COLLINS
ARCHITECTURAL GROUP, P.S.
950 12th AVE., SUITE 200
LONGVIEW, WA 98632
PHONE: 360-425-0000

OVERALL PLAN
LONGVIEW SCHOOL DISTRICT
MINT VALLEY ELEMENTARY SCHOOL

A10.1

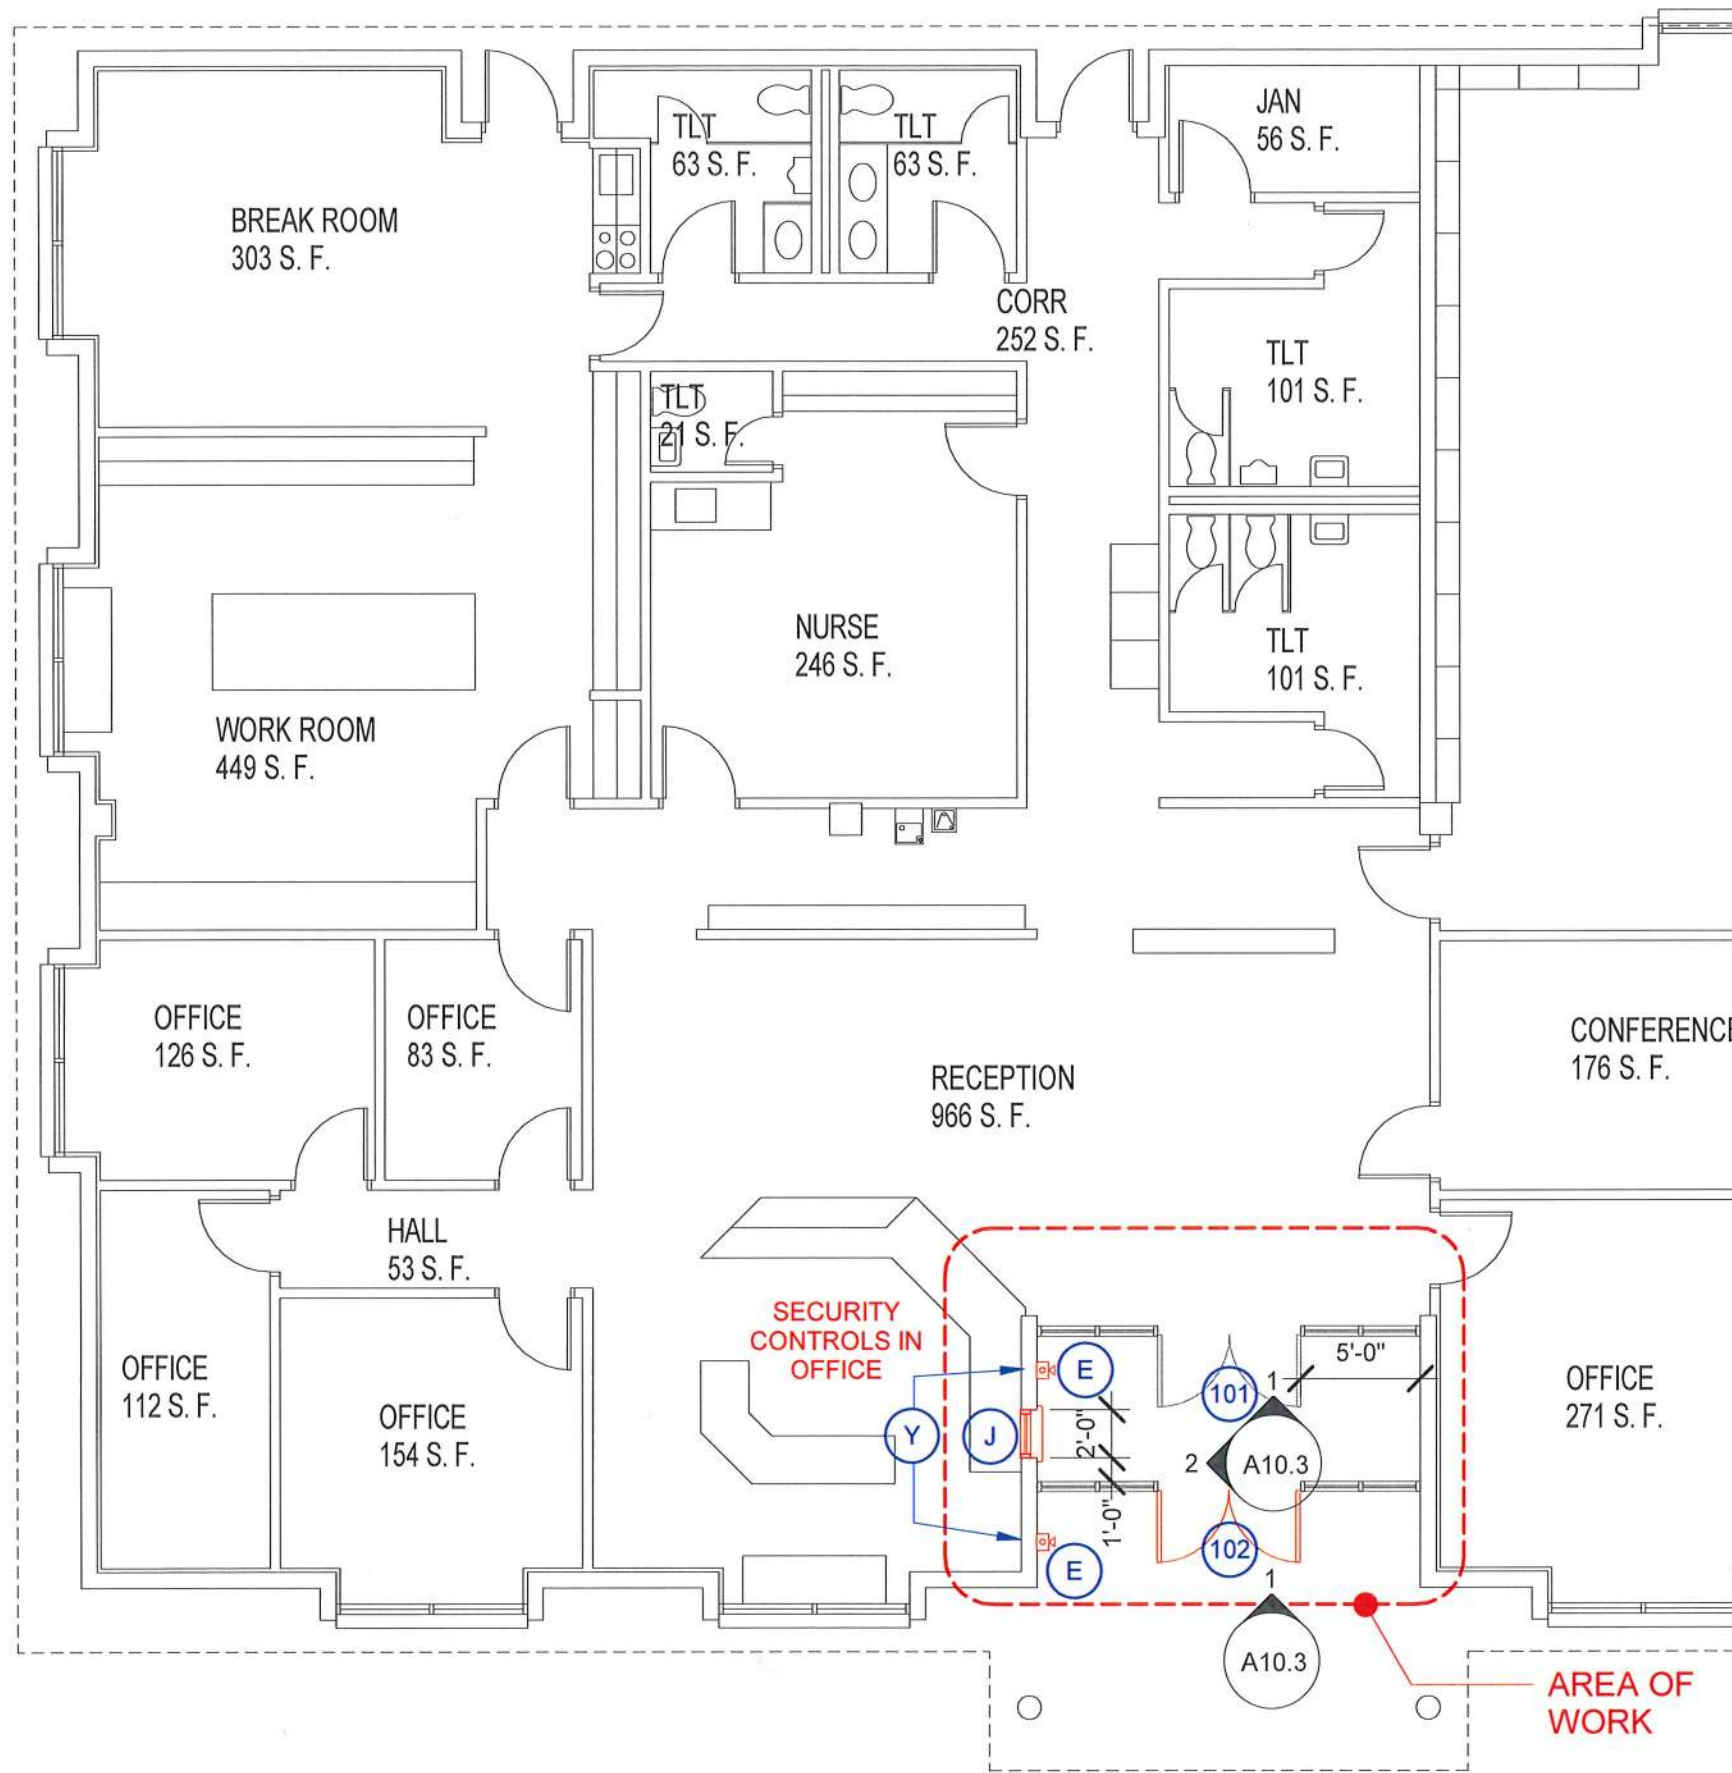

- (101) EXISTING DOOR(S) TO BE RETROFITTED FOR SECURITY CONTROL. LOCKED FROM VESTIBULE SIDE. UNLOCK VIA CONTROL IN OFFICE. FREE EXIT FROM INTERIOR.
- (102) EXISTING DOOR(S) TO BE RETROFITTED FOR SECURITY CONTROL. LOCKED FROM EXTERIOR. UNLOCK VIA CONTROL IN OFFICE. FREE EXIT FROM INTERIOR.
- (E) INTERCOM/CAMERA WITH COMMUNICATION TO OFFICE
- (J) NEW SECURE WINDOW WITH SPEAK HOLE AND DOCUMENT PASS-THROUGH
- (L) EXISTING DOORS TO BE REMOVED.
- (Y) SURFACE MOUNT CABLING IN WIREMOLD ON OFFICE/RECEPTION SIDE OF MASONRY WALL. PENETRATE WALL TO SURFACE MOUNTED DEVICES AT ENTRY AND IN VESTIBULE. SEAL PENETRATIONS WITH INSULATING FOAM.

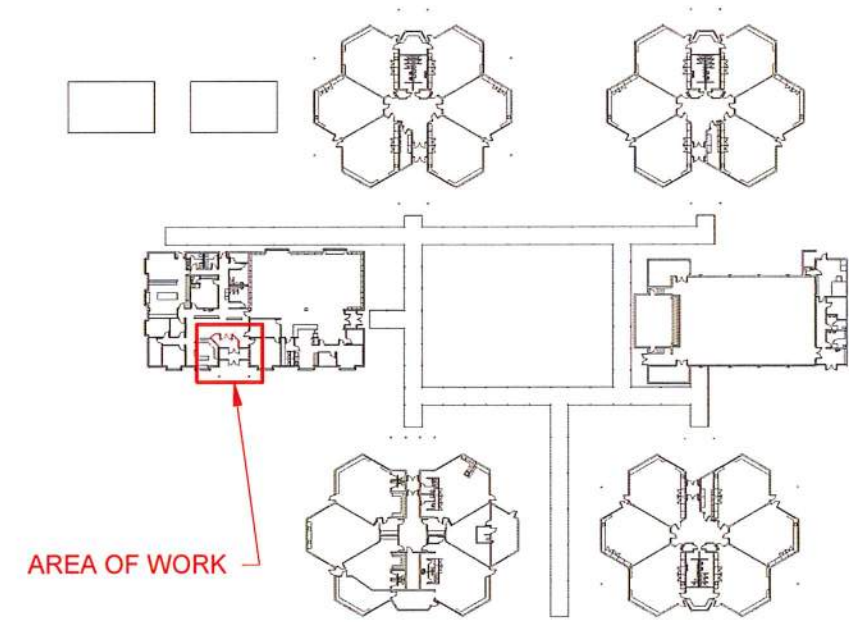

A FLOOR PLAN
A10.2 1/8" = 1'-0"

ADD1 12/22/2021



KEYPLAN

4331
REGISTERED ARCHITECT
Craig M. Collins
CRAIG M. COLLINS
STATE OF WASHINGTON

Scale 1/8" = 1'-0"	Date 2/14/2022	Project # 2021-18
COLLINS ARCHITECTURAL GROUP, P.S. 950 12th AVE., SUITE 200 LONGVIEW, WA 98632 PHONE: 360-425-0000		

VESTIBULE SECURITY PLAN

LONGVIEW SCHOOL DISTRICT

MINT VALLEY ELEMENTARY SCHOOL


A10.2

DOOR SCHEDULE											
DOOR NO.	SIZE WxHxT	DOOR					FRAME			HARDWARE GROUP	REMARKS
		GLAZING	TYPE	MAT	FINISH	LABEL	TYPE	MAT	FIN		
101	PR 6'-0"x6'-11"x2"	exist.	N	alum	-	-	1/A10.3	exist.	bronze	16	1, 2, 3
103	PR 6'-0"x6'-11"x2"	TEMP	N	ALUM	-	-	1/A10.3	exist.	bronze	16	1, 2, 3


UPPERCASE = NEW MATERIAL lowercase = existing material

REMARKS:


1. DOOR HAS ELECTRONIC ACCESS CONTROL OR MONITORING.
2. POWER SUPPLY REQUIRES 120V AC
3. REMOVE EXISTING DOOR CLOSERS, FILL FLOOR AND INSTALL NEW BOTTOM PIVOT ASSEMBLY AND NEW THRESHOLD.
FIELD VERIFY NEW PIVOT OFFSET DIMENSION & PROPER THRESHOLD DEPTH BEFORE PROCUREMENT

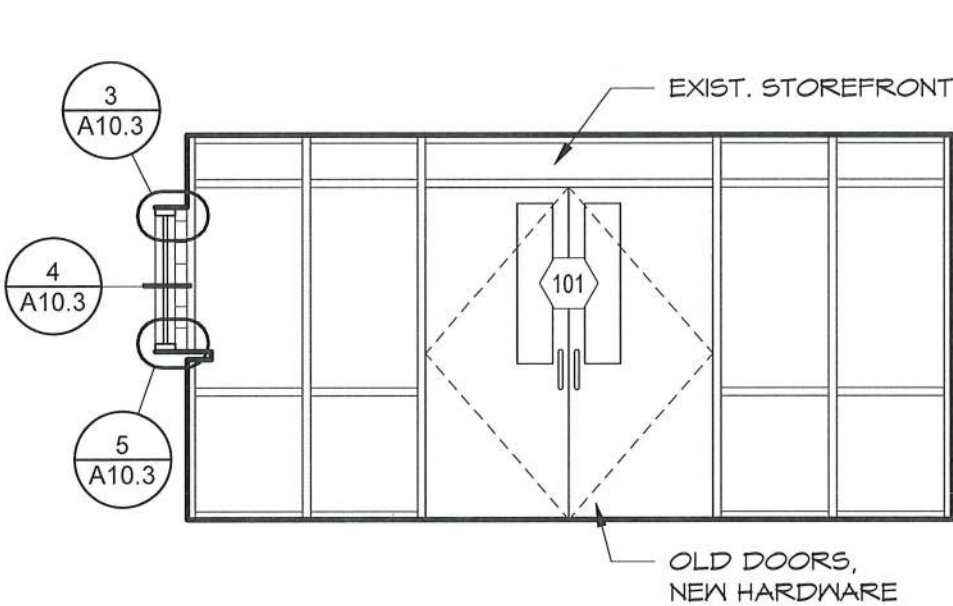


1 NW STOREFRONT ELEVATION
A10.3 1/4" = 1'-0"

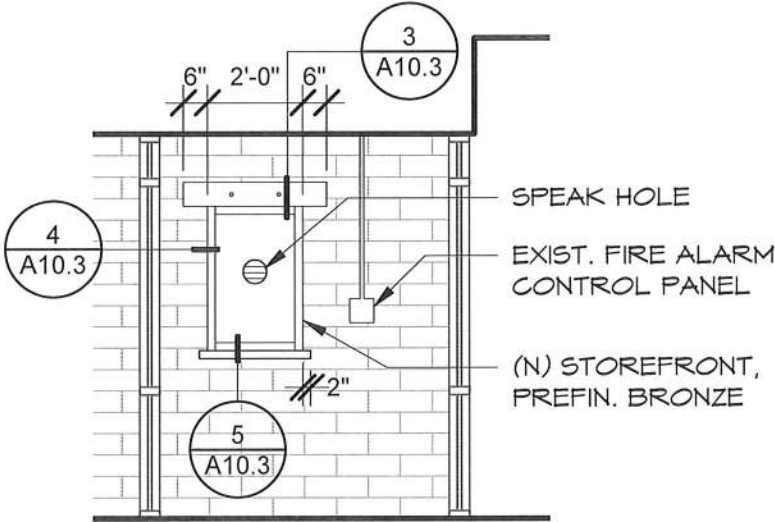


2 SW STOREFRONT
A10.3 1/4" = 1'-0"

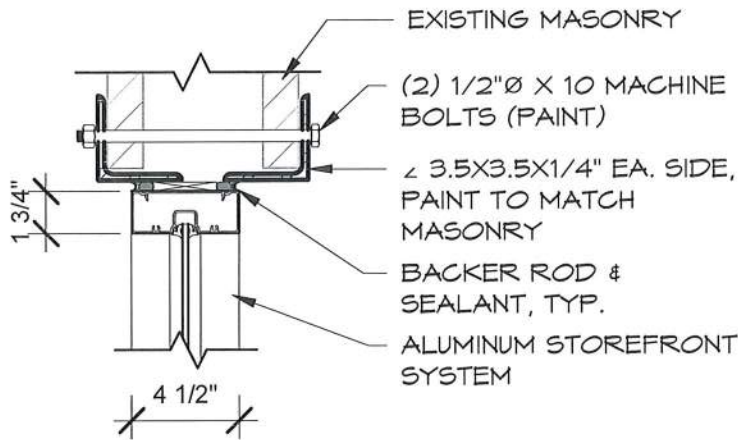

3 SF HEAD
A10.3 1 1/2" = 1'-0"

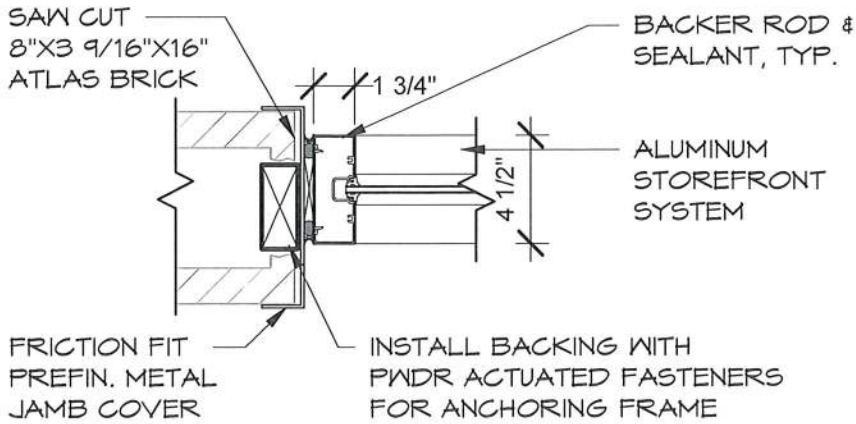

4 SF JAMB
A10.3 1 1/2" = 1'-0"

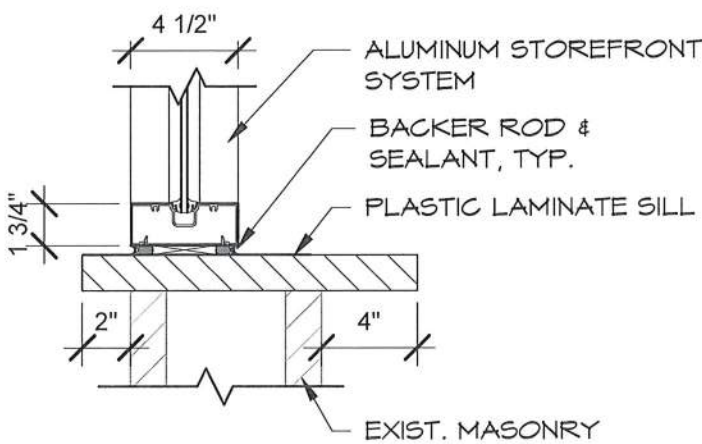

5 SF SILL
A10.3 1 1/2" = 1'-0"

4331
REGISTERED ARCHITECT
CRAIG M. COLLINS
STATE OF WASHINGTON

Scale
As indicated

Date
2/14/2022

Project #
2021-18

 
COLLINS
ARCHITECTURAL GROUP, P.S.
950 12th AVE., SUITE 200
LONGVIEW, WA 98632
PHONE: 360-425-0000

SCHEDULE, ELEVATIONS, & DETAILS
LONGVIEW SCHOOL DISTRICT
MINT VALLEY ELEMENTARY SCHOOL

A10.3



Kessler Elementary
School

1902 Kessler Blvd



NOTE: ROUTE NEW DATA CABLING FOR ACCESS CONTROL AND MONITORING TO IDF, ROUTE THROUGH CONCEALED SPACES WHERE POSSIBLE, USE WIREMOLD WHERE CABLING MUST BE EXPOSED. IT IS ASSUMED THAT 120V POWER IS AVAILABLE FROM AN ELECTRICAL PANEL WITHIN 50 FEET OF THE POINT OF USE. ANY CONDUIT/WIRING BEYOND 50FT WILL BE PROCESSED AS A CHANGE ORDER.

Auditorium Basement

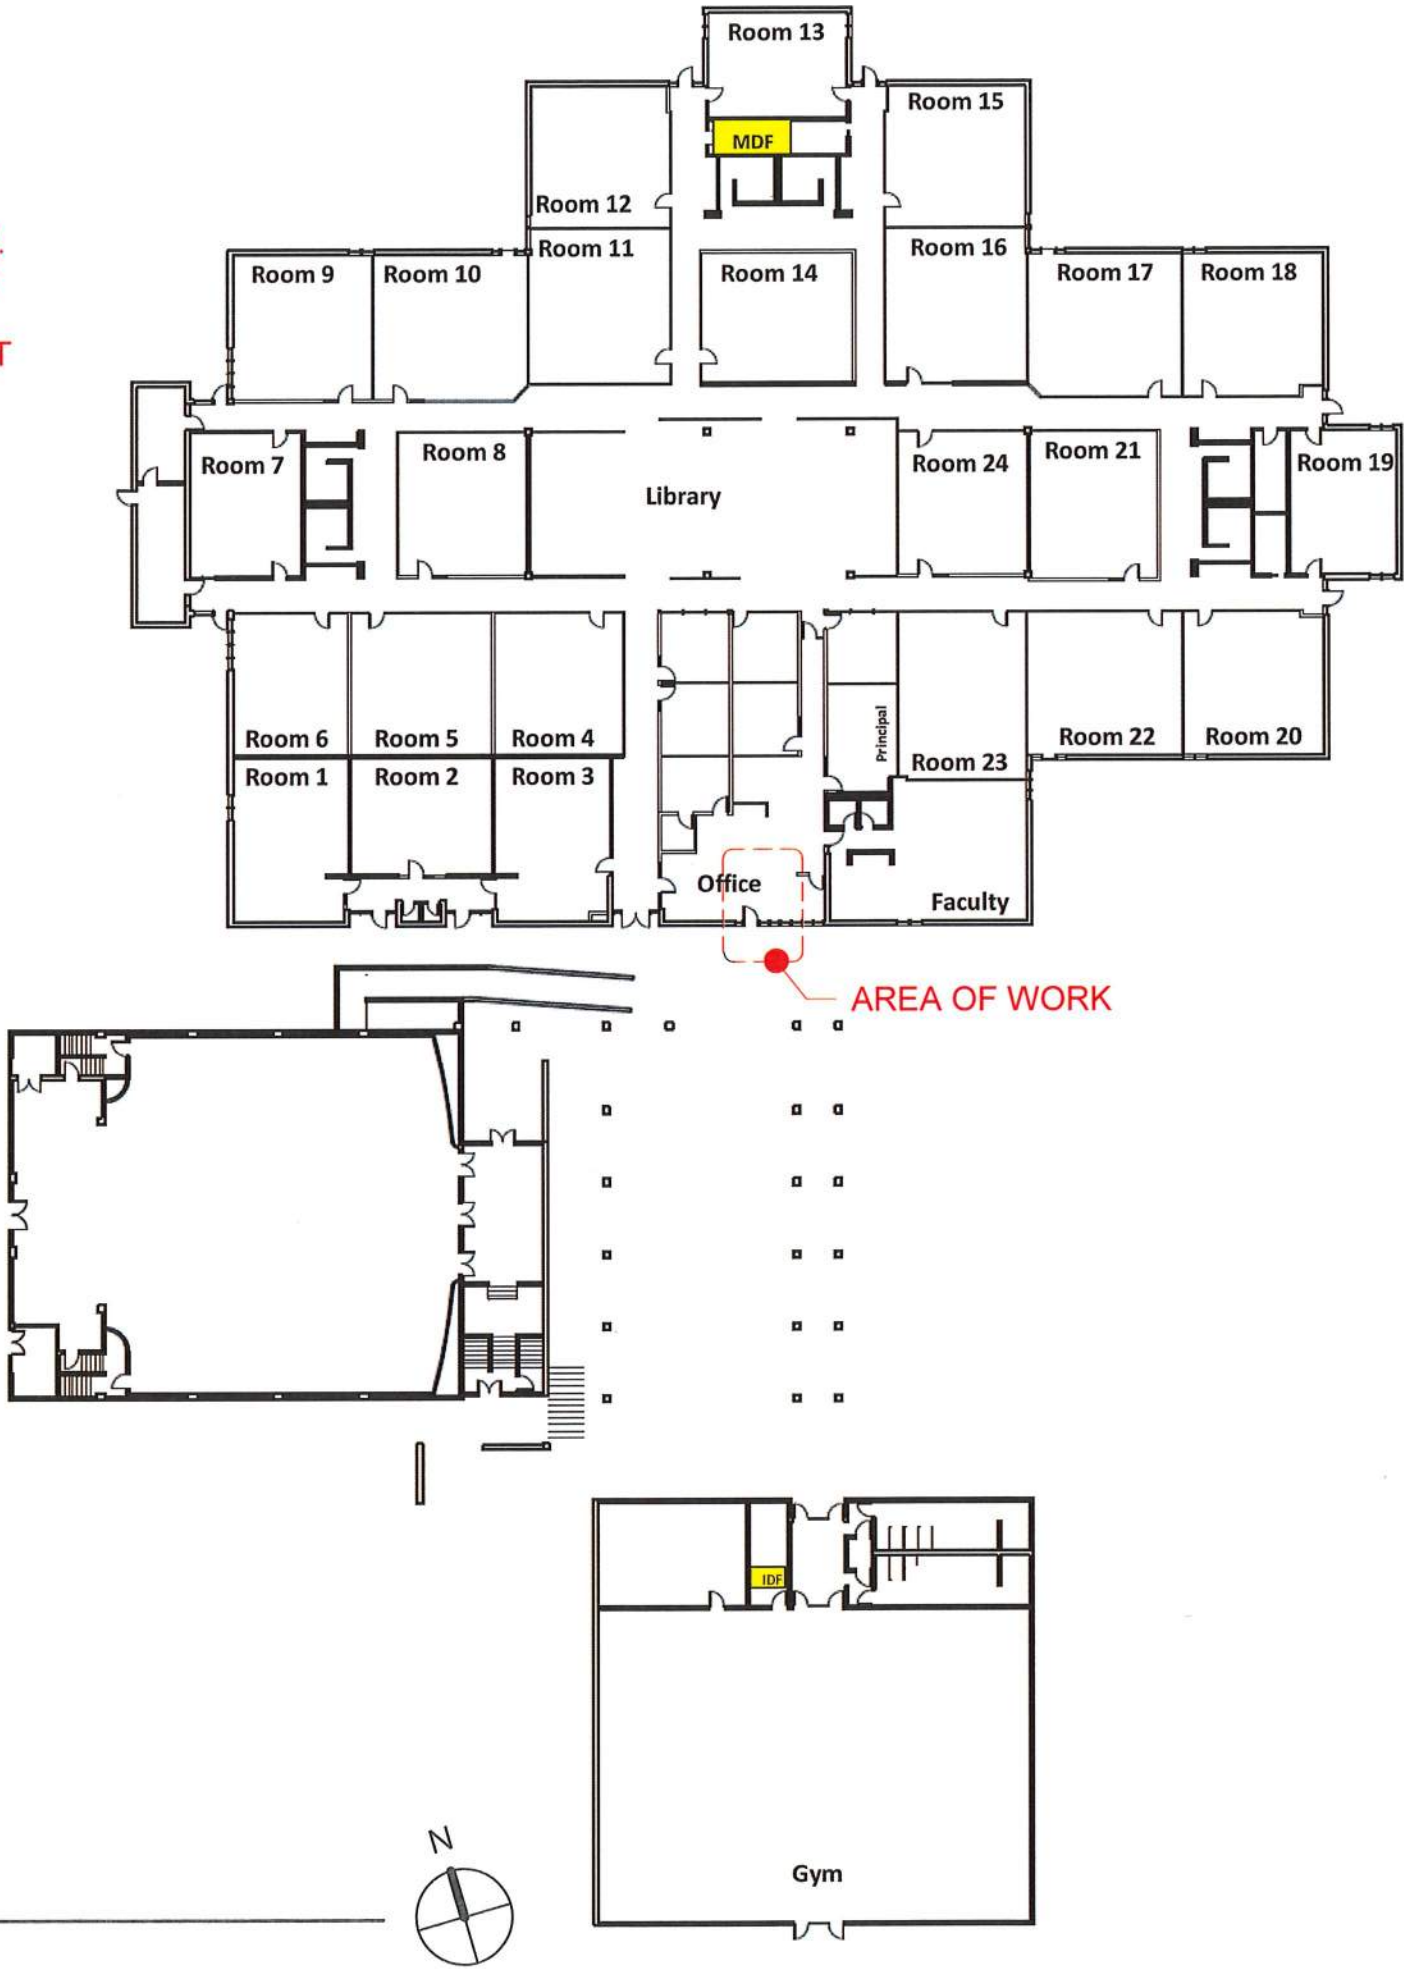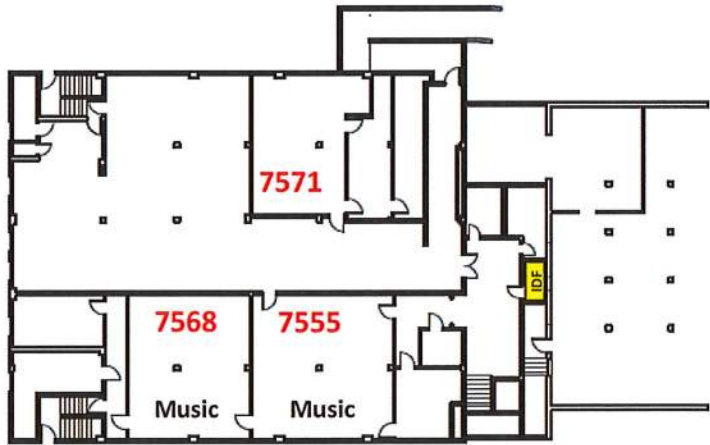

A

OVERALL PLAN

A11.1 1" = 40'-0"

4331

REGISTERED ARCHITECT

CRAIG M. COLLINS
STATE OF WASHINGTON

Scale
1" = 40'-0"

Date
2/14/2022

Project #
2021-18

COLLINS

ARCHITECTURAL GROUP, P.S.


950 12th AVE., SUITE 200
LONGVIEW, WA 98632
PHONE: 360-425-0000

OVERALL PLAN


LONGVIEW SCHOOL DISTRICT

KESSLER ELEMENTARY SCHOOL

A11.1

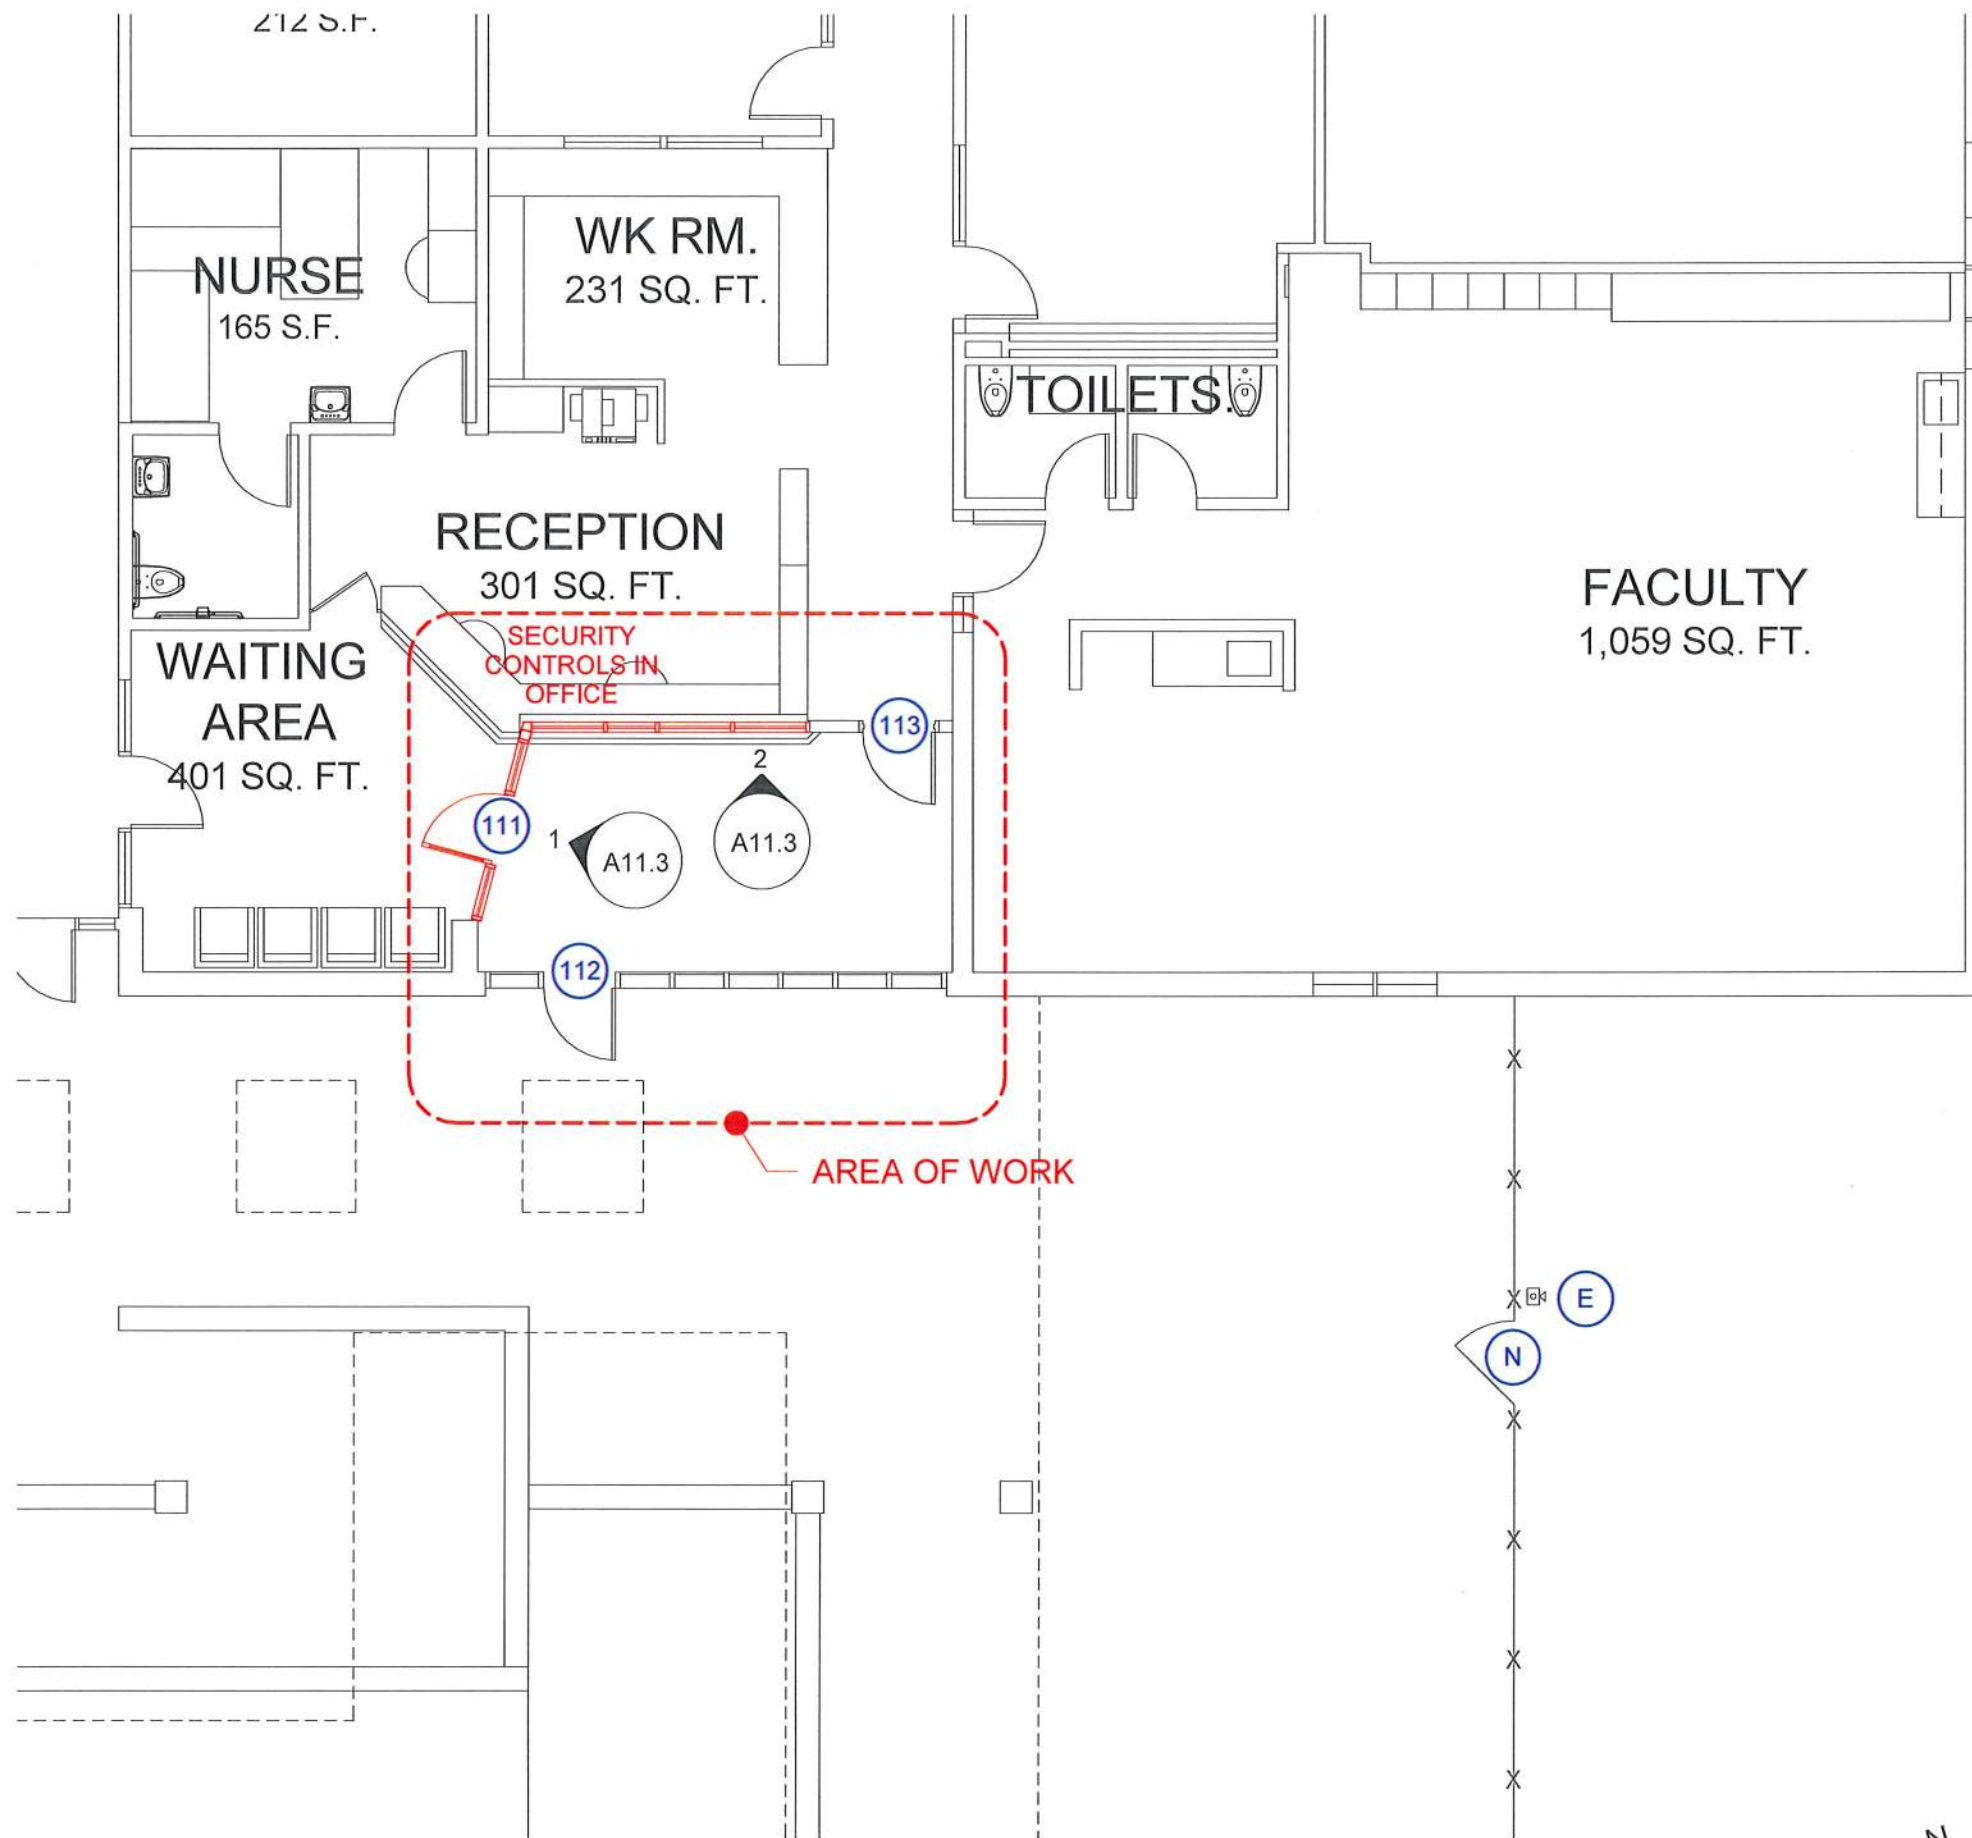

- 111 NEW DOOR WITH SECURITY CONTROL AND SIDELITES. LOCKED FROM VESTIBULE SIDE. UNLOCK VIA CONTROL IN OFFICE. FREE EXIT FROM INTERIOR.
- 112 EXISTING DOOR(S) TO BE RETROFITTED FOR SECURITY CONTROL. LOCKED FROM EXTERIOR. UNLOCK VIA CONTROL IN OFFICE. FREE EXIT FROM INTERIOR.
- 113 SAME AS DOOR 112
- E EXISTING INTERCOM/CAMERA WITH COMMUNICATION TO OFFICE
- N EXISTING SECURE GATE. LOCKED FROM EXTERIOR. UNLOCK VIA CONTROL IN OFFICE. EXISTING INTERCOM/CAMERA WITH COMMUNICATION TO OFFICE. FREE EXIT FROM INTERIOR.

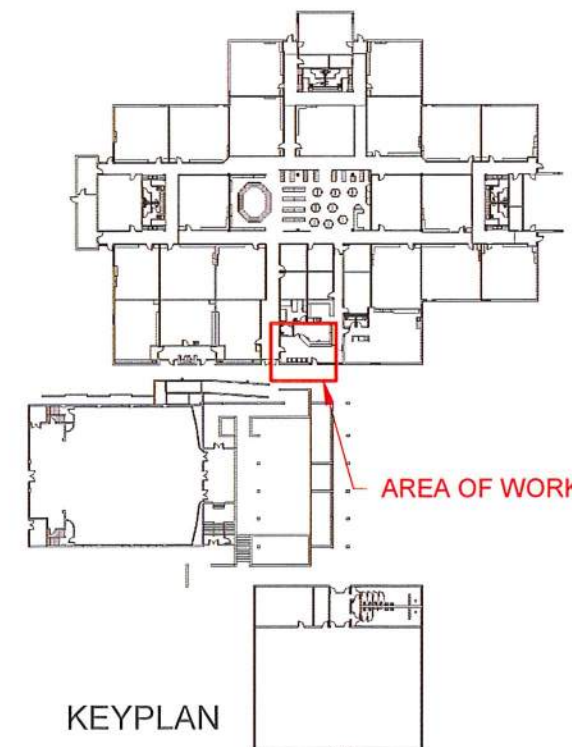

A FLOOR PLAN
A11.2 1/8" = 1'-0"



4331
REGISTERED ARCHITECT
Craig M. Collins
CRAIG M. COLLINS
STATE OF WASHINGTON

Scale 1/8" = 1'-0"	Date 2/14/2022	Project # 2021-18
-----------------------	-------------------	----------------------

COLLINS
ARCHITECTURAL GROUP, P.S.
950 12th AVE., SUITE 200
LONGVIEW, WA 98632
PHONE: 360-425-0000

VESTIBULE SECURITY PLAN

LONGVIEW SCHOOL DISTRICT
KESSLER ELEMENTARY SCHOOL

A11.2


DOOR SCHEDULE

DOOR NO.	SIZE WxHxT	DOOR					FRAME			HARDWARE GROUP	REMARKS
		GLAZING	TYPE	MAT	FINISH	LABEL	TYPE	MAT	FIN		
111	3'-0"x7'-0"x1 3/4"	TEMP	1/A11.3	ALUM	-	-	1/A11.3	ALUM	-	17	1
112	3'-0"x7'-0"x1 3/4"	temp	exist.	alum	-	-	exist.	-	-	11	1, 2
113	3'-0"x7'-0"x1 3/4"	-	exist.	exist.	-	-	exist.	-	-	15	1

UPPERCASE = NEW MATERIAL lowercase = existing material


REMARKS:

1. DOOR HAS ELECTRONIC ACCESS CONTROL OR MONITORING
2. POWER SUPPLY REQUIRES 120V AC

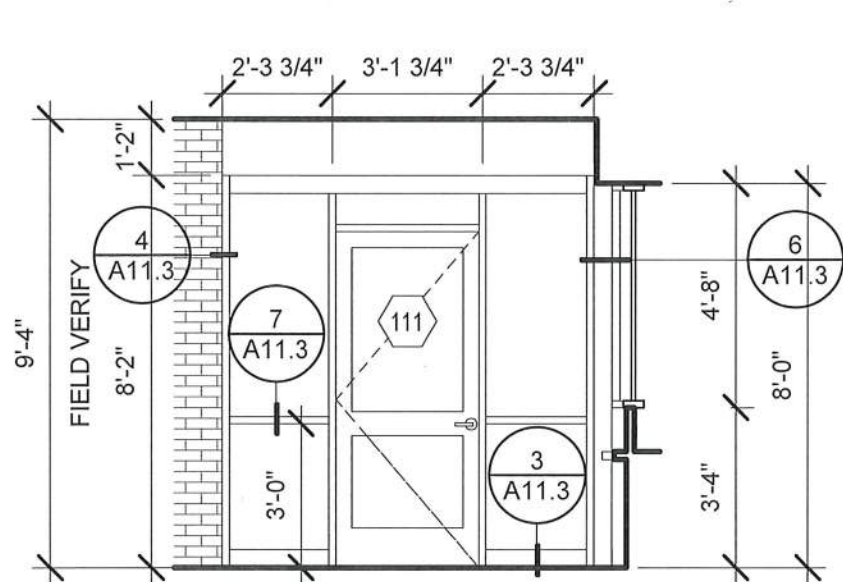


1 STOREFRONT WEST ELEVATION

A11.3 1/4" = 1'-0"

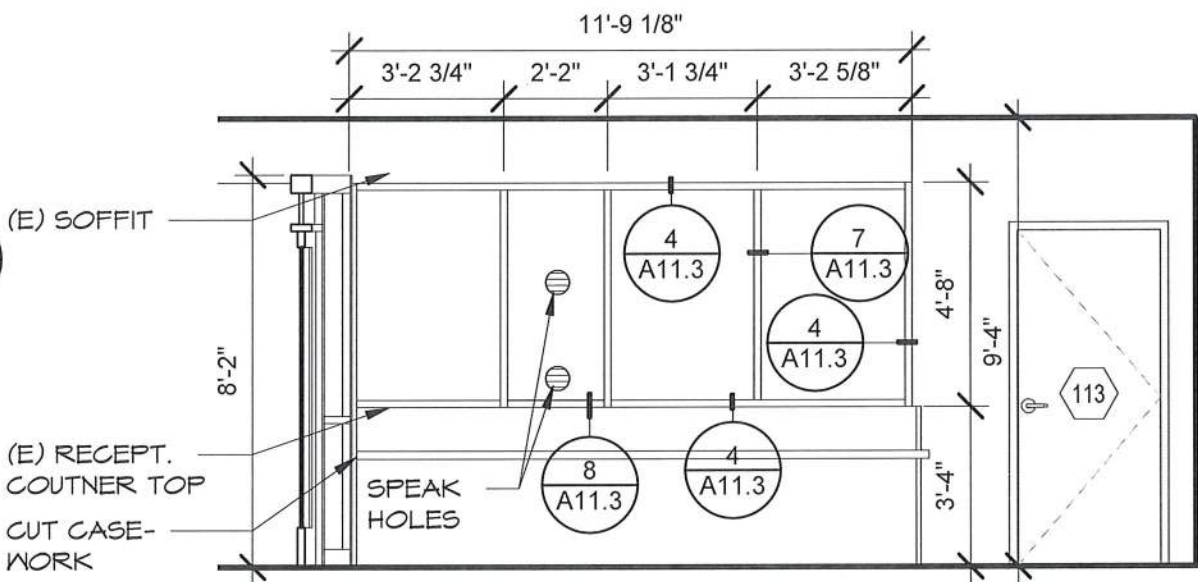


2 STOREFRONT NORTH ELEVATION

A11.3 1/4" = 1'-0"

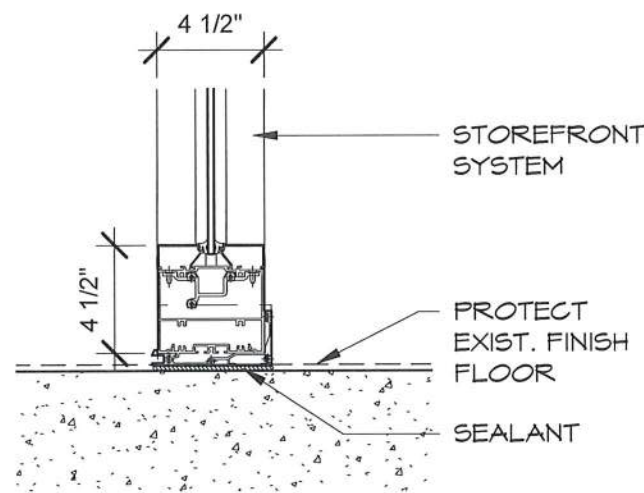


3 STOREFRONT SILL

A11.3 1 1/2" = 1'-0"

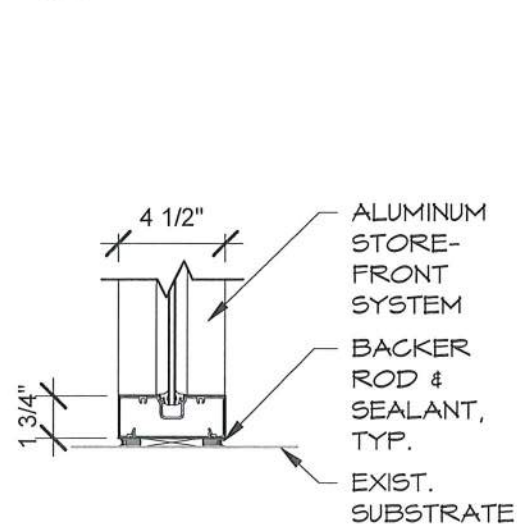


4 SF JAMB

A11.3 1 1/2" = 1'-0"

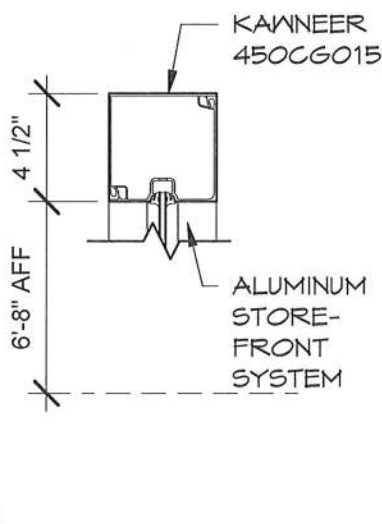


5 SF HEAD

A11.3 1 1/2" = 1'-0"

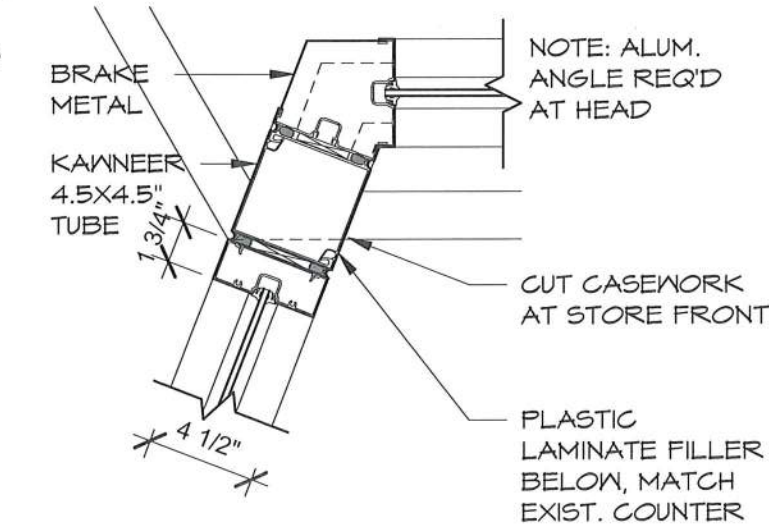


6 SF VARIABLE CORNER

A11.3 1 1/2" = 1'-0"

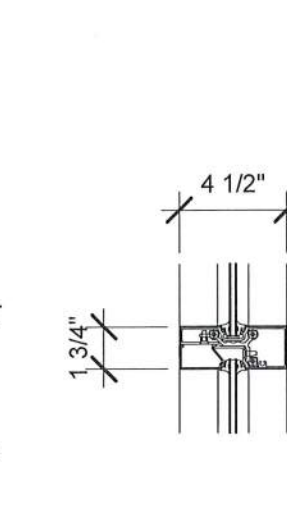

7 SF MULLION

A11.3 1 1/2" = 1'-0"

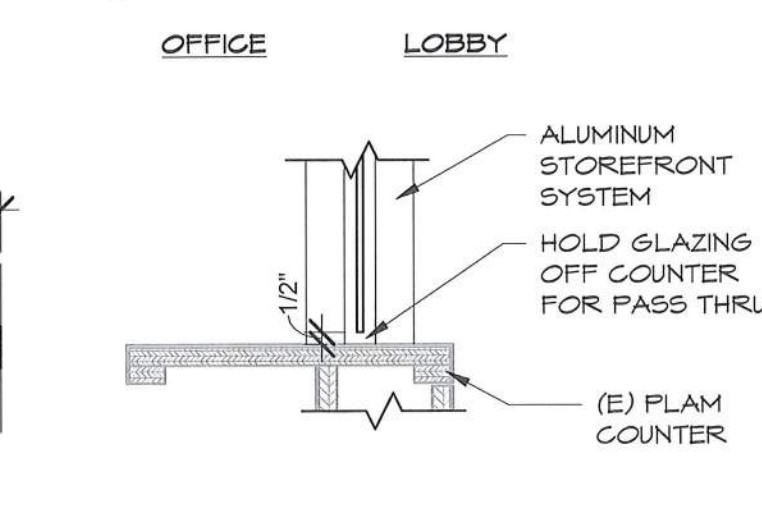

8 PASS THRU SILL

A11.3 1 1/2" = 1'-0"



Scale As indicated
Date 2/14/2022
Project # 2021-18


COLLINS
ARCHITECTURAL GROUP, P.S.
950 12th AVE., SUITE 200
LONGVIEW, WA 98632
PHONE: 360-425-0000

SCHEDULE, ELEVATIONS, & DETAILS

LONGVIEW SCHOOL DISTRICT


KESSLER ELEMENTARY SCHOOL

A11.3

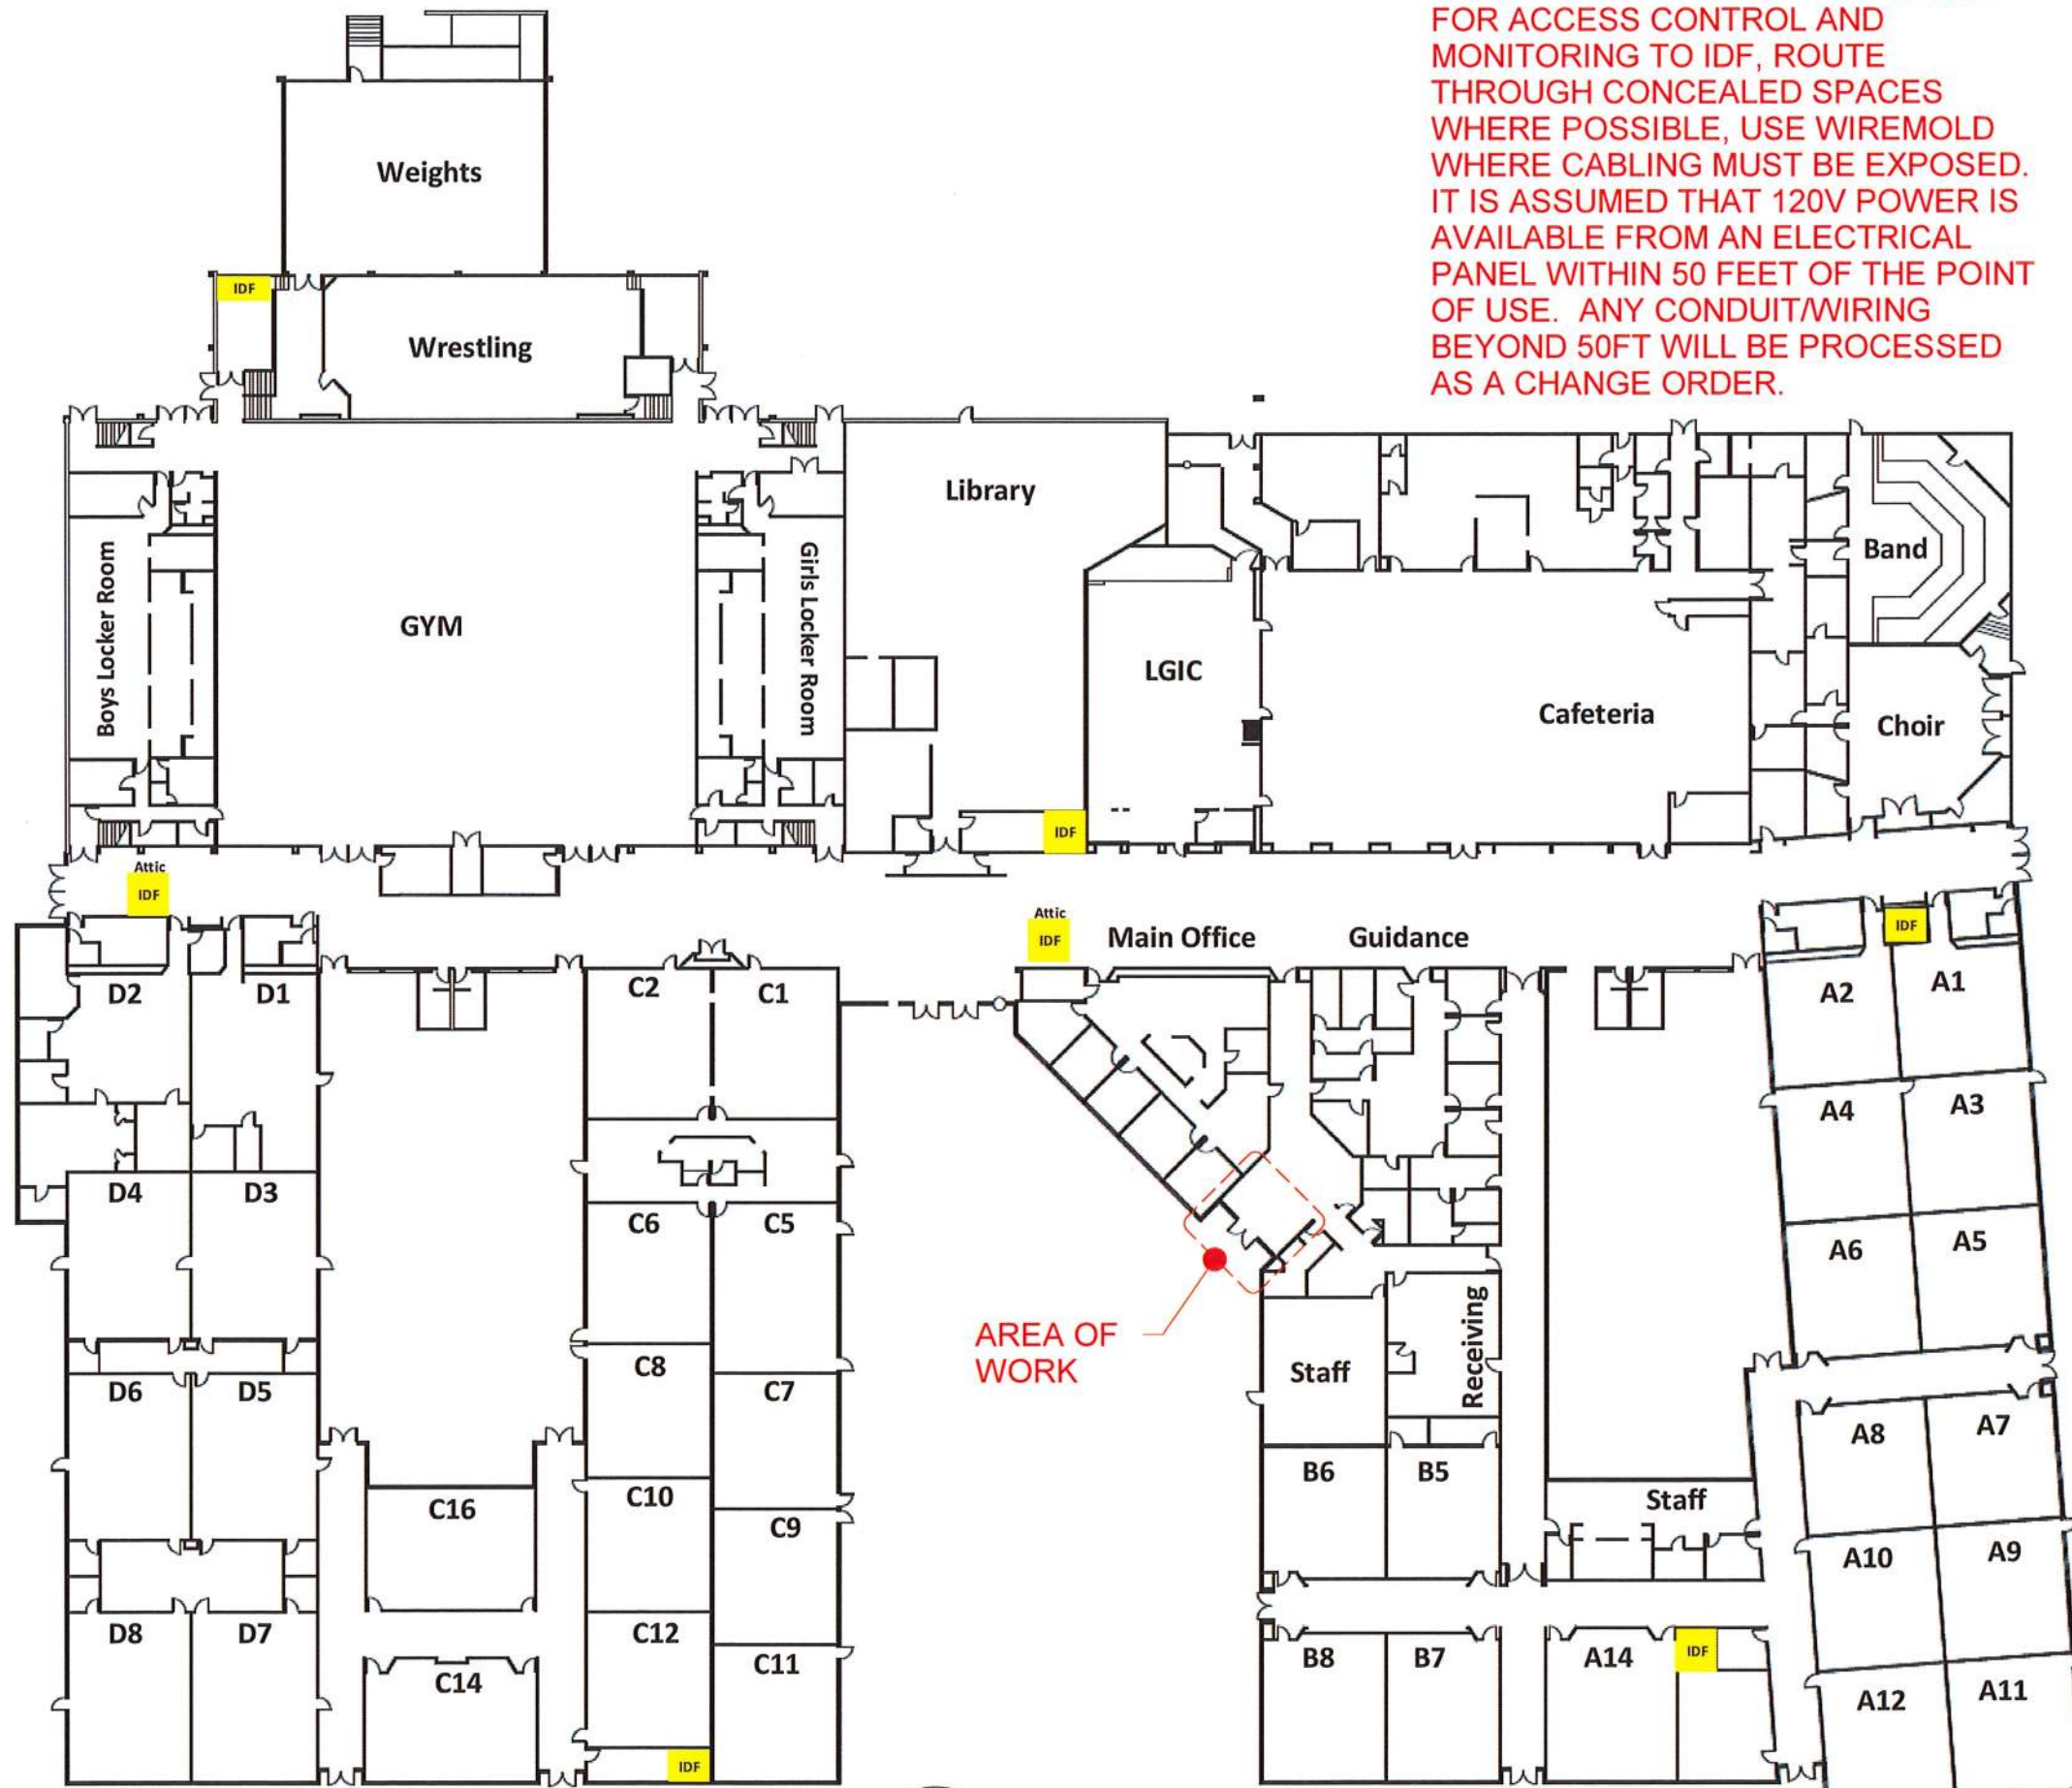

NOTE: ROUTE NEW DATA CABLING FOR ACCESS CONTROL AND MONITORING TO IDF, ROUTE THROUGH CONCEALED SPACES WHERE POSSIBLE, USE WIREMOLD WHERE CABLING MUST BE EXPOSED. IT IS ASSUMED THAT 120V POWER IS AVAILABLE FROM AN ELECTRICAL PANEL WITHIN 50 FEET OF THE POINT OF USE. ANY CONDUIT/WIRING BEYOND 50FT WILL BE PROCESSED AS A CHANGE ORDER.

 **Mark Morris
High School
1602 Mark Morris Ct**



4331
REGISTERED ARCHITECT
Craig M. Collins
CRAIG M. COLLINS
STATE OF WASHINGTON

Scale 1" = 40'-0"	Date 2/14/2022	Project # 2021-18
----------------------	-------------------	----------------------

COLLINS
ARCHITECTURAL GROUP, P.S.
950 12th AVE., SUITE 200
LONGVIEW, WA 98632
PHONE: 360-425-0000


LONGVIEW SCHOOL DISTRICT
MARK MORRIS HIGH SCHOOL

OVERALL PLAN

A12.1

A OVERALL PLAN
A12.1 1" = 40'-0"



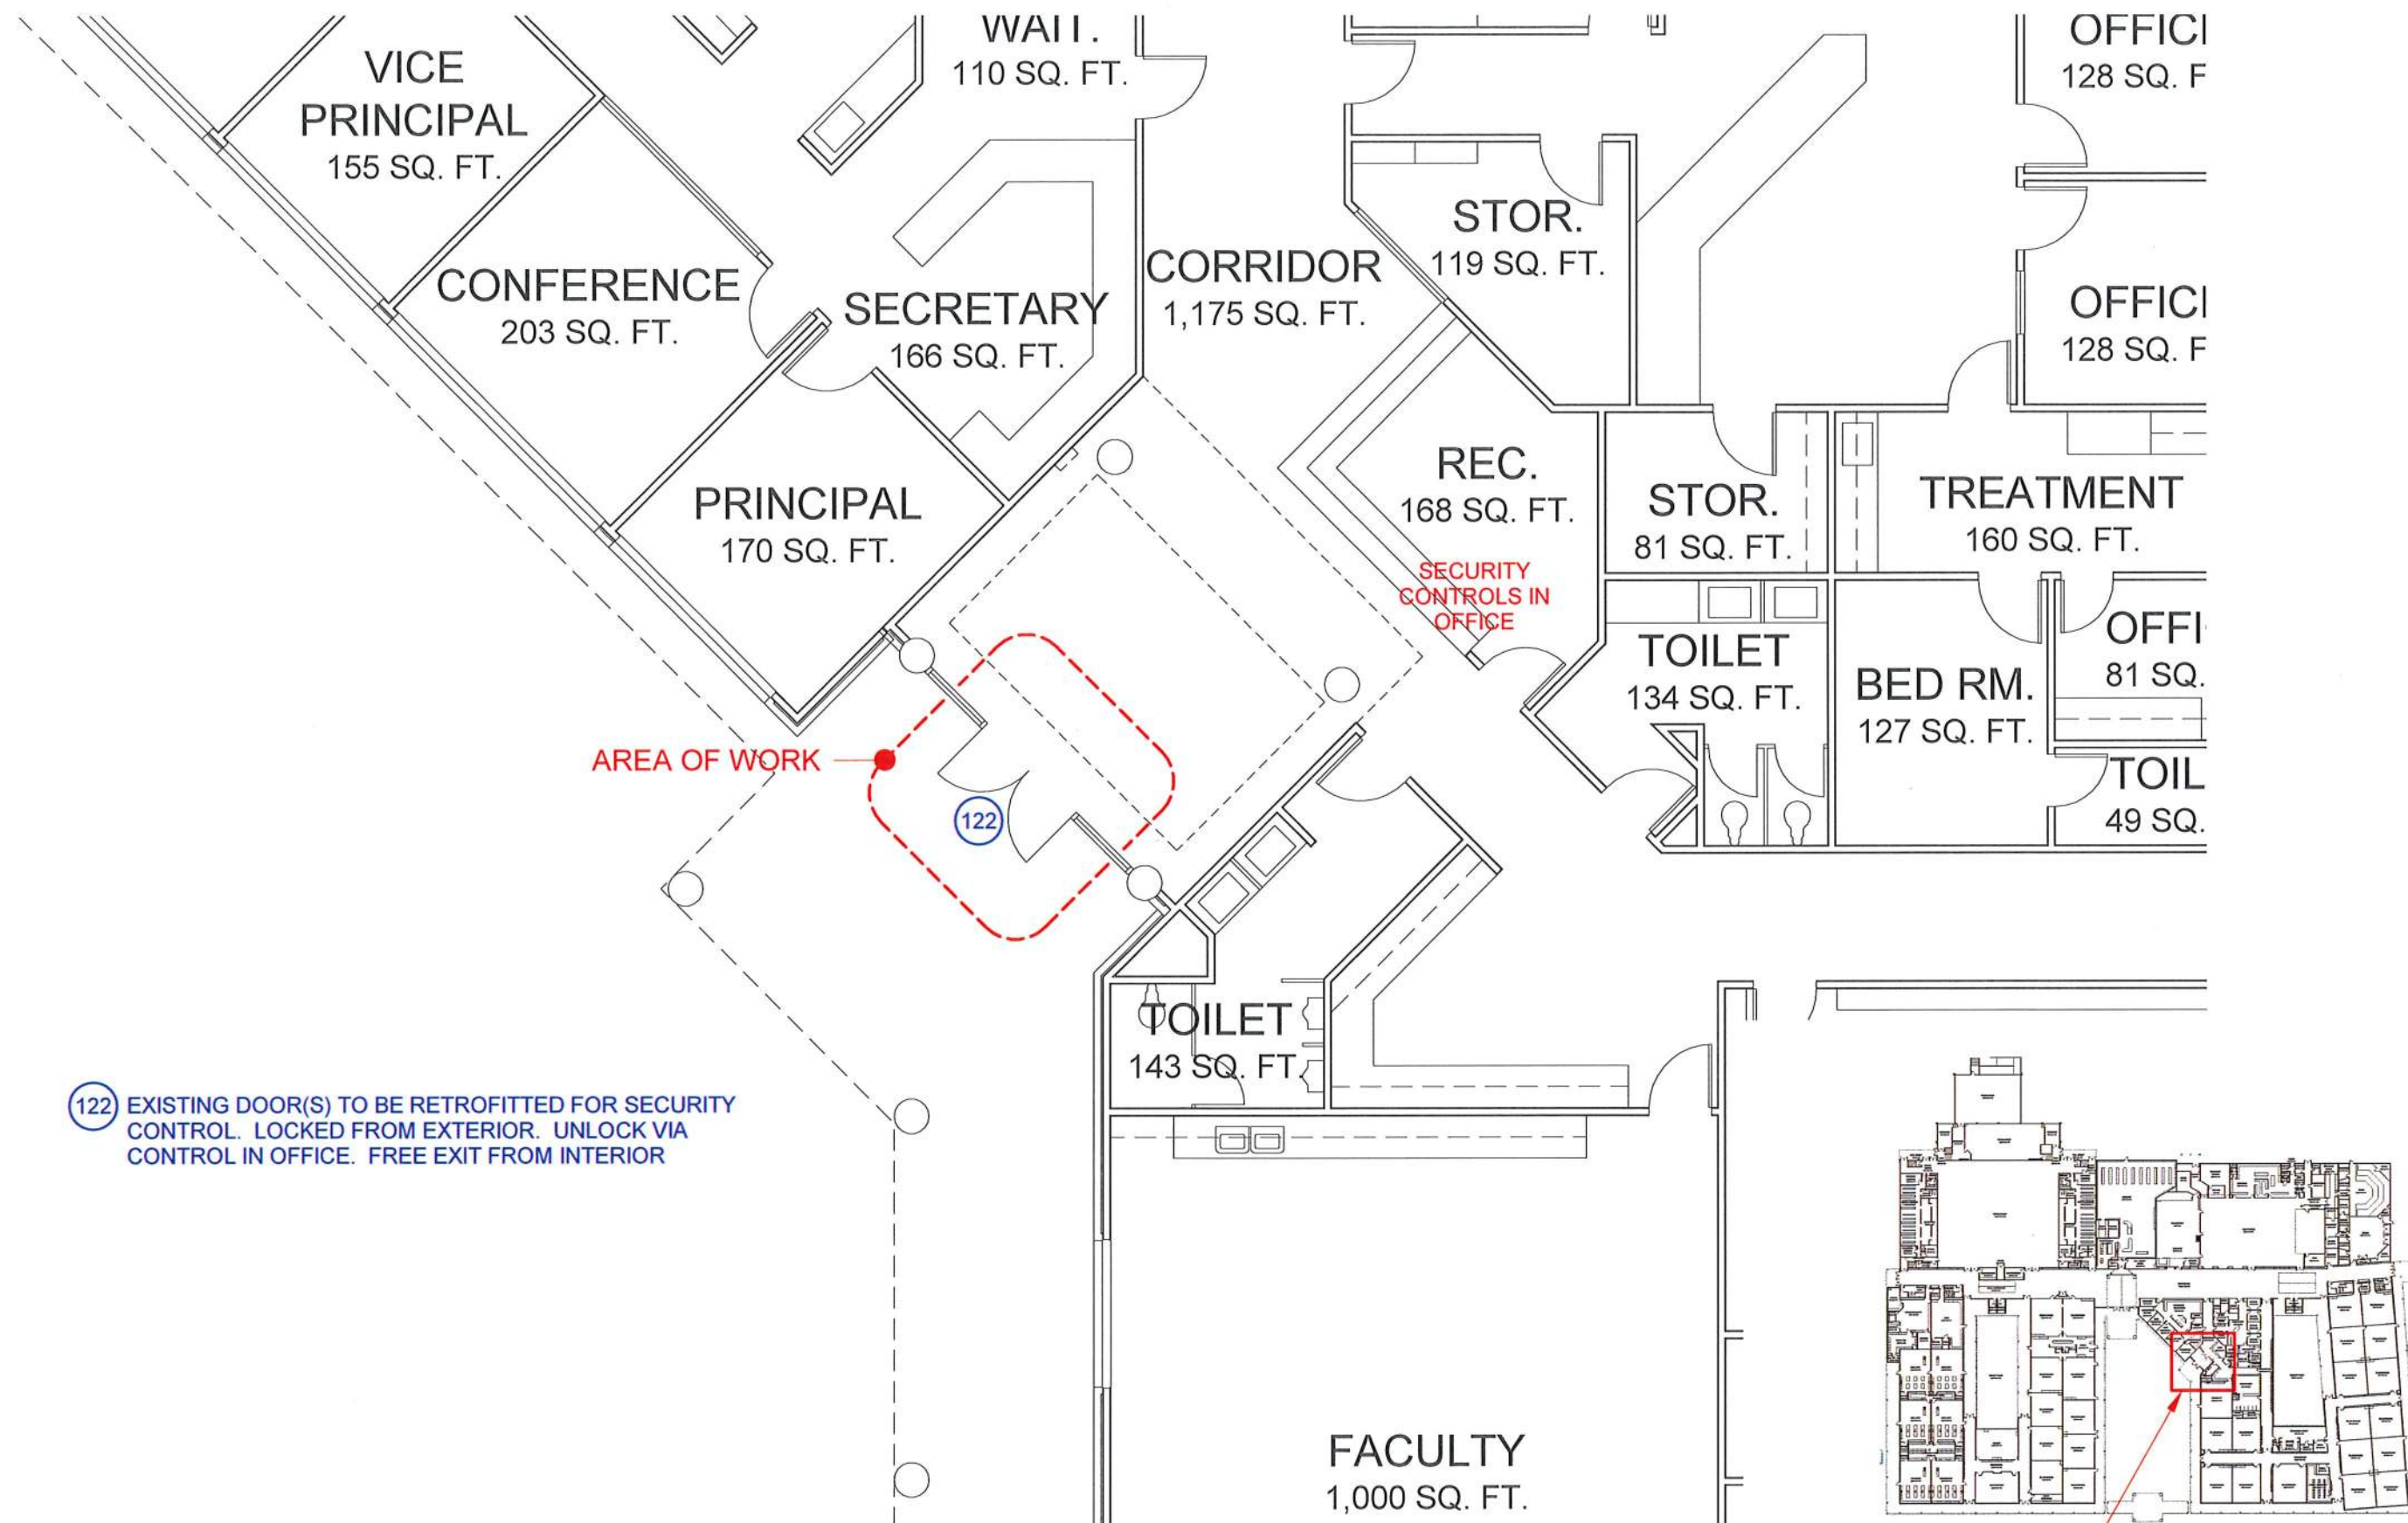

A FLOOR PLAN
A12.2 1/8" = 1'-0"

4331 REGISTERED ARCHITECT CRAIG M. COLLINS STATE OF WASHINGTON		
Scale 1/8" = 1'-0"	Date 2/14/2022	Project # 2021-18
COLLINS ARCHITECTURAL GROUP, P.S. 950 12th AVE., SUITE 200 LONGVIEW, WA 98632 PHONE: 360-425-0000		
VESTIBULE SECURITY PLAN LONGVIEW SCHOOL DISTRICT MARK MORRIS HIGH SCHOOL		
A12.2		

DOOR SCHEDULE											
DOOR NO.	SIZE WxHxT	DOOR					FRAME			HARDWARE GROUP	REMARKS
		GLAZING	TYPE	MAT	FINISH	LABEL	TYPE	MAT	FIN		
122	PR 6'-0"x7'-0"x1 3/4"	temp	exist.	alum	paint	-	exist.	alum	paint	09	1, 2

UPPERCASE = NEW MATERIAL lowercase = existing material

REMARKS:
1. DOOR HAS ELECTRONIC ACCESS CONTROL OR MONITORING.
2. POWER SUPPLY REQUIRES 120V AC

4331

REGISTERED ARCHITECT

CRAIG M. COLLINS
STATE OF WASHINGTON

Scale

Date
2/14/2022

Project #
2021-18




COLLINS
ARCHITECTURAL GROUP, P.S.
950 12th AVE., SUITE 200
LONGVIEW, WA 98632
PHONE: 360-425-0000

LONGVIEW SCHOOL DISTRICT

MARK MORRIS HIGH SCHOOL


A12.3

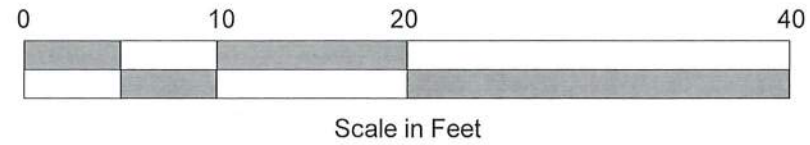

NOTE: ROUTE NEW DATA CABLING FOR ACCESS CONTROL AND MONITORING TO IDF, ROUTE THROUGH CONCEALED SPACES WHERE POSSIBLE, USE WIREMOLD WHERE CABLING MUST BE EXPOSED. IT IS ASSUMED THAT 120V POWER IS AVAILABLE FROM AN ELECTRICAL PANEL WITHIN 50 FEET OF THE POINT OF USE. ANY CONDUIT/WIRING BEYOND 50FT WILL BE PROCESSED AS A CHANGE ORDER.

Discovery High School
2742 Harding st

AREA OF WORK

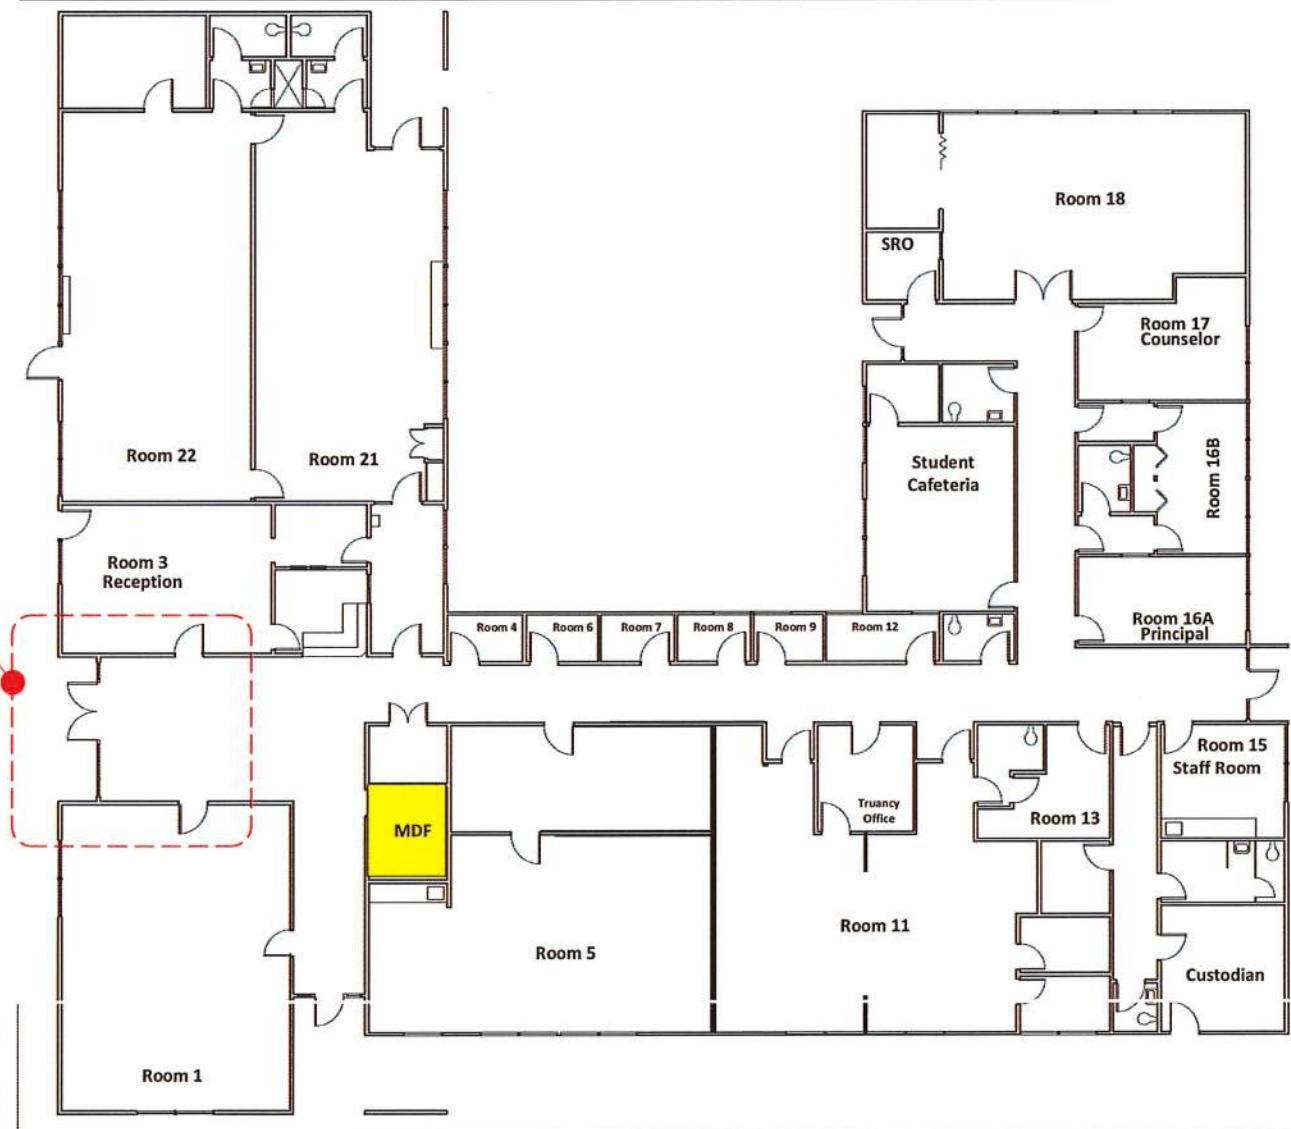

A OVERALL PLAN
A14.1 1" = 20'-0"



4331
REGISTERED ARCHITECT
CRAIG M. COLLINS
STATE OF WASHINGTON

Scale 1" = 20'-0"	Date 2/14/2022	Project # 2021-18
----------------------	-------------------	----------------------


COLLINS
ARCHITECTURAL GROUP, P.S.
950 12th AVE., SUITE 200
LONGVIEW, WA 98632
PHONE: 360-425-0000

OVERALL PLAN


LONGVIEW SCHOOL DISTRICT

DISCOVERY HIGH SCHOOL

A14.1

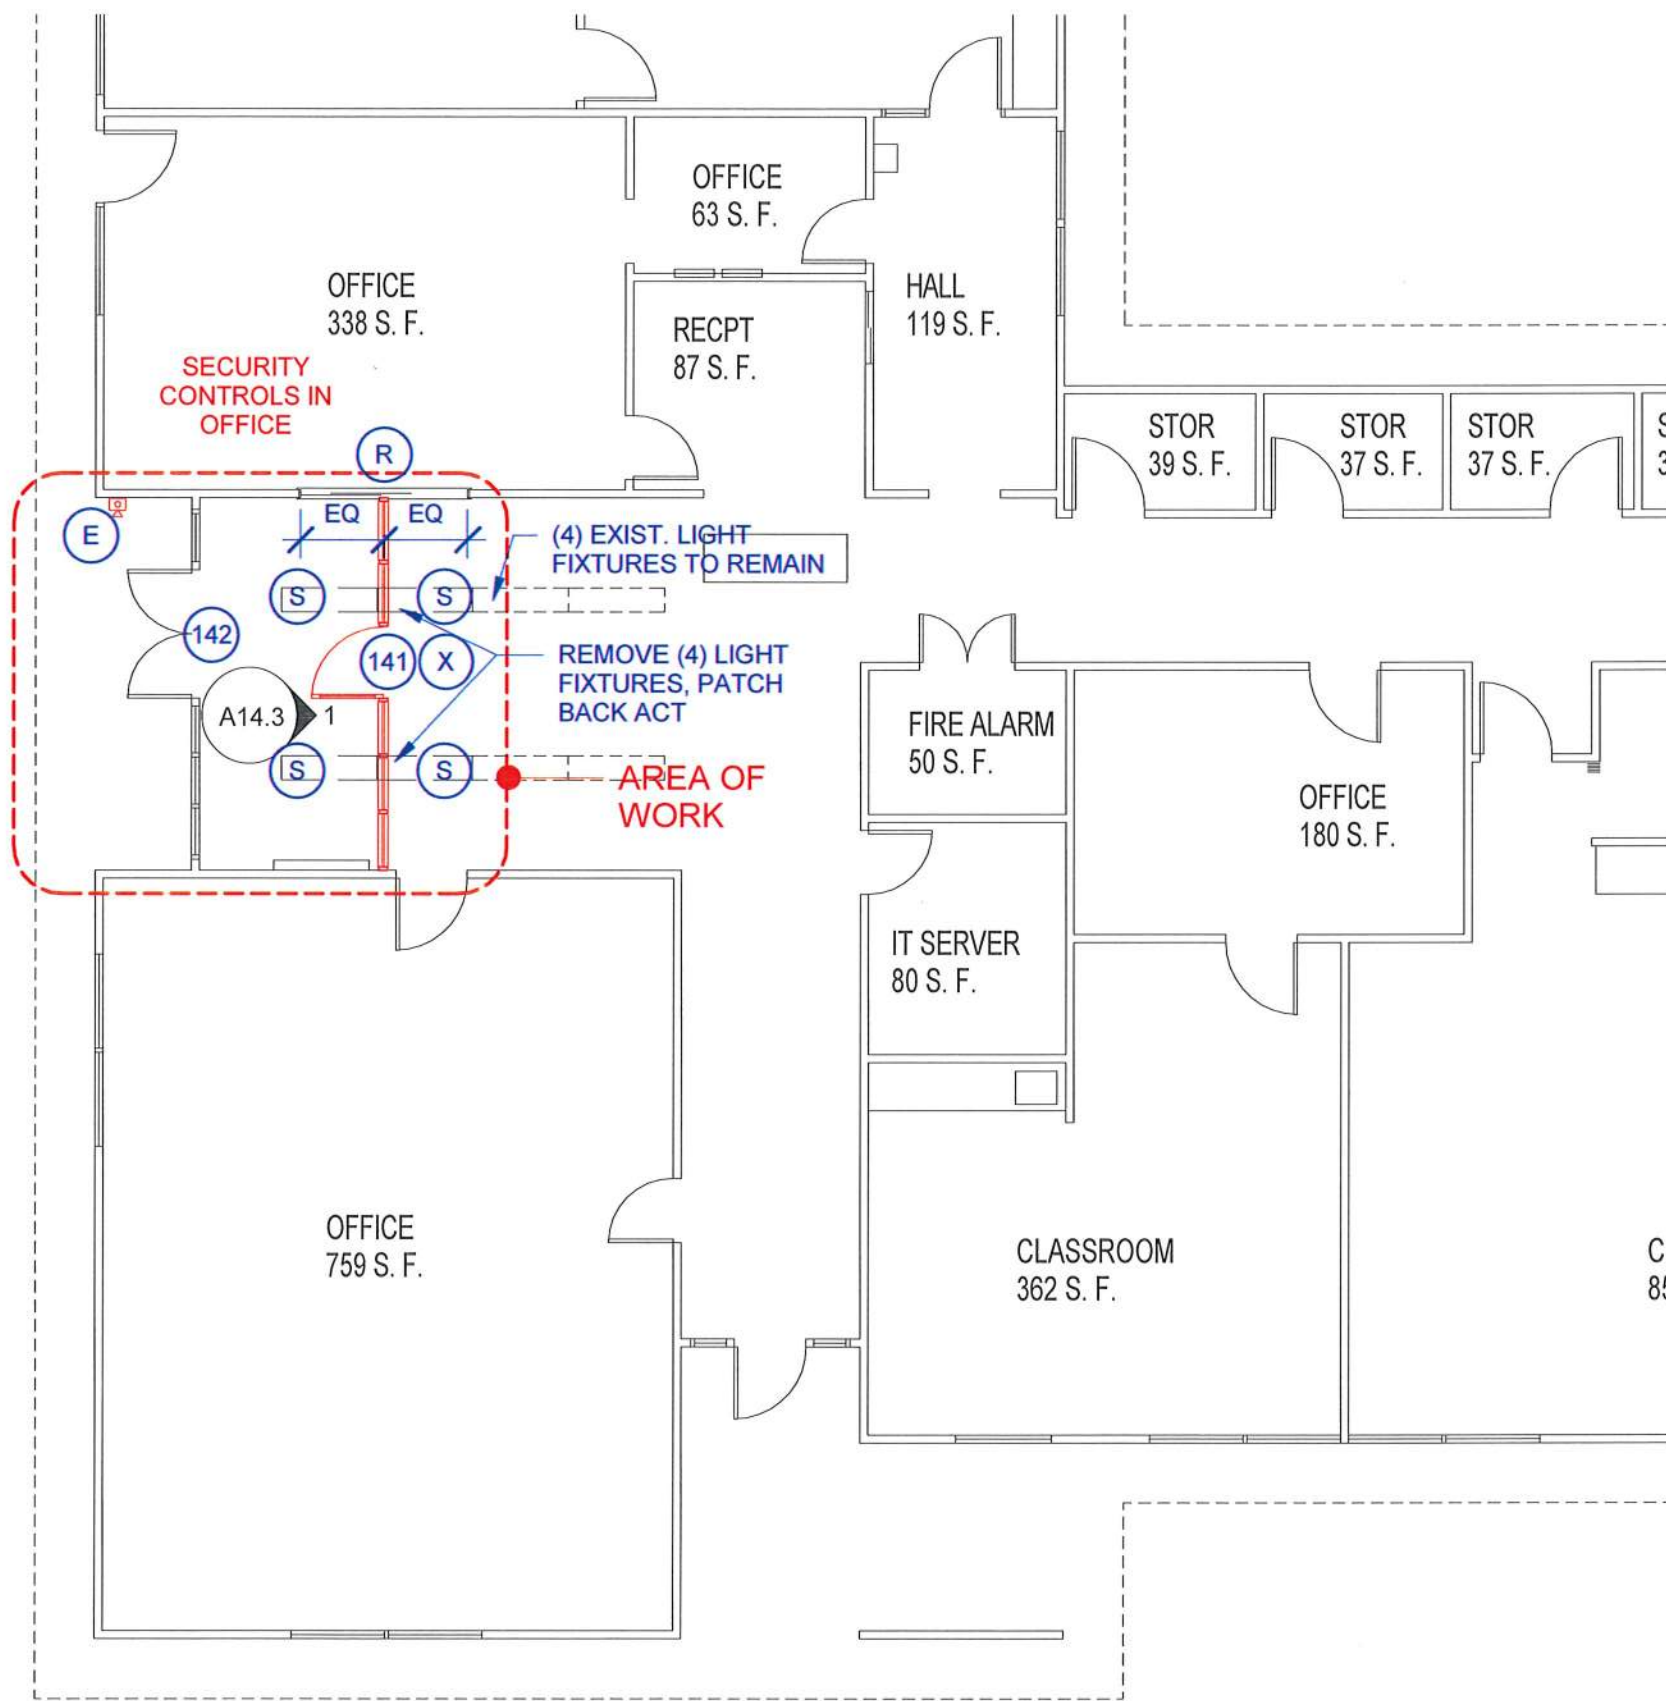

- (141) NEW DOOR WITH SECURITY CONTROL AND SIDELITES. LOCKED FROM VESTIBULE SIDE. UNLOCK VIA CONTROL IN OFFICE. FREE EXIT FROM INTERIOR.
- (142) EXISTING DOOR(S) TO BE RETROFITTED FOR SECURITY CONTROL. LOCKED FROM EXTERIOR. UNLOCK VIA CONTROL IN OFFICE. FREE EXIT FROM INTERIOR.
- (E) INTERCOM/CAMERA WITH COMMUNICATION TO OFFICE
- (R) NEW SECURE WINDOW WITH SPEAK HOLE AND DOCUMENT PASS-THROUGH
- (S) NEW OVERHEAD CAN LIGHTING, USE LITHONIA LDN6 CYLINDER
- (X) RELOCATE CEILING MOUNTED EXIT SIGN (ILLUMINATED WITH BATTERY BACKUP)

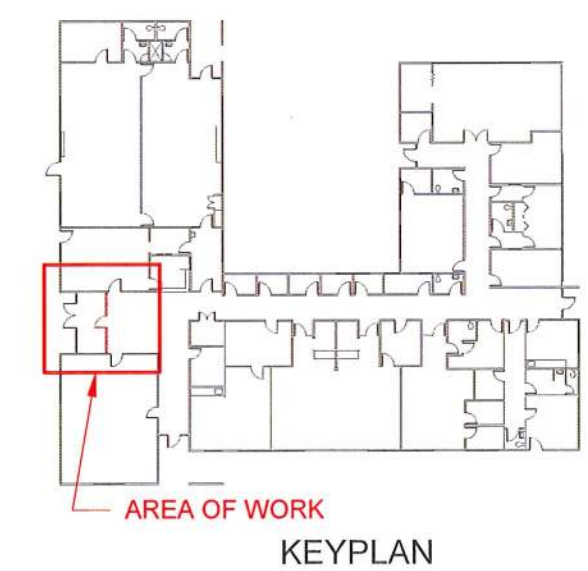

A FLOOR PLAN
A14.2 1/8" = 1'-0"



4331

REGISTERED ARCHITECT

CRAIG M. COLLINS
STATE OF WASHINGTON

Scale
1/8" = 1'-0"

Date
2/14/2022

Project #
2021-18

ACOLLINS
ARCHITECTURAL GROUP, P.S.

950 12th AVE., SUITE 200
LONGVIEW, WA 98632
PHONE: 360-425-0000

VESTIBULE SECURITY PLAN

LONGVIEW SCHOOL DISTRICT

DISCOVERY HIGH SCHOOL


A14.2

DOOR SCHEDULE


DOOR NO.	SIZE WxHxT	DOOR					FRAME			HARDWARE GROUP	REMARKS
		GLAZING	TYPE	MAT	FINISH	LABEL	TYPE	MAT	FIN		
141	3'-0"x6'-8"x1 3/4"	TEMP	1/A14.3	ALUM	-	-	1/A14.3	ALUM	-	18	1, 2
142	PR. 2'-8"x7'-0"x1 3/4"	temp	exist.	hm	paint	-	exist.	wd	paint	09	1, 2

UPPERCASE = NEW MATERIAL lowercase = existing material


REMARKS:
1. DOOR HAS ELECTRONIC ACCESS CONTROL OR MONITORING
2. POWER SUPPLY REQUIRES 120V AC

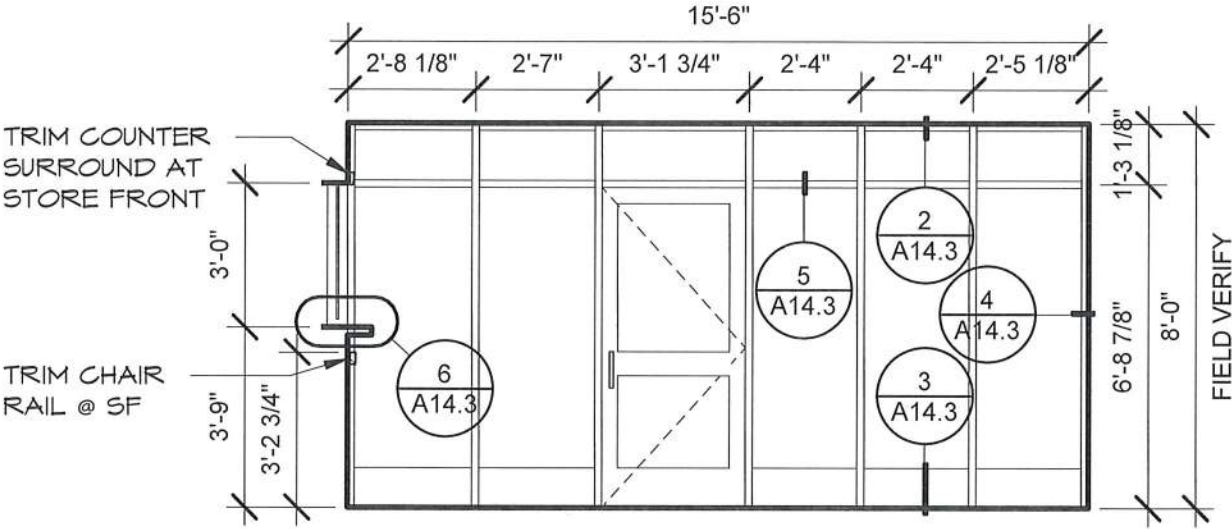


1 STOREFRONT EAST ELEVATION
A14.3 1/4" = 1'-0"

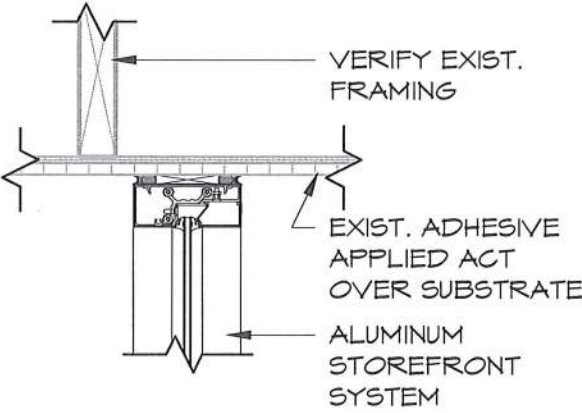


2 STOREFRONT HEAD
A14.3 1 1/2" = 1'-0"

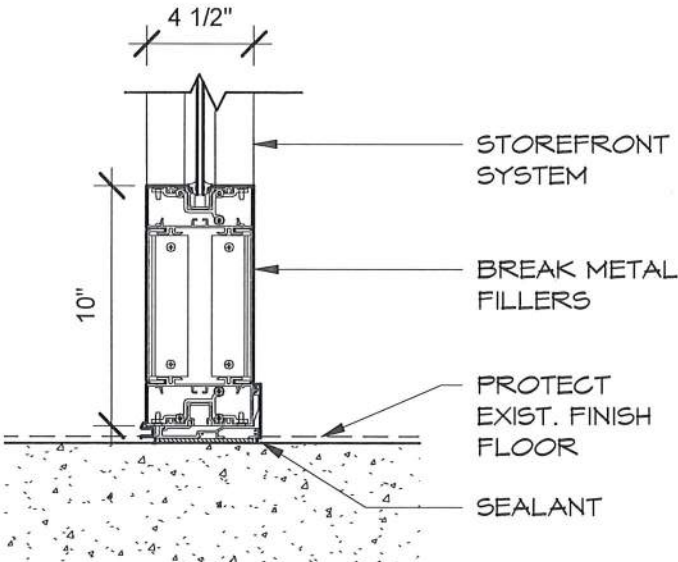


3 STOREFRONT SILL
A14.3 1 1/2" = 1'-0"

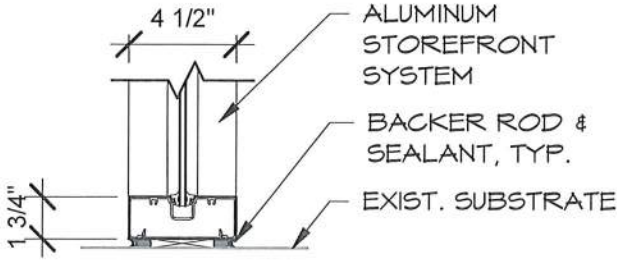

4 STOREFRONT JAMB
A14.3 1 1/2" = 1'-0"

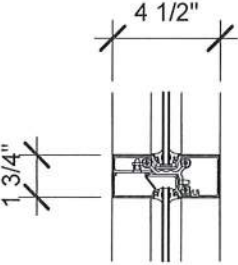

5 SF MULLION
A14.3 1 1/2" = 1'-0"

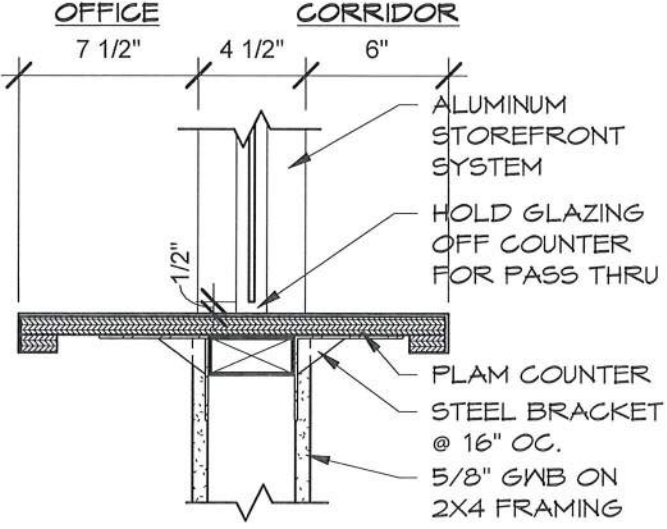

6 PASS THRU SILL
A14.3 1 1/2" = 1'-0"

4331
REGISTERED ARCHITECT
CRAIG M. COLLINS
STATE OF WASHINGTON

Scale As indicated	Date 2/14/2022	Project # 2021-18
-----------------------	-------------------	----------------------

COLLINS
ARCHITECTURAL GROUP, P.S.
950 12th AVE., SUITE 200
LONGVIEW, WA 98632
PHONE: 360-425-0000

SCHEDULE, ELEVATIONS, & DETAILS
LONGVIEW SCHOOL DISTRICT
DISCOVERY HIGH SCHOOL

A14.3