

ADDENDUM TO BID DOCUMENTS

 Pleasanton Unified School District	ADDENDUM 02
	Project: Lydiksen Elementary School Modernization (2021-22.14)
	Date: April 20, 2022

The following clarifications are provided based on questions received or changes in District requirements and must be added/considered when completing your submittal:

Acknowledgement of receipt of this **ADDENDUM** is required in the bid form. Please clearly note the addendum date and number.

Questions:

Q: Do we need to be prequalified to bid the project?

A: Yes, please refer to Instructions to Bidders Item #3.

Clarifications:

Schedule Clarification:

There are two different completion dates for the project. The shade structure's completion date is August 5, 2022. The remodel of Buildings C & E completion date is September 30, 2022.

Attachments:

A. Aedis Addendum #2 (**11 pages**)

END OF ADDENDUM 02



April 15, 2022

Aedis Architects
387 S. First St., Suite 300
San Jose, CA 95113

Subject: Lydiksen Elementary School Modernization
Pleasanton School District
Aedis Project No. 2020029.02
DSA Application #01-119816

ADDENDUM NO. 2

CHANGES AND/OR CLARIFICATIONS OF THE DRAWINGS AND SPECIFICATIONS ARE AS FOLLOWS:

DRAWINGS

ITEM NO. 2.1: DRAWING SHEET A3.02 – BUILDING C – WALL TYPES AND SIGNAGE PLAN

Add: Building C – Floor Finish Plan per attached AD2-A3.02

Add: Finish legend per attached AD2-A3.02

ITEM NO. 2.2: DRAWING SHEET A3.03 – BUILDING E – FLOOR & RCP DEMOLITION PLAN

Revise: Floor plan with finish legend per attached AD2-A3.03

ITEM NO. 2.3: DRAWING SHEET A3.10 – ENLARGED RESTROOM PLANS & ELEVATIONS

Revise: STAFF restroom wall finish per attached AD2-A3.10

Revise: Custodian wall finish per attached AD2-A3.10

ITEM NO. 2.4: DRAWING SHEET A11.01 – FINISH SCHEDULE & LEGEND, CASEWORK SCHEDULE

Revise: Finish Legend per attached AD2-A11.01

Revise: Finish Schedule per attached AD2-A11.01

ITEM NO. 2.5: DRAWING SHEET S5.01 – CONCRETE DETAILS

Revise: Detail 13 per attached AD2-A11.01

ITEM NO. 2.6: DRAWING SHEET E0.2 – ELECTRICAL PANEL SCHEDULES AND LIGHT FIXTURE SCHEDULE

Revise: Panel schedule "B" per attached AD2-E0.2

ADDENDUM NO. 2

04/15/2022

Lydiksen Elementary School Modernization
Pleasanton Unified School District
Aedis Project No. 2020029.02

ITEM NO. 2.7: DRAWING SHEET E1.1 – ELECTRICAL SITE PLAN

Add: Receptacles at each pole of shade structure per attached AD2-E1.1

ITEM NO. 2.8: DRAWING SHEET EC2.2 – SIGNAL – BUILDING C – NEW FLOOR PLAN

Revise: Construction Keynote #10 - per attached AD2-EC2.2

Attachments:

Drawing:

ARCHITECTURAL

SHEET A3.02

SHEET AD2-A3.03

SHEET AD2-A3.10

SHEET A11.01

STRUCTURAL

SHEET AD2-S5.01

ELECTRICAL

SHEET AD2-E0.2

SHEET AD2-E1.1

SHEET AD2-EC2.2

ADDENDUM NO. 2

Lydiksen Elementary School Modernization
Pleasanton Unified School District
Aedis Project No. 2020029.02

04/15/2022



Thang Do, Architect
Aedis Architects




Thuy Fontelera, Structural Engineer
Element Structural Engineers, Inc.




Rolando Sotelo, Electrical Engineer
Optimum Energy Design, Inc.

Division of the State Architect
Office Of Regulation Services

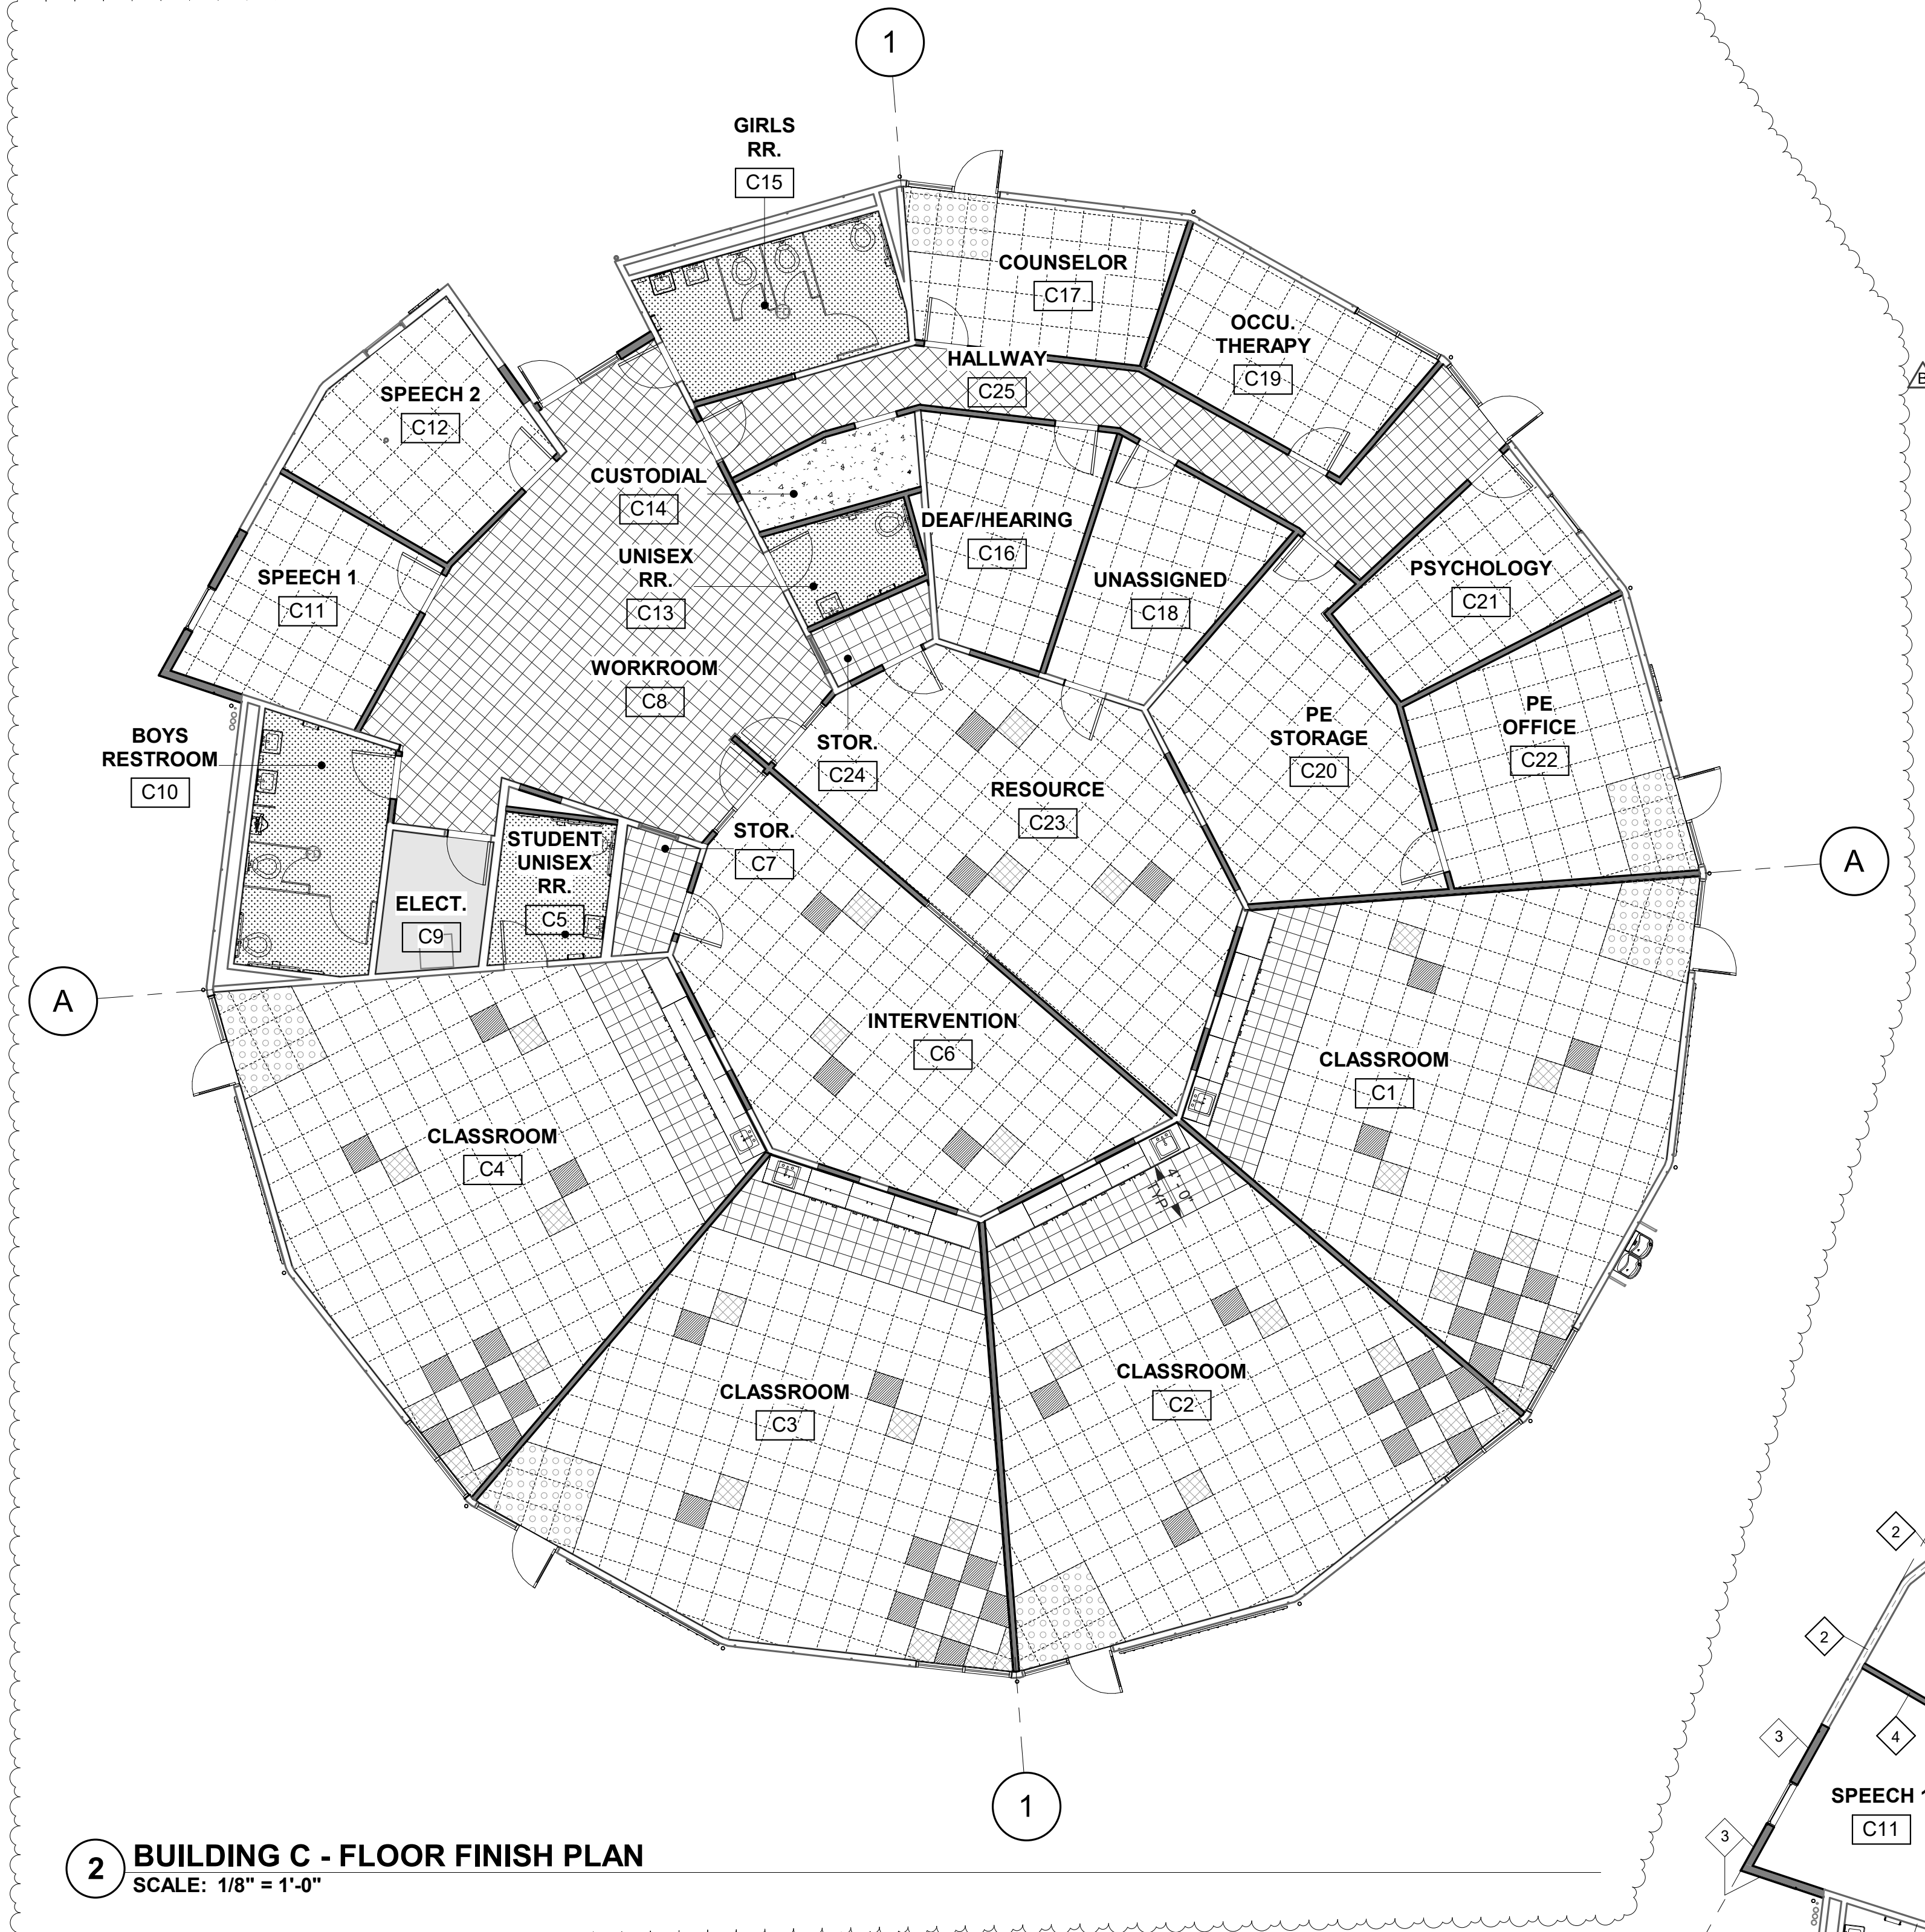

2 BUILDING C - FLOOR FINISH PLAN
SCALE: 1/8" = 1'-0"

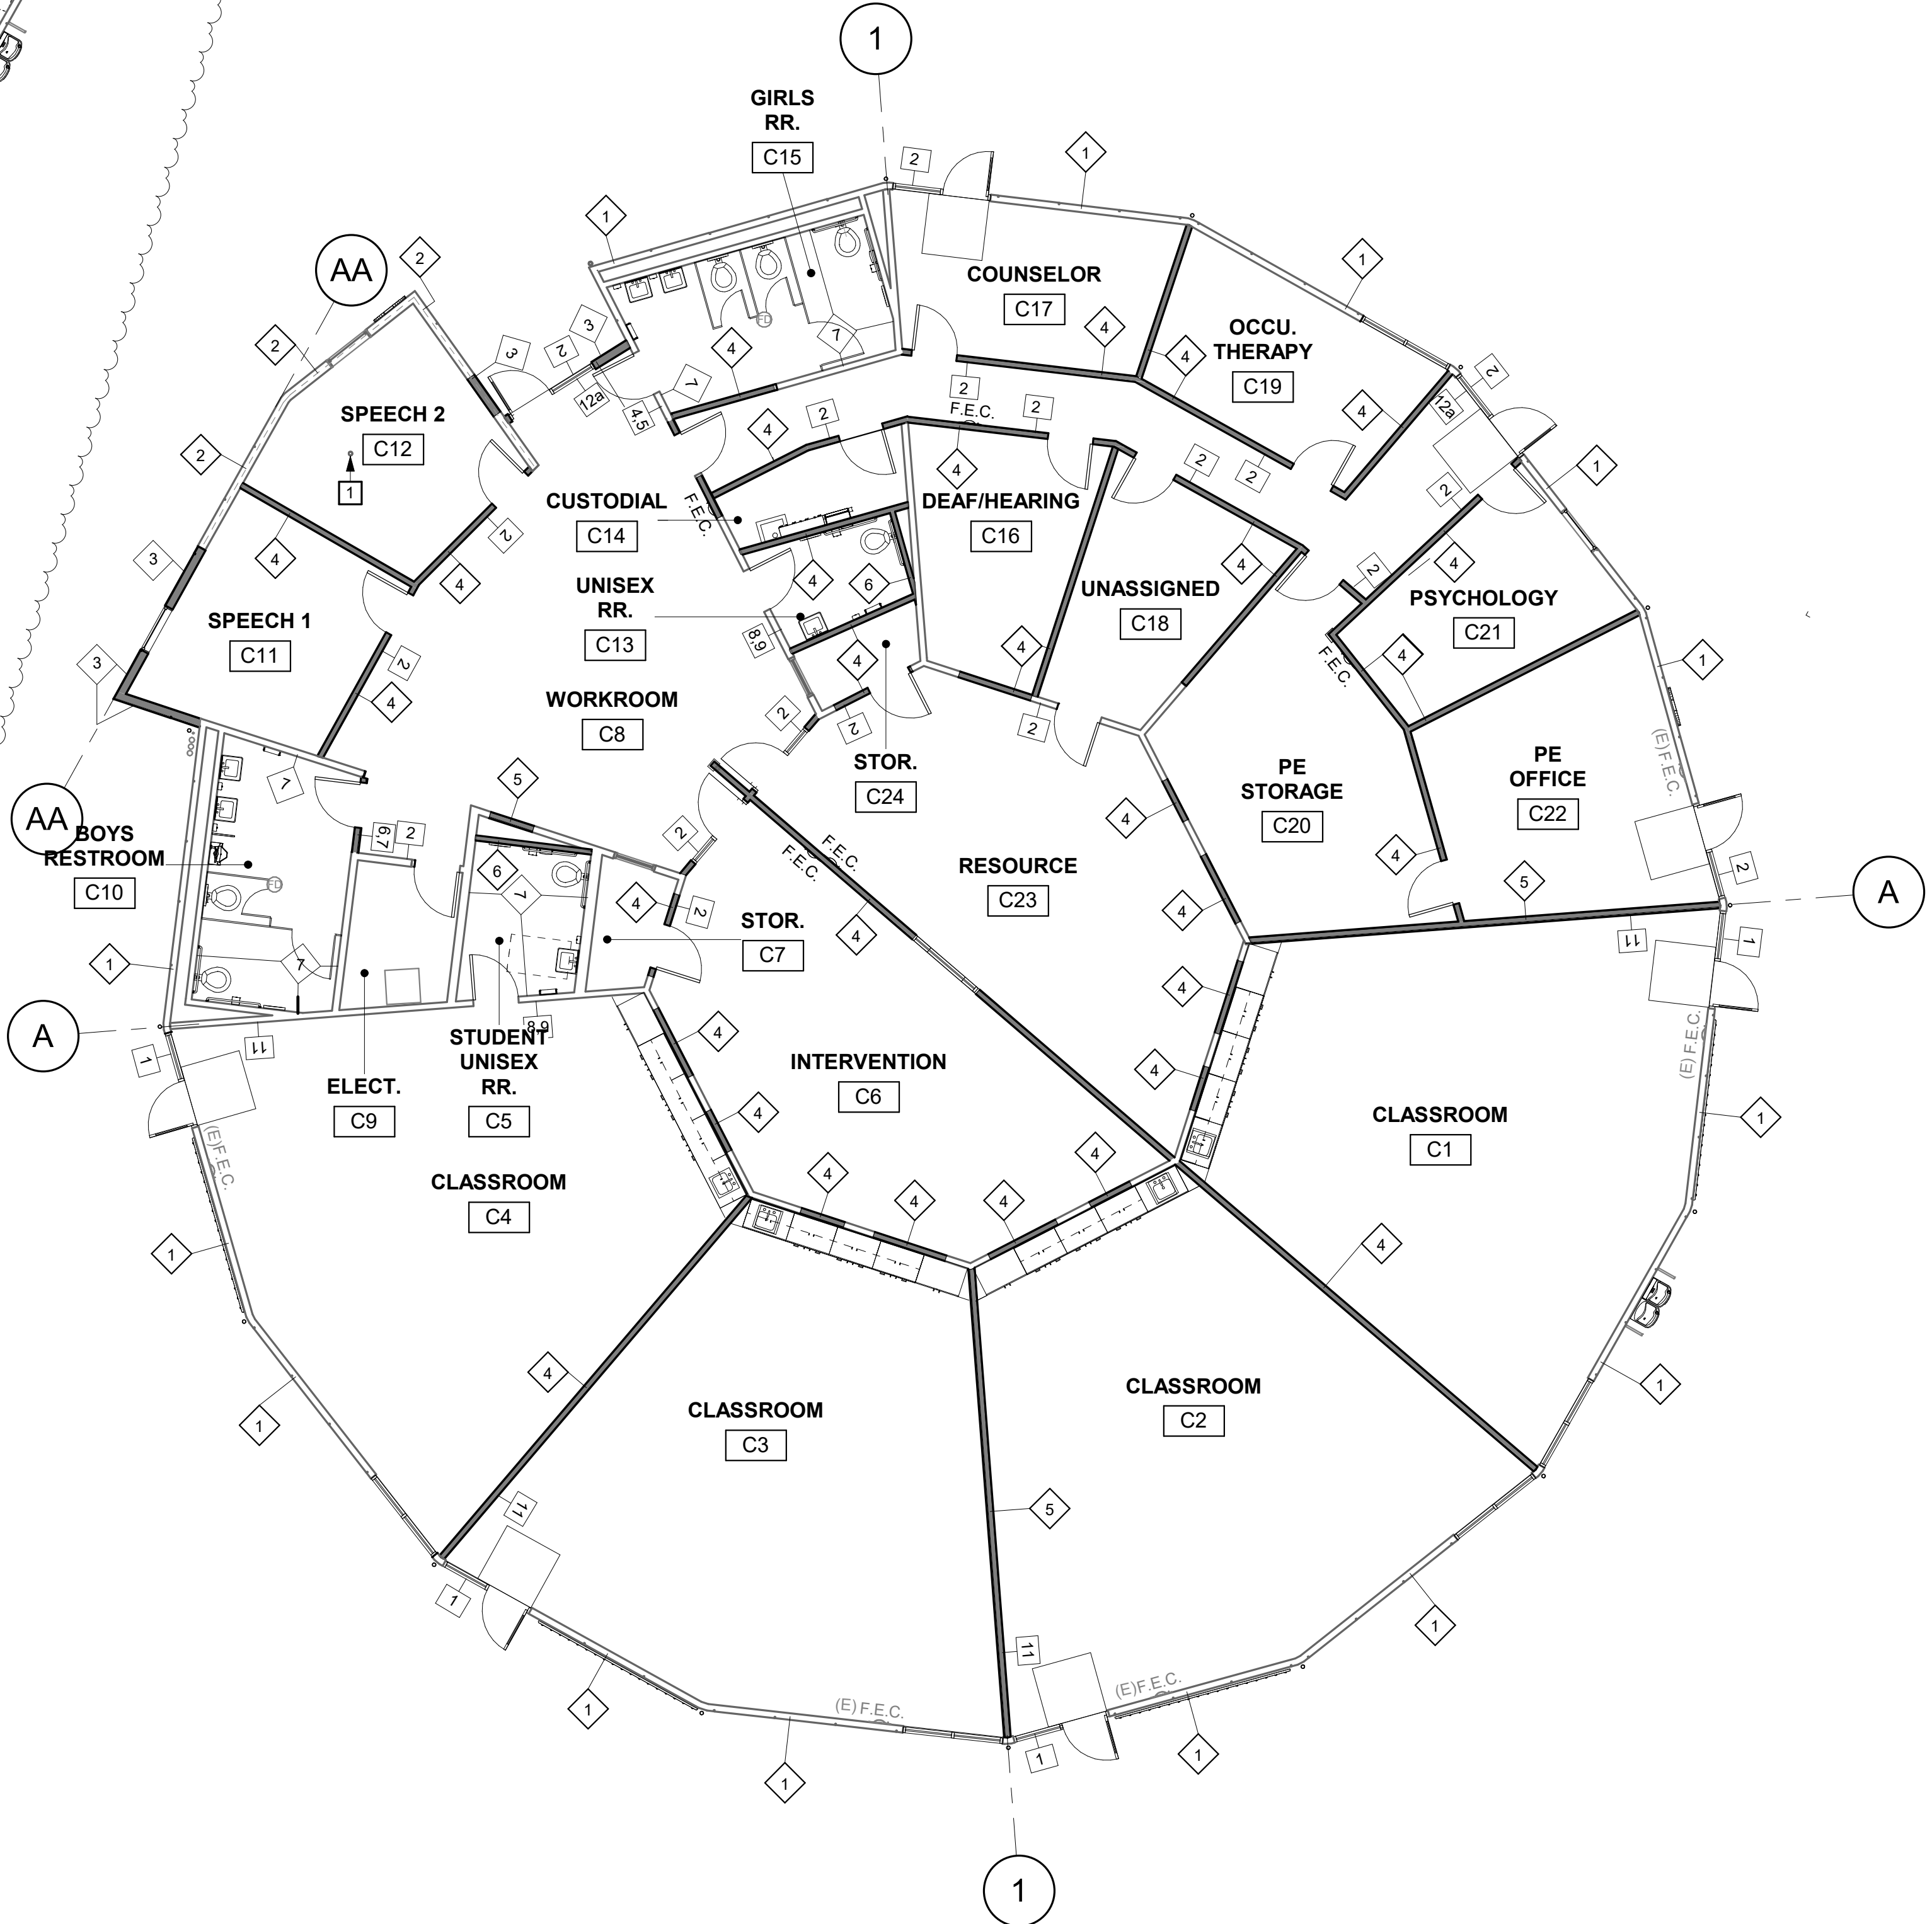

1 BUILDING C - WALL TYPES AND SIGNAGE PLAN
SCALE: 1/8" = 1'-0"

GENERAL SHEET NOTES

- I EXISTING PLUMBING NOT IN USE FOR THE PROPOSED DESIGN, TO BE REMOVED, PATCH AND PREPARE THE WALL TO RECEIVE NEW FINISHES
- J PROVIDE 6" CONCRETE CURB AT ALL EXTERIOR WALLS AND TOILET ROOM WALLS.
- K PROVIDE WALL BLOCKING AT ALL TOILET FIXTURE AND ACCESSORY MOUNTING LOCATIONS AS REQUIRED.
- L ALL TOILET ROOM STUD WALLS SHALL HAVE NEW SOUND ATTENUATION INSULATION.
- M WATER SUPPLY AND DRAIN PIPES ACCESSIBLE UNDER LAVATORIES SHALL BE INSULATED OR OTHERWISE COVERED. THERE SHALL BE NO SHARP OR ABRASIVE OBJECTS OR SURFACES UNDER LAVATORIES, TYP.
- N REFER TO FINISH PLAN AND SCHEDULE FOR IDENTIFICATION OF ALL FINISHES.
- P PATCH EXISTING GYPBOARD CEILING AT NEW WALLS.

FLOOR FINISH KEY

- CPT-1 FIELD CARPET TILE
- CPT-2 WALK OFF CARPET
- CPT-3 ACCENT CARPET TILE
- CPT-4 ACCENT CARPET TILE
- VCT-1 VINYL COMPOSITION TILE
- EPX-1 EPOXY FLOORING
- SC-1 SEALED CONCRETE
- EXISTING FLOOR FINISH


GRAPHIC KEY

- WALL TYPES:**
- WALL TYPE, REFER TO A9.01
 - SIGNAGE TYPE, REFER TO A10.01
- NEW STUD WALL**
- EXISTING STUD WALL**

FIXTURE TYPES:

- NEW SEMI RECESSED FIRE EXTINGUISHER CABINET.
- EXISTING SEMI RECESSED FIRE EXTINGUISHER CABINET.
- FIRE EXTINGUISHER CABINET

KEY PLAN

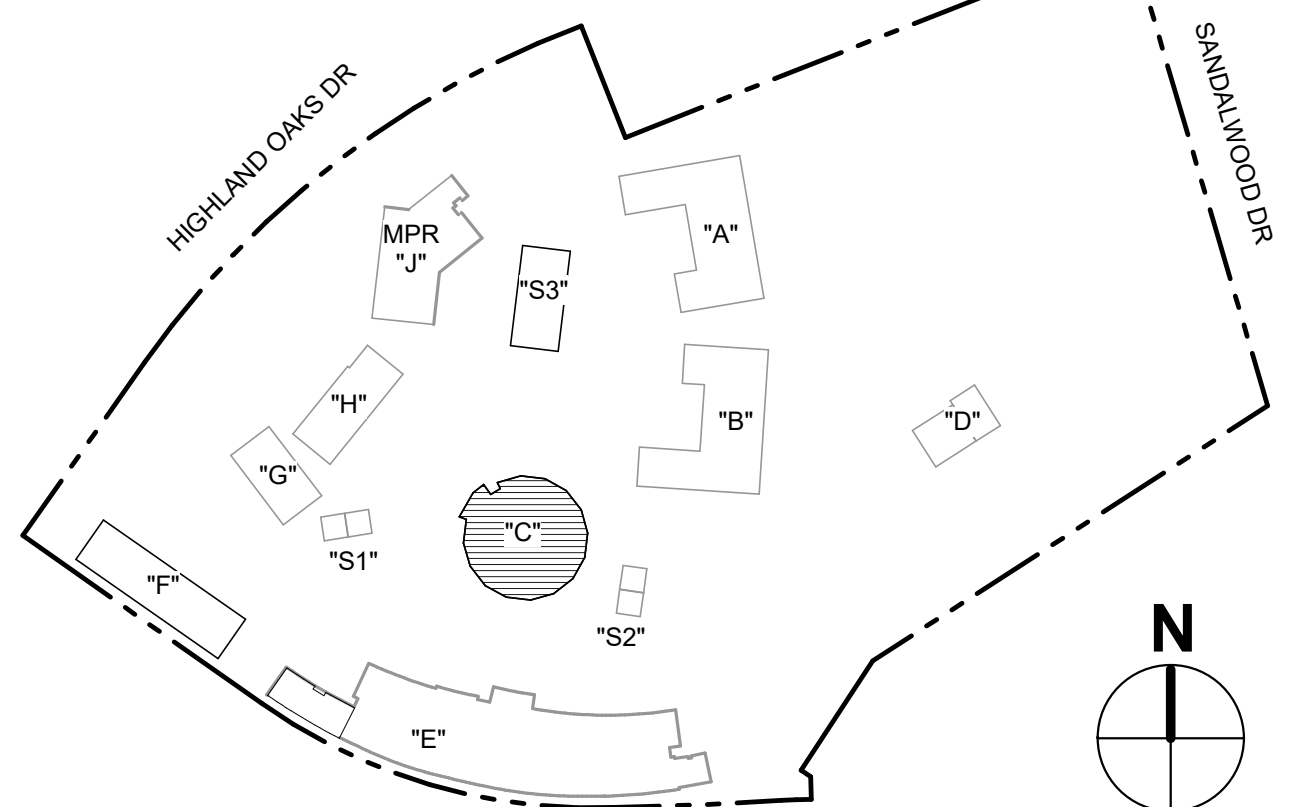

aedis
architects

www.aedisarchitects.com
387 S. 1st Street, Suite 300
San Jose, CA 95113
tel: (408) 300-5100
fax: (408) 300-5121

PROJECT
**LYDIKSEN
ELEMENTARY
SCHOOL
MODERNIZATION**

PLEASANTON UNIFIED
SCHOOL DISTRICT
CONSULTANT

STAMP



STATE
DSA FILE NUMBER **1-32**
APPL # **01-119816**


REVISIONS
No. Description Date
Addendum 2 04/15/22

MILESTONES
SD 06/28/2021
DD 08/23/2021
50% CD 09/20/2021
90% CD 10/14/2021
DSA SUB 10/19/2021

SHEET
**BUILDING C-
WALL TYPES
AND SIGNAGE
PLAN**

DATE **02/15/2022**
JOB # **2020029.02**
SHEET #

A3.02

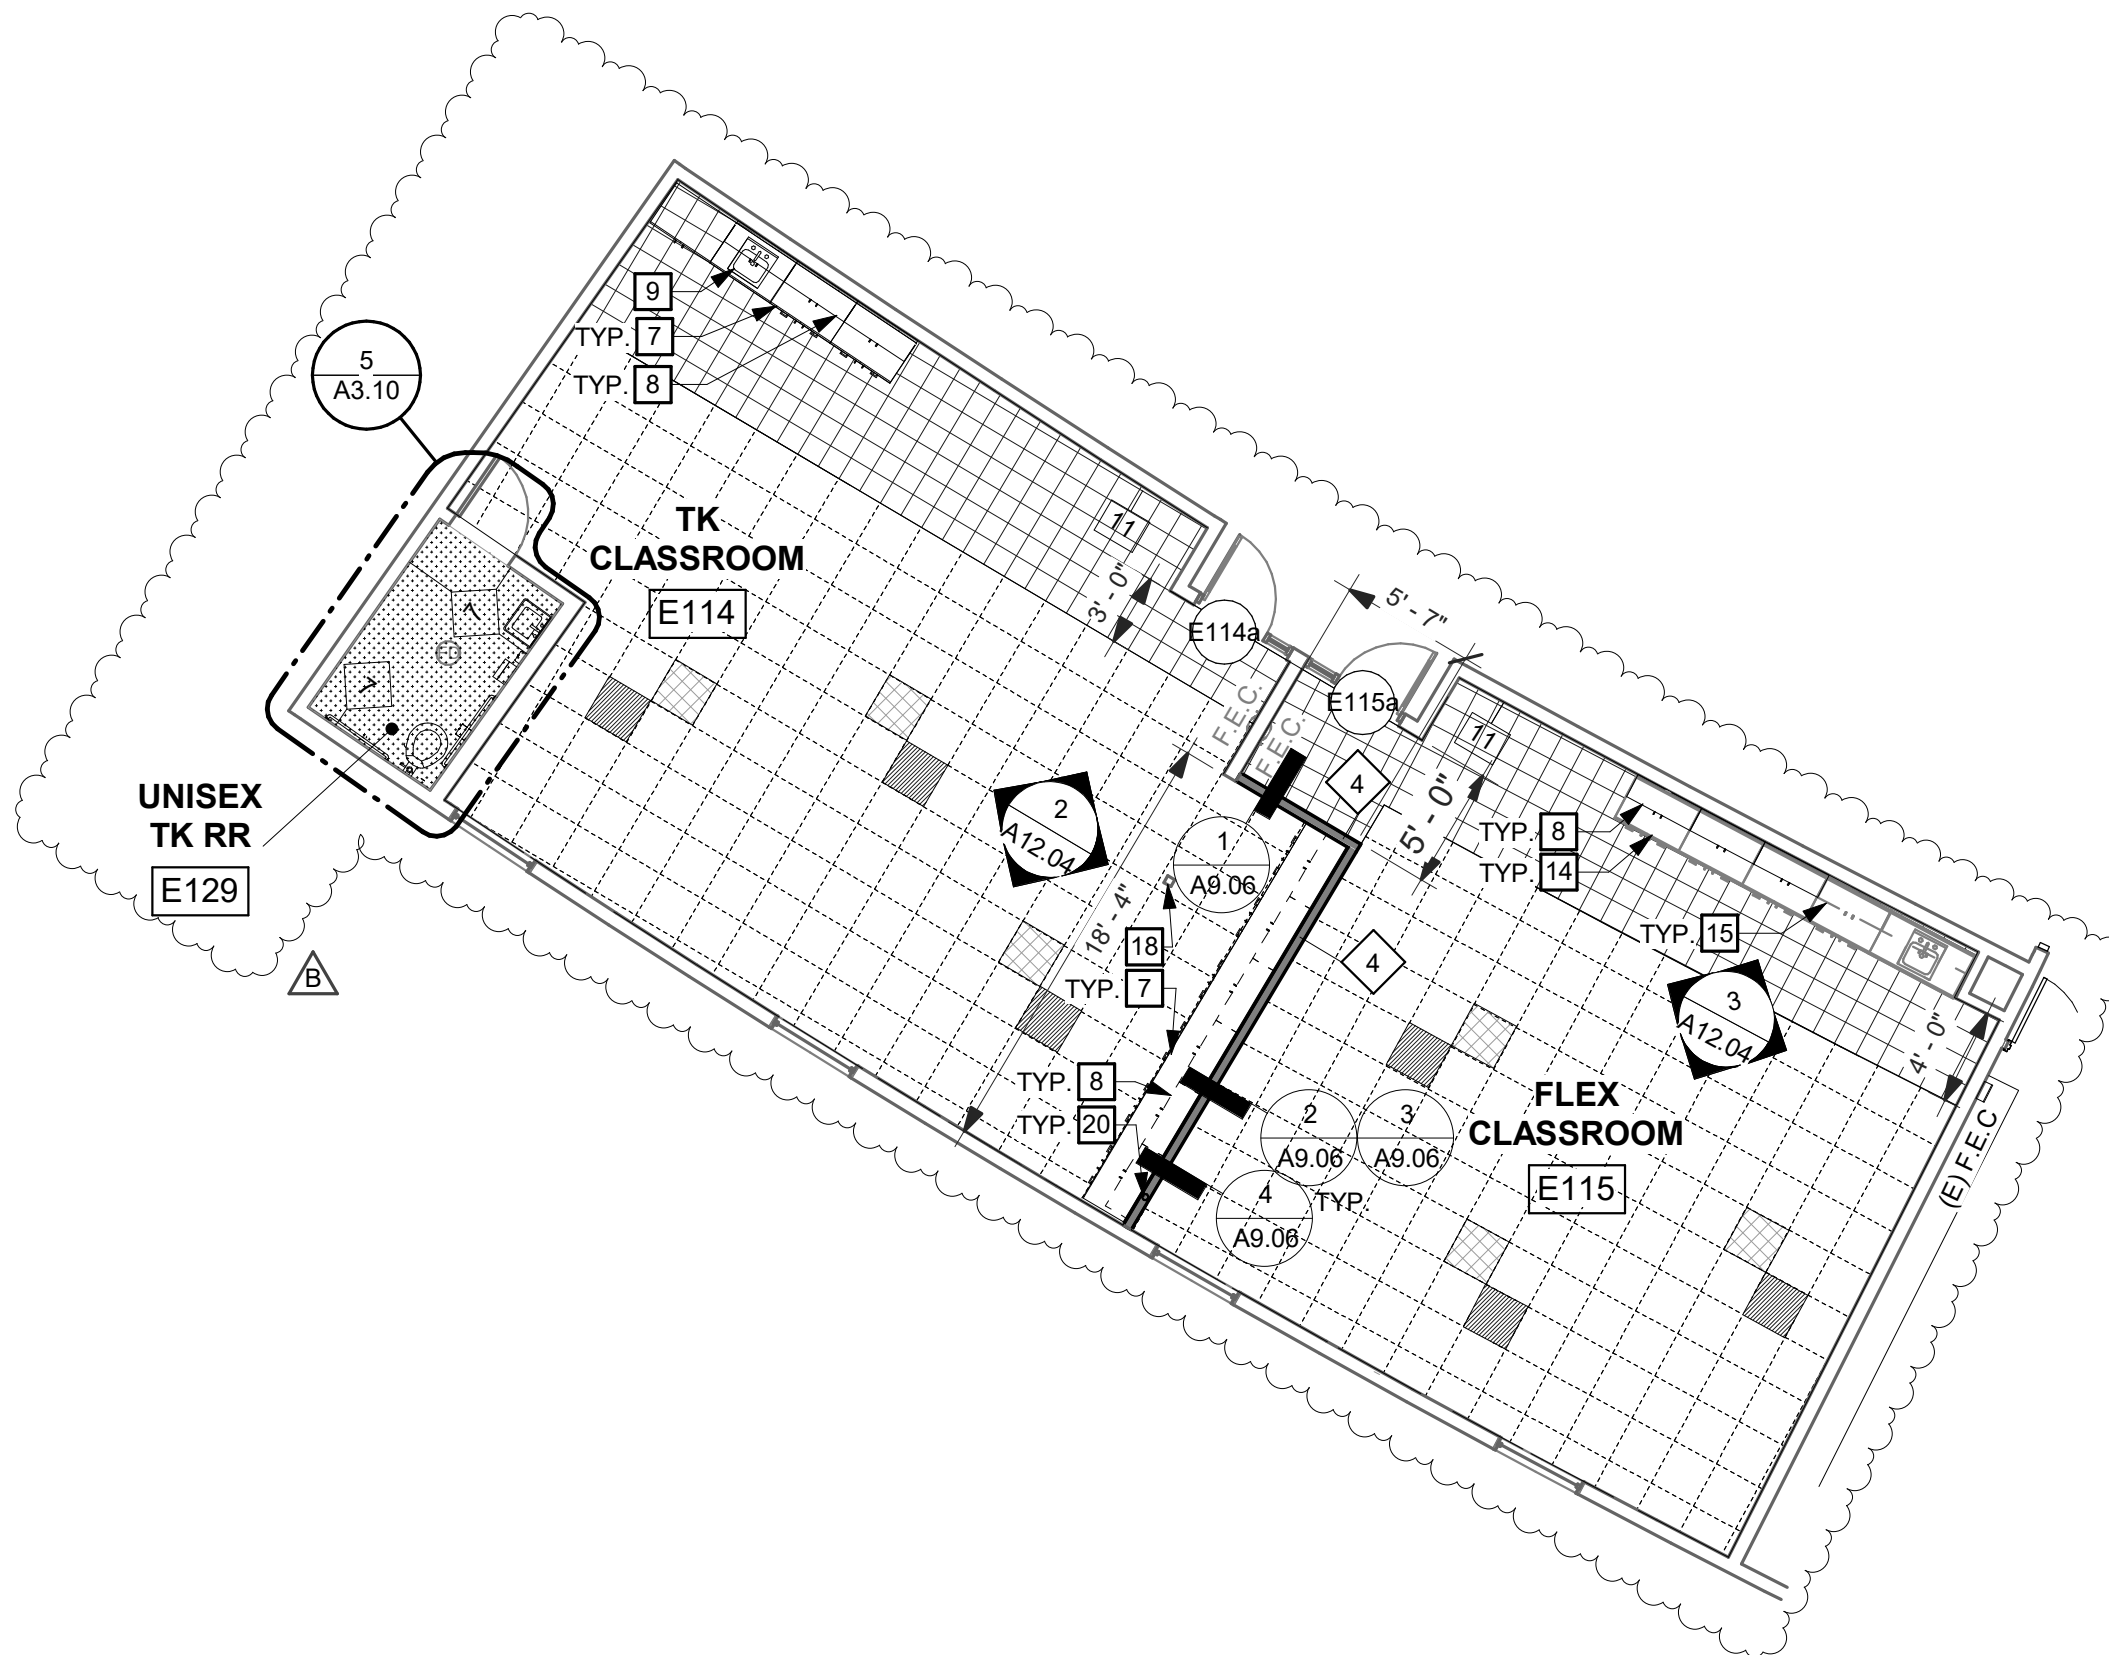

FLOOR FINISH KEY

CPT-1		FIELD CARPET TILE
CPT-3		ACCENT CARPET TILE
CPT-4		ACCENT CARPET TILE
VCT-1		VINYL COMPOSITION TILE
EPX-1		EPOXY FLOORING

3

BUILDING E - FLOOR PLAN

SCALE: 1/8" = 1'-0"



aedis
architects

387 S. 1st Street, Suite 300
San Jose, CA., 95113

tel: (408) 300 - 5160
fax: (408) 300 - 5121

A3.03- BUILDING E- FLOOR & RCP

LYDIKSEN ELEMENTARY SCHOOL
MODERNIZATION
PLEASANTON UNIFIED SCHOOL DISTRICT

FILE NO.: 1-32


APPL NO.: 01-119816

JOB NO. 2020029.02

DATE 04/15/22


SHEET

AD2-A3.03

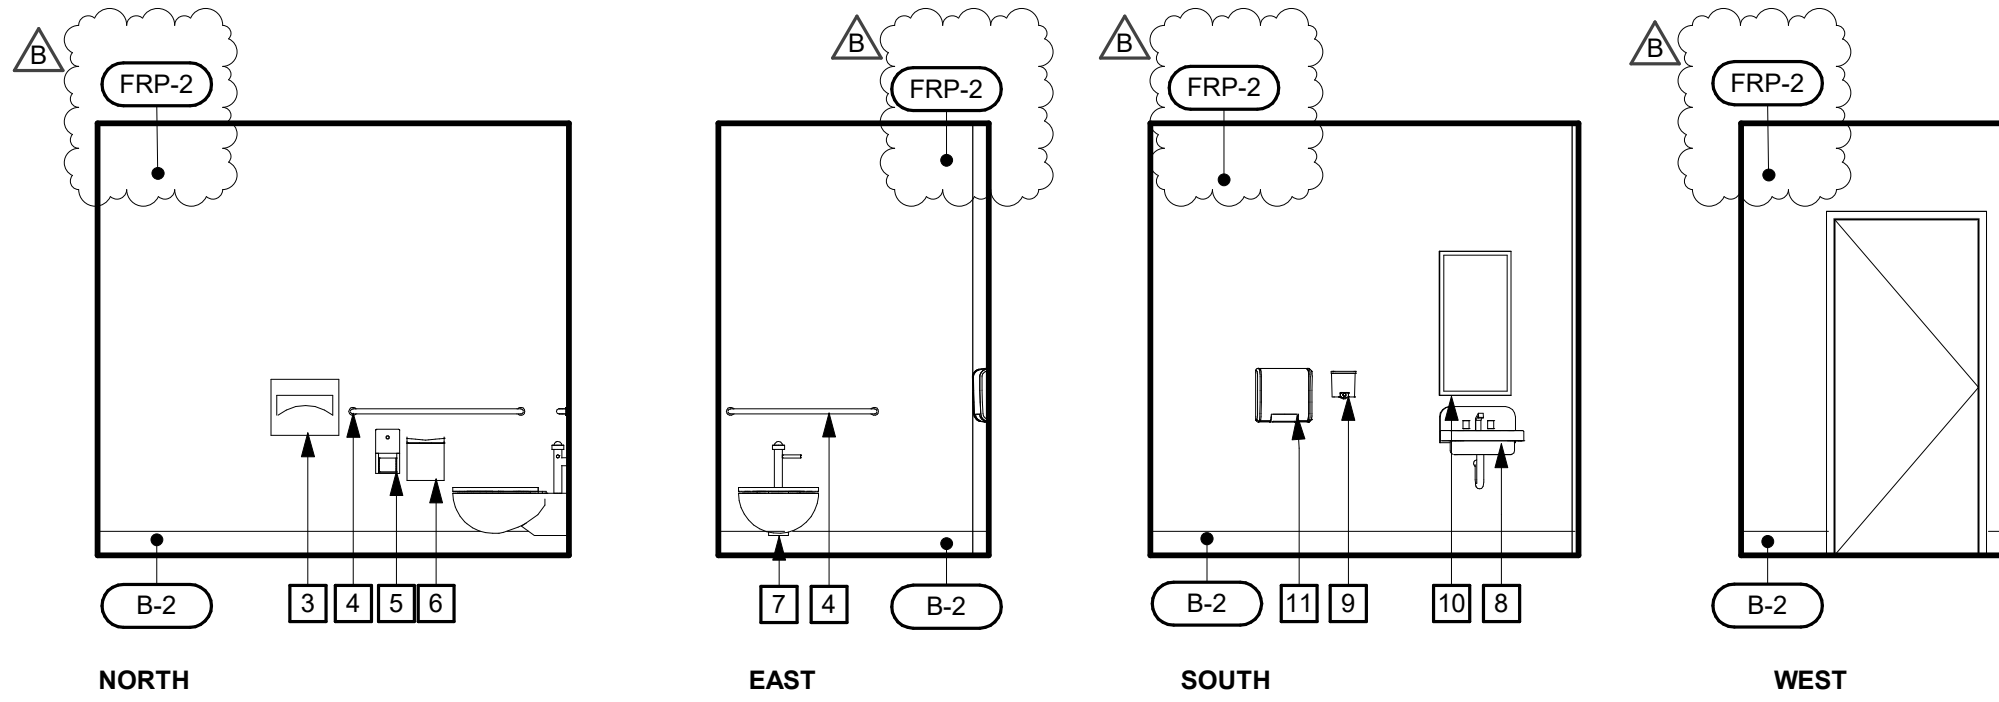

6 STAFF RESTROOM - C13 - INTERIOR ELEVATIONS

SCALE: 1/4" = 1'-0"

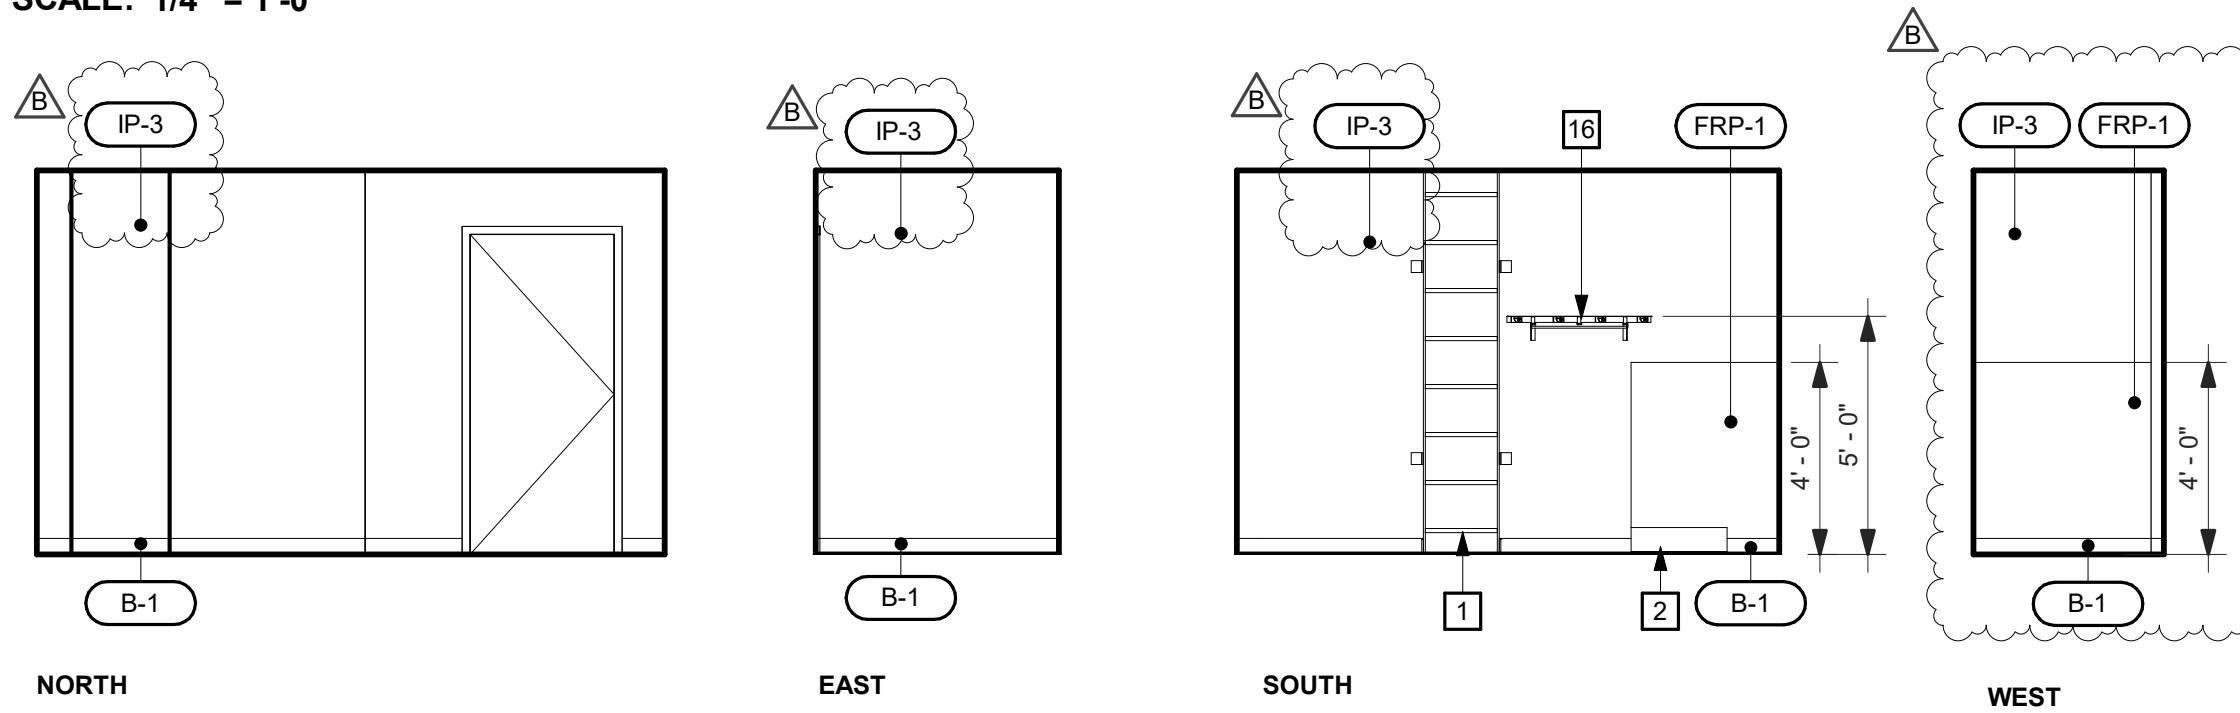

7 CUSTODIAN - C14 - INTERIOR ELEVATIONS

SCALE: 1/4" = 1'-0"

A3.10- ENLARGED RESTROOM PLANS AND ELEVATIONS



aedis architects		LYDIKSEN ELEMENTARY SCHOOL MODERNIZATION PLEASANTON UNIFIED SCHOOL DISTRICT	
		FILE NO.: 1-32 APPL NO.: 01-119816 JOB NO.: 2020029.02 DATE: 04/15/22	SHEET AD2-A3.10
387 S. 1st Street, Suite 300 San Jose, CA., 95113		tel: (408) 300 - 5160 fax: (408) 300 - 5121	

GENERAL FINISH NOTES

- A WHERE MULTIPLE WALL FINISHES ARE CALLED OUT. REFER TO INTERIOR ELEVATIONS FOR LOCATIONS OF INDIVIDUAL FINISHES.
- B WHERE MULTIPLE FLOOR FINISHES ARE CALLED OUT. REFER TO FLOOR FINISH PLANS FOR LOCATIONS OF INDIVIDUAL FINISHES.
- C PROVIDE FINISHES TO COMPLY WITH FLAME SPREAD & SMOKE DENSITY REQUIREMENTS OF CBC 803 and 804.

GENERAL CASEWORK NOTES

- 1 REFER TO INTERIOR ELEVATIONS FOR QUANTITIES, LOCATIONS, FINISHES.
- 2 CONTRACTOR SHALL BE RESPONSIBLE FOR FIELD VERIFYING ALL DIMENSIONS PRIOR TO FABRICATION.

aedisarchitects

www.aedisarchitects.com

387 S. 1st Street, Suite 300

San Jose, CA 95113

tel: (408)-300-5100

fax: (408)-300-5121

PROJECT

LYDIKSEN
ELEMENTARY
SCHOOL
MODERNIZATION

PLEASANTON UNIFIED
SCHOOL DISTRICT

CONSULTANT

STAMP



STATE

DSA FILE NUMBER

1-32

APPL #

01-119816

REVISIONS

No. Description Date

1 Addendum 2 04/15/22

MILESTONES

SD	06/28/2021
DD	08/23/2021
50% CD	09/20/2021
90% CD	10/14/2021
DSA SUB	10/19/2021

SHEET

FINISH
SCHEDULE &
LEGEND &
CASEWORK
SCHEDULE

DATE

02/15/2022

JOB #

2020029.02

SHEET #

A11.01

FINISH LEGEND				
MARK	DESCRIPTION	MFR. / BRAND	COLOR / FINISH	COMMENTS
ACC-1	ACOUSTICAL CEILING CLOUD	ARMSTRONG/SOUND SCAPES	WHITE	
ACT-1	ACOUSTICAL CEILING TILE	USG	2742 RADAR	
B-1	4" RUBBER TOP SET BASE	MANNINGTON COMMERCIAL BURKE	502/BROWN	
B-2	6" EPOXY COVED BASE	TERALITE TERRAGEM III DQ TERA BLEND	BONE WHITE #70 MESH	
CPT-1	CARPET (TILE)	TANDUS/APPLAUSE II	MOSAIC/28502	FIELD CARPET TILE
CPT-2	WALK-OFF MAT	TANDUS/ABRASIVE ACTION	CHARCOAL/19100	
CPT-3	CARPET ACCENT	TANDUS/PLEXUS COLOUR IV	GREAT LAKES 18548	ACCENT CARPET TILE
CPT-4	CARPET ACCENT	TANDUS/PLEXUS COLOUR IV	PURPLE HAZE 18543	ACCENT CARPET TILE
EP-1	EXTERIOR PAINT	DUNN EDWARDS	DEC752/BIRCHWOOD	FIELD PAINT
EP-2	EXTERIOR PAINT	DUNN EDWARDS	DEC759/HICKORY	ACCENT PAINT
EP-3	EXTERIOR PAINT	DUNN EDWARDS	DES977/MUTED BERRY	ACCENT PAINT
EPX-1	EPOXY FLOORING	TERALITE TERRAGEM III DQ TERA BLEND	BONE WHITE #70 MESH	
FRP-1	FIBERGLASS REINFORCED PLASTIC PANELS	MARLITE	NATURAL ALMOND/P-118	
FRP-2	FIBERGLASS REINFORCED PLASTIC PANELS	MARLITE	LIGHT GRAY S2S S4890N	
GB	GYPSON BOARD	SEE SPECIFICATIONS	WHITEST WHITE/KMW43	PAINTED TYP., U.O.N
IP-2	INTERIOR PAINT	DUNN EDWARDS	BLUEMOON/DE5764	ACCENT PAINT
IP-3	INTERIOR PAINT	DUNN EDWARDS	WHISPER DEW340	FIELD PAINT
PL-1	PLASTIC LAMINATE	WILSONART	MONTECELLO MAPLE 7825	CASEWORK EXPOSED SURFACE
PL-2	PLASTIC LAMINATE	WILSONART	GINSENG TEA 4929	COUNTER TOP
RWS	ROLLER WINDOW SHADE	MECHOSHADES/THERMOVEIL	1502 BEIGE	
SC-1	SEALED CONCRETE	SEE SPECIFICATIONS		
TWP-1	TACKABLE WALL PANELS (OI GYP. BD.)	XOROSEAL/SONESTA	CERES TERM (B321-05)	
VCT-1	VINYL COMPOSITION TILE	ARMSTRONG/PREMIUM EXCELON	5CB11/ANTIQUE WHITE-CROWN TEXTURE	
WS	WRITABLE WALL PANEL	NELSOM ADAMS	WHITE	

CASEWORK SCHEDULE					
MARK	WOODWORK INSTITUTE CASEWORK DESIGN SERIES #	WIDTH	HEIGHT	DEPTH	COMMENTS
C-1	155-	3' - 0"	2' - 6"	2' - 0"	
C-2	222	3' - 0"	2' - 6"	2' - 0"	
C-2C	222	2' - 0"	2' - 8 1/2"	2' - 0"	
C-3	302	3' - 0"	2' - 6"	1' - 0 1/2"	
C-3C	302	4' - 0"	2' - 6"	1' - 0 1/2"	
C-4	530	3' - 0"	7' - 0"	2' - 0"	TALL CABINET
C-5	302	3' - 0"	2' - 6"	1' - 0 1/2"	
C-6	222	3' - 0"	2' - 6"	2' - 0"	
C-8	530	3' - 0"	7' - 0"	2' - 0"	TALL CABINET
C-10	155-	3' - 0"	2' - 0"	2' - 0"	
C-11	222	3' - 0"	2' - 0"	2' - 0"	

FINISH SCHEDULE						
FLOOR						
NUMBER	NAME	FLOOR FINISH	BASE FINISH	WALL FINISH	CEILING FINISH	COMMENTS
C1	CLASSROOM	CPT-1,CPT-2,CPT-3,CPT-4,VCT-1	B-1	IP-3, TWP-1, WS	(E) GB, IP-3	
C2	CLASSROOM	CPT-1,CPT-2,CPT-3,CPT-4,VCT-1	B-1	IP-3, TWP-1, WS	(E) GB, IP-3	
C3	CLASSROOM	CPT-1,CPT-2,CPT-3,CPT-4,VCT-1	B-1	IP-3, TWP-1, WS	(E) GB, IP-3	
C4	CLASSROOM	CPT-1,CPT-2,CPT-3,CPT-4,VCT-1	B-1	IP-3, TWP-1, WS	(E) GB, IP-3	
C5	STUDENT UNISEX RR.	EPX-1	B-2	FRP-1	(E) GB, IP-3	
C6	INTERVENTION	CPT-1,CPT-3,CPT-4	B-1	IP-3	(E) GB, IP-3	
C7	STOR.	VCT-1	B-1	IP-3	(E) GB, IP-3	
C8	WORKROOM	VCT-1	B-1	IP-2, IP-3	ACT-1, GB, IP-3	
C9	ELECT.	(E)	B-1	IP-3	(E) GB, IP-3	
C10	BOYS RESTROOM	EPX-1	B-2	FRP-1	(E) GB, IP-3	
C11	SPEECH 1	CPT-1	B-1	IP-3	GB, IP-3, ACC-1	
C12	SPEECH 2	CPT-1	B-1	IP-3	GB, IP-3, ACC-1	
C13	UNISEX RR.	EPX-1	B-2	FRP-2	GB, IP-3	
C14	CUSTODIAL	SC-1	B-1	IP-3, FRP-1	GB, IP-3	
C15	GIRLS RR.	EPX-1	B-2	FRP-1	(E) GB, IP-3	
C16	DEAF/HEARING	CPT-1	B-1	IP-3	(E) GB, GB, IP-3	
C17	COUNSELOR	CPT-1,CPT-2	B-1	IP-3	(E) GB, IP-3, ACC-1	
C18	UNASSIGNED	CPT-1	B-1	IP-3	(E) GB, GB, IP-3	
C19	OCCU. THERAPY	CPT-1	B-1	IP-3	(E) GB, IP-3, ACC-1	
C20	PE STORAGE	CPT-1	B-1	IP-3	(E) GB, GB, IP-3	
C21	PSYCHOLOGY	CPT-1	B-1	IP-3	(E) GB, IP-3, ACC-1	
C22	PE OFFICE	CPT-1,CPT-2	B-1	IP-3	(E) GB, IP-3, ACC-1	
C23	RESOURCE	CPT-1,CPT-3,CPT-4	B-1	IP-3	(E) GB, IP-3	
C24	STOR.	VCT-1	B-1	IP-3	(E) GB, IP-3	
C25	HALLWAY	VCT-1	B-1	IP-3	ACT-1	
E114	TK CLASSROOM	VCT-1,CPT-1,CPT-3,CPT-4	B-1	IP-3, WS, TWP-1	(E) ACT, ACT-1	
E115	FLEX CLASSROOM	VCT-1,CPT-1,CPT-3,CPT-4	B-1	IP-3, WS, TWP-1	(E) ACT, ACT-1	
E129	UNISEX TK RR	EPX-1	B-2	FRP-1	(E) GB, IP-3	

(E)PANEL "B"				MAIN BREAKER: 300A				SCA: 10 KAIC			
VOLTAGE: 120/208V 4-WIRE				BUS SIZE				MOUNT: SURFACE			
LOCATION: ELEC RM				COPPER: 300A				ENTRY: BOTTOM			
DESCRIPTION	OKT	BKR	P	LTS	REC	MSC	MTR	A-VA	B-VA	C-VA	AMPS
RECEPT. CLASSROOM C1	1	20	1		5			900			
RECEPT. CLASSROOM C1	3	20	1		7				1260		
RECEPT. CLASSROOM C2	5	20	1		5					900	
RECEPT. CLASSROOM C2	7	20	1		7			1260			
RECEPT. CLASSROOM C3	9	20	1		5				900		
RECEPT. CLASSROOM C3	11	20	1		7					1260	
RECEPT. CLASSROOM C4	13	20	1		5			900			
RECEPT. CLASSROOM C4	15	20	1		7				1260		
RECEPT. RM C5, C6	17	20	1		5					900	
RECEPT. RM C6, C7	19	20	1		4			720			
RECEPT. RM C10, C11, C12	21	20	1		10				1800		
RECEPT. RM C8	23	20	1		9					1620	
RECEPT. RM C15, C17	25	20	1		8			1440			
RECEPT. RM C19	27	20	1		8				1440		
RECEPT. RM C16, C18	29	20	1		9					1620	
RECEPT. RM C31	31	20	1		6			1440			
RECEPT. RM C33	33	20	1		8				1080		
RECEPTACLES	35	20	1								
PANEL L2B	37	100	3					7094			
W/CKT. 37	39	-	-						3988		
W/CKT. 37	41	-	-							4404	
SUB TOTAL VOLT/AMPS:								13754	11728	10704	
WATER HEATER EWH-1	2	20	2			1		1500			
W/CKT. 2	4	-	-						1500		
RECEPT. RM C13, C23	6	20	1		5					900	
RECEPT. RM C23, C24	8	20	1		4			720			
SF-1	10	20	1			1			600		
EF-1	12	20	1			1				10	
EF-2	14	20	1			1		10			
PELICAN GATEWAY GW400	16	20	1			1			100		
FAEP-B	18	20	1							100	
IDE	20	20	1					200			
EXTERIOR POLE RECEPTACLES	22	20	1		3				1080		
FC-1B	24	20	1							200	
REF	26	20	1					700			
SPARE	28	15	1								
CU-1B	30	30	2							1300	
W/CKT. 30	32	-	-					1300			
HAND DRYER - BOYS RESTROOM	34	15	1						700		
HAND DRYER - GIRLS RESTROOM	36	15	1							700	
SITE LIGHTING	38	20	1	3				1028			
SPARE	40	20	2								
W/CKT. 40	42	-	-								
SUB TOTAL VOLT/AMPS:								5458	3980	3210	
TOTAL VOLT/AMPS:								19212	15708	13914	
TOTAL LCU/PHASE								0	0	0	
TOTAL VOLT/AMPS:								19212	15708	13914	
TOTAL AMPS/PHASE:								160	131	116	
CONNECTED: 48834 VA											
25% OF MTR: 0 VA											
25% OF LCL: 0 VA											
CALCULATED: 48834 VA = 135.6 AVERAGE AMPS											

* = INDICATES EXISTING LOAD TO REMAIN. (LOADS FROM AS-BUILT DRAWINGS)

□ = INDICATES NEW LOAD ON EXISTING CIRCUIT BREAKER.

○ = INDICATES EXISTING LOAD TO BE REMOVED AND RENAME THE BREAKER AS SPARE.



E-0.2 - ELECTRICAL PANEL SCHEDULES AND LIGHT FIXTURE SCHEDULE

		LYDIKSEN ELEMENTARY SCHOOL MODERNIZATION PLEASANTON UNIFIED SCHOOL DISTRICT	
387 S. 1st Street, Suite 300 San Jose, CA., 95113		FILE NO.: 1-32	SHEET
tel: (408) 300 - 5160 fax: (408) 300 - 5121		APPL NO.: 01-119816	AD2-E-0.2
		JOB NO. 2020029.02	
		DATE 04/15/22	

(1) 12 STRAND SM FIBER (DATA)-
(1) 6PR CAT 6 (TEL) _____




aedis
architects

tel: (408) 300 - 5160
fax: (408) 300 - 5121

FILE NO.:	1-32
APPL NO.:	01-119816
JOB NO.	2020029.02
DATE	04/15/22

AD2-E1.1

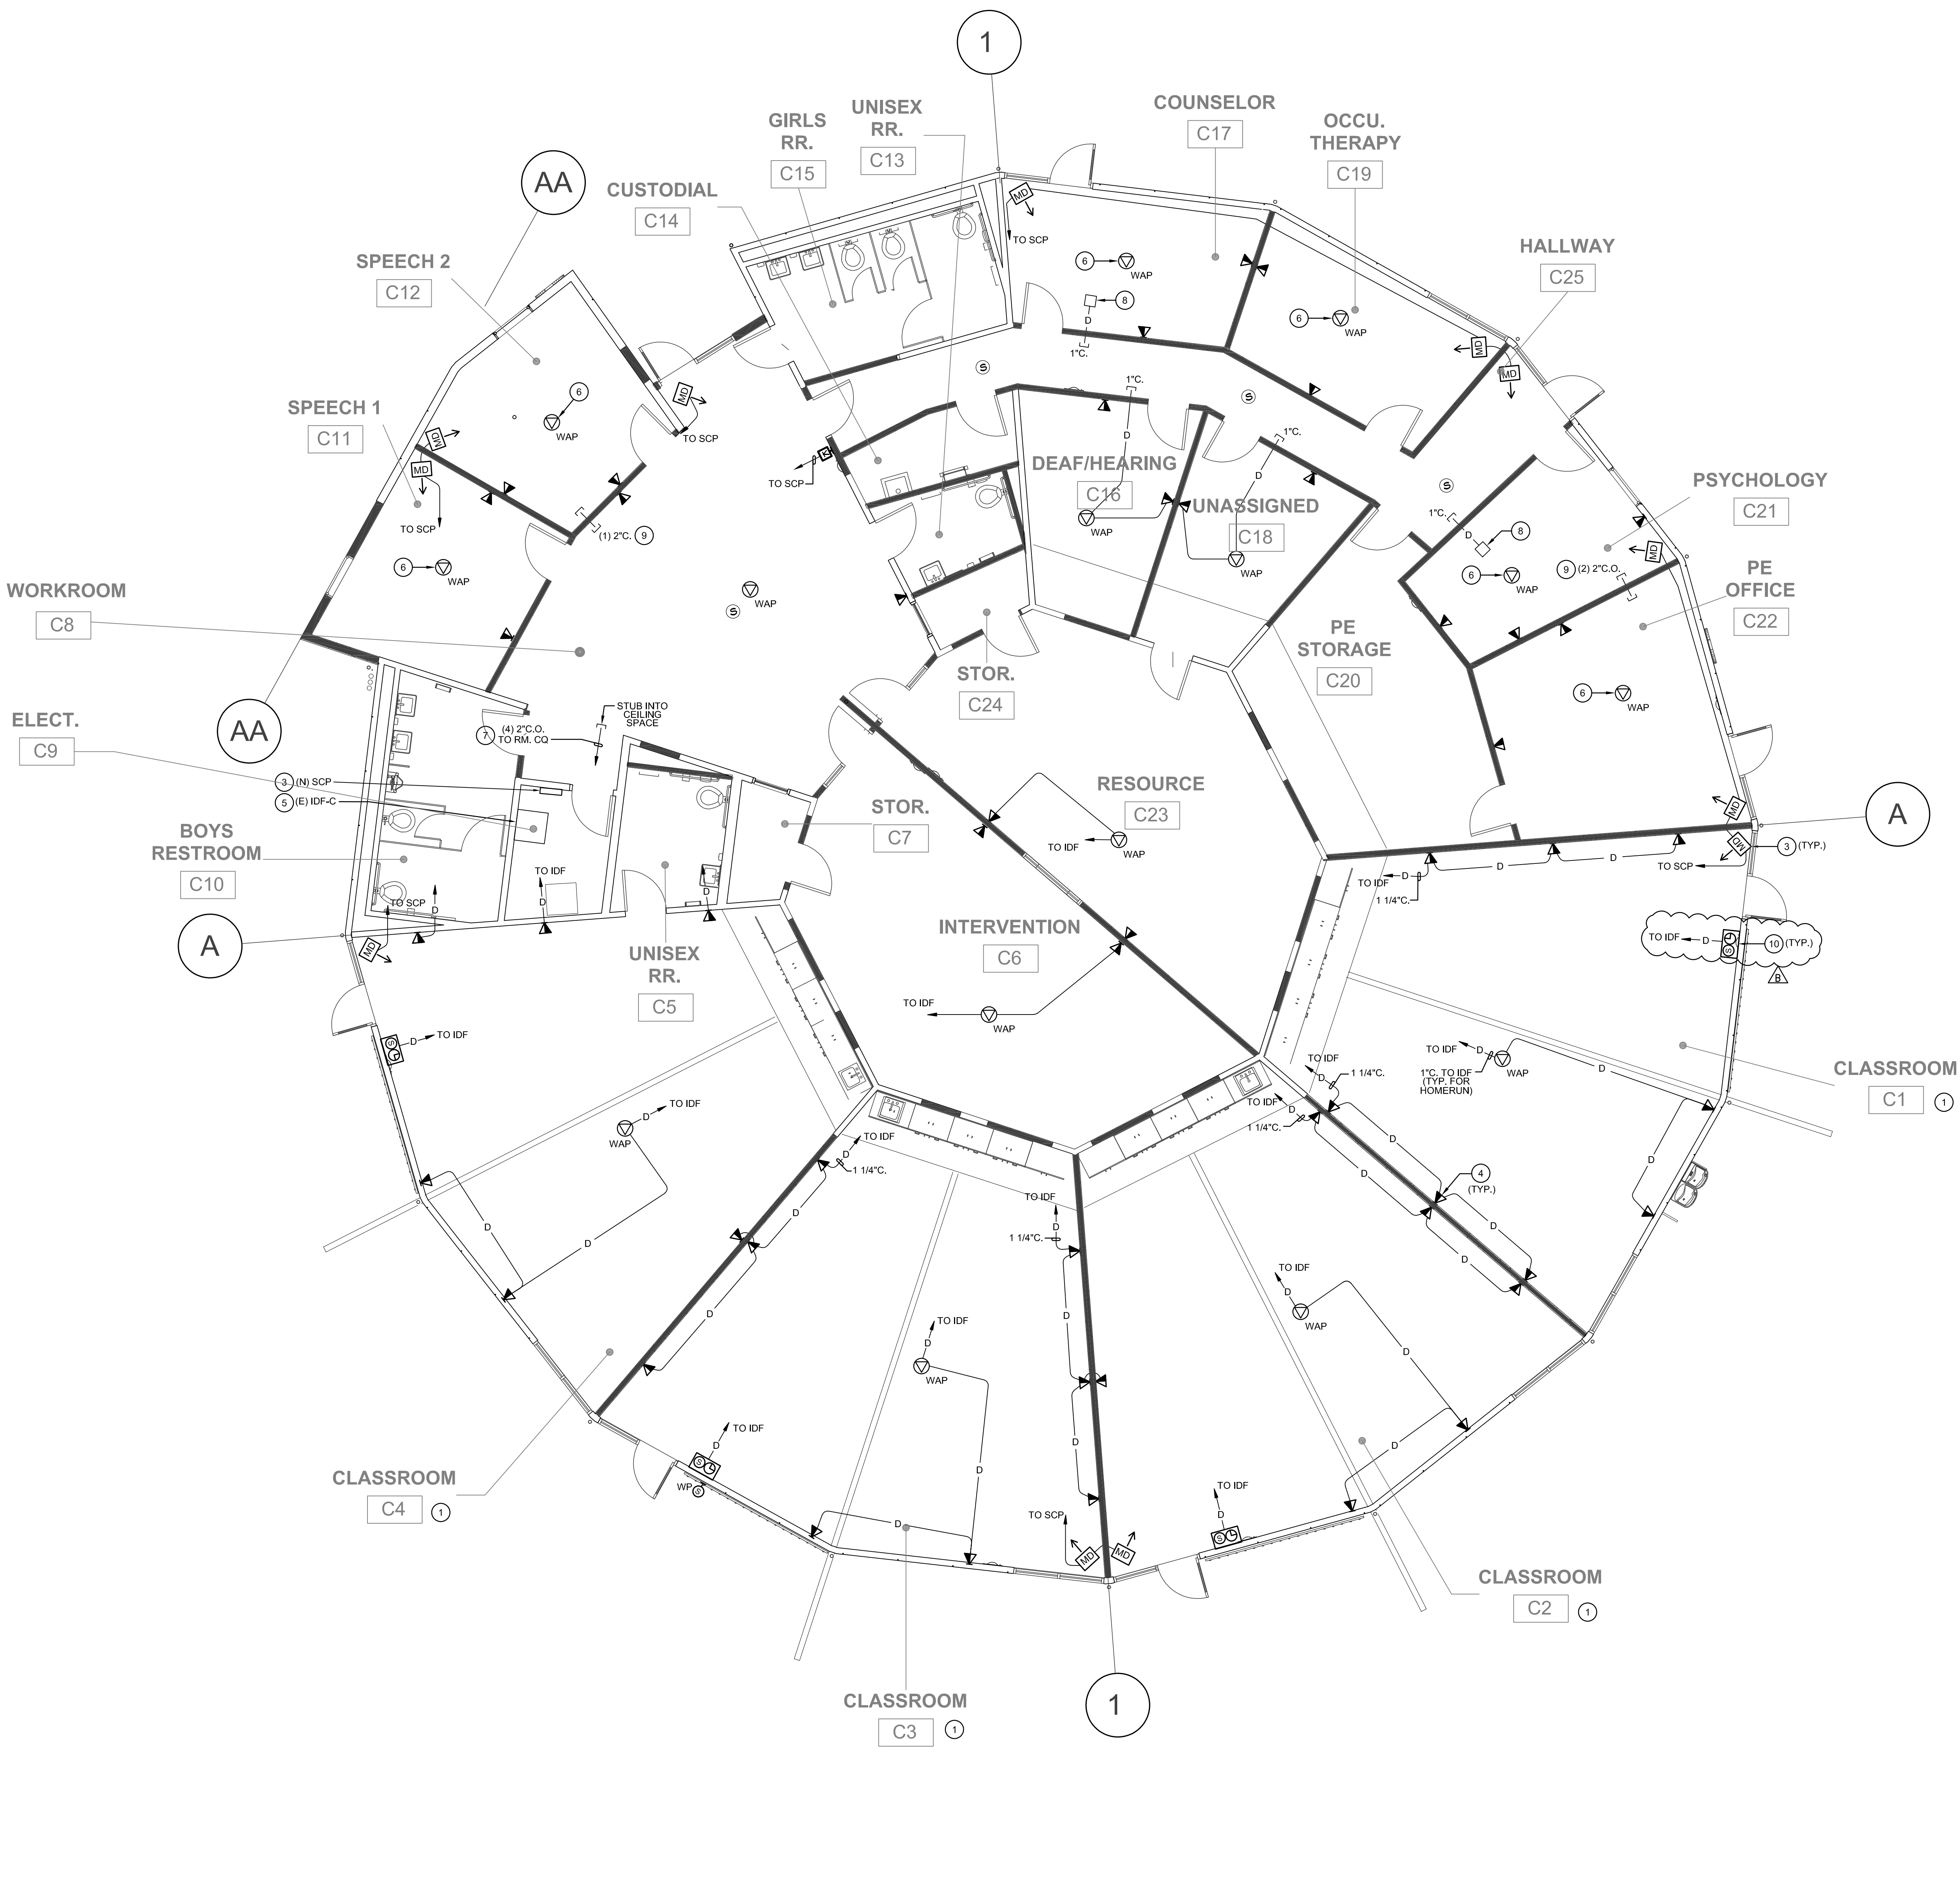

NEW CONSTRUCTION GENERAL NOTES

CONSTRUCTION KEYNOTES

- ALL NEW CONDUIT RUN IN CLASSROOM CEILINGS SHALL BE RUN CONCEALED WITHIN THE JOIST.
- LOW VOLTAGE WIRE/CABLE INSTALLED OVER T-BAR CEILING SHALL BE PLENUM RATED AND SUPPORTED BY J-HOOK.
- PROVIDE BACKBOX AND RACEWAY ONLY FOR INSTALLATION OF OWNER FURNISHED AND INSTALLED SECURITY EQUIPMENT/DEVICES AND WIRE/CABLE. EXACT LOCATION OF THE SECURITY CONTROL PANEL (SCP) TO BE DETERMINED IN FIELD.
- OUTLET BOXES IN WALLS SHALL NOT BE INSTALLED BACK-TO-BACK, MAINTAIN MINIMUM 12" HORIZONTAL SEPARATION BETWEEN OUTLETS, ON OPPOSITE WALL SURFACES, WHERE INSTALLED IN THE SAME STUD BAY.
- EXISTING IDF TO BE RETROFITTED WITH NEW RACK MOUNTED EQUIPMENT (i.e. PATCH PANELS, MODULES, CONNECTORS, ETC.) THAT ARE FULLY COMPATIBLE WITH THE NEW SINGLE MODE NETWORK FIBER CABLEING SYSTEM. EXISTING RACK MOUNTED EQUIPMENT THAT IS NO LONGER IN USE SHALL BE DISCONNECTED, REMOVED AND TURNED OVER TO THE SCHOOL DISTRICT IN "AS-FOUND" CONDITION.
- IN ROOMS WITH FLOATING CEILINGS, INSTALL WIRELESS ACCESS POINTS ON THE FLOATING CEILING AND IN SUCH A MANNER AS TO AVOID CONFLICT WITH OTHER OUTLETS, DEVICES, FIXTURES, AND UTILITIES.
- PROVIDE CONDUIT SLEEVES FOR ROUTING OF LOW VOLTAGE WIRE/CABLE BETWEEN ACCESSIBLE CEILING SPACES AND ROOMS WITH HARD-ID CEILINGS OR ROOMS WITH NO CEILINGS, AND FOR ROUTING OF CABLES THRU FULL HEIGHT WALLS. SLEEVES SHALL BE SEALED TO ELIMINATE NOISE TRANSMISSION BETWEEN ROOMS.
- PROVIDE 9" SQUARE X 4" DEEP MINIMUM PULL BOX TO COLLECT/GATHER LOW VOLTAGE CABLES INSTALLED IN OPEN CEILINGS.
- ALL CONDUIT WALL PENETRATIONS SHALL BE SEALED TO ELIMINATE NOISE TRANSMISSION BETWEEN ROOMS.
- EXISTING COMBINATION SURFACE MOUNTED IP SPEAKER AND CLOCK TO BE REMOVED AND RE-INSTALLED IN THE SAME LOCATION.

aedis
architects


www.aedisarchitects.com
387 S. 1st Street, Suite 300
San Jose, CA 95113
tel: (408) 300-5160
fax: (408) 300-5121

PROJECT
LYDIKSEN
ELEMENTARY
SCHOOL
MODERNIZATION

PLEASANTON UNIFIED
SCHOOL DISTRICT
CONSULTANT

optimum
energy
design

Consulting Engineers
5515 Doyle Street
Suite 4
Emeryville, CA 94608
Telephone: (510) 837-9182

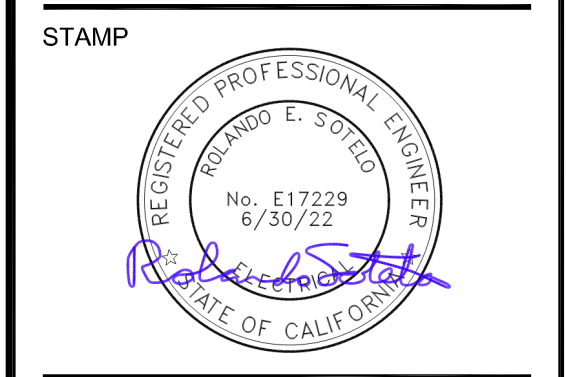


STATE
DSA FILE NUMBER 1-32
APPL # 01-119816

REVISIONS
ADDENDUM 2 04/15/2022

MILESTONES	
SD	06/28/2021
DD	08/23/2021
50% CD	09/20/2021
90% CD	10/14/2021
DSA SUB	10/21/2021

KEY PLAN
SIGNAL - BUILDING
C - NEW FLOOR
PLAN

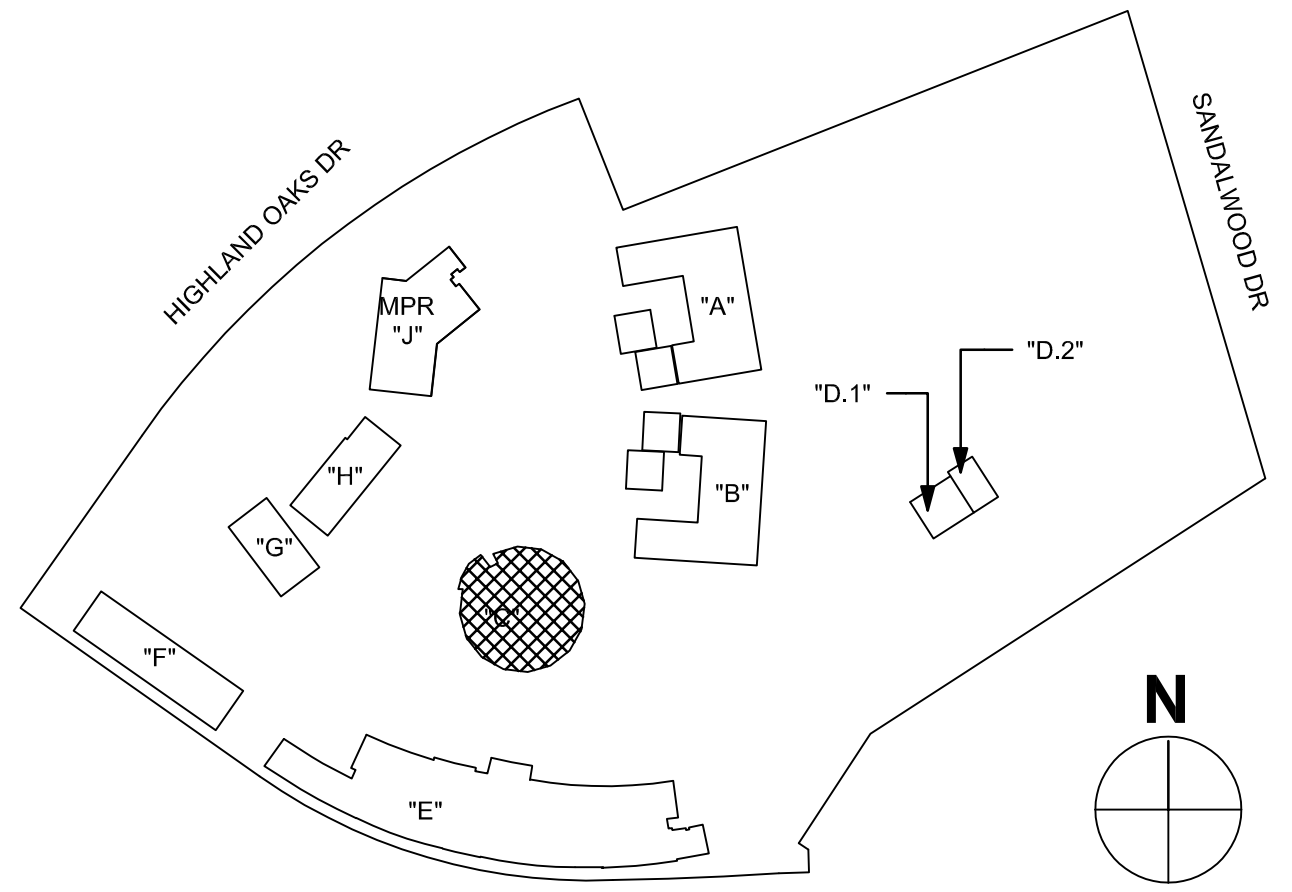

SIGNAL - BUILDING C - NEW FLOOR PLAN

3/16" = 1'-0"

1

DATE 10/21/2021
JOB # 2020029.02
SHEET # AD2-
EC2.2