



TMP ARCHITECTURE INC
 1391 WEST SQUARE LAKE ROAD
 BLOOMFIELD HILLS, MICHIGAN 48302
 PH: 248.338.4561 FX: 248.338.0223
 EM: INFO@TMP-ARCHITECTURE.COM

REGISTRATION SEAL

CONSULTANT



Peter Basso Associates Inc
 CONSULTING ENGINEERS
 5145 Livernois, Suite 100
 Troy, Michigan 48068-3276
 Tel: 248-879-5666
 Fax: 248-879-0007
 www.PeterBassoAssociates.com
 PBA Project No: 2022.0385

PROJECT TITLE

Wylie Elementary School

Dexter Community Schools

DRAWING TITLE

ELECTRICAL SITE PLAN

ISSUE DATES

DATE: _____ ISSUED FOR: _____

DRAWN: TLC

CHECKED: STP

APPROVED: STP

PROJECT NO.

22072


DRAWING NO.

E0.3



**Know what's below.
Call before you dig.**

Not For Construction

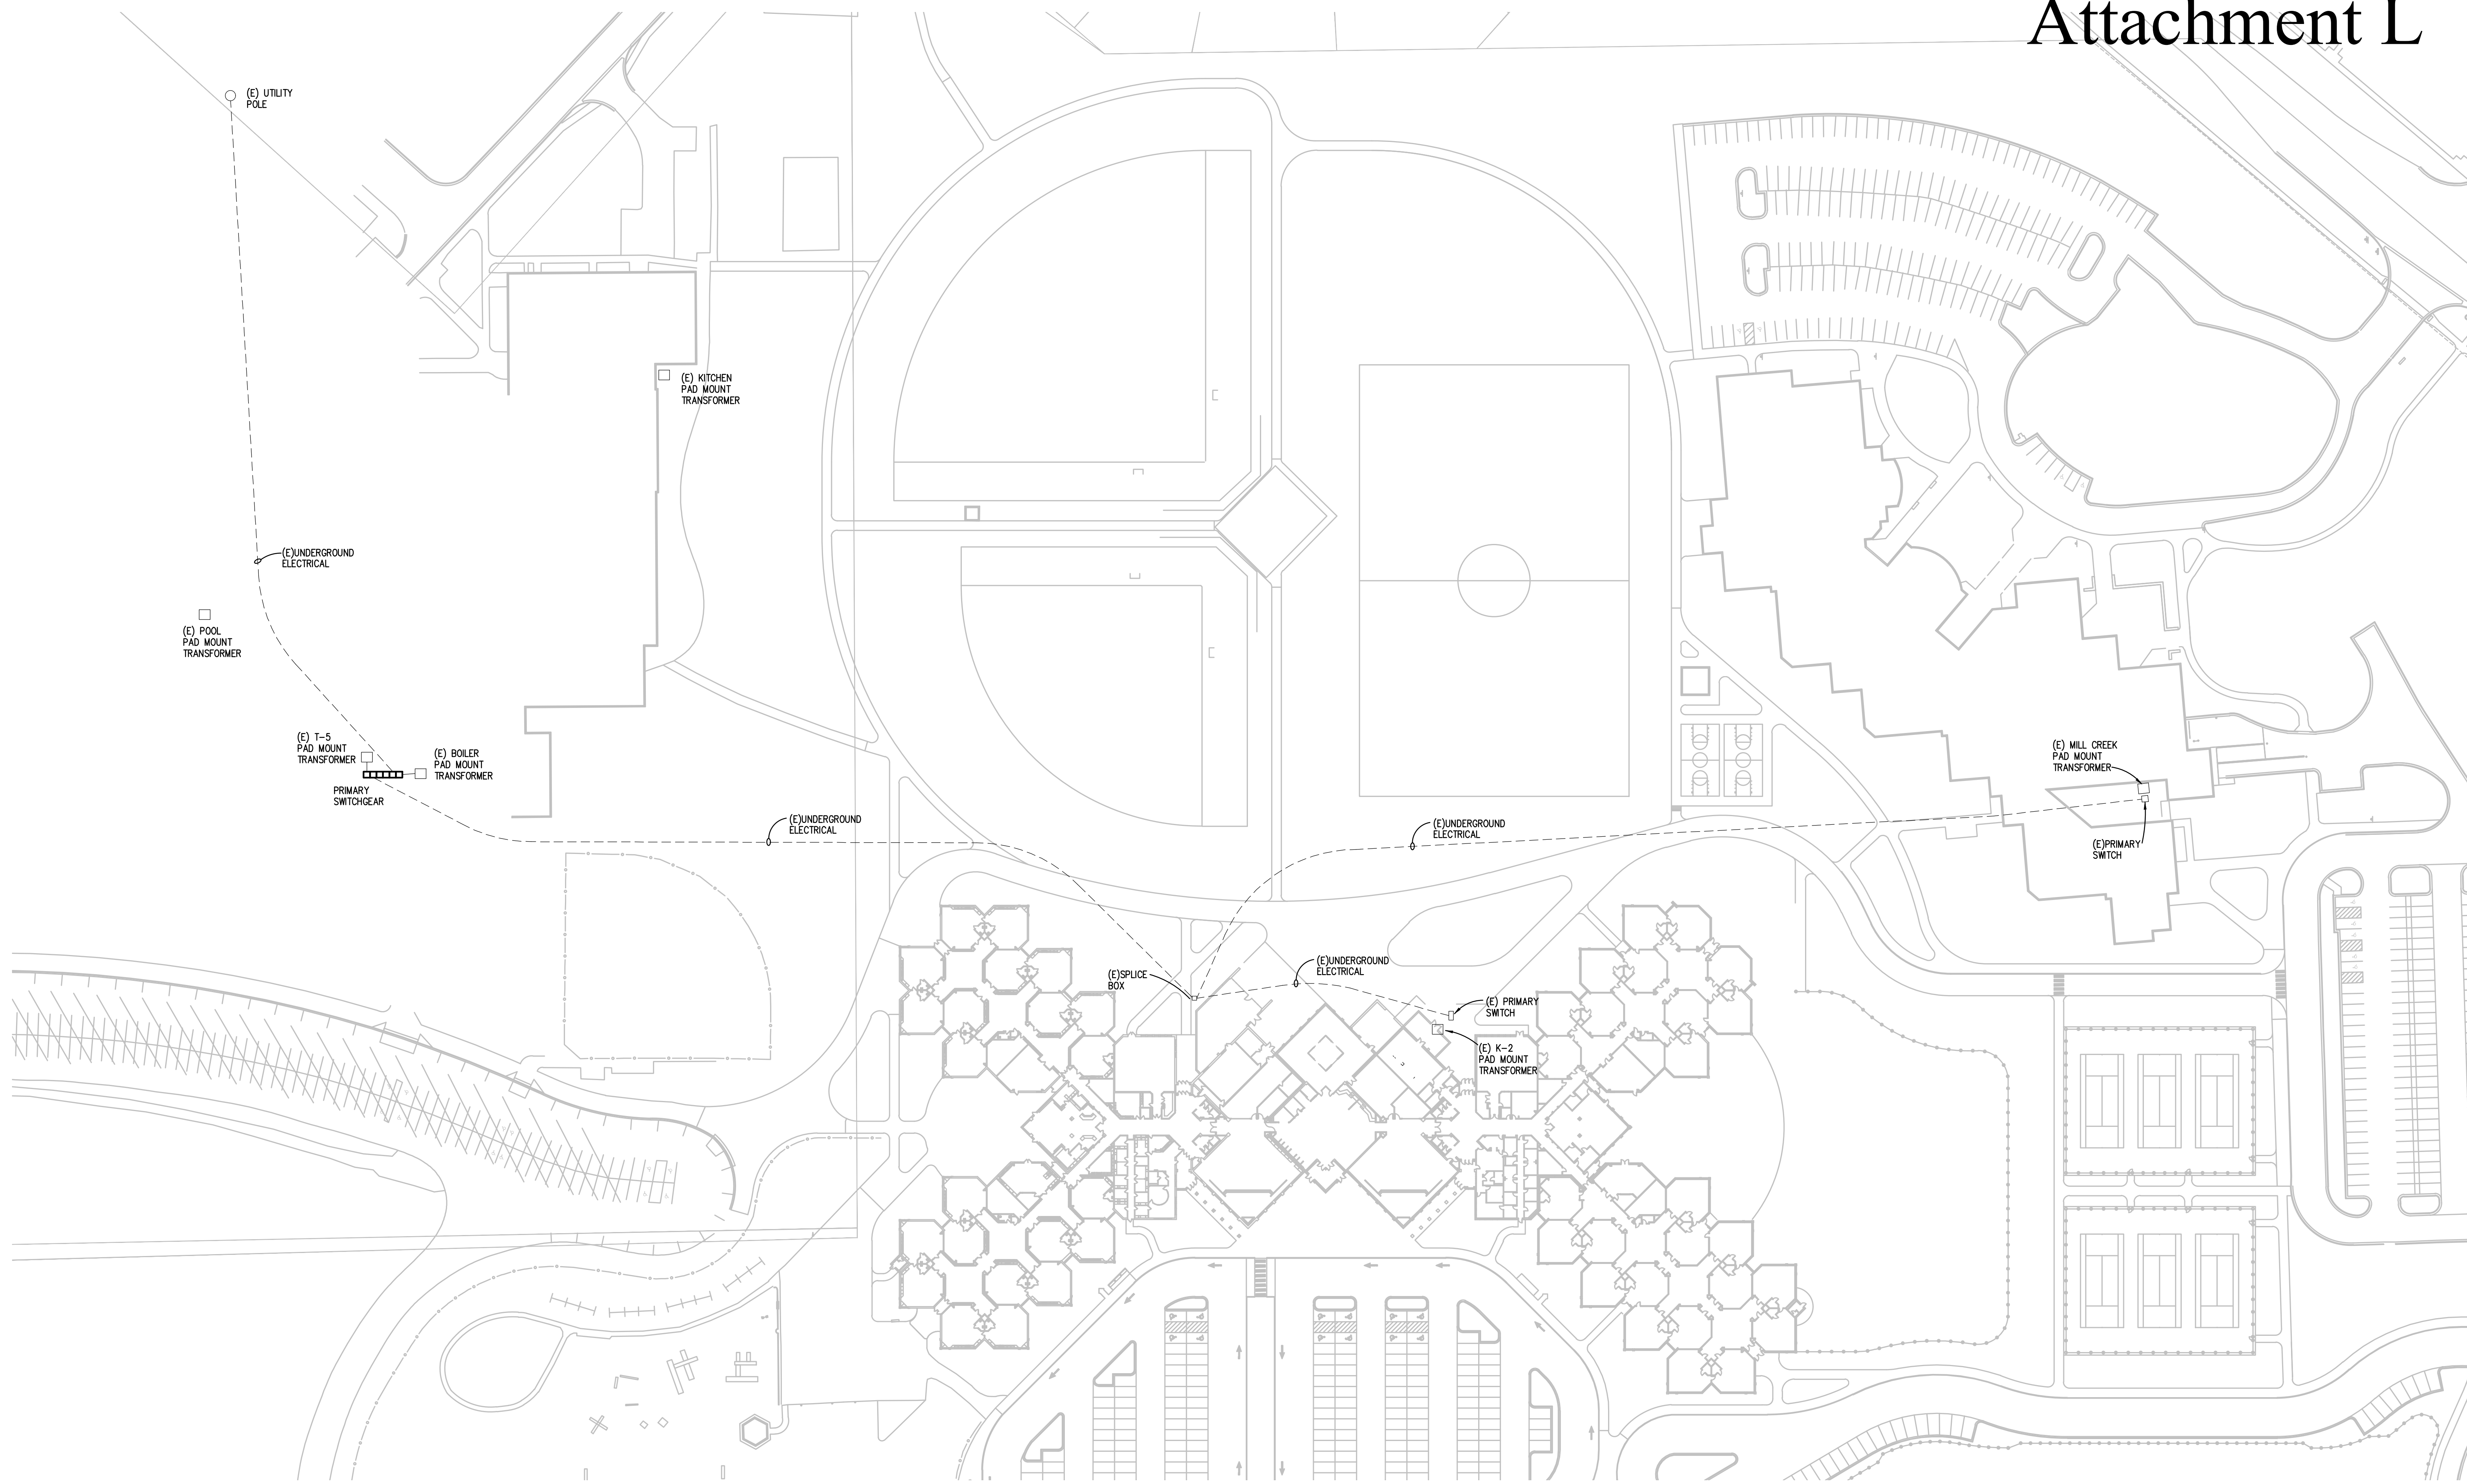

ELECTRICAL SITE PLAN
 SCALE: 1" = 60'

SITE PLAN GENERAL NOTES:

- THESE NOTES ARE GENERIC GUIDELINES ONLY. ELECTRICAL CONTRACTOR'S PERSONNEL ON SITE SHALL BE THOROUGHLY FAMILIAR WITH THE PUBLISHED SPECIFICATIONS FOR EXACT DESCRIPTIONS OF SCOPE, METHODS, AND MATERIAL.
- THESE DRAWINGS REPRESENT THE GENERAL EXTENT AND ARRANGEMENT OF SYSTEMS. COORDINATE EXACT EQUIPMENT LOCATIONS, ELEVATIONS, AND FINAL CONNECTION REQUIREMENTS. PROVIDE EACH SYSTEM COMPLETE, INCLUDING ALL NECESSARY COMPONENTS, FITTINGS AND OFFSETS.
- CONDUCT A SURVEY TO IDENTIFY ALL UNDERGROUND UTILITIES. CALL 811 PRIOR TO EXCAVATION.
- UTILITIES SHOWN ON THESE DRAWINGS ARE FOR REFERENCE ONLY. COORDINATE EXACT LOCATION OF ALL EXISTING UTILITIES, AND ROUTING OF ALL NEW UNDERGROUND UTILITIES PRIOR TO EXCAVATION.
- DEWATER TRENCHES PRIOR TO INSTALLATION OF CONDUITS. PROVIDE WATER TIGHT FITTINGS ON ALL UNDERGROUND CONDUITS.
- COORDINATE DEMOLITION WORK, AND ELECTRICAL AND TELEPHONE SERVICES TO THE SITE, WITH THE RESPECTIVE LOCAL UTILITY COMPANY REPRESENTATIVES PRIOR TO COMMENCEMENT OF WORK. INCLUDE ALL ASSOCIATED COSTS/FEE'S BY THE UTILITY COMPANIES IN THE BID PRICE.
- INSTALL UNDERGROUND CONDUITS 42" BELOW FINISHED GRADE, MINIMUM, UNLESS NOTED OTHERWISE.
- COORDINATE SERVICE SHUT-DOWNS WITH ALL TRADES INVOLVED ON SITE AND OBTAIN WRITTEN AUTHORIZATION FROM OWNER 72 HOURS PRIOR TO ANY ELECTRICAL AND/OR TELEPHONE SHUT-DOWN.
- REMOVE ALL DE-ENERGIZED CONDUCTORS FROM SITE AT COMPLETION OF THE PROJECT.
- OUTDOOR LIGHTING BRANCH CIRCUIT WIRING SHALL BE MINIMUM #8 AWG CONDUCTORS (XHHW-2), IN MINIMUM 1" DIA. CONDUIT, UNLESS NOTED OTHERWISE.
- SPARE CONDUITS SHALL INCLUDE PULL STRING AND SHALL BE TERMINATED WITH A CAP.
- EXCAVATE THE ENTIRE LENGTH OF TRENCH TO PROPERLY SET DUCT ELEVATIONS.

CONSTRUCTION KEY NOTES:

- xxx
- xxx