

10/7/2016 11:33 AM


D

C

B

A

C:\Users\mfe\Documents\16102_001\16102_001.dwg

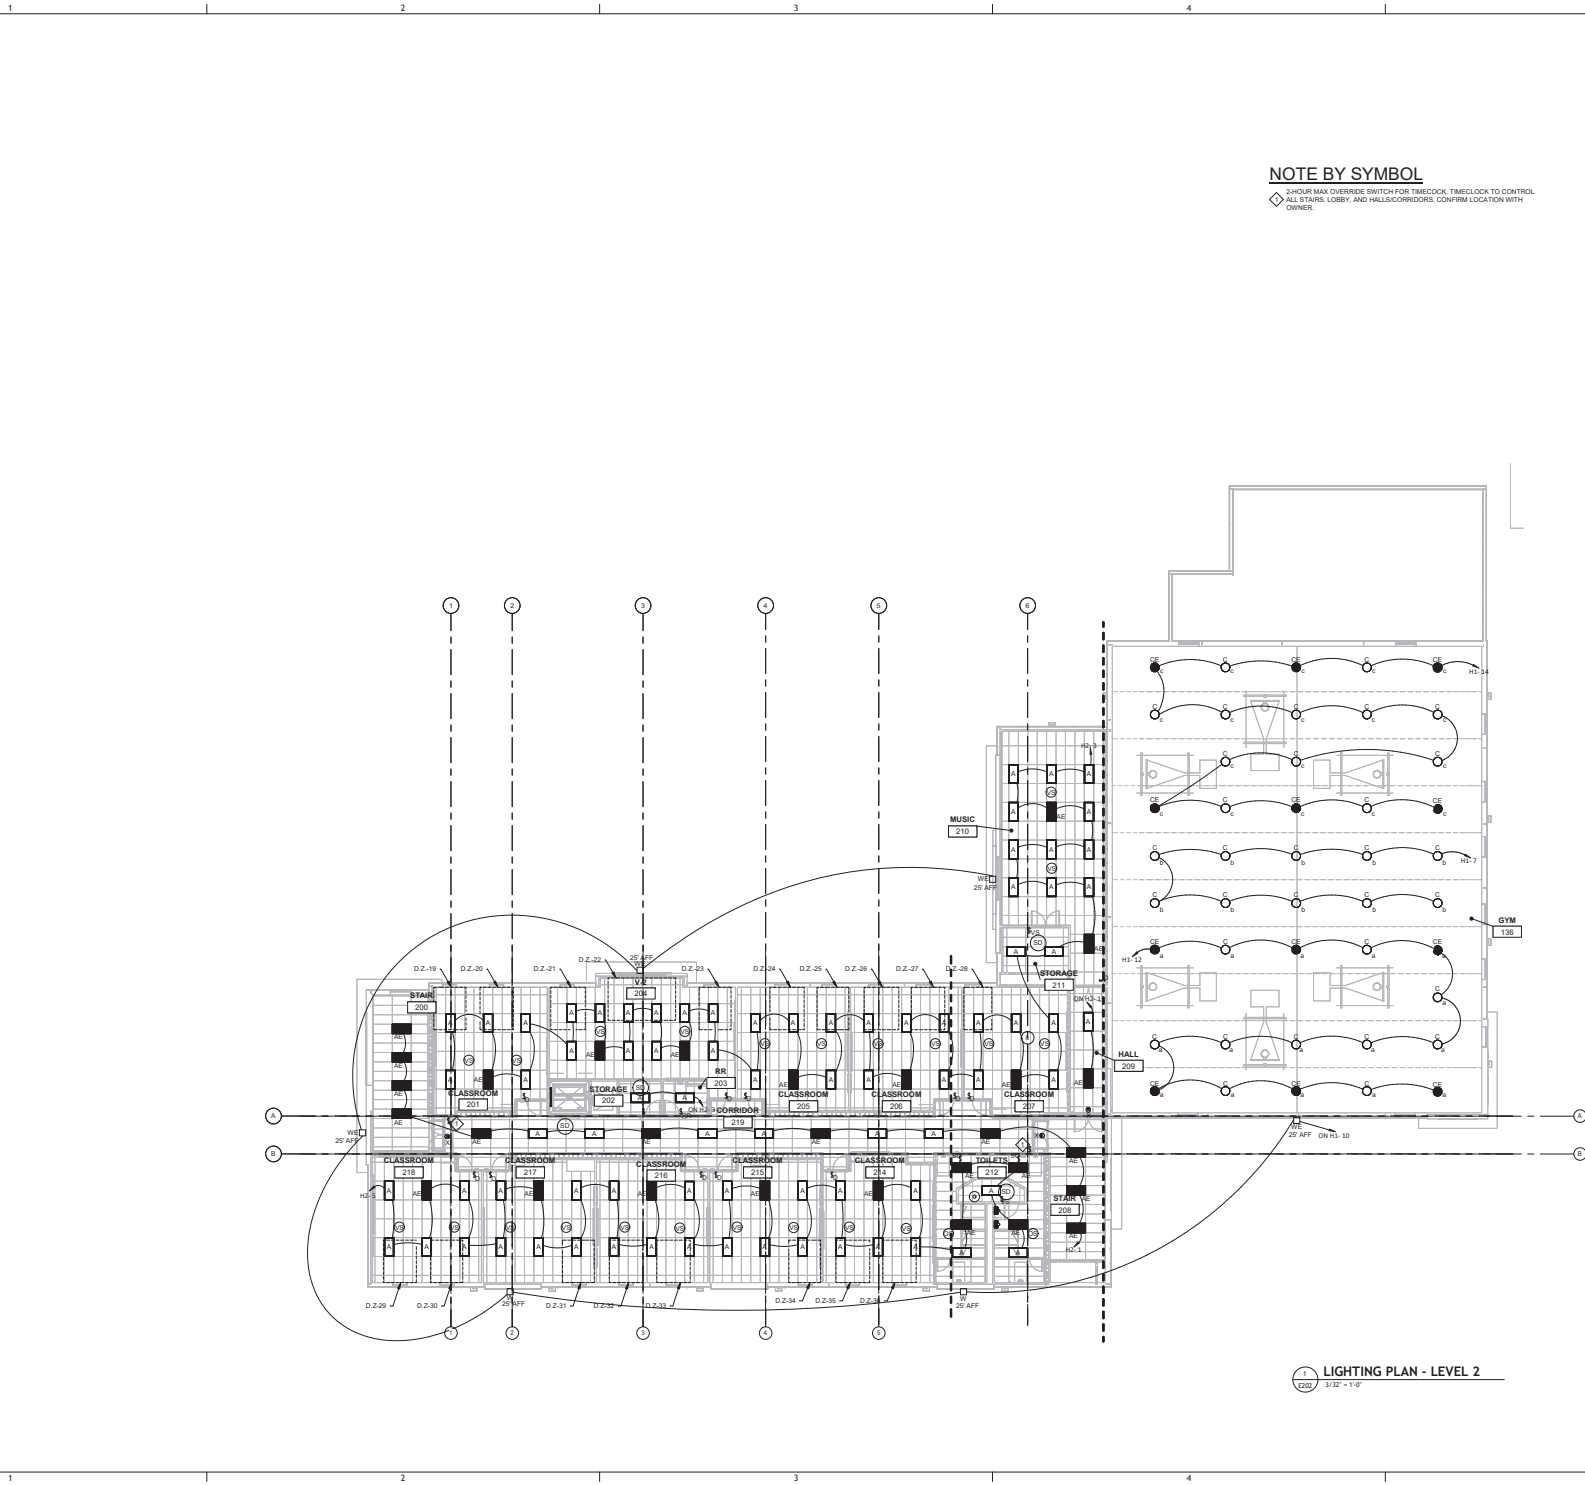

NOTE BY SYMBOL

◇ 24-HOUR MAX OVERRIDE SWITCH FOR TIMECLOCK. TIMECLOCK TO CONTROL ALL STAIR, LOBBY, AND HALLS/CORRIDORS. CONFIRM LOCATION WITH OWNER.

1 LIGHTING PLAN - LEVEL 2
200 1/2" = 1'-0"

MUSSMAN
ARCHITECTS

610 N. Ninth Street
Greenville, SC 29601
P.O. Box 10335
Greenville, SC 29615
www.mussmanarchitects.com

LINDSEY E. TURNER, P.E.
Professional Engineer
No. 12345
State of South Carolina
Expires 12/31/2018



TCCA HIGH SCHOOL BUILDING
1400 SE LOWE RD.
STUART FLORIDA 3497

NO.	DATE	DESCRIPTION	BY

PRINCIPAL IN CHARGE: _____ Approver: _____
PROJECT ARCHITECT: _____ Checker: _____
DRAWN BY: _____ Author: _____

SHEET TITLE:
LIGHTING PLAN - LEVEL 2

SHEET NO. _____ PROJ. NO. 022004

E202