

10/27/2016 11:14:44 AM


D

C

B

A

C:\Users\mturner\Documents\16105\_HVAC\_Plan\_Level\_2.dwg

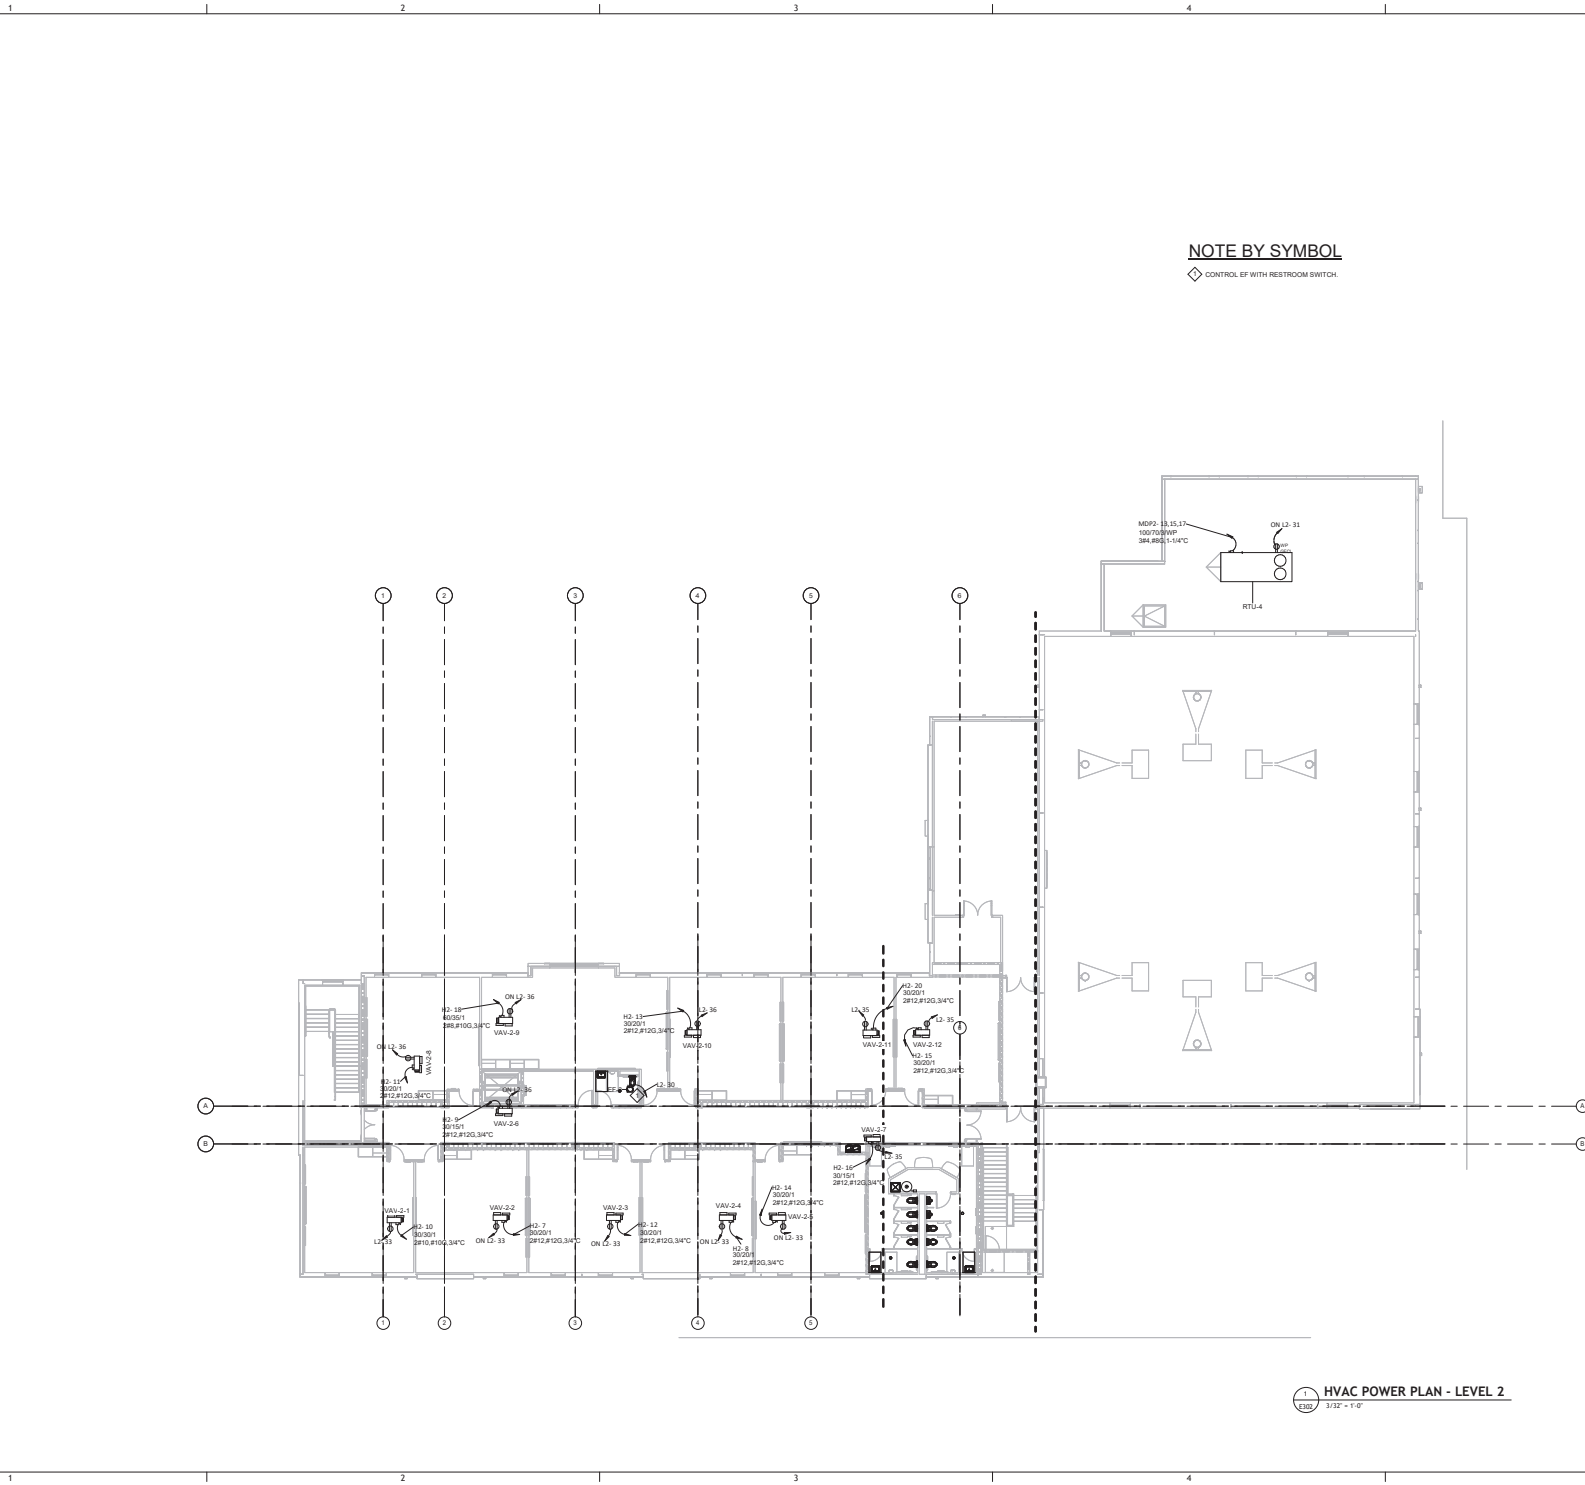

**NOTE BY SYMBOL**  
 ◇ CONTROL EF WITH RESTROOM SWITCH

**HVAC POWER PLAN - LEVEL 2**  
 1/32" = 1'-0"

**MUSSMAN ARCHITECTS**  
 610 N. Walsh Street  
 Greenville, SC 29601  
 P.O. Box 1030336 Greenville, SC 29603  
 www.mussmanarchitects.com

PROJECT: TCCA HS - LEVEL 2  
 DATE: 10/27/16  
 DRAWN BY: MTURNER  
 CHECKED BY: JTURNER  
 PROJECT ENGINEER  
 JAMES F. TURNER, P.E.  
 LICENSE NO. 72441  
 STATE OF SOUTH CAROLINA



**TCCA HIGH SCHOOL BUILDING**  
 1400 SE COWIE RD.  
 STUART FLORIDA 34997

SHEET ISSUE:	NO.	DATE	DESCRIPTION	BY

PRINCIPAL IN CHARGE: JTURNER  
 PROJECT ARCHITECT: MTURNER  
 DRAWING: JTURNER

**HVAC TITLE:**  
 HVAC POWER PLAN - LEVEL 2

SHEET NO. 022004  
 PROJ. NO. 16105

**E302**