


10/27/2018 11:14:44 AM

D

C

B

A

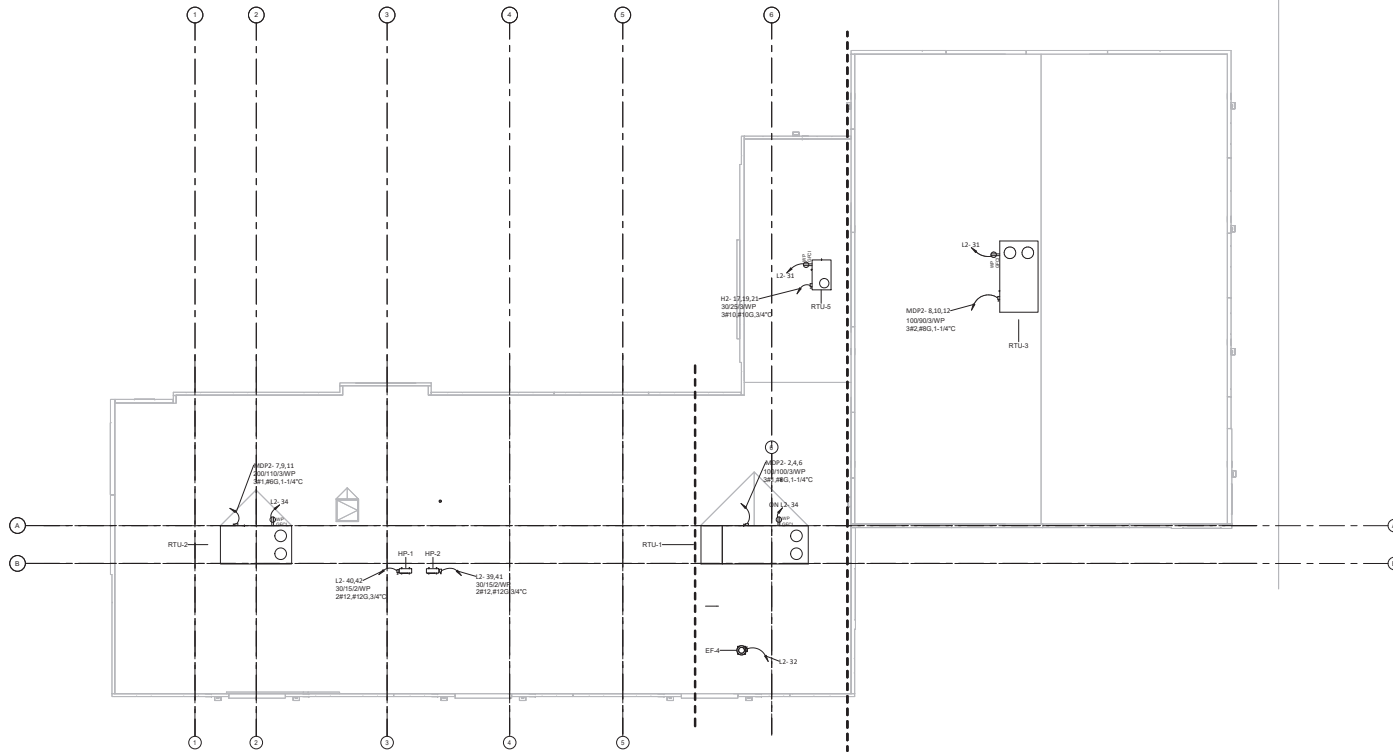

POWER PLAN ROOF  
1/32" = 1'-0"



**TCCA HIGH SCHOOL BUILDING**  
1400 SE COWE RD  
STUART FLORIDA, 34997

SHEET ISSUE:		
NO.	DATE	DESCRIPTION

PRINCIPAL IN CHARGE	APPROVER
PROJECT ARCHITECT	CHECKER
DRAWN BY	AUTHOR

SHEET TITLE:  
**POWER PLAN - ROOF**

SHEET NO.	PROJ. NO.
<b>E303</b>	022004