



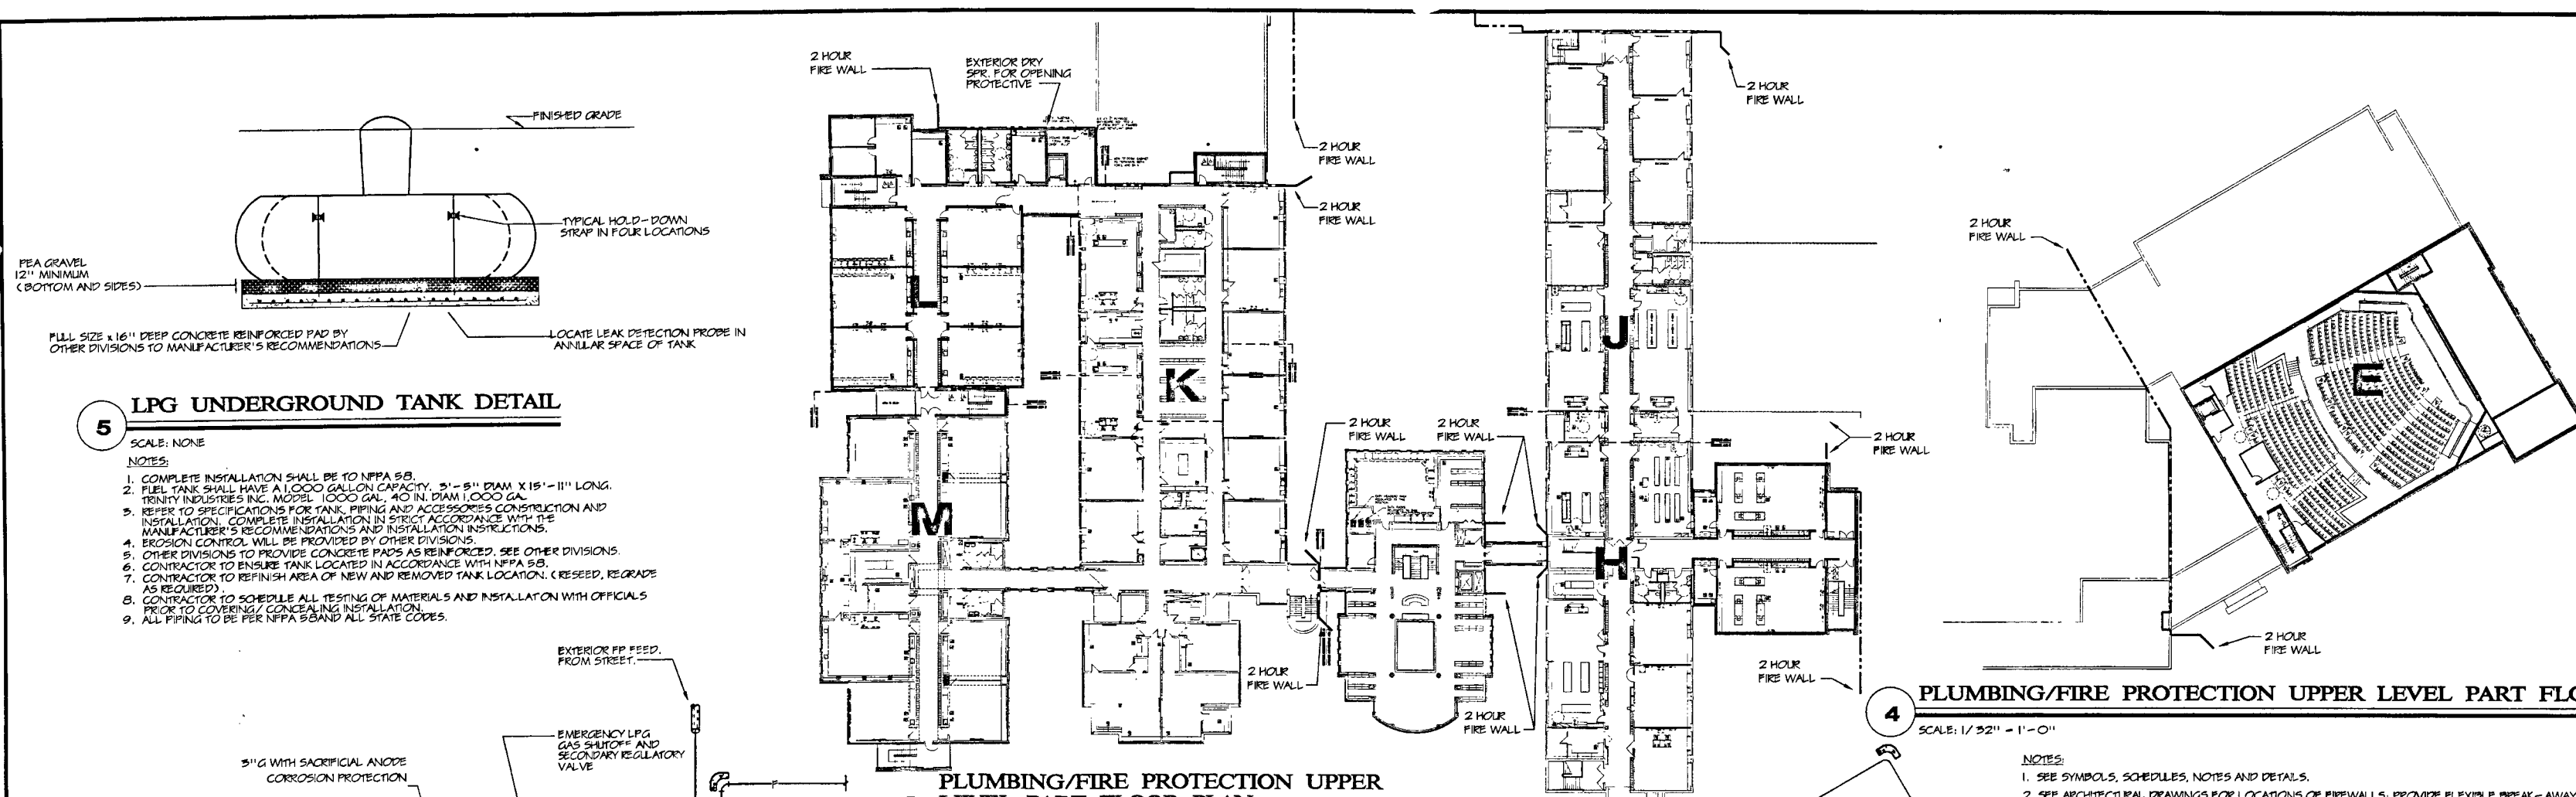

4 PLUMBING/FIRE PROTECTION UPPER LEVEL PART FLOOR PLAN
SCALE: 1/32" = 1'-0"


NOTES:
1. SEE SYMBOLS, SCHEDULES, NOTES AND DETAILS.
2. SEE ARCHITECTURAL DRAWINGS FOR LOCATIONS OF FIREWALLS; PROVIDE FLEXIBLE BREAK-AWAY CONNECTIONS EACH SIDE OF FIREWALL IN AN APPROVED MANNER. MAINTAIN ALL ROOF PENETRATIONS AT LEAST 10'-0" CLEAR OF FIRE WALLS.
3. NOT SHOWN IS CATWALK ABOVE STAGE AND ORCHESTRA AREA. SEE ARCHITECTURAL DRAWINGS.

5 LPG UNDERGROUND TANK DETAIL
SCALE: NONE
NOTES:
1. COMPLETE INSTALLATION SHALL BE TO NFPA 58.
2. FUEL TANK SHALL HAVE A 1000 GALLON CAPACITY, 5'-5" DIAM X 15'-11" LONG, TRINITY INDUSTRIES INC. MODEL 1000 GAL. 40 IN. DIAM 1000 GAL.
3. REFER TO SPECIFICATIONS FOR TANK, PIPING AND ACCESSORIES CONSTRUCTION AND INSTALLATION. COMPLETE INSTALLATION IN STREET ACCORDANCE WITH THE MANUFACTURER'S RECOMMENDATIONS AND INSTALLATION INSTRUCTIONS.
4. EROSION CONTROL SHALL BE PROVIDED BY OTHER DIVISIONS.
5. OTHER DIVISIONS TO PROVIDE CONCRETE PADS AS REINFORCED. SEE OTHER DIVISIONS.
6. CONTRACTOR TO ENSURE TANK LOCATED IN ACCORDANCE WITH NFPA 58.
7. CONTRACTOR TO REFINISH AREA OF NEW AND REMOVED TANK LOCATION. (RESEED, REGRADE AS REQUIRED).
8. CONTRACTOR TO SCHEDULE ALL TESTING OF MATERIALS AND INSTALLATION WITH OFFICIALS PRIOR TO COVERING/CONCRETE INSTALLATION.
9. ALL PIPING TO BE PER NFPA 58 AND ALL STATE CODES.

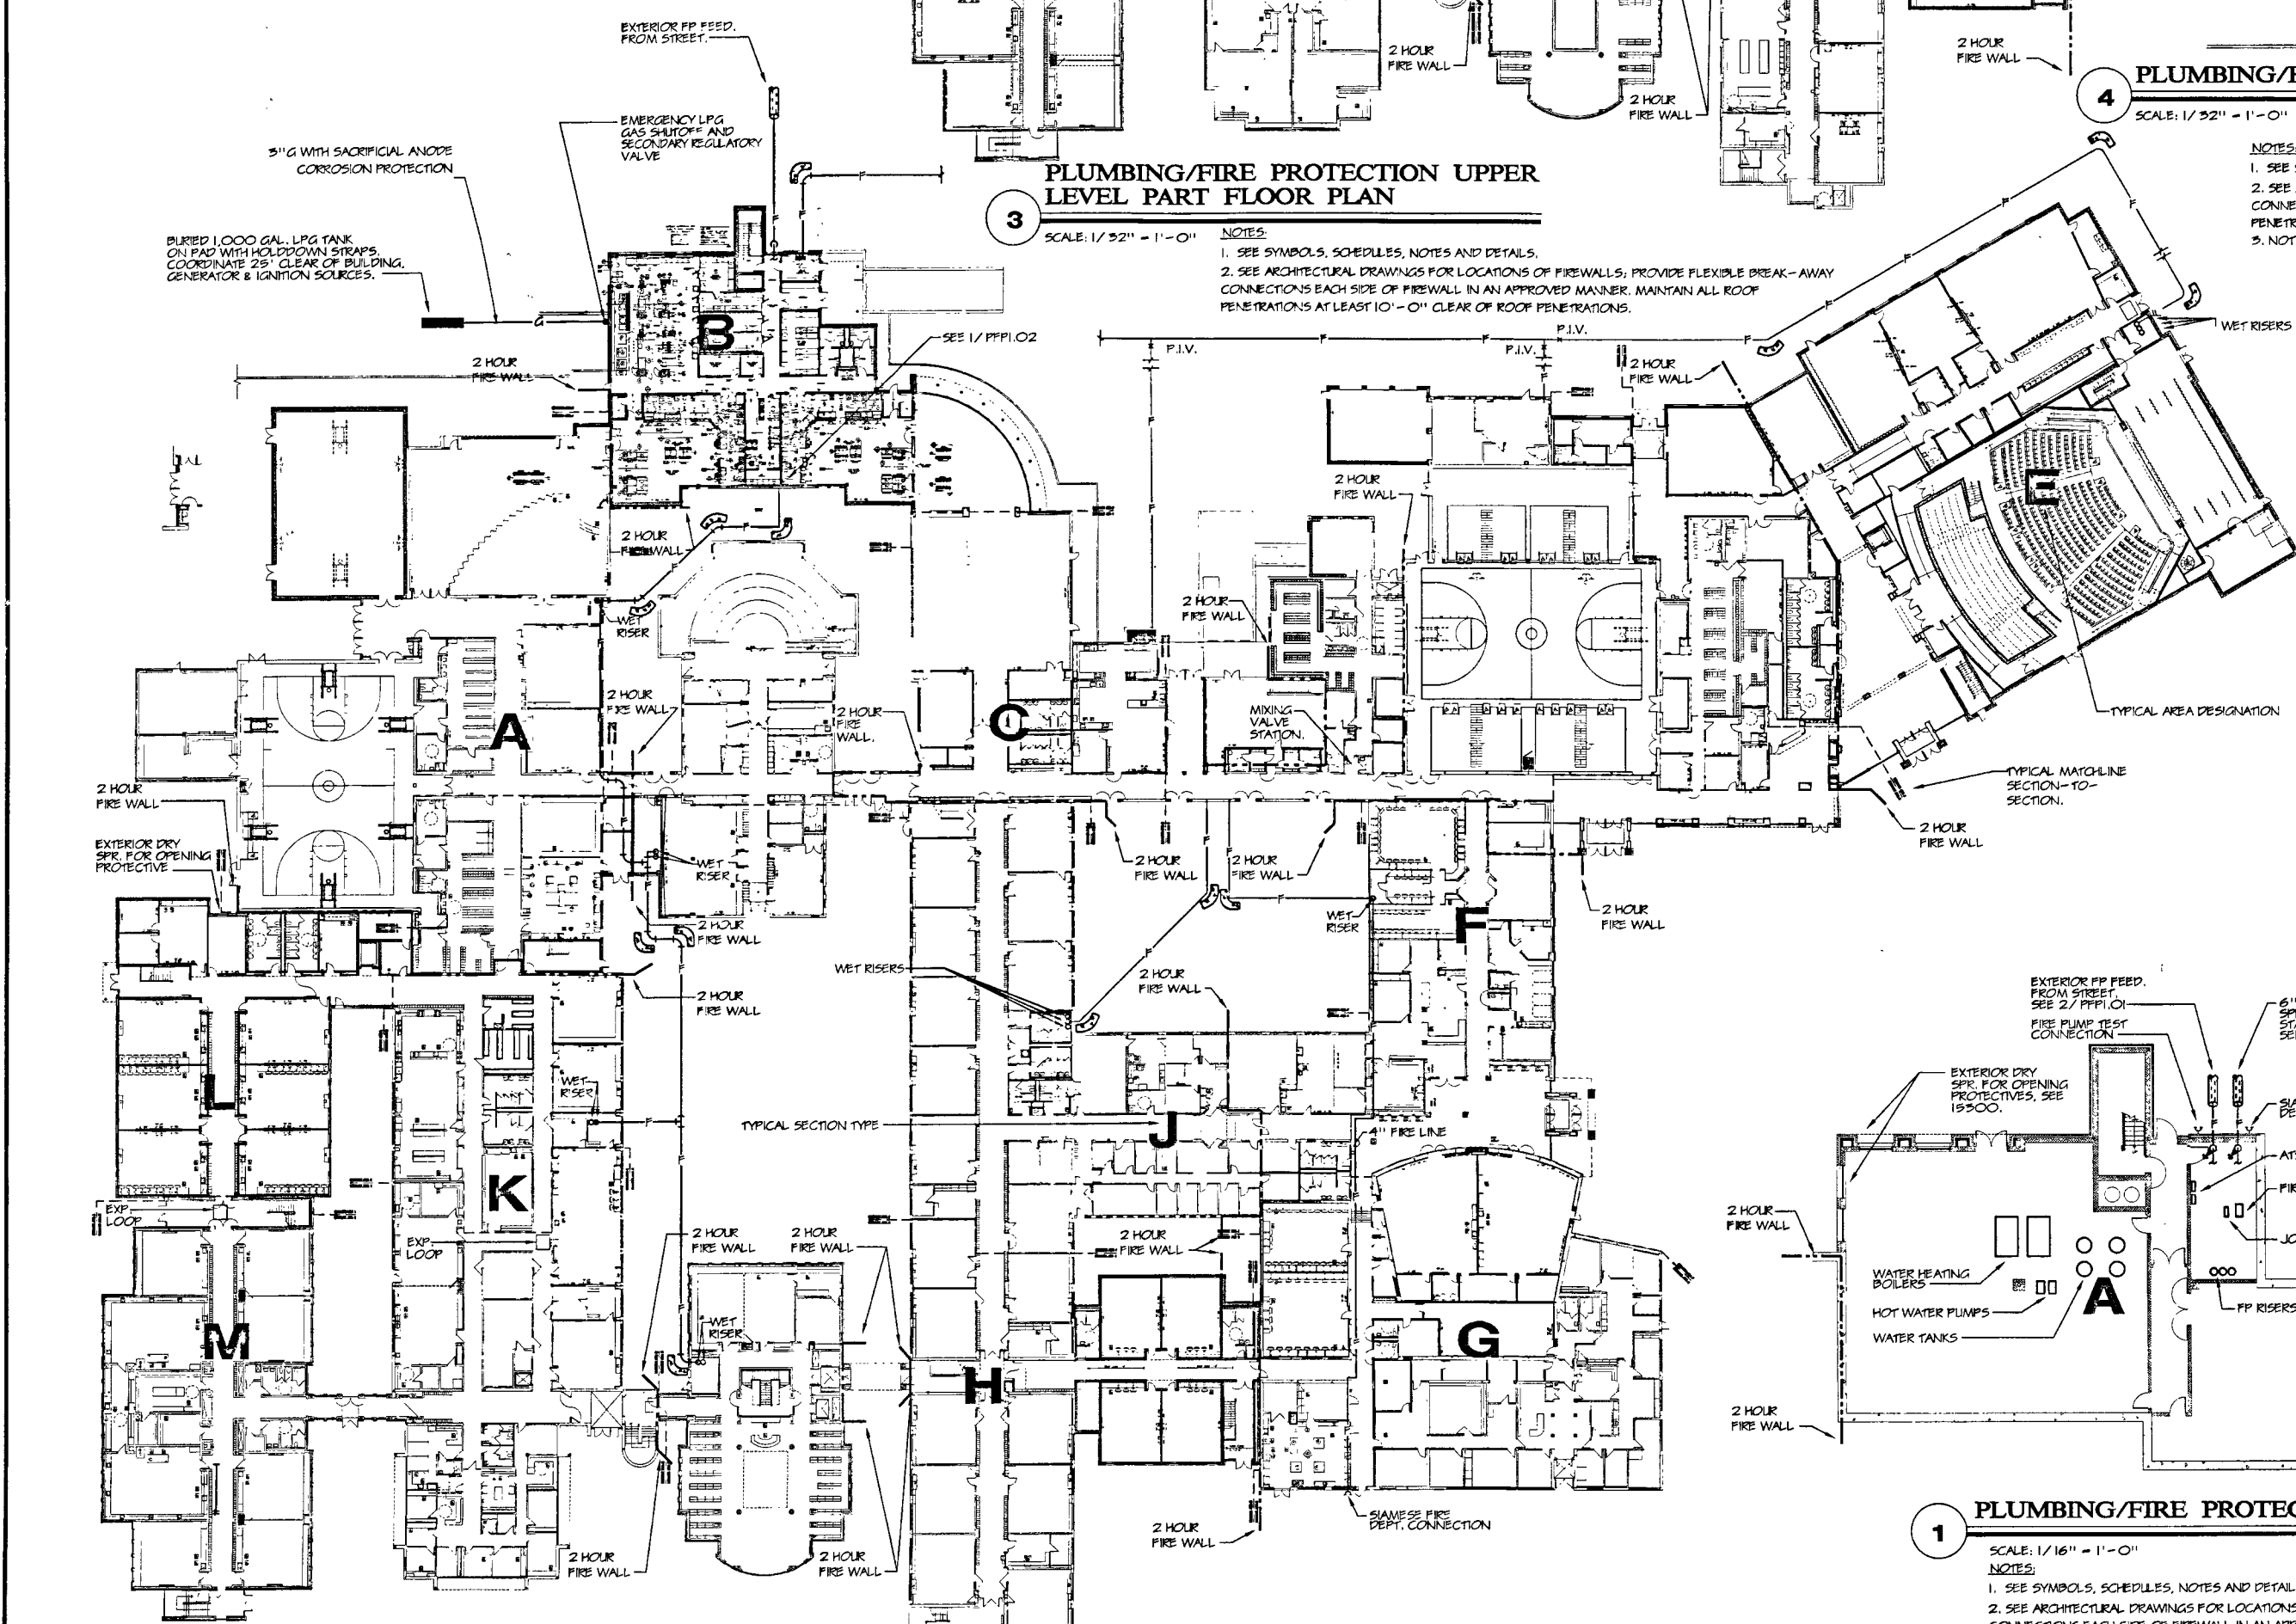

2 PLUMBING/FIRE PROTECTION MAIN LEVEL FLOOR PLAN
SCALE: 1/32" = 1'-0"

NOTES:
1. SEE SYMBOLS, SCHEDULES, NOTES AND DETAILS.
2. SEE ARCHITECTURAL DRAWINGS FOR LOCATIONS OF FIREWALLS; PROVIDE FLEXIBLE BREAK-AWAY CONNECTIONS EACH SIDE OF FIREWALL IN AN APPROVED MANNER. MAINTAIN ALL ROOF PENETRATIONS AT LEAST 10'-0" CLEAR OF FIRE WALLS.

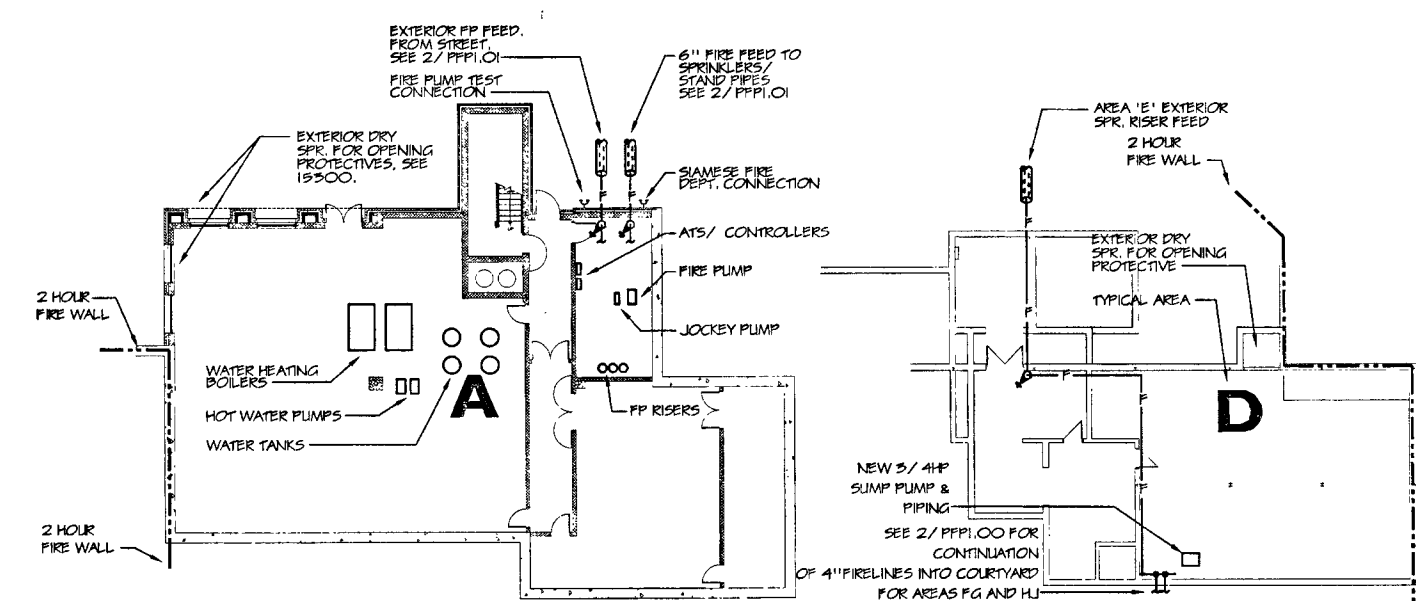

1 PLUMBING/FIRE PROTECTION LOWER LEVEL PART FLOOR PLANS
SCALE: 1/16" = 1'-0"

NOTES:
1. SEE SYMBOLS, SCHEDULES, NOTES AND DETAILS.
2. SEE ARCHITECTURAL DRAWINGS FOR LOCATIONS OF FIREWALLS; PROVIDE FLEXIBLE BREAK-AWAY CONNECTIONS EACH SIDE OF FIREWALL IN AN APPROVED MANNER. MAINTAIN ALL ROOF PENETRATIONS AT LEAST 10'-0" CLEAR OF FIRE WALLS.

DATE	MARK	DESCRIPTION
NOVEMBER 22, 2004		PHASE 1 DRAWINGS ISSUED FOR STATE DEPARTMENT OF EDUCATION REVIEW
MARCH 1, 2005		ISSUED FOR BIDDING/CONSTRUCTION PURPOSES




RENOVATIONS AND ADDITIONS TO THE REGIONAL SCHOOL DISTRICT 10 LEWIS S. MILLS HAR-BUR COMPLEX
24/26 LYON ROAD
BURLINGTON, CT 06013

STATE PROJECT NO. 210-0036

WALTER MCILVEEN ASSOCIATES, INC.
CONSULTING ENGINEERS
195 WEST MAIN STREET
AVON, CT 06001-0516

DRAWING IS PROVIDED FOR SITE WORK REFERENCE ONLY. ALL PIPING TO BE PART OF PHASE 5.

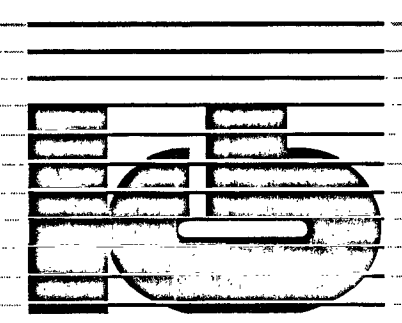


KAESTLE BOOS ASSOCIATES, INC.
418 SOUTH MAIN STREET, NEW BRUNSWICK, NJ 08901 (609) 728-3861
100 GROVE STREET, SUITE 215, FRANKLIN, MA 02038 (508) 326-9828
117 NEW HAMPSHIRE AVE., SUITE 125, PORTSMOUTH, NH 03801 (603) 706-1865

DRAWN BY: JML
CHECKED BY: AHC
SCALE: AS NOTED

PLUMBING/FIRE PROTECTION FLOOR PLANS

PROJECT NO.: 04000/48114 DRAWING NO.:

DATE: NOVEMBER 15, 2004 **PFP1.00**

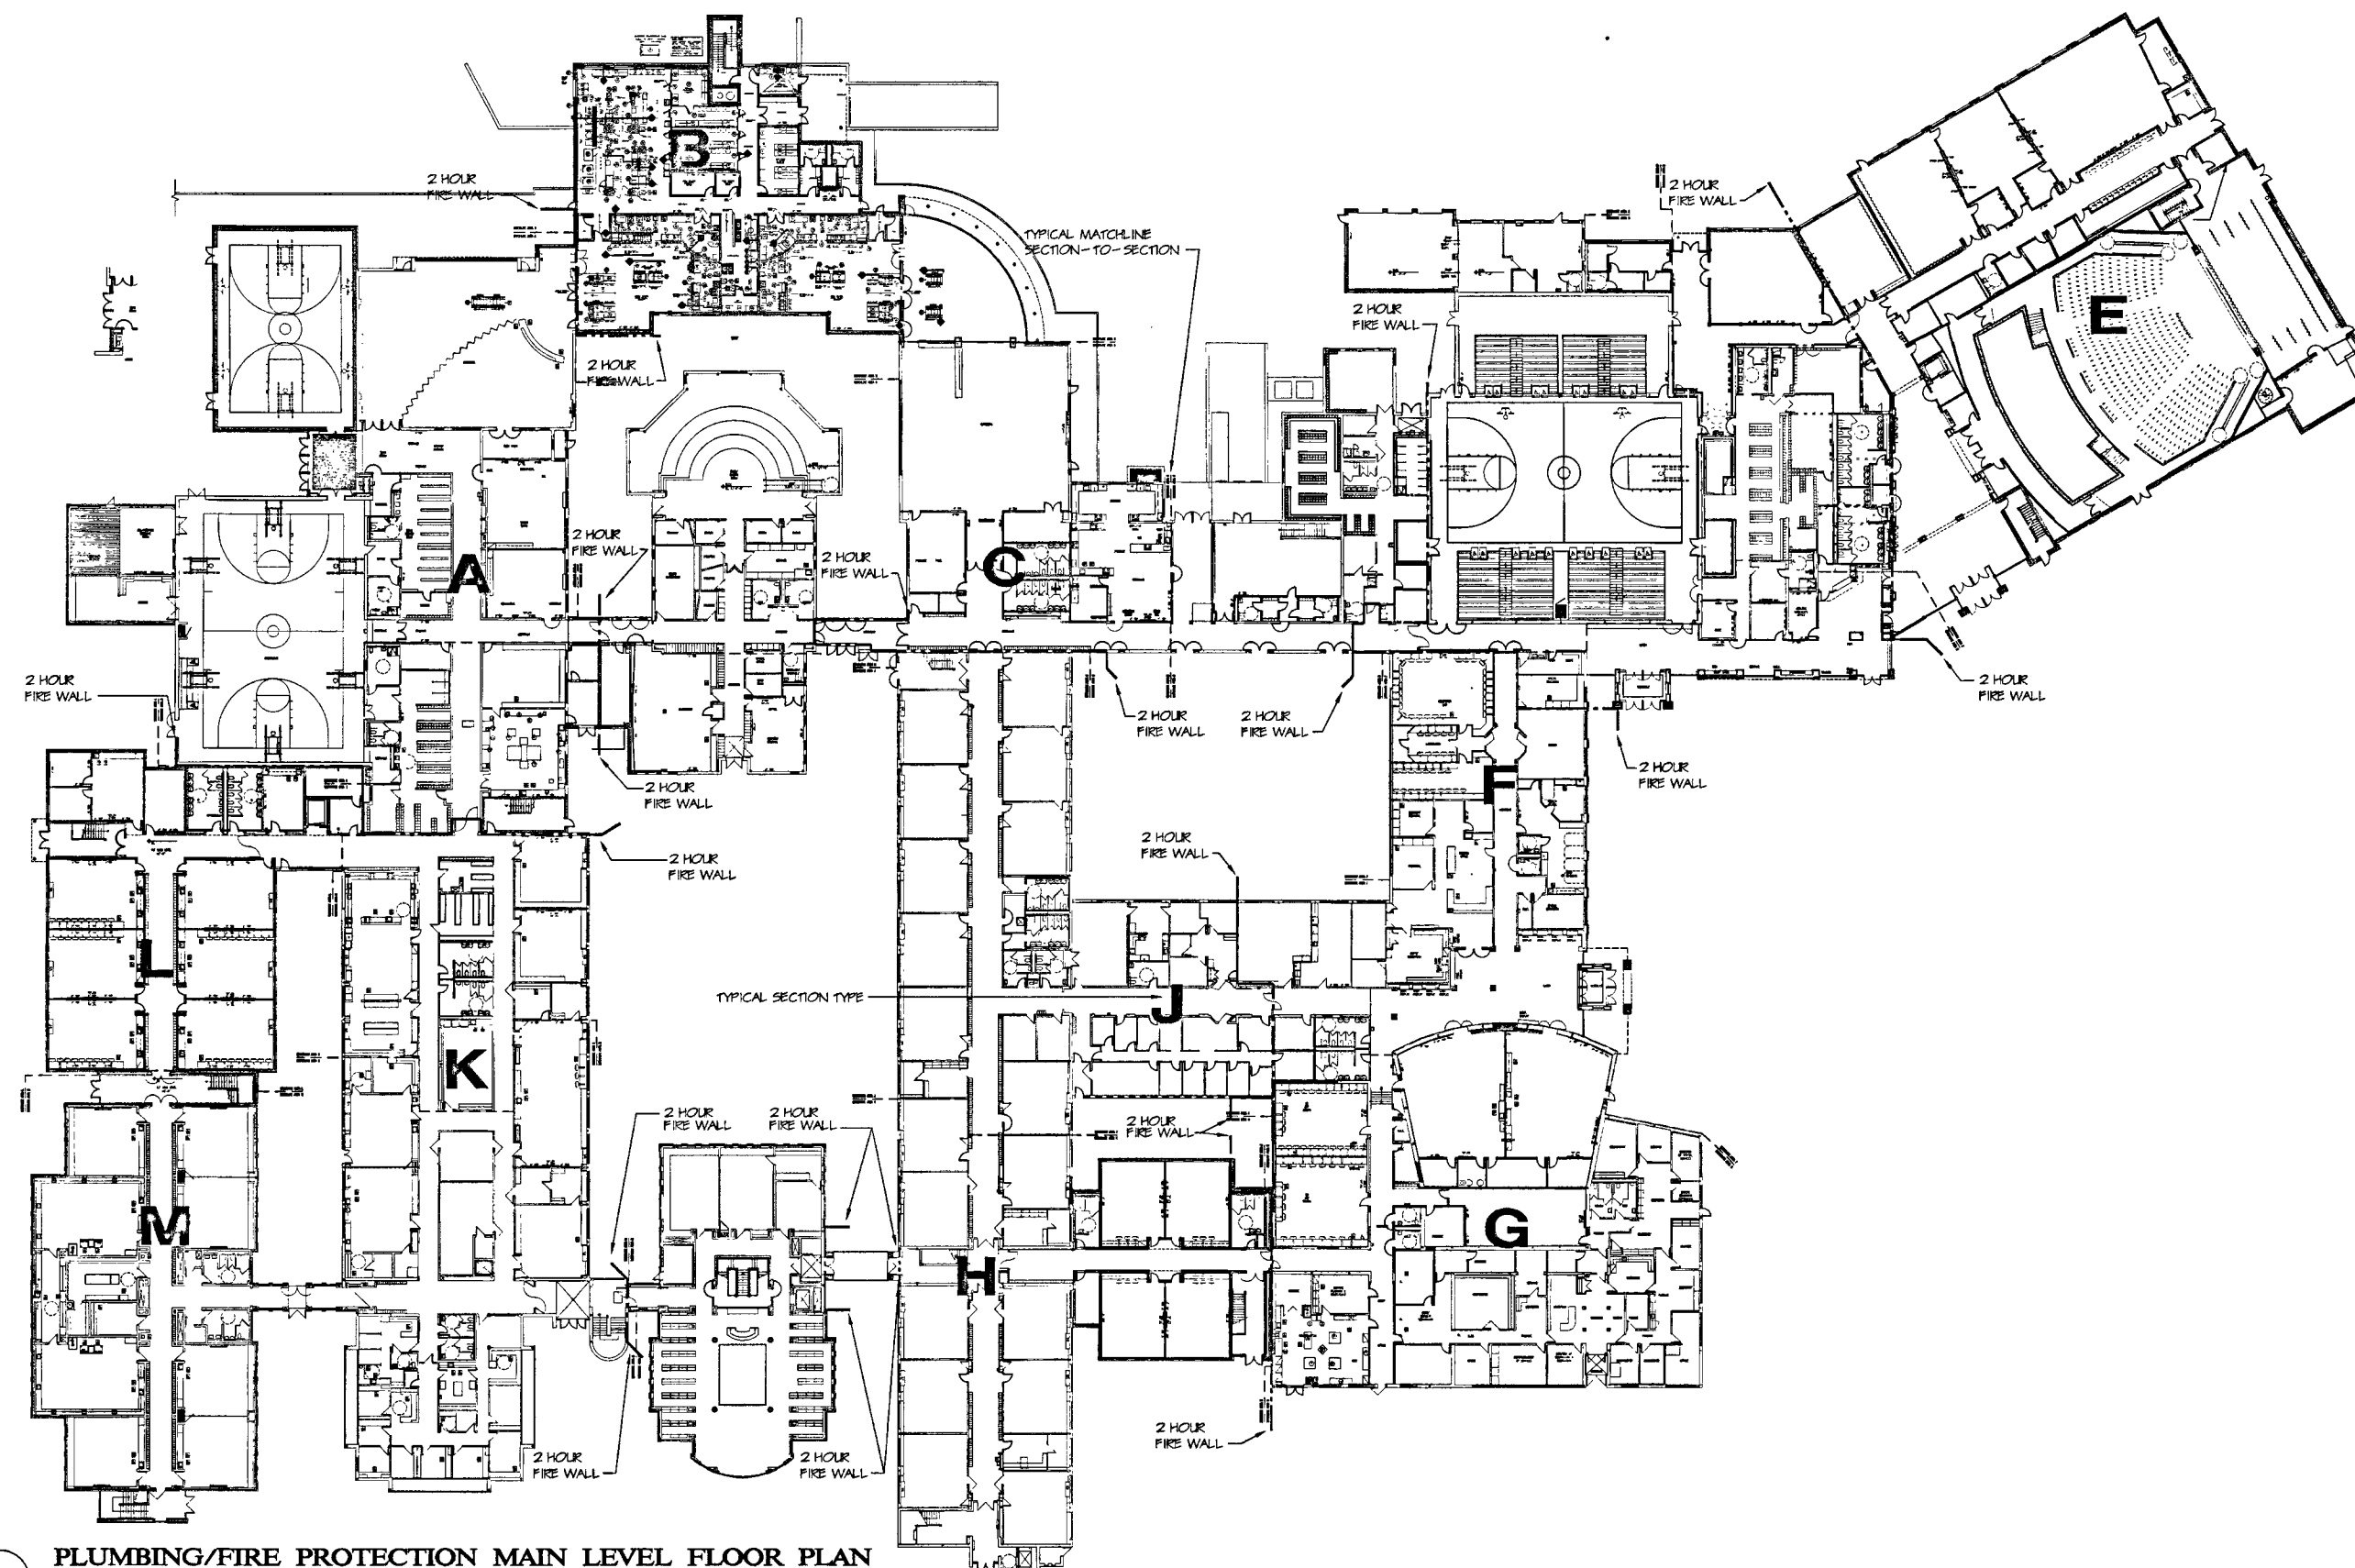


2 PLUMBING/FIRE PROTECTION MAIN LEVEL FLOOR PLAN

SCALE: 1/32" = 1'-0"

NOTES:

1. SEE SYMBOLS, SCHEDULES, NOTES AND DETAILS.

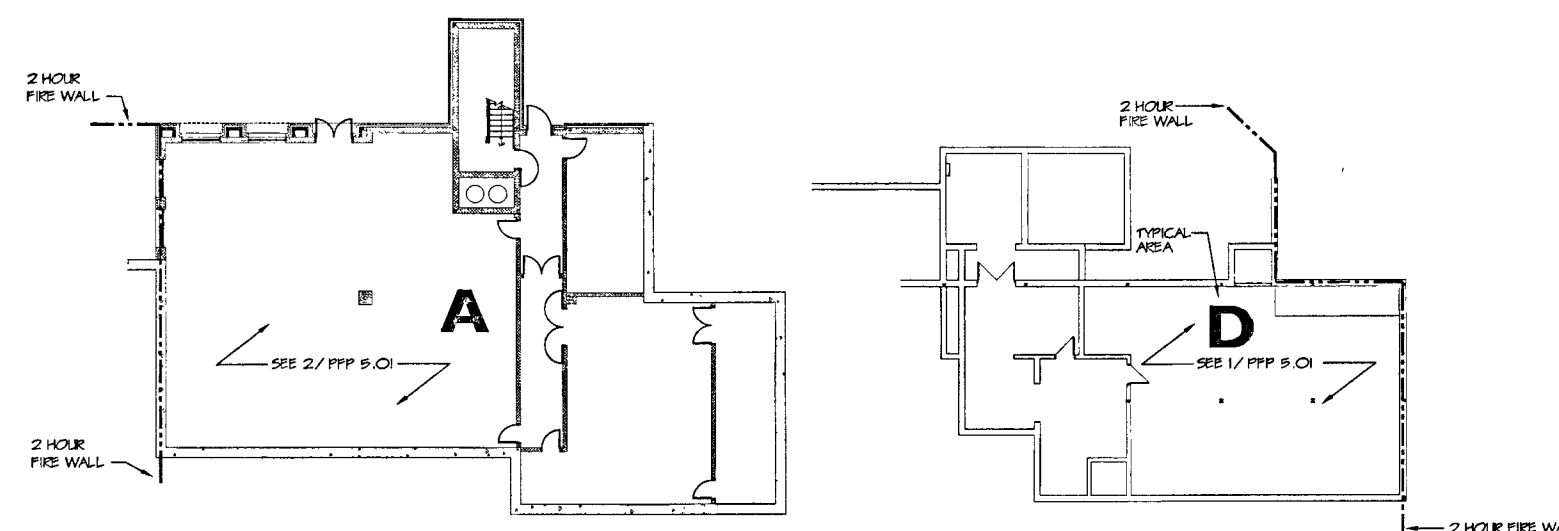

1 PLUMBING/FIRE PROTECTION LOWER LEVEL PART FLOOR PLANS


SCALE: 1/16" = 1'-0"

NOTES:

1. SEE SYMBOLS, SCHEDULES, NOTES AND DETAILS.


CONTRACTOR TO NOTE

DRAWING IS PROVIDED FOR SITE WORK ONLY.
ALL ROOFTOP EQUIPMENT TO BE PART OF PHASE 3.

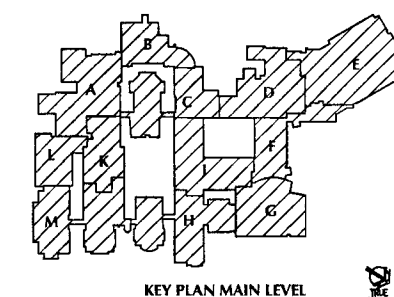

KEY PLAN MAIN LEVEL

DATE	MARK	REVISIONS	DESCRIPTION
MARCH 1, 2005			ISSUED FOR BIDDING AND CONSTRUCTION PURPOSES (FOR REFERENCE ONLY AS PHASE I)

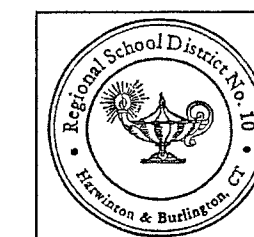


RENOVATIONS AND ADDITIONS TO THE REGIONAL SCHOOL DISTRICT 10 LEWIS S. MILLS HAR-BUR COMPLEX

24/26 LYON ROAD
BURLINGTON, CT 06013

STATE PROJECT NO. 210-0036

WALTER MCILVEEN ASSOCIATES, INC.
CONSULTING ENGINEERS
195 WEST MAIN STREET
AVON, CT 06001-0516

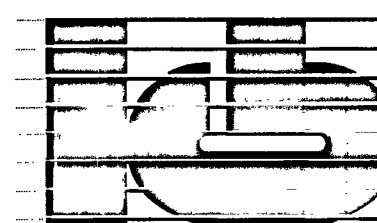

KAESTLE BOOS ASSOCIATES, INC.

418 SLATER RD., NEW BRITAIN, CT 06050 (860) 258-2061
124 CHASE ST., SUITE 210, FARMINGTON, CT 06030 (860) 500-0025
11 NEW HAMPSHIRE AVE., SUITE 125, PORTSMOUTH, NH 02871 (603) 795-1985



DRAWN BY: JML
CHECKED BY: AMC
SCALE: AS NOTED

PLUMBING/FIRE PROTECTION UNDERGROUND FLOOR PLANS


PROJECT NO.: 04000/48114

DRAWING NO.:

DATE: JANUARY 28, 2005 **PPF5.00**

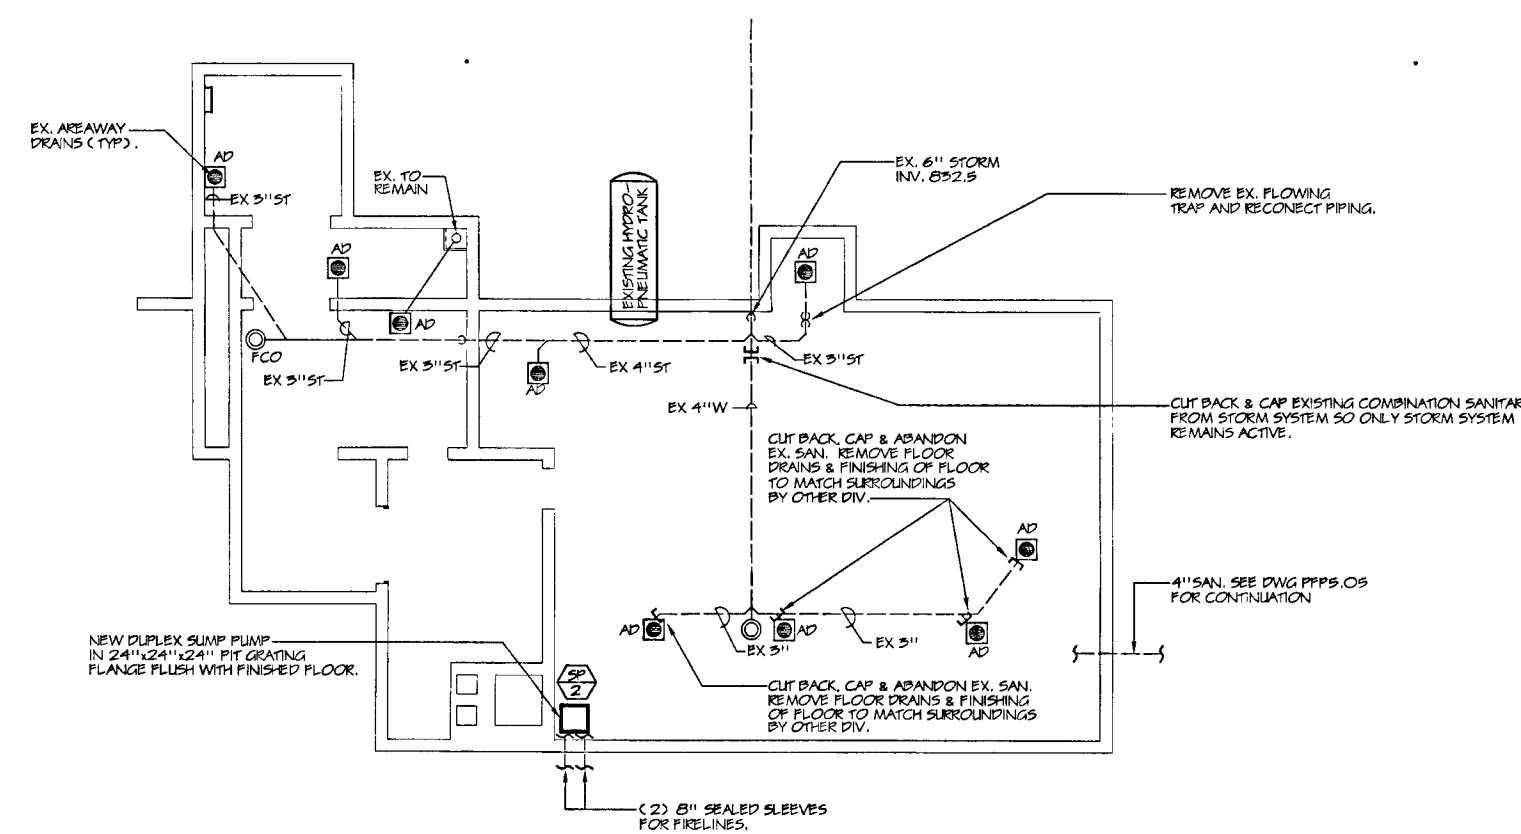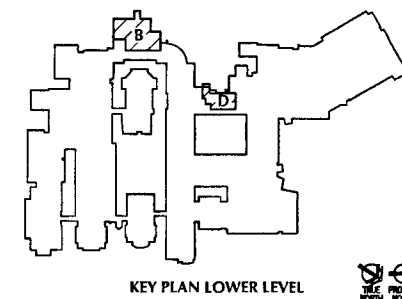

1 PLUMBING/FIRE PROTECTION LOWER LEVEL UNDERGROUND FLOOR PLAN- AREA D
 SCALE: 1/8"=1'-0"
 NOTES:
 1. SEE SYMBOLS, SCHEDULES, NOTES AND DETAILS.

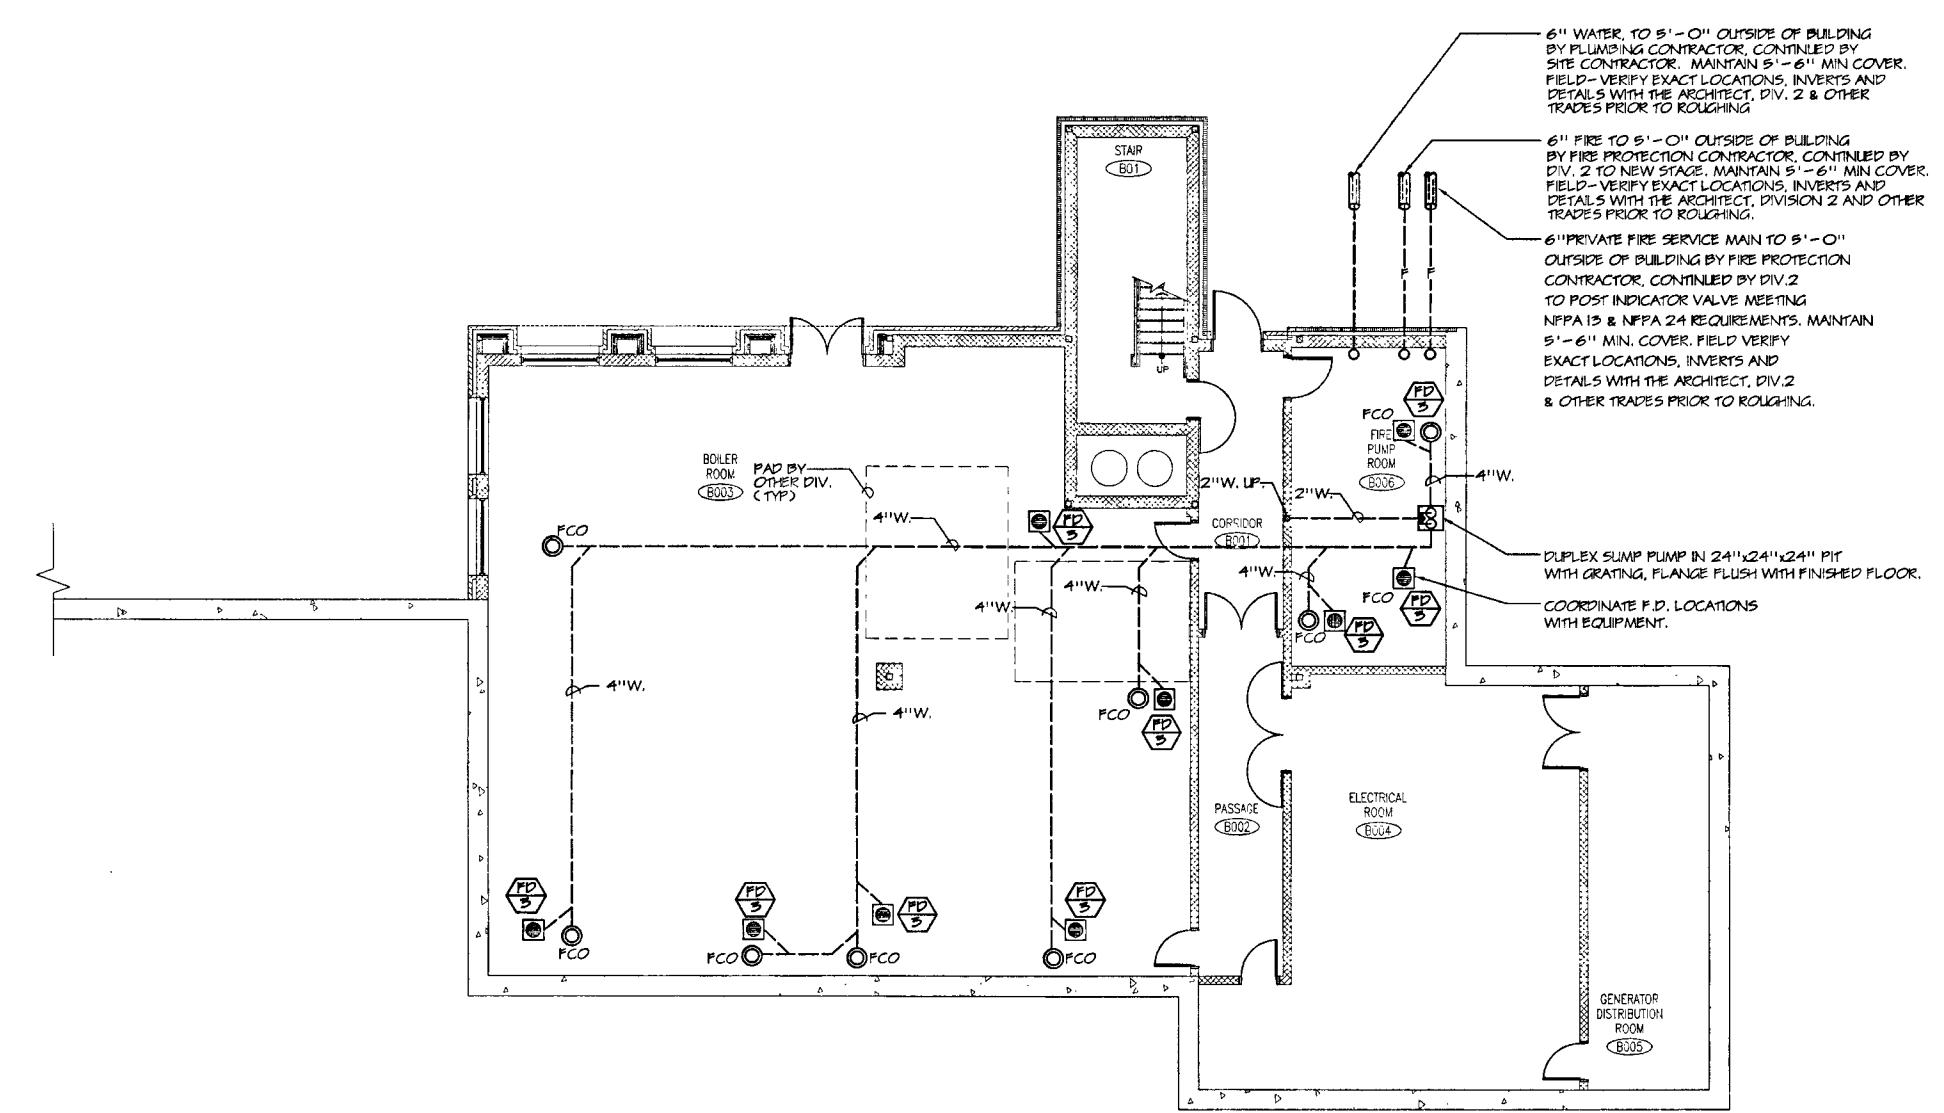

2 PLUMBING/FIRE PROTECTION LOWER LEVEL UNDERGROUND FLOOR PLAN- AREA B
 SCALE: 1/8"=1'-0"
 NOTES:
 1. SEE SYMBOLS, SCHEDULES, NOTES AND DETAILS.
 2. SEE KITCHEN PLAN FOR GREASE SYSTEM PIPING AND DRAINAGE TROUGH PIPING.

CONTRACTOR TO NOTE
 DRAWING IS PROVIDED FOR SITE WORK ONLY
 ALL ROOFTOP EQUIPMENT TO BE PART OF PHASE 3.

DATE	MARK	REVISIONS	DESCRIPTION
MARCH 1, 2005		ISSUED FOR BIDDING AND CONSTRUCTION PURPOSES (FOR REFERENCE ONLY AS PHASE 1)	




RENOVATIONS AND ADDITIONS TO THE REGIONAL SCHOOL DISTRICT 10 LEWIS S. MILLS HAR-BUR COMPLEX
 24/26 LYON ROAD
 BURLINGTON, CT 06013

STATE PROJECT NO. 210-0036
WALTER MCILVEEN ASSOCIATES, INC.
 CONSULTING ENGINEERS
 195 WEST MAIN STREET
 AVON, CT 06001-0516




KAESTLE BOOS ASSOCIATES, INC.
 1000 STATE ST., NEW BRITAIN, CT 06050 (860) 728-0061
 1000 STATE ST., SUITE 215, HARTFORD, CT 06103 (860) 300-0928
 1000 STATE ST., SUITE 125, PORTSMOUTH, NH 03801 (603) 784-1945

DRAWN BY: JML
 CHECKED BY: AMC
 SCALE: AS NOTED
PLUMBING AND FIRE PROTECTION LOWER LEVEL UNDERGROUND FLOOR PLAN-AREAS B + D

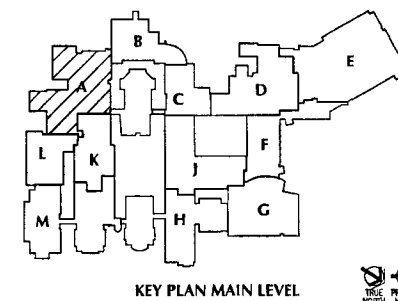

REVISIONS		
DATE	MARK	DESCRIPTION
MARCH 1, 2005		ISSUED FOR BIDDING AND CONSTRUCTION PURPOSES (FOR REFERENCE ONLY AS PHASE I)

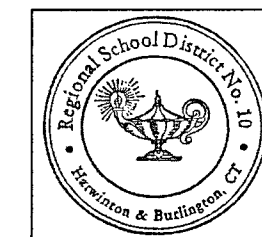


RENOVATIONS AND ADDITIONS TO THE REGIONAL SCHOOL DISTRICT 10 LEWIS S. MILLS HAR-BUR COMPLEX

24/26 LYON ROAD
BURLINGTON, CT 06013

STATE PROJECT NO. 210-0036

**WALTER MCILVEEN
ASSOCIATES, INC.**

CONSULTING ENGINEERS
195 WEST MAIN STREET
AVON, CT 06001-0516

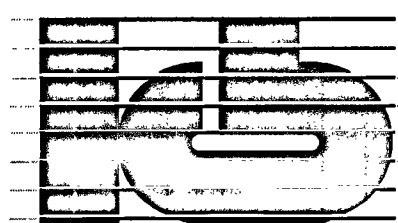

**KAESTLE BOOS
ASSOCIATES, INC.**

210 SLATER RD., NEW BRITAIN, CT 06051 (800) 250-2501
100 CHASE ST., SUITE 210, FARMINGTON, CT 06030 (860) 520-9000
111 NEW HAVEN AVE., SUITE 125, PORTSMOUTH, NH 03801 (603) 766-7865


DRAWN BY: JML
CHECKED BY: AMG
SCALE: AS NOTED

**PLUMBING/FIRE
PROTECTION
MAIN LEVEL
UNDERGROUND FLOOR
PLAN-AREA A**

PROJECT NO.: 04000/48114

DRAWING NO.:

DATE: JANUARY 28, 2005 **FPF5.02**

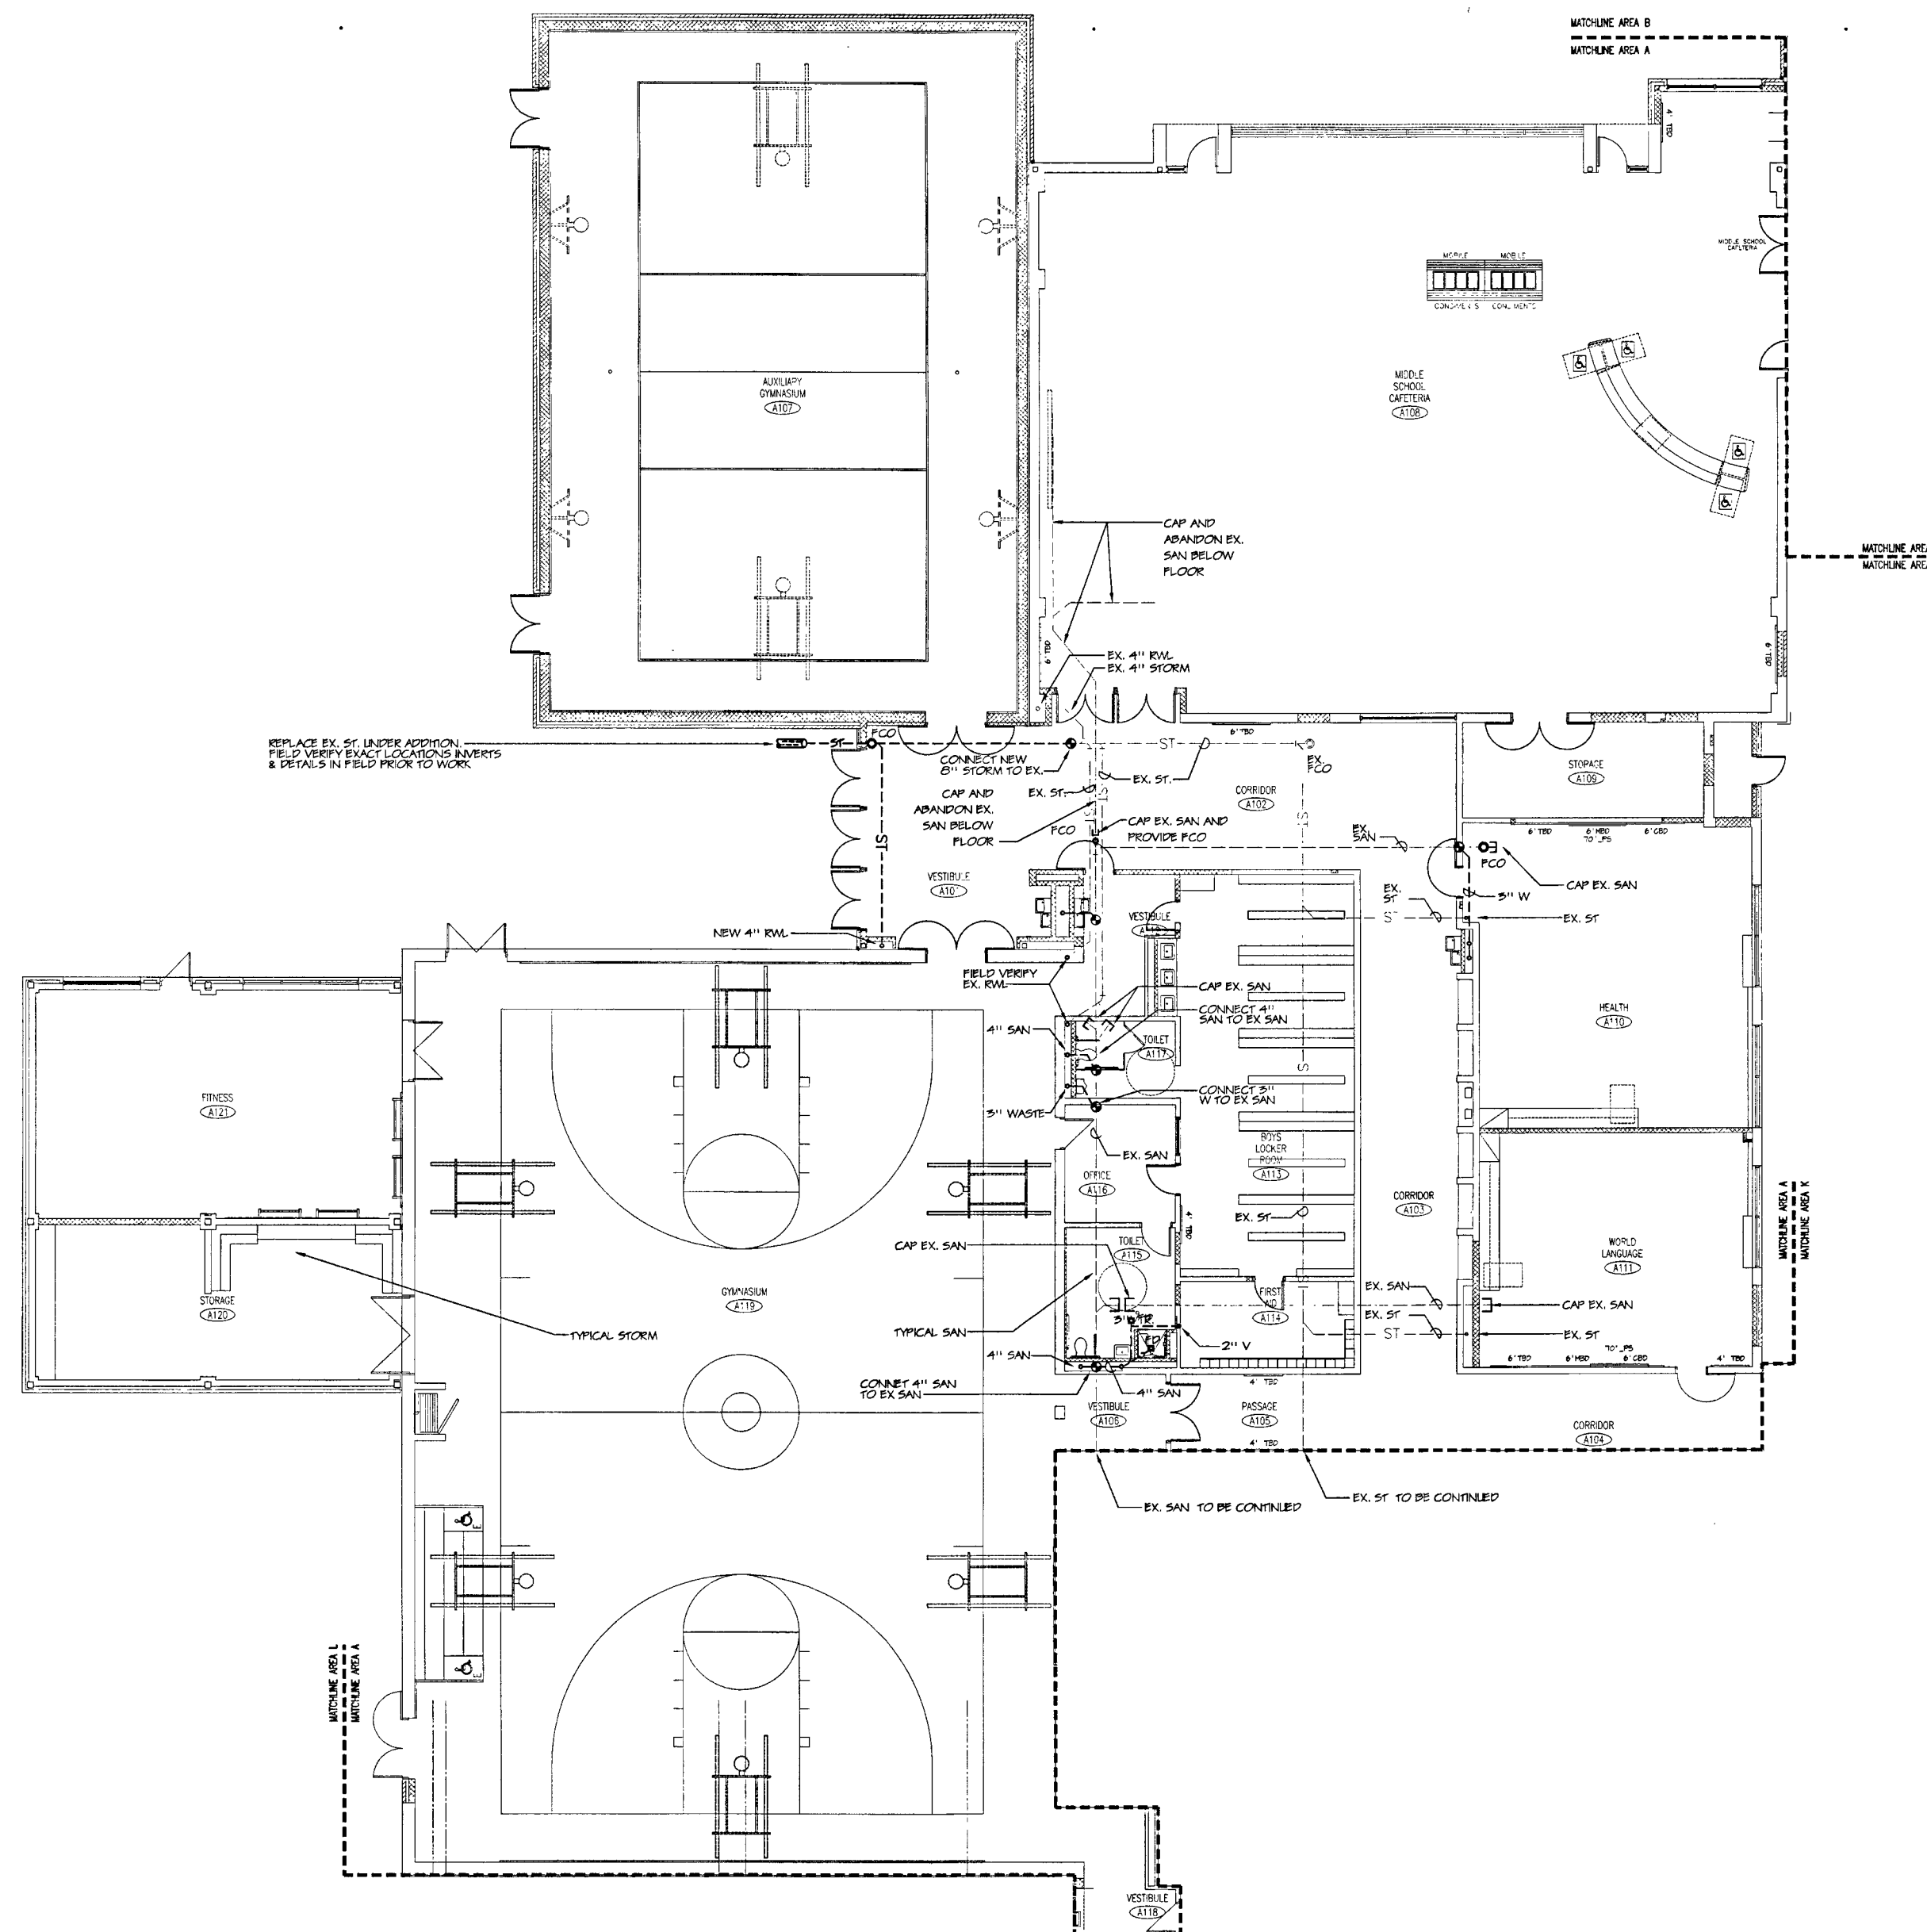

1

PLUMBING/FIRE PROTECTION MAIN LEVEL UNDERGROUND FLOOR PLAN- AREA A


SCALE: 1/8" = 1'-0"

NOTES:

1. SEE SYMBOLS, SCHEDULES, NOTES AND DETAILS.


CONTRACTOR TO NOTE

DRAWING IS PROVIDED FOR SITE WORK ONLY.
ALL ROOFTOP EQUIPMENT TO BE PART OF PHASE 3.

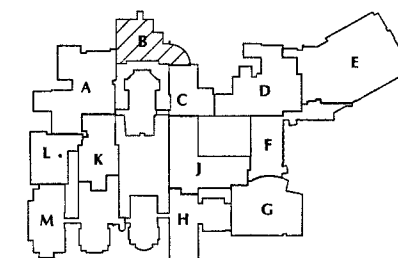

KEY PLAN MAIN LEVEL

REVISIONS		
DATE	MARK	DESCRIPTION
MARCH 1, 2005		ISSUED FOR BIDDING AND CONSTRUCTION PURPOSES (FOR REFERENCE ONLY AS PHASE I)

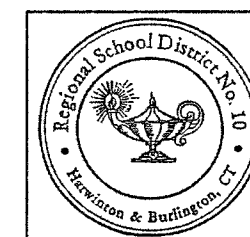

RENOVATIONS AND ADDITIONS TO THE
REGIONAL
SCHOOL
DISTRICT 10
LEWIS S. MILLS
HAR-BUR
COMPLEX

24/26 LYON ROAD
BURLINGTON, CT 06013

STATE PROJECT NO. 210-0036

WALTER MCILVEEN
ASSOCIATES, INC.
CONSULTING ENGINEERS
195 WEST MAIN STREET
AVON, CT 06001-0516



KAESTLE BOOS
ASSOCIATES, INC.

118 SLATER RD. NEW BRITAIN, CT 06050 (860) 228-0581

124 BROOK ST. SUITE 213 FRANKLIN, MA 02038 (508) 882-9928

21 NEW HAVEN AVE. SUITE 125 PORTSMOUTH, NH 03801 (603) 766-1595


DRAWN BY: JML SCALE: AS NOTED

CHECKED BY: AMC

PLUMBING/FIRE
PROTECTION
MAIN LEVEL
UNDERGROUND FLOOR
PLAN-AREA B

PROJECT NO.: 04000/48114 DRAWING NO.:

DATE: JANUARY 28, 2005 PFP5.03

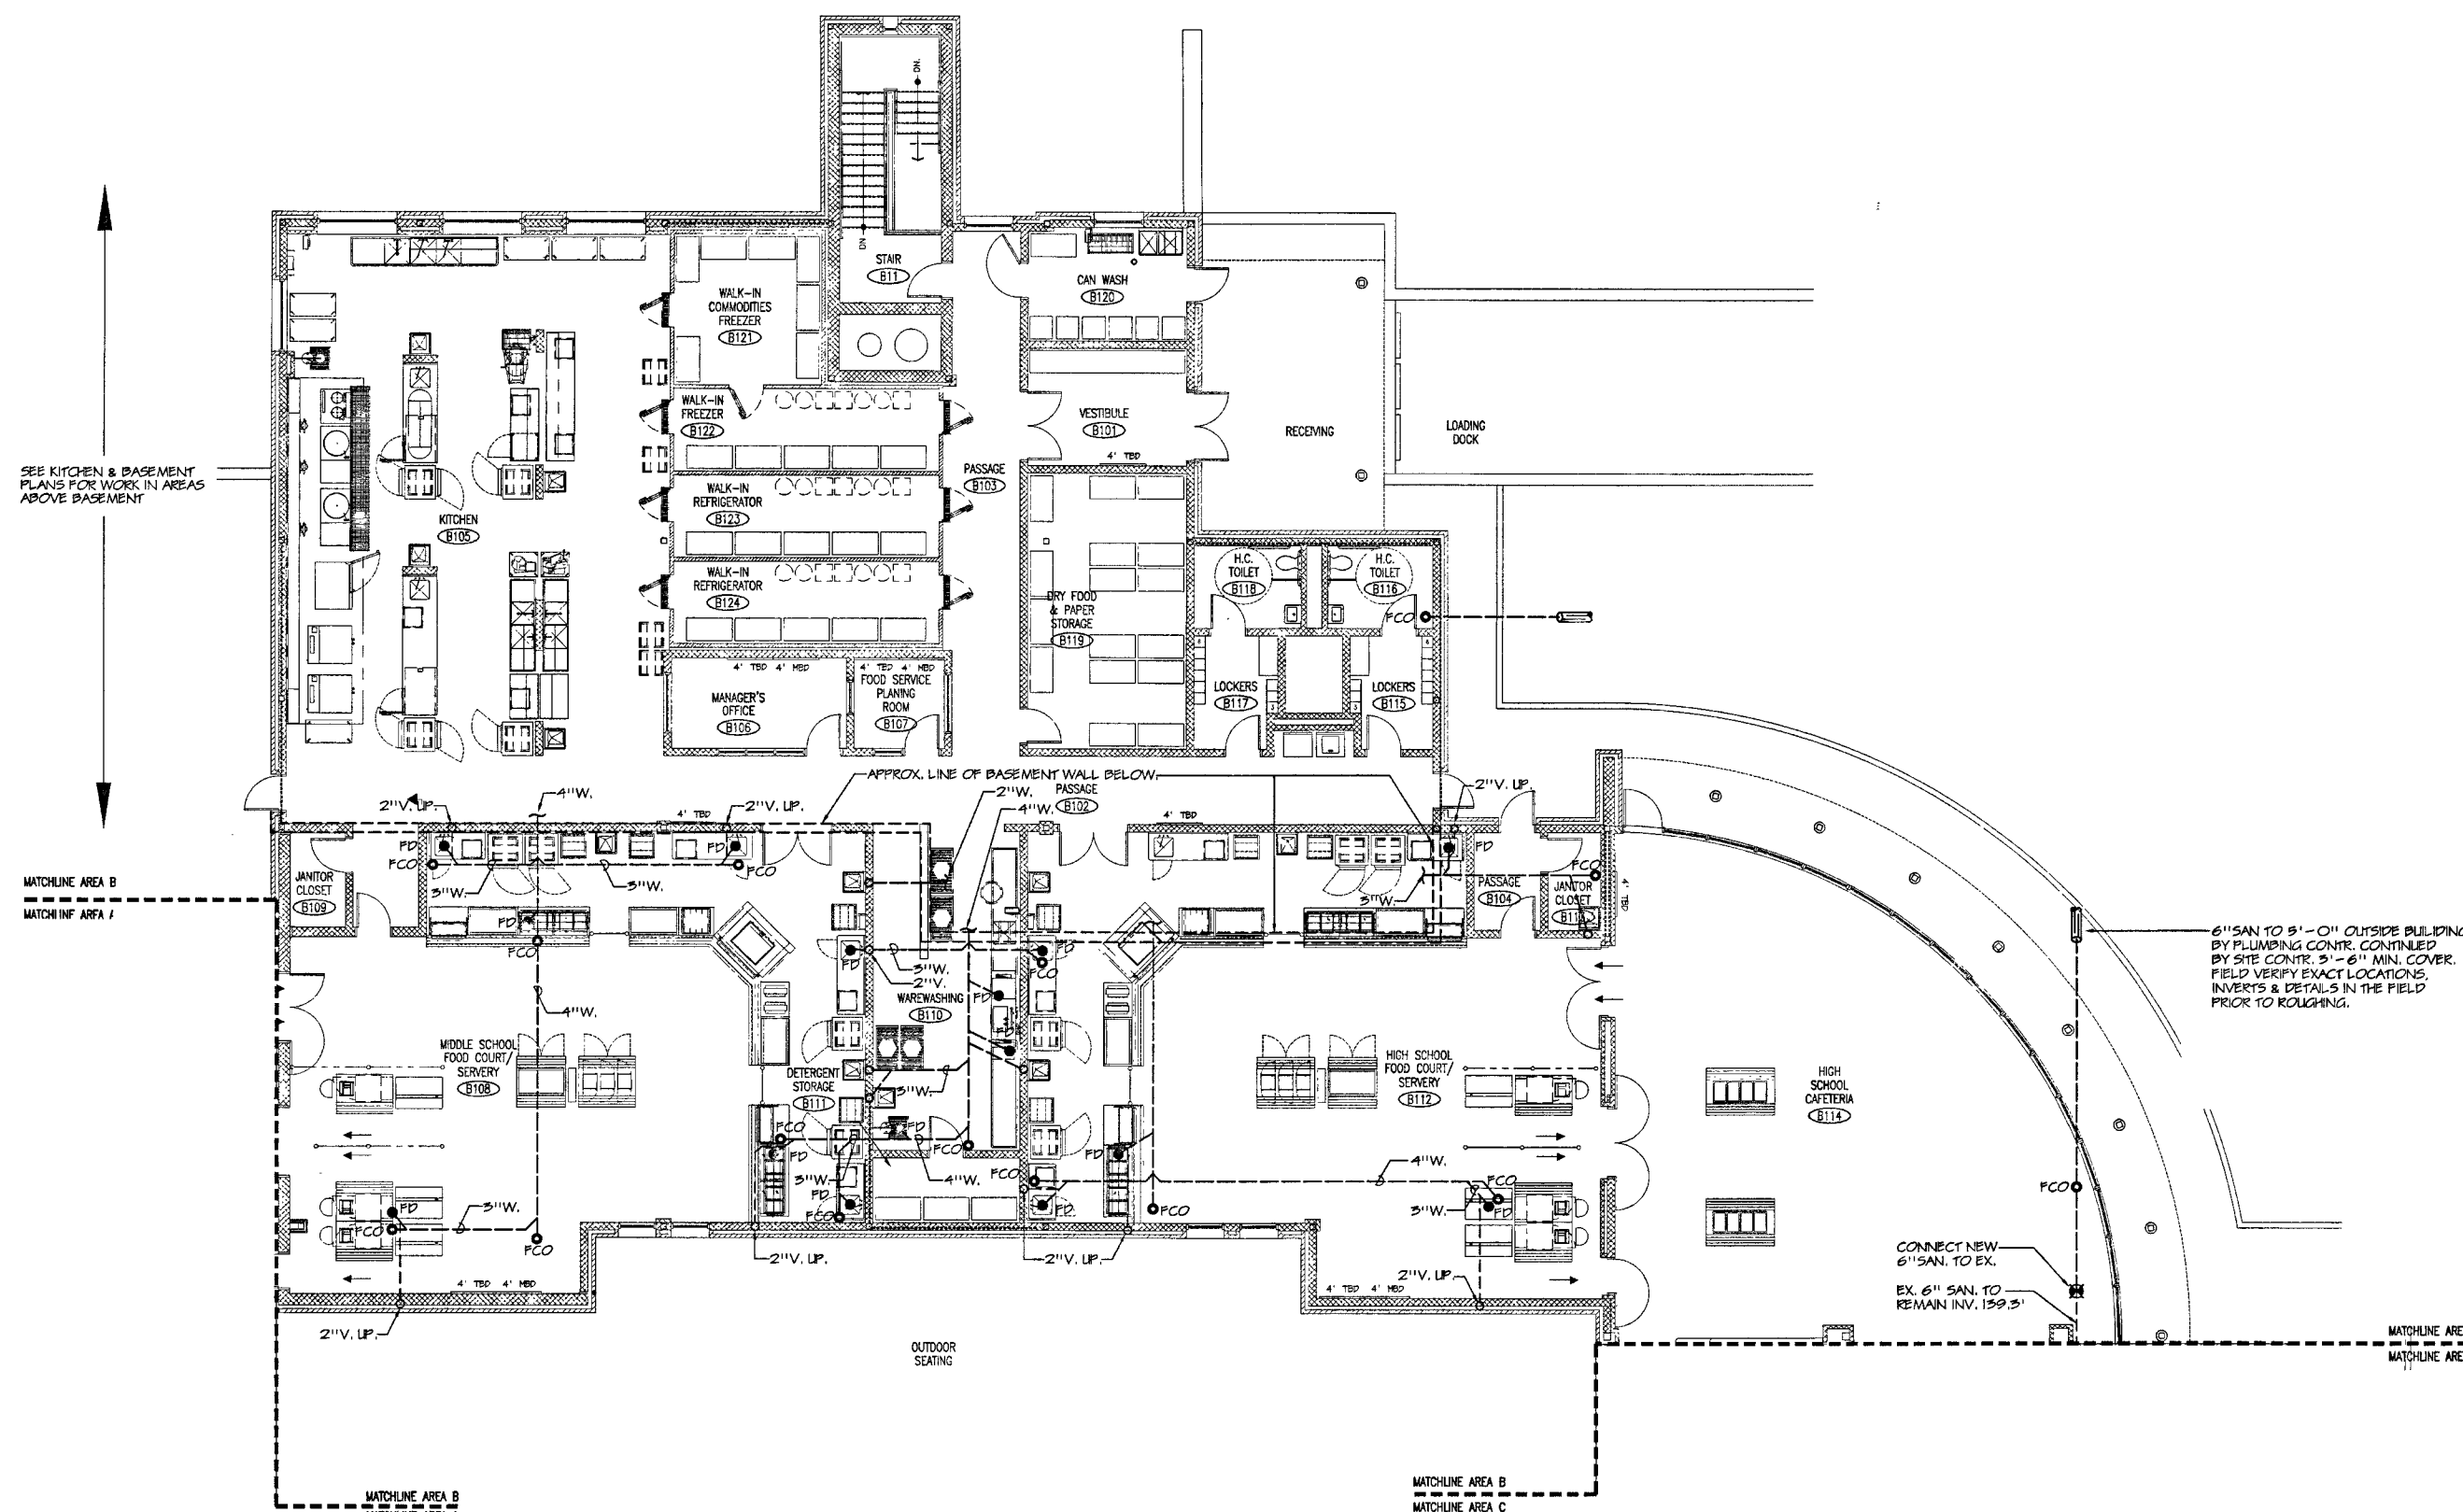

1 PLUMBING/FIRE PROTECTION MAIN LEVEL UNDERGROUND FLOOR PLAN- AREA B


SCALE: 1/8" = 1'-0"

NOTES:

1. SEE SYMBOLS, SCHEDULES, NOTES AND DETAILS.
2. SEE DWG. PFP5.01 FOR UNDERGROUND PIPING IN BASEMENT.


CONTRACTOR TO NOTE

DRAWING IS PROVIDED FOR SITE WORK ONLY
ALL ROOFTOP EQUIPMENT TO BE PART OF PHASE 3.

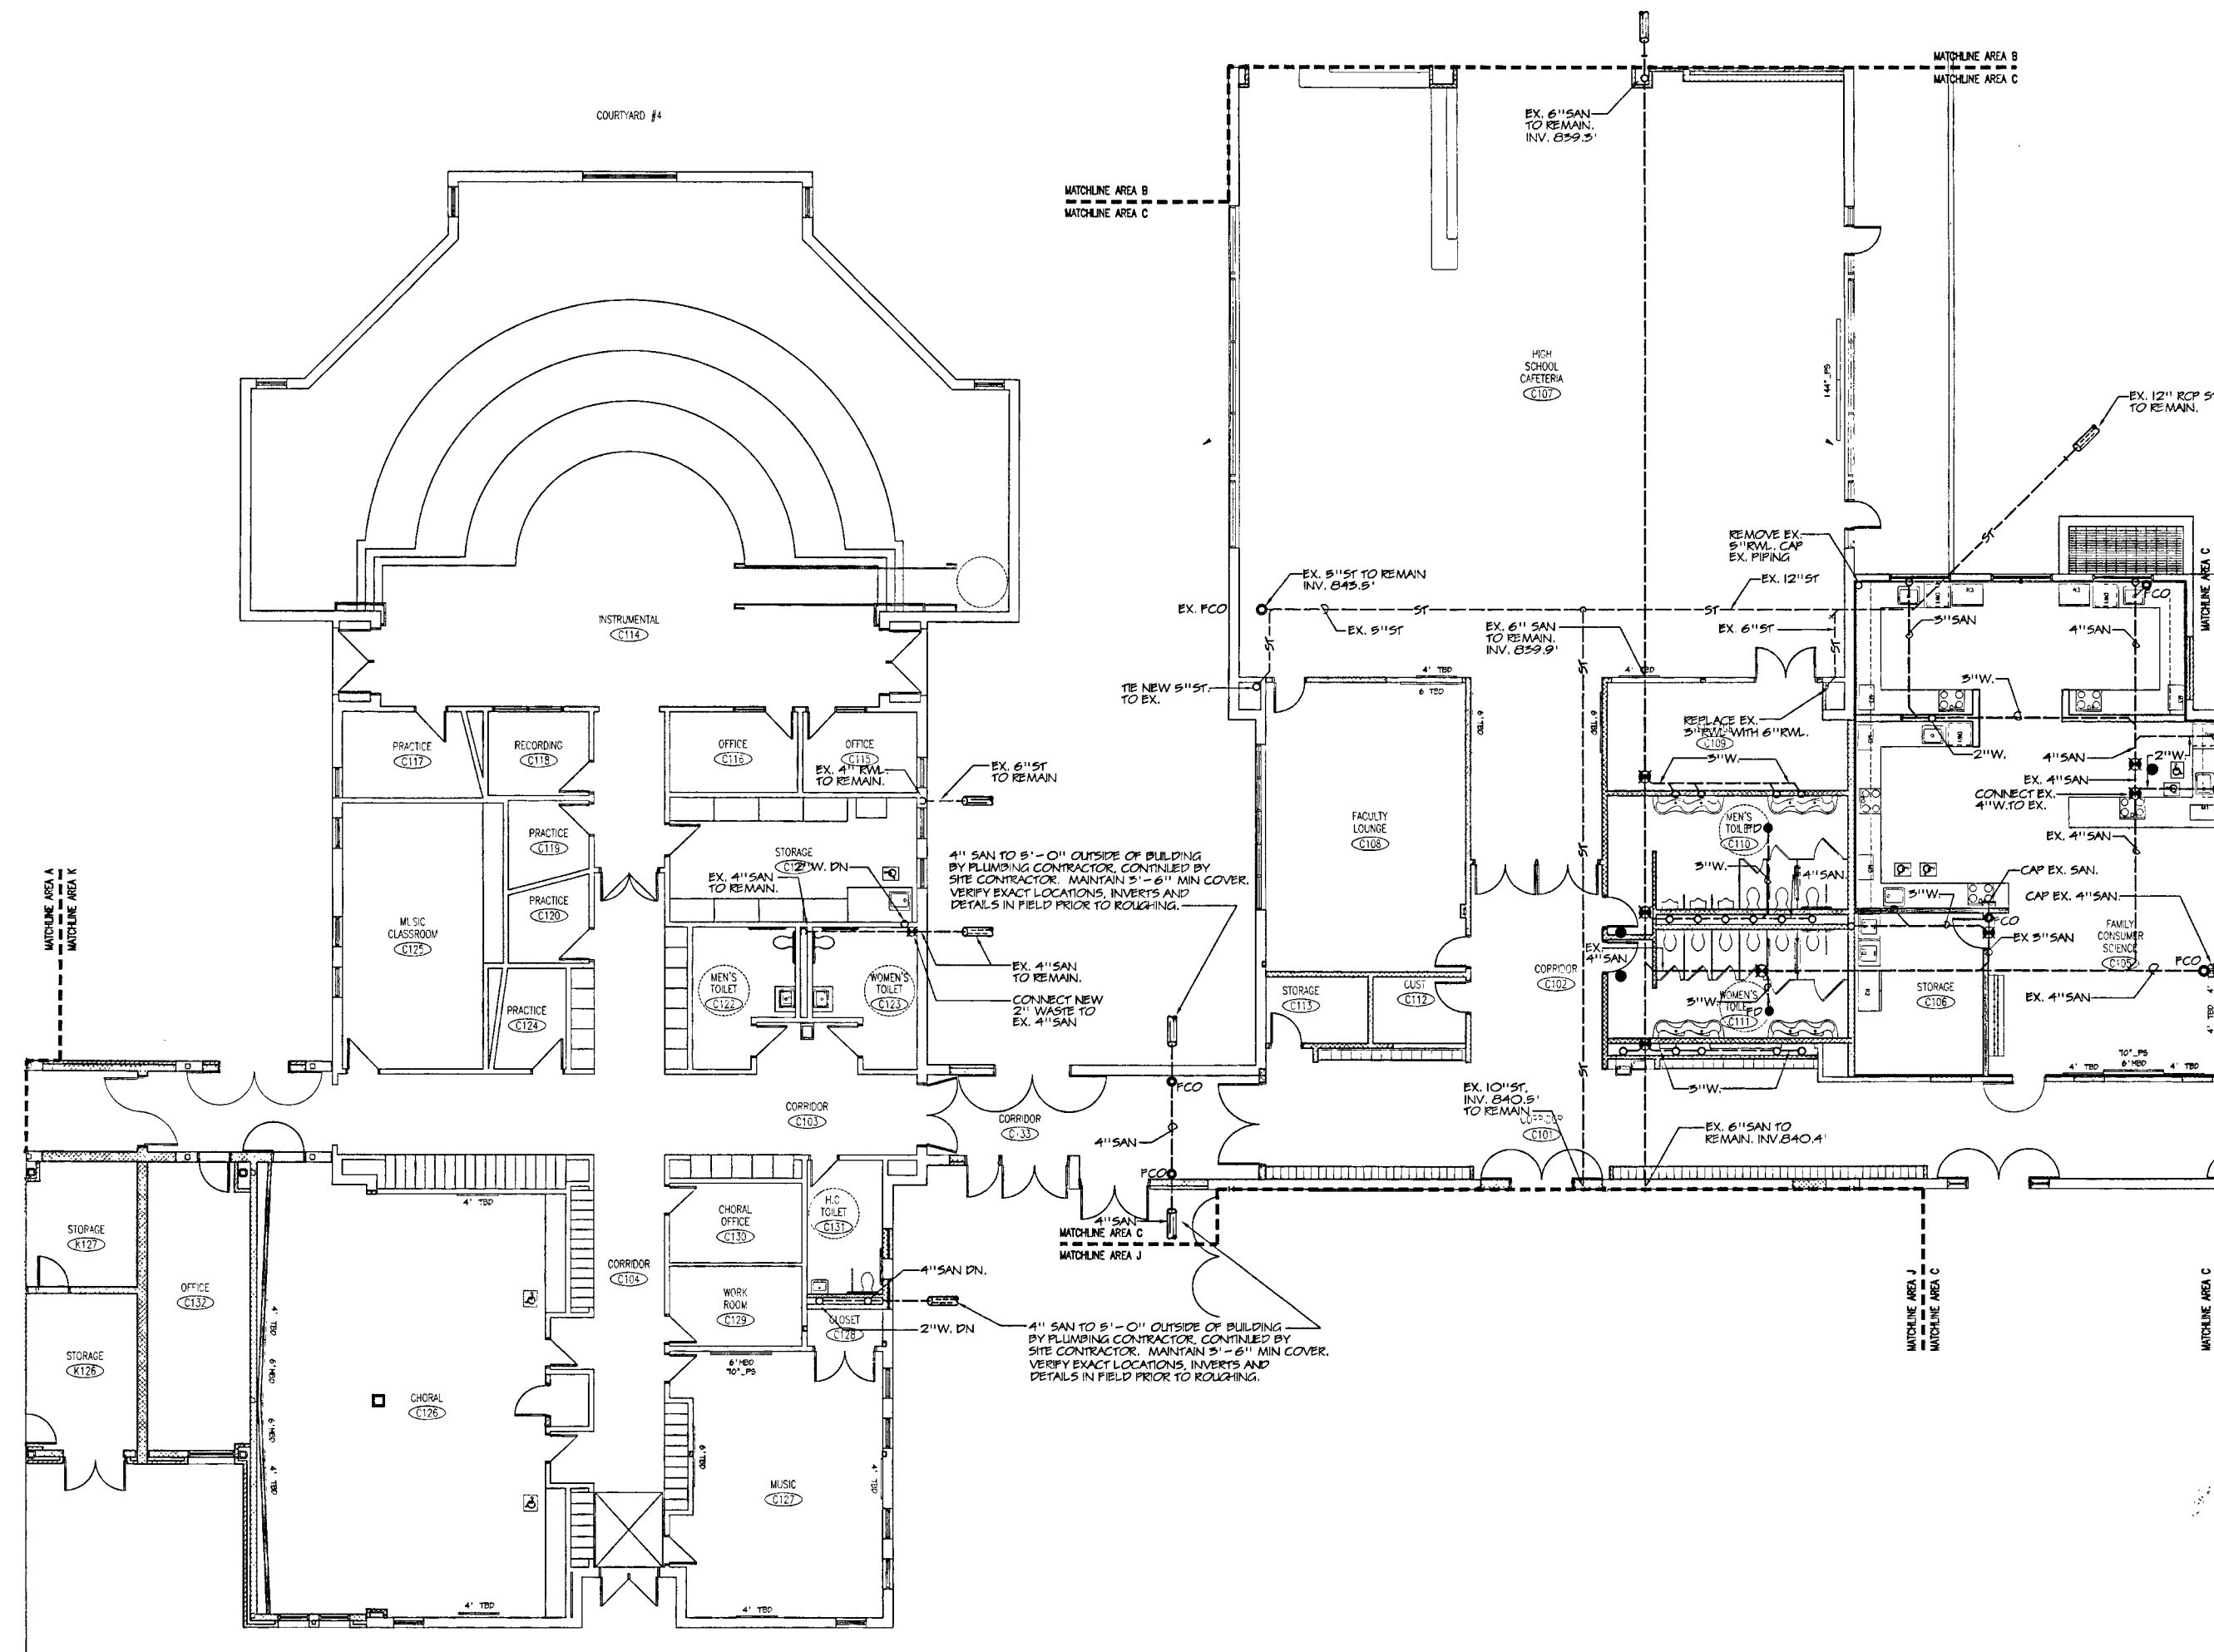


1 PLUMBING/FIRE PROTECTION MAIN LEVEL UNDERGROUND FLOOR PLAN- AREA C
 SCALE: 1/8" = 1'-0"
 NOTES:
 1. SEE SYMBOLS, SCHEDULES, NOTES AND DETAILS.

CONTRACTOR TO NOTE
 DRAWING IS PROVIDED FOR SITE WORK ONLY
 ALL ROOFTOP EQUIPMENT TO BE PART OF PHASE 3.

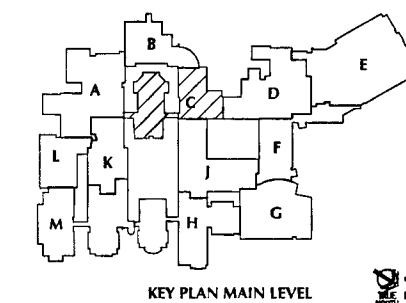

DATE	MARK	REVISIONS	DESCRIPTION
MARCH 1, 2005			ISSUED FOR BIDDING AND CONSTRUCTION PURPOSES (FOR REFERENCE ONLY AS PHASE 1)

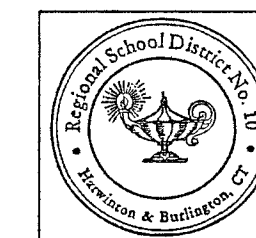

RENOVATIONS AND ADDITIONS TO THE REGIONAL SCHOOL DISTRICT 10 LEWIS S. MILLS HAR-BUR COMPLEX
 24/26 LYON ROAD
 BURLINGTON, CT 06013

STATE PROJECT NO. 210-0036

WALTER MCILVEEN ASSOCIATES, INC.
 CONSULTING ENGINEERS
 195 WEST MAIN STREET
 AVON, CT 06001-0516



KAESTLE BOOS ASSOCIATES, INC.


418 SLATER RD. NEW BRIDGEMAN, CT 06050 (860) 226-0361
 124 BROOME ST. SUITE 213 FRANKLIN, MA 02038 (603) 882-9924
 1 NEW HAMPSHIRE AVE. SUITE 100 PORTSMOUTH, NH 03801 (603) 786-1565

DRAWN BY: JAL
 CHECKED BY: AMC
 SCALE: AS NOTED
PLUMBING/FIRE PROTECTION MAIN LEVEL UNDERGROUND FLOOR PLAN-AREA C

PROJECT NO.: 04000/48114


DRAWING NO.

DATE: JANUARY 28, 2005 **PFP5.04**

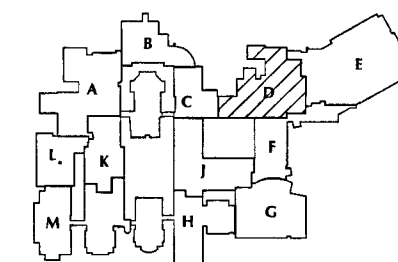

KEY PLAN MAIN LEVEL

DATE	MARK	REVISIONS	DESCRIPTION
MARCH 1, 2005		ISSUED FOR BIDDING AND CONSTRUCTION PURPOSES (FOR REFERENCE ONLY AS PHASE I)	

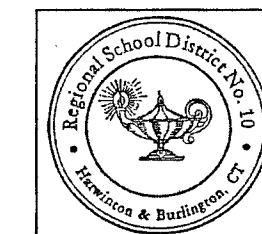

RENOVATIONS AND ADDITIONS TO THE REGIONAL SCHOOL DISTRICT 10 LEWIS S. MILLS HAR-BUR COMPLEX

24/26 LYON ROAD
BURLINGTON, CT 06013

STATE PROJECT NO. 210-0036

WALTER MCILVEEN ASSOCIATES, INC.
CONSULTING ENGINEERS
195 WEST MAIN STREET
AVON, CT 06001-0516



KAESTLE BOOS ASSOCIATES, INC.


216 SLATER RD., NEW BRITAIN, CT 06050 (860) 229-0361
240 BROAD ST., SUITE 215 FARMINGTON, CT 06030 (860) 229-3628
21 NEW HAVEN AVE., SUITE 125 FARMINGTON, CT 06031 (860) 788-1985

DRAWN BY: JML
CHECKED BY: AMG
SCALE: AS NOTED
PLUMBING/FIRE PROTECTION MAIN LEVEL UNDERGROUND FLOOR PLAN-AREA D

PROJECT NO.: 04000/48114

DRAWING NO.:


DATE: JANUARY 28, 2005 **PFP5.05**

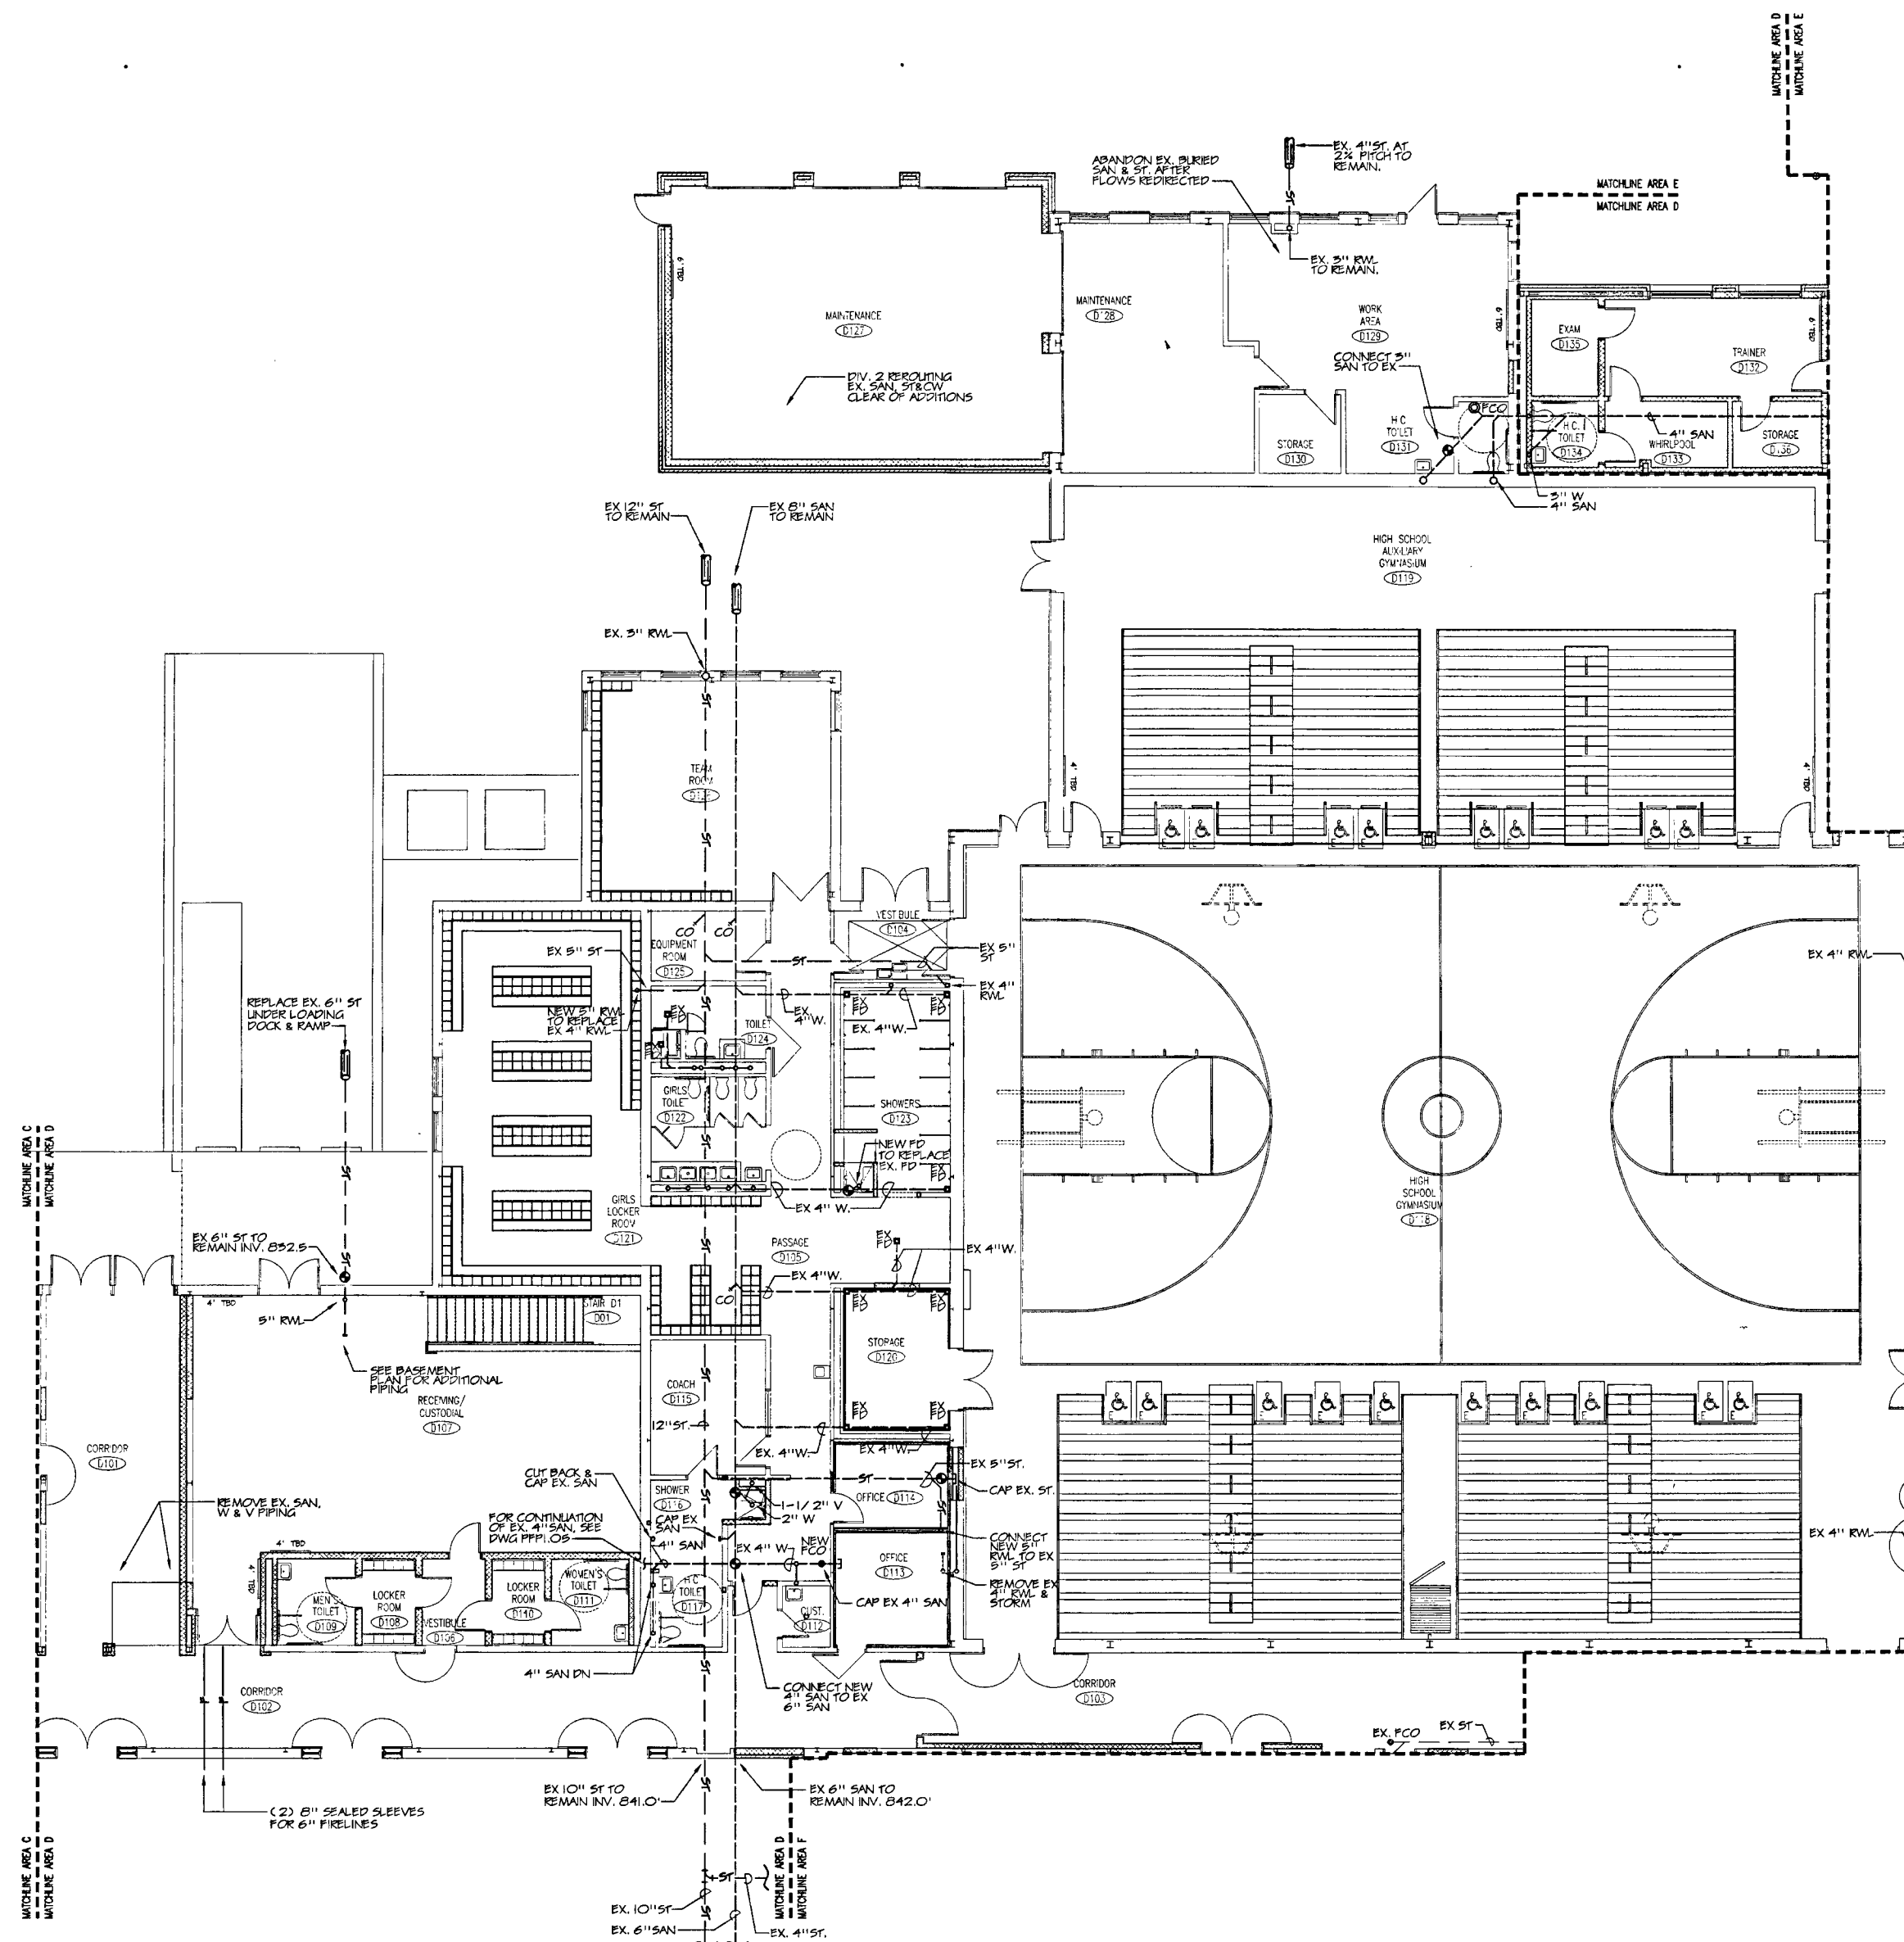

1 PLUMBING/FIRE PROTECTION MAIN LEVEL UNDERGROUND FLOOR PLAN- AREA D


SCALE: 1/8" = 1'-0"
NOTES:
1. SEE SYMBOLS, SCHEDULES, NOTES AND DETAILS.

CONTRACTOR TO NOTE
DRAWING IS PROVIDED FOR SITE WORK ONLY
ALL ROOFTOP EQUIPMENT TO BE PART OF PHASE 3.

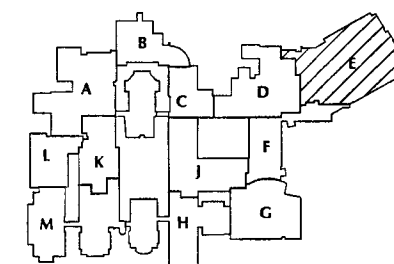

KEY PLAN MAIN LEVEL

DATE	MARK	REVISIONS	DESCRIPTION
MARCH 1, 2005			ISSUED FOR BIDDING AND CONSTRUCTION PURPOSES (FOR REFERENCE ONLY AS PHASE 1)

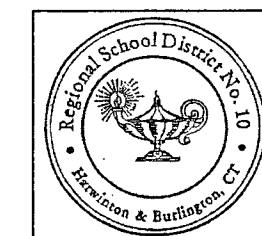


RENOVATIONS AND
ADDITIONS TO THE
REGIONAL
SCHOOL
DISTRICT 10
LEWIS S. MILLS
HAR-BUR
COMPLEX

24/26 LYON ROAD
BURLINGTON, CT 06013

STATE PROJECT NO. 210-0036

WALTER MCILVEEN
ASSOCIATES, INC.
CONSULTING ENGINEERS
195 WEST MAIN STREET
AVON, CT 06001-0516

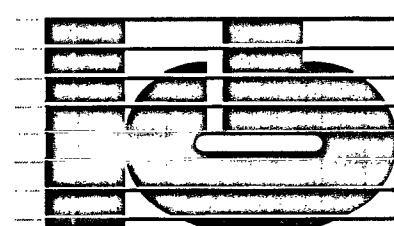

KAESTLE BOOS
ASSOCIATES, INC.

1000 SLATER AVE., NEW BRITAIN, CT 06050 (860) 326-0088
1000 GLOVE ST., SUITE 215, FARMINGTON, CT 06030 (860) 326-9928
100 NEW HAVEN AVE., SUITE 205, HARTFORD, CT 06103 (860) 766-1965


DRAWN BY: JMC CHECKED BY: JMC SCALE AS NOTED

PLUMBING/FIRE
PROTECTION
MAIN LEVEL
UNDERGROUND FLOOR
PLAN-AREA E

PROJECT NO.: 04000/48114

DRAWING NO.:

DATE: JANUARY 28, 2005 PFP5.06

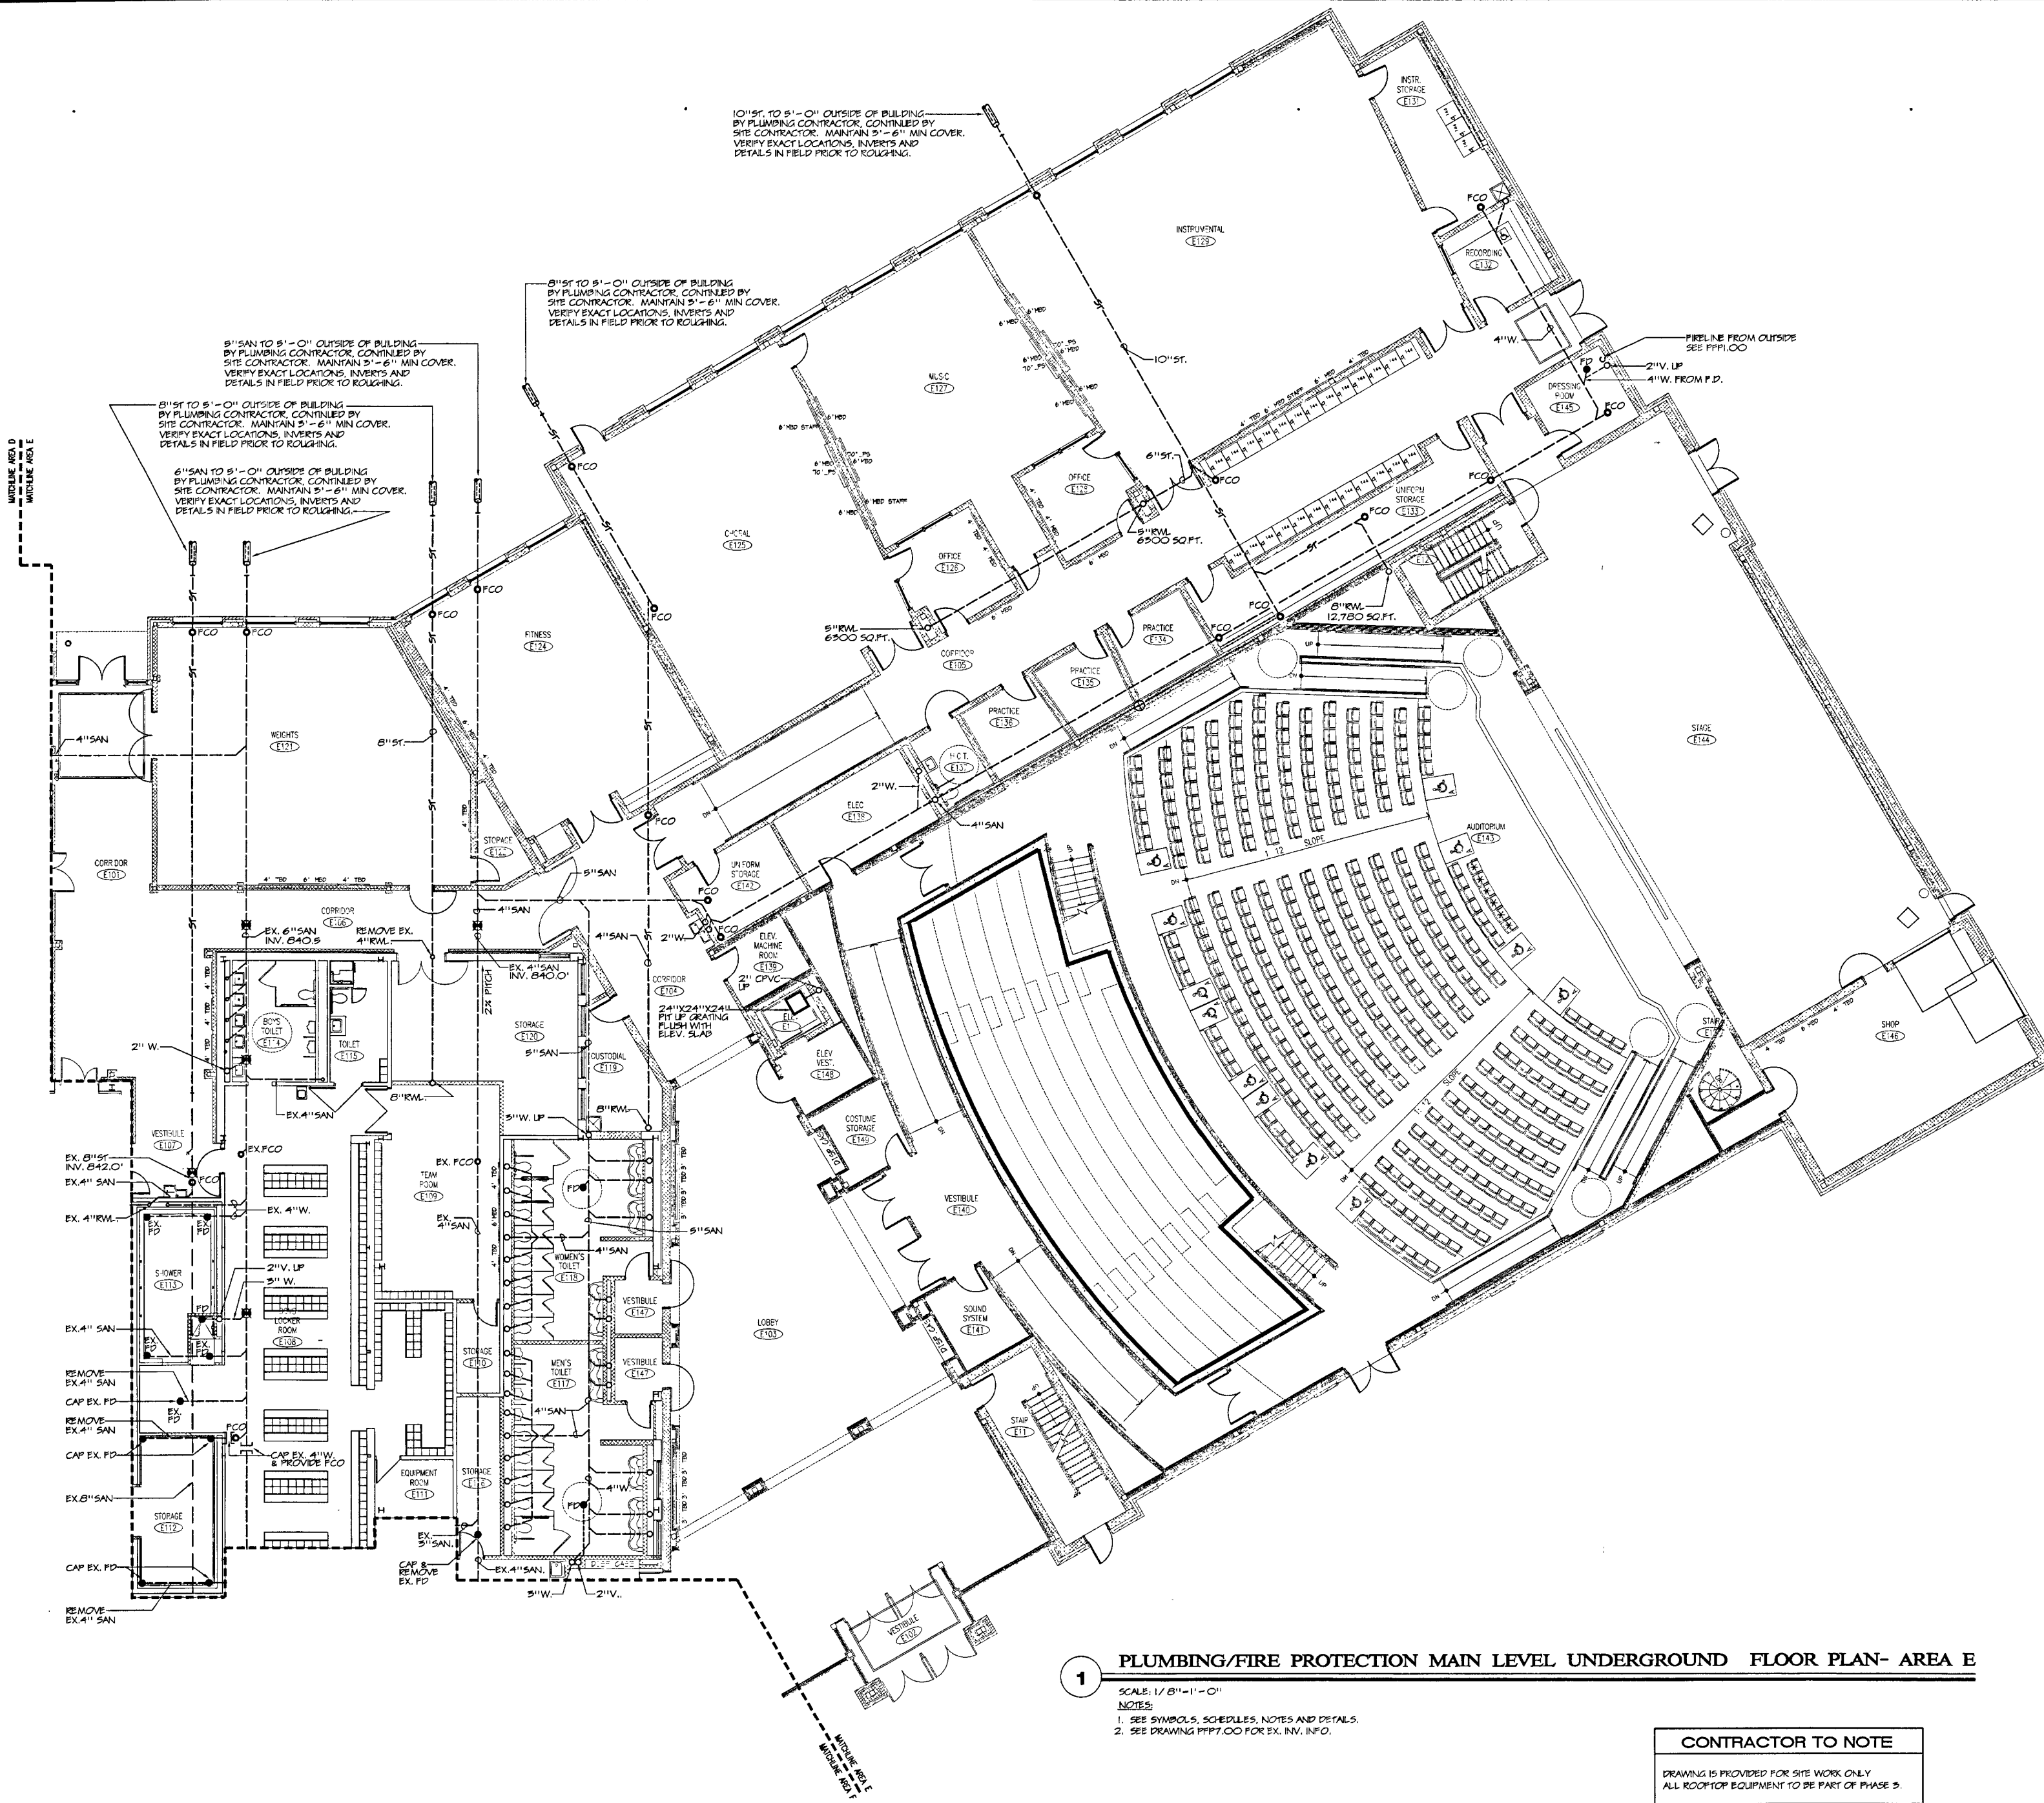


1 PLUMBING/FIRE PROTECTION MAIN LEVEL UNDERGROUND FLOOR PLAN- AREA E

SCALE: 1/8"=1'-0"
NOTES:
1. SEE SYMBOLS, SCHEDULES, NOTES AND DETAILS.
2. SEE DRAWING PFP7.00 FOR EX. INV. INFO.


CONTRACTOR TO NOTE

DRAWING IS PROVIDED FOR SITE WORK ONLY
ALL ROOFTOP EQUIPMENT TO BE PART OF PHASE 3.

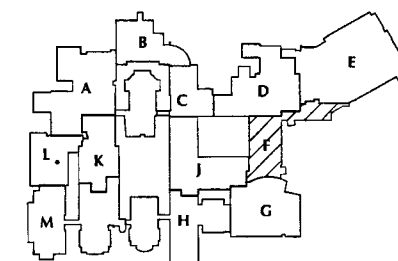

KEY PLAN MAIN LEVEL

DATE	MARK	REVISIONS	DESCRIPTION
MARCH 1, 2005		ISSUED FOR BIDDING AND CONSTRUCTION PURPOSES (FOR REFERENCE ONLY AS PHASE 1)	

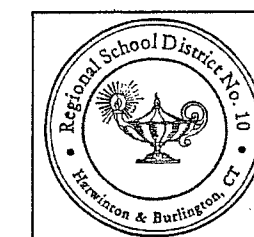


RENOVATIONS AND ADDITIONS TO THE
REGIONAL
SCHOOL
DISTRICT 10
LEWIS S. MILLS
HAR-BUR
COMPLEX

24/26 LYON ROAD
BURLINGTON, CT 06013

STATE PROJECT NO. 210-0036

WALTER MCILVEEN
ASSOCIATES, INC.
CONSULTING ENGINEERS
195 WEST MAIN STREET
AVON, CT 06001-0516

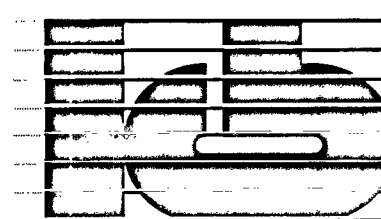


KAESTLE BOOS
ASSOCIATES, INC.

124 GROVE ST., SUITE 205, FRANKLIN, CT 06030 (860) 325-2261
124 GROVE ST., SUITE 205, FRANKLIN, CT 06030 (860) 325-2261
124 GROVE ST., SUITE 205, FRANKLIN, CT 06030 (860) 325-2261

DRAWN BY: JML
CHECKED BY: AMG
SCALE: AS NOTED

PLUMBING/FIRE
PROTECTION
MAIN LEVEL
UNDERGROUND FLOOR
PLAN-AREA F

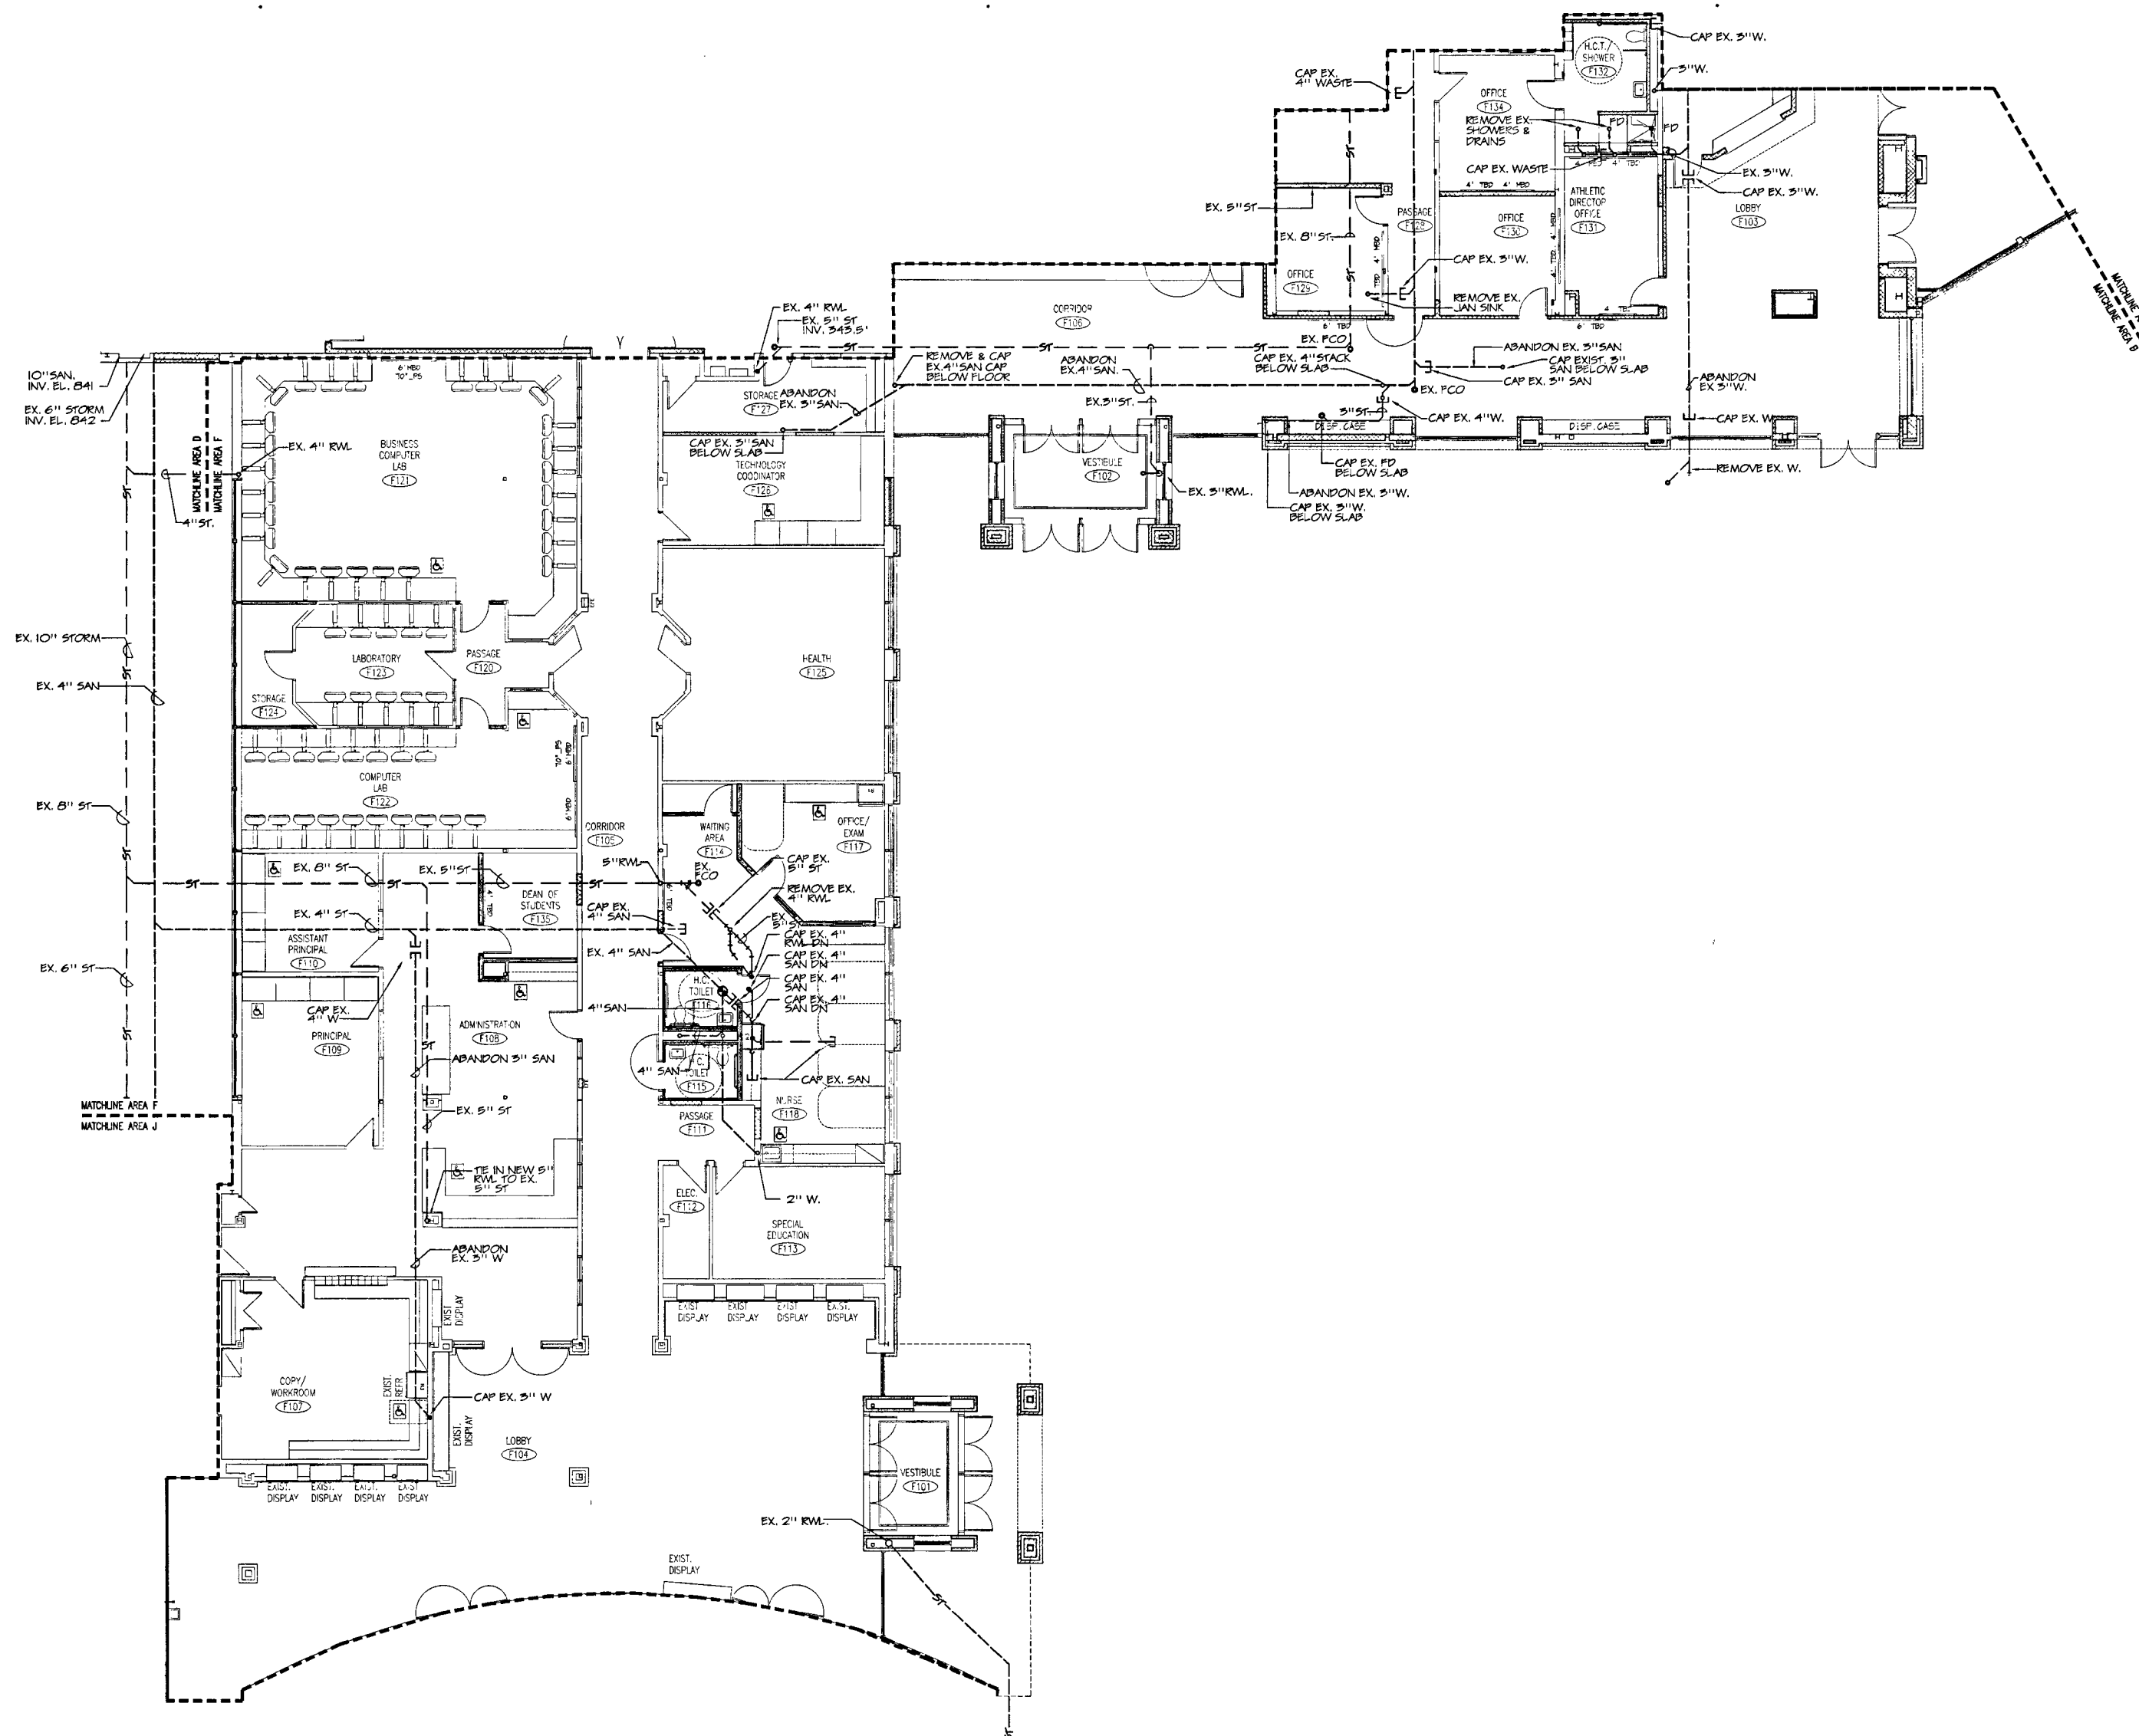

1 PLUMBING/FIRE PROTECTION MAIN LEVEL UNDERGROUND FLOOR PLAN- AREA F

SCALE: 1/8"=1'-0"

NOTES:

1. SEE SYMBOLS, SCHEDULES, NOTES AND DETAILS.


CONTRACTOR TO NOTE

DRAWING IS PROVIDED FOR SITE WORK ONLY.
ALL ROOFTOP EQUIPMENT TO BE PART OF PHASE 3.

PROJECT NO.: 04000/48114


DRAWING NO.:

DATE: JANUARY 28, 2005 PFP5.07

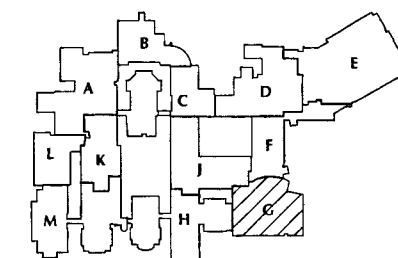

KEY PLAN MAIN LEVEL

REVISIONS		
DATE	MARK	DESCRIPTION
MARCH 1, 2005		ISSUED FOR BIDDING AND CONSTRUCTION PURPOSES (FOR REFERENCE ONLY AS PHASE I)

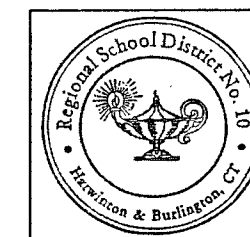

RENOVATIONS AND ADDITIONS TO THE
REGIONAL
SCHOOL
DISTRICT 10
LEWIS S. MILLS
HAR-BUR
COMPLEX

24/26 LYON ROAD
BURLINGTON, CT 06013

STATE PROJECT NO. 210-0036

**WALTER MCILVEEN
ASSOCIATES, INC.**
CONSULTING ENGINEERS
195 WEST MAIN STREET
AVON, CT 06001-0516

**KAESTLE BOOS
ASSOCIATES, INC.**


418 SCATER RD. NEW BRITAIN, CT 06050 (860) 224-0061
144 BRIDGE ST. SUITE 215 FARMINGTON, CT 06030 (860) 320-0020
11 NEW HAVENS AVE. SUITE 125 FARMINGTON, CT 06030 (860) 768-1905


DRAWN BY: JML
CHECKED BY: AMC
SCALE AS NOTED
PLUMBING/FIRE
PROTECTION
MAIN LEVEL PART
UNDERGROUND FLOOR
PLAN-AREA G

PROJECT NO. 04000/48114

DRAWING NO.:


DATE JANUARY 28, 2005 **PFP5.08**

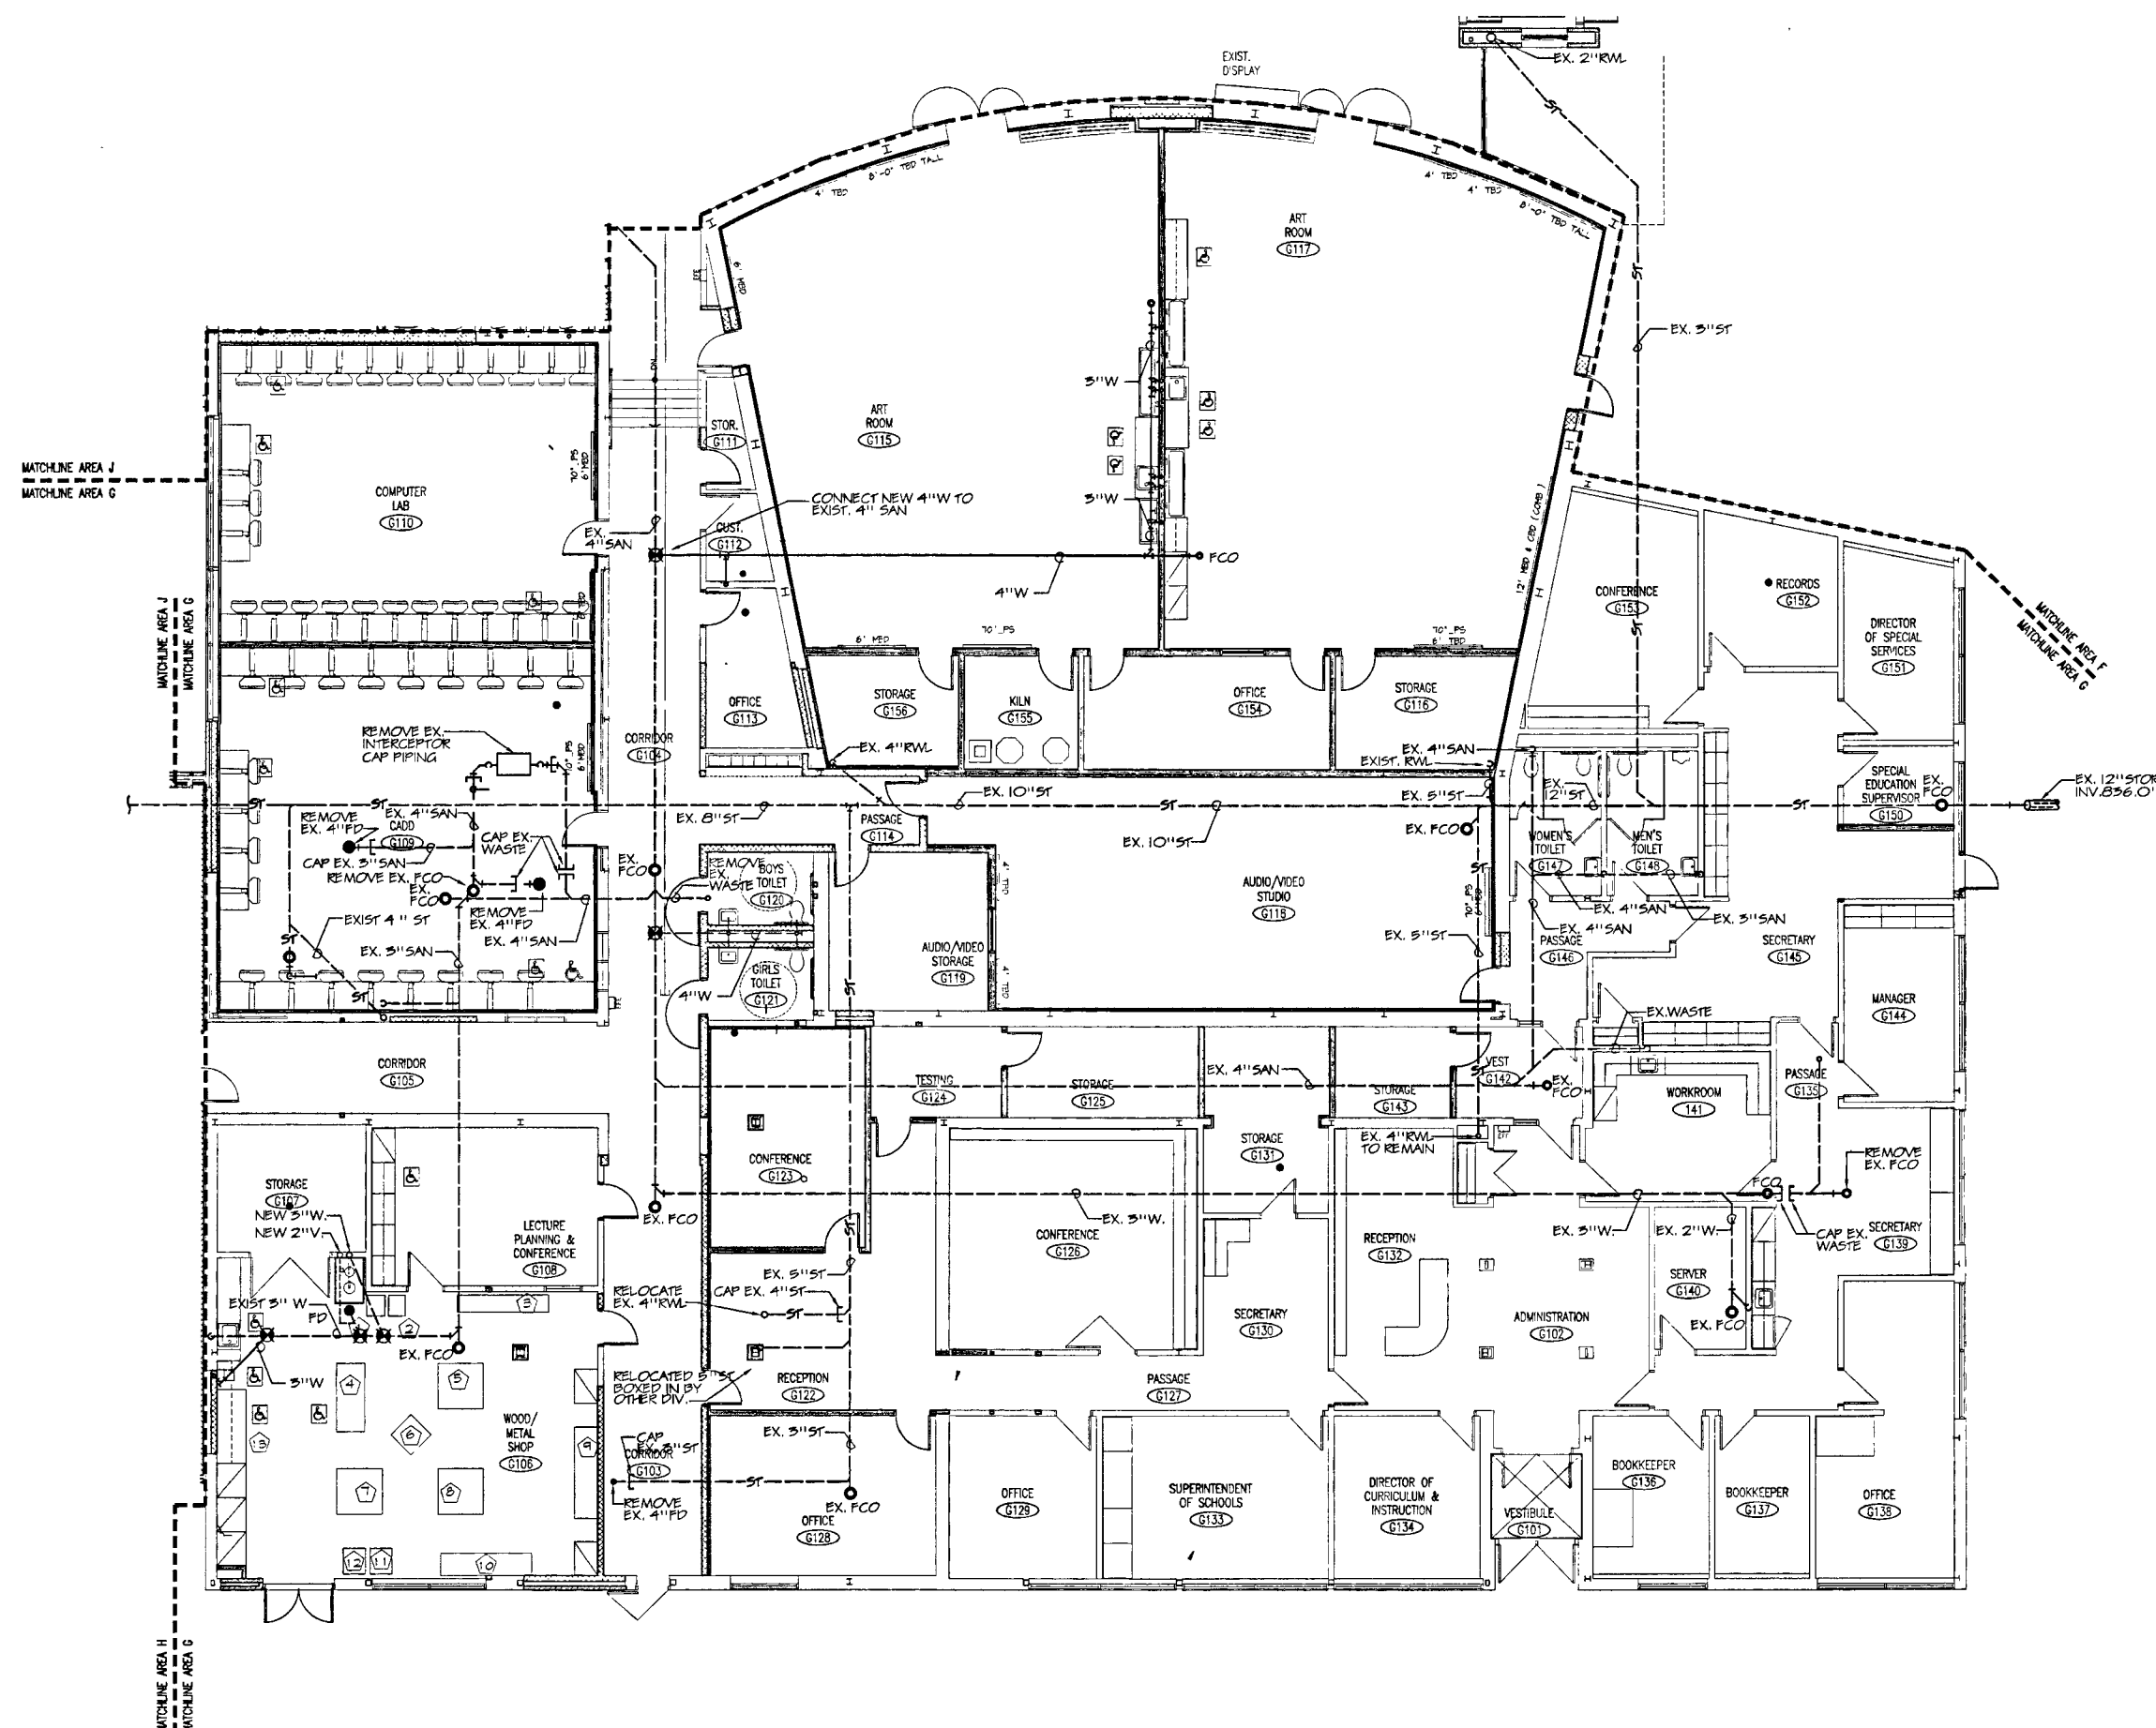

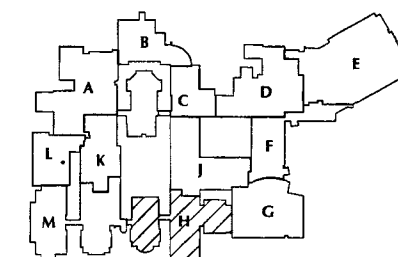

KEY PLAN MAIN LEVEL

REVISIONS		
DATE	MARK	DESCRIPTION
MARCH 1, 2005		ISSUED FOR BIDDING AND CONSTRUCTION PURPOSES (FOR REFERENCE ONLY AS PHASE 1)

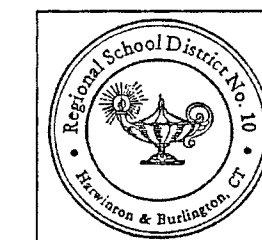

RENOVATIONS AND ADDITIONS TO THE
REGIONAL
SCHOOL
DISTRICT 10
LEWIS S. MILLS
HAR-BUR
COMPLEX

24/26 LYON ROAD
BURLINGTON, CT 06013

STATE PROJECT NO. 210-0036

**WALTER MCILVEEN
ASSOCIATES, INC.**
CONSULTING ENGINEERS
195 WEST MAIN STREET
AVON, CT 06001-0516



**KAESTLE BOOS
ASSOCIATES, INC.**

416 SOUTH RD. NEW BRITAIN, CT 06050 (860) 229-1000
324 GROVE ST. SUITE 215 FARMINGTON, CT 06030 (860) 626-0600
21 NEW HAMPSHIRE AVE. SUITE 125 PORTSMOUTH, NH 03801 (603) 766-1848


DRAWN BY: JML
CHECKED BY: AHC
SCALE: AS NOTED

PLUMBING/FIRE
PROTECTION
MAIN LEVEL
UNDERGROUND FLOOR
PLAN-AREA H

PROJECT NO.: 04000/48114

DRAWING NO.:


DATE: JANUARY 28, 2005 **PFP5.09**

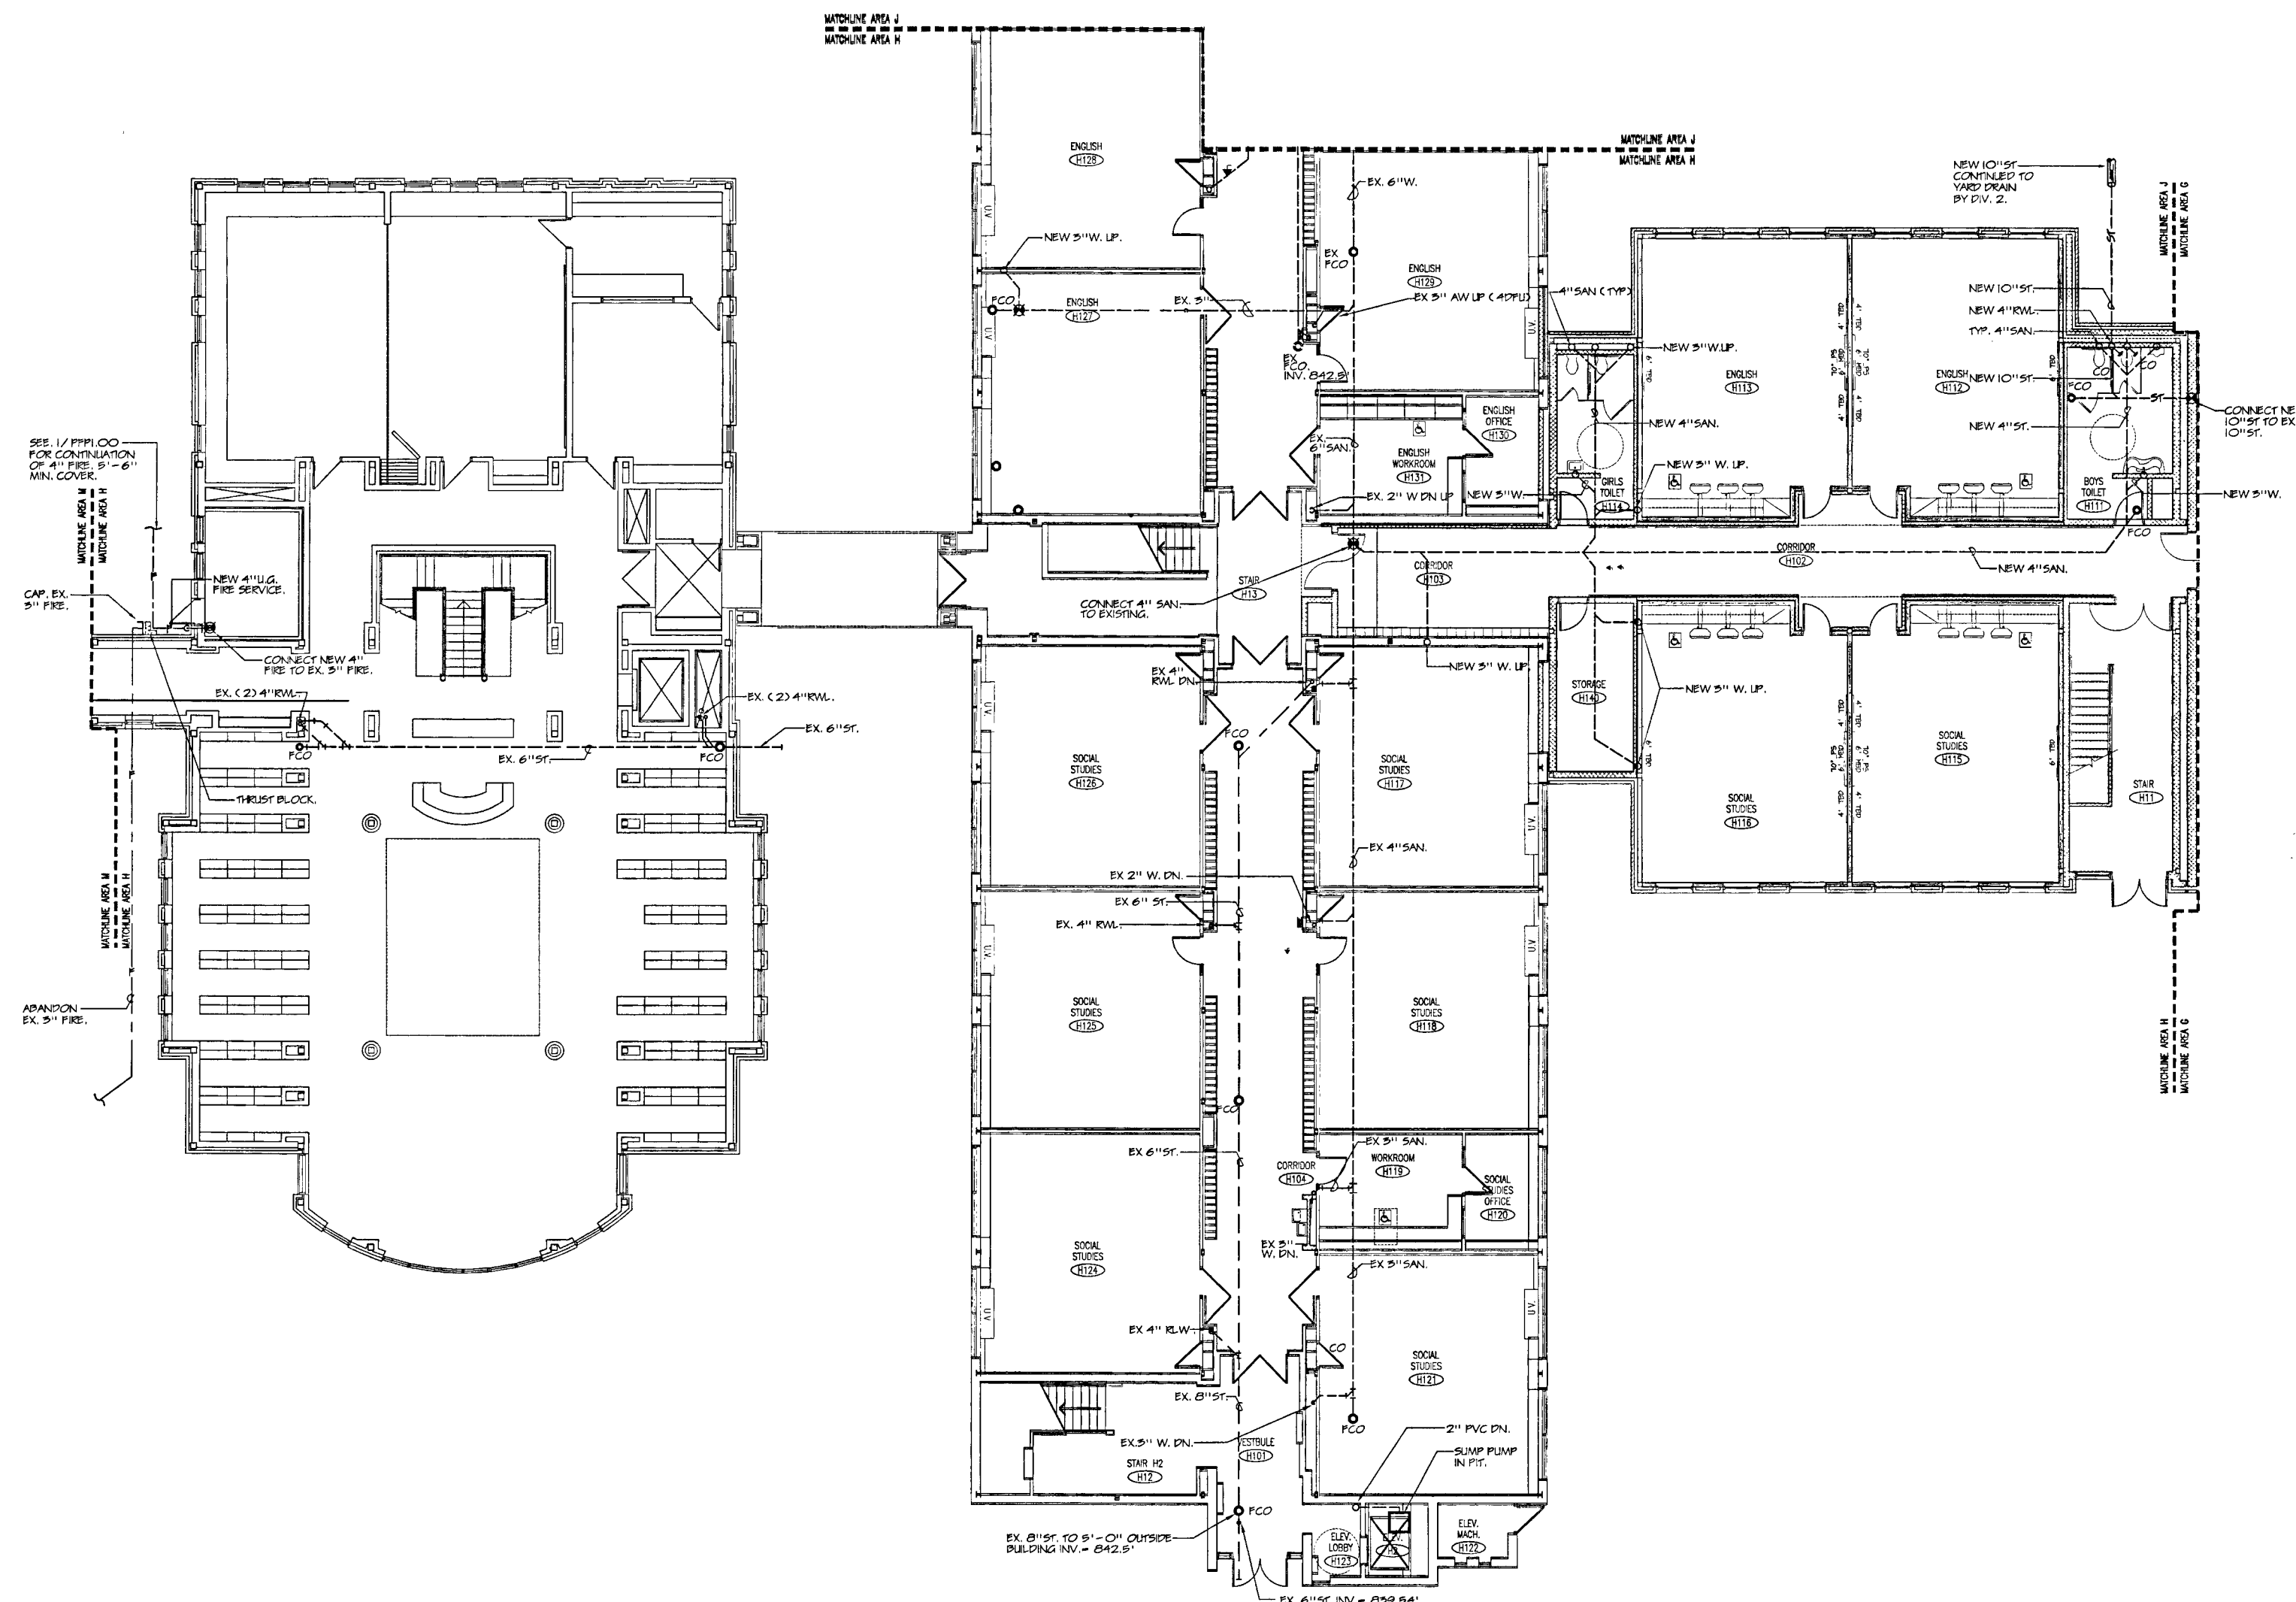

1 PLUMBING/FIRE PROTECTION MAIN LEVEL UNDERGROUND FLOOR PLAN- AREA H
SCALE: 1/8"=1'-0"
NOTES:
1. SEE SYMBOLS, SCHEDULES, NOTES AND DETAILS.


CONTRACTOR TO NOTE

DRAWING IS PROVIDED FOR SITE WORK ONLY.
ALL ROOFTOP EQUIPMENT TO BE PART OF PHASE 3.

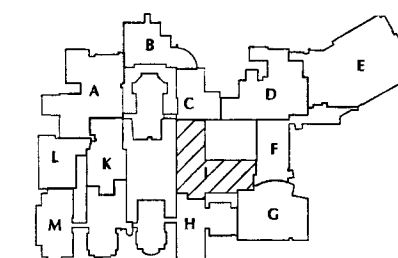

KEY PLAN MAIN LEVEL

DATE	MARK	REVISIONS	DESCRIPTION
MARCH 1, 2005		ISSUED FOR BIDDING AND CONSTRUCTION PURPOSES (FOR REFERENCE ONLY AS PHASE I)	

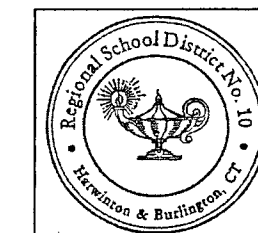

RENOVATIONS AND ADDITIONS TO THE REGIONAL SCHOOL DISTRICT 10 LEWIS S. MILLS HAR-BUR COMPLEX

24/26 LYON ROAD
BURLINGTON, CT 06013

STATE PROJECT NO. 210-0036

WALTER MCILVEEN ASSOCIATES, INC.
CONSULTING ENGINEERS
195 WEST MAIN STREET
AVON, CT 06001-0516



KAESTLE BOOS ASSOCIATES, INC.

416 SUMMIT RD., NEW BRITAIN, CT 06050 (860) 729-0381
124 GROVE ST., SUITE 215, FRANKLIN, MA 02045 (508) 520-9028
100 NEW HAVEN AVE., SUITE 125, HARTFORD, CT 06103 (860) 766-7555


DRAWN BY: JML CHECKED BY: JMC SCALE: AS NOTED

PLUMBING/FIRE PROTECTION MAIN LEVEL UNDERGROUND FLOOR PLAN-AREA J

PROJECT NO.: 04000/48114


DRAWING NO.:

DATE: JANUARY 28, 2005 **FPF5.10**

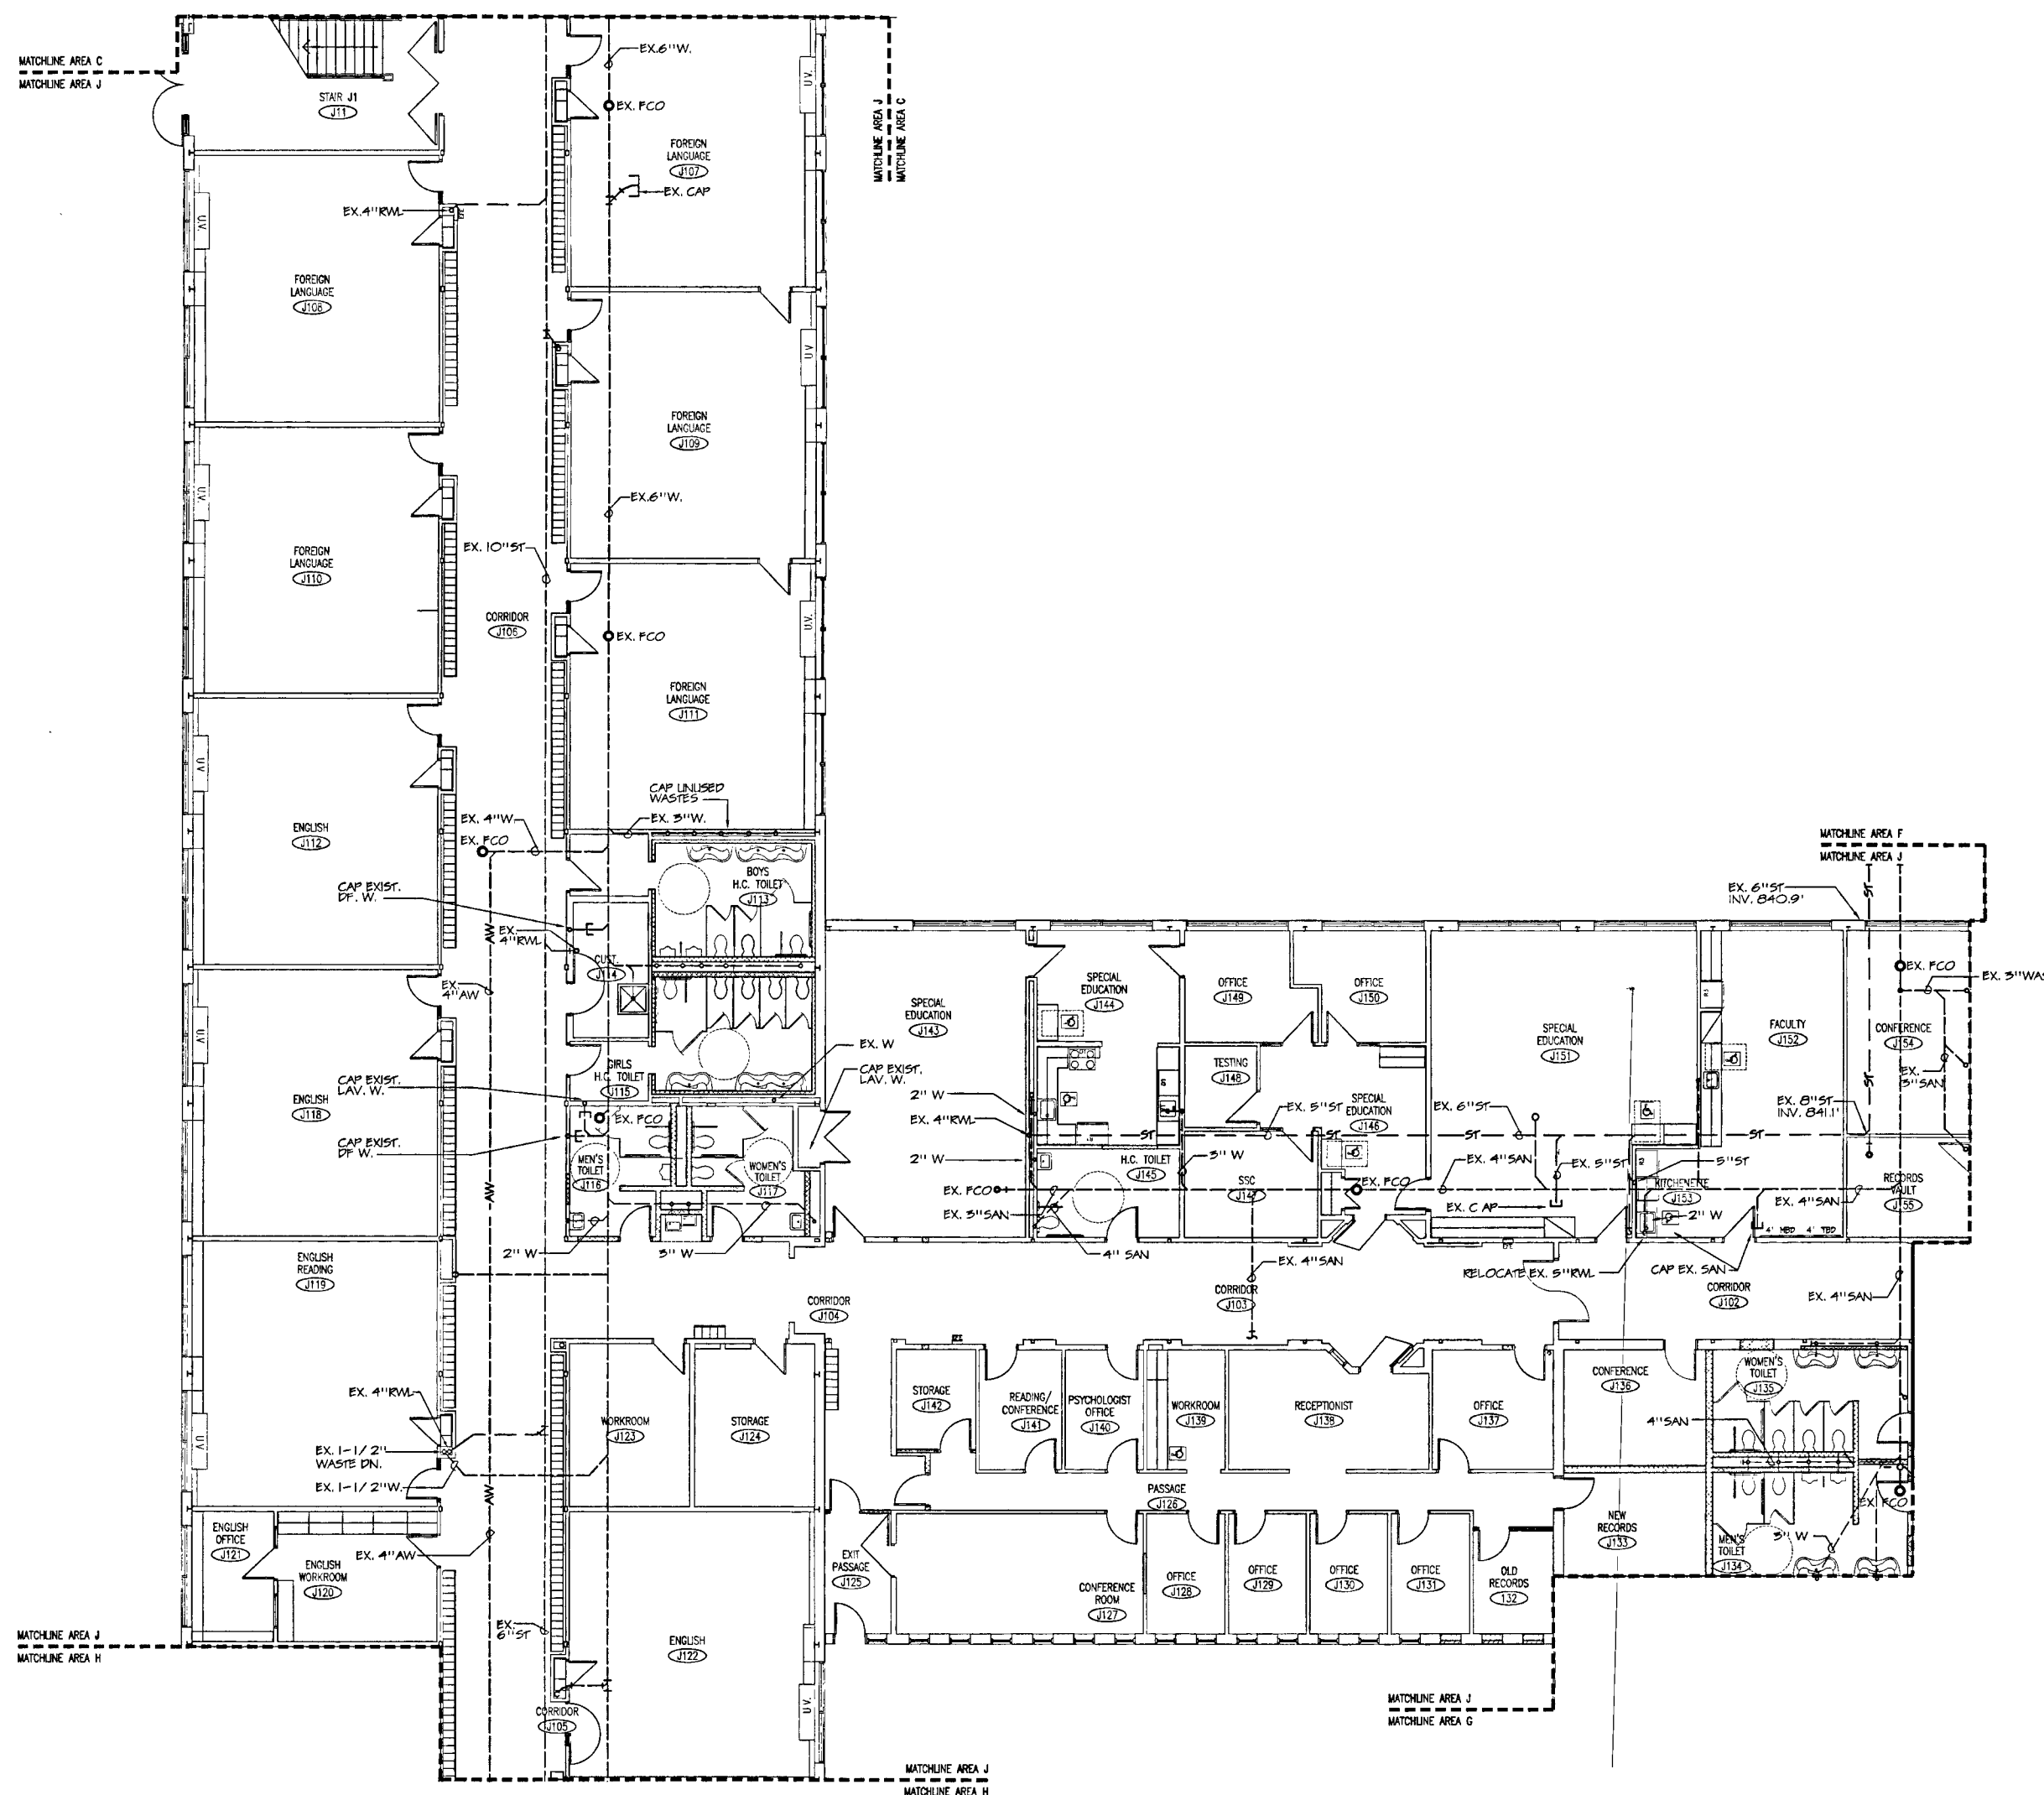


1 PLUMBING/FIRE PROTECTION MAIN LEVEL UNDERGROUND FLOOR PLAN- AREA J
SCALE: 1/8"=1'-0"
NOTES:
1. SEE SYMBOLS, SCHEDULES, NOTES AND DETAILS.

CONTRACTOR TO NOTE
DRAWING IS PROVIDED FOR SITE WORK ONLY
ALL ROOF TOP EQUIPMENT TO BE PART OF PHASE 2.

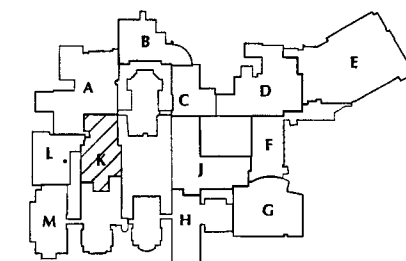

KEY PLAN MAIN LEVEL

DATE	MARK	REVISIONS	DESCRIPTION
MARCH 1, 2005			ISSUED FOR BIDDING AND CONSTRUCTION PURPOSES (FOR REFERENCE ONLY AS PHASE I)

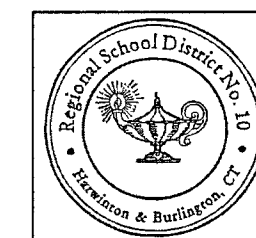


RENOVATIONS AND ADDITIONS TO THE REGIONAL SCHOOL DISTRICT 10 LEWIS S. MILLS HAR-BUR COMPLEX

24/26 LYON ROAD
BURLINGTON, CT 06013

STATE PROJECT NO. 210-0036

WALTER MCILVEEN ASSOCIATES, INC.
CONSULTING ENGINEERS
195 WEST MAIN STREET
AVON, CT 06001-0516

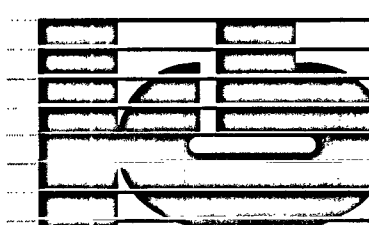

KAESTLE BOOS ASSOCIATES, INC.

116 BLAINE BL. NEW BRITAIN, CT 06053 (800) 789-2000
194 BRIDGE ST. SUITE 215 FARMINGTON, MA 01403 (508) 520-8428
21 NEW HAMPSHIRE AVE. SUITE 125 PORTSMOUTH, NH 03801 (603) 766-1865


DRAWN BY: JML
CHECKED BY: AMG
SCALE AS NOTED

PLUMBING/FIRE PROTECTION MAIN LEVEL UNDERGROUND FLOOR PLAN-AREA K

PROJECT NO. 04000/48114

DRAWING NO.:

DATE: JANUARY 25, 2005 **PFP5.11**

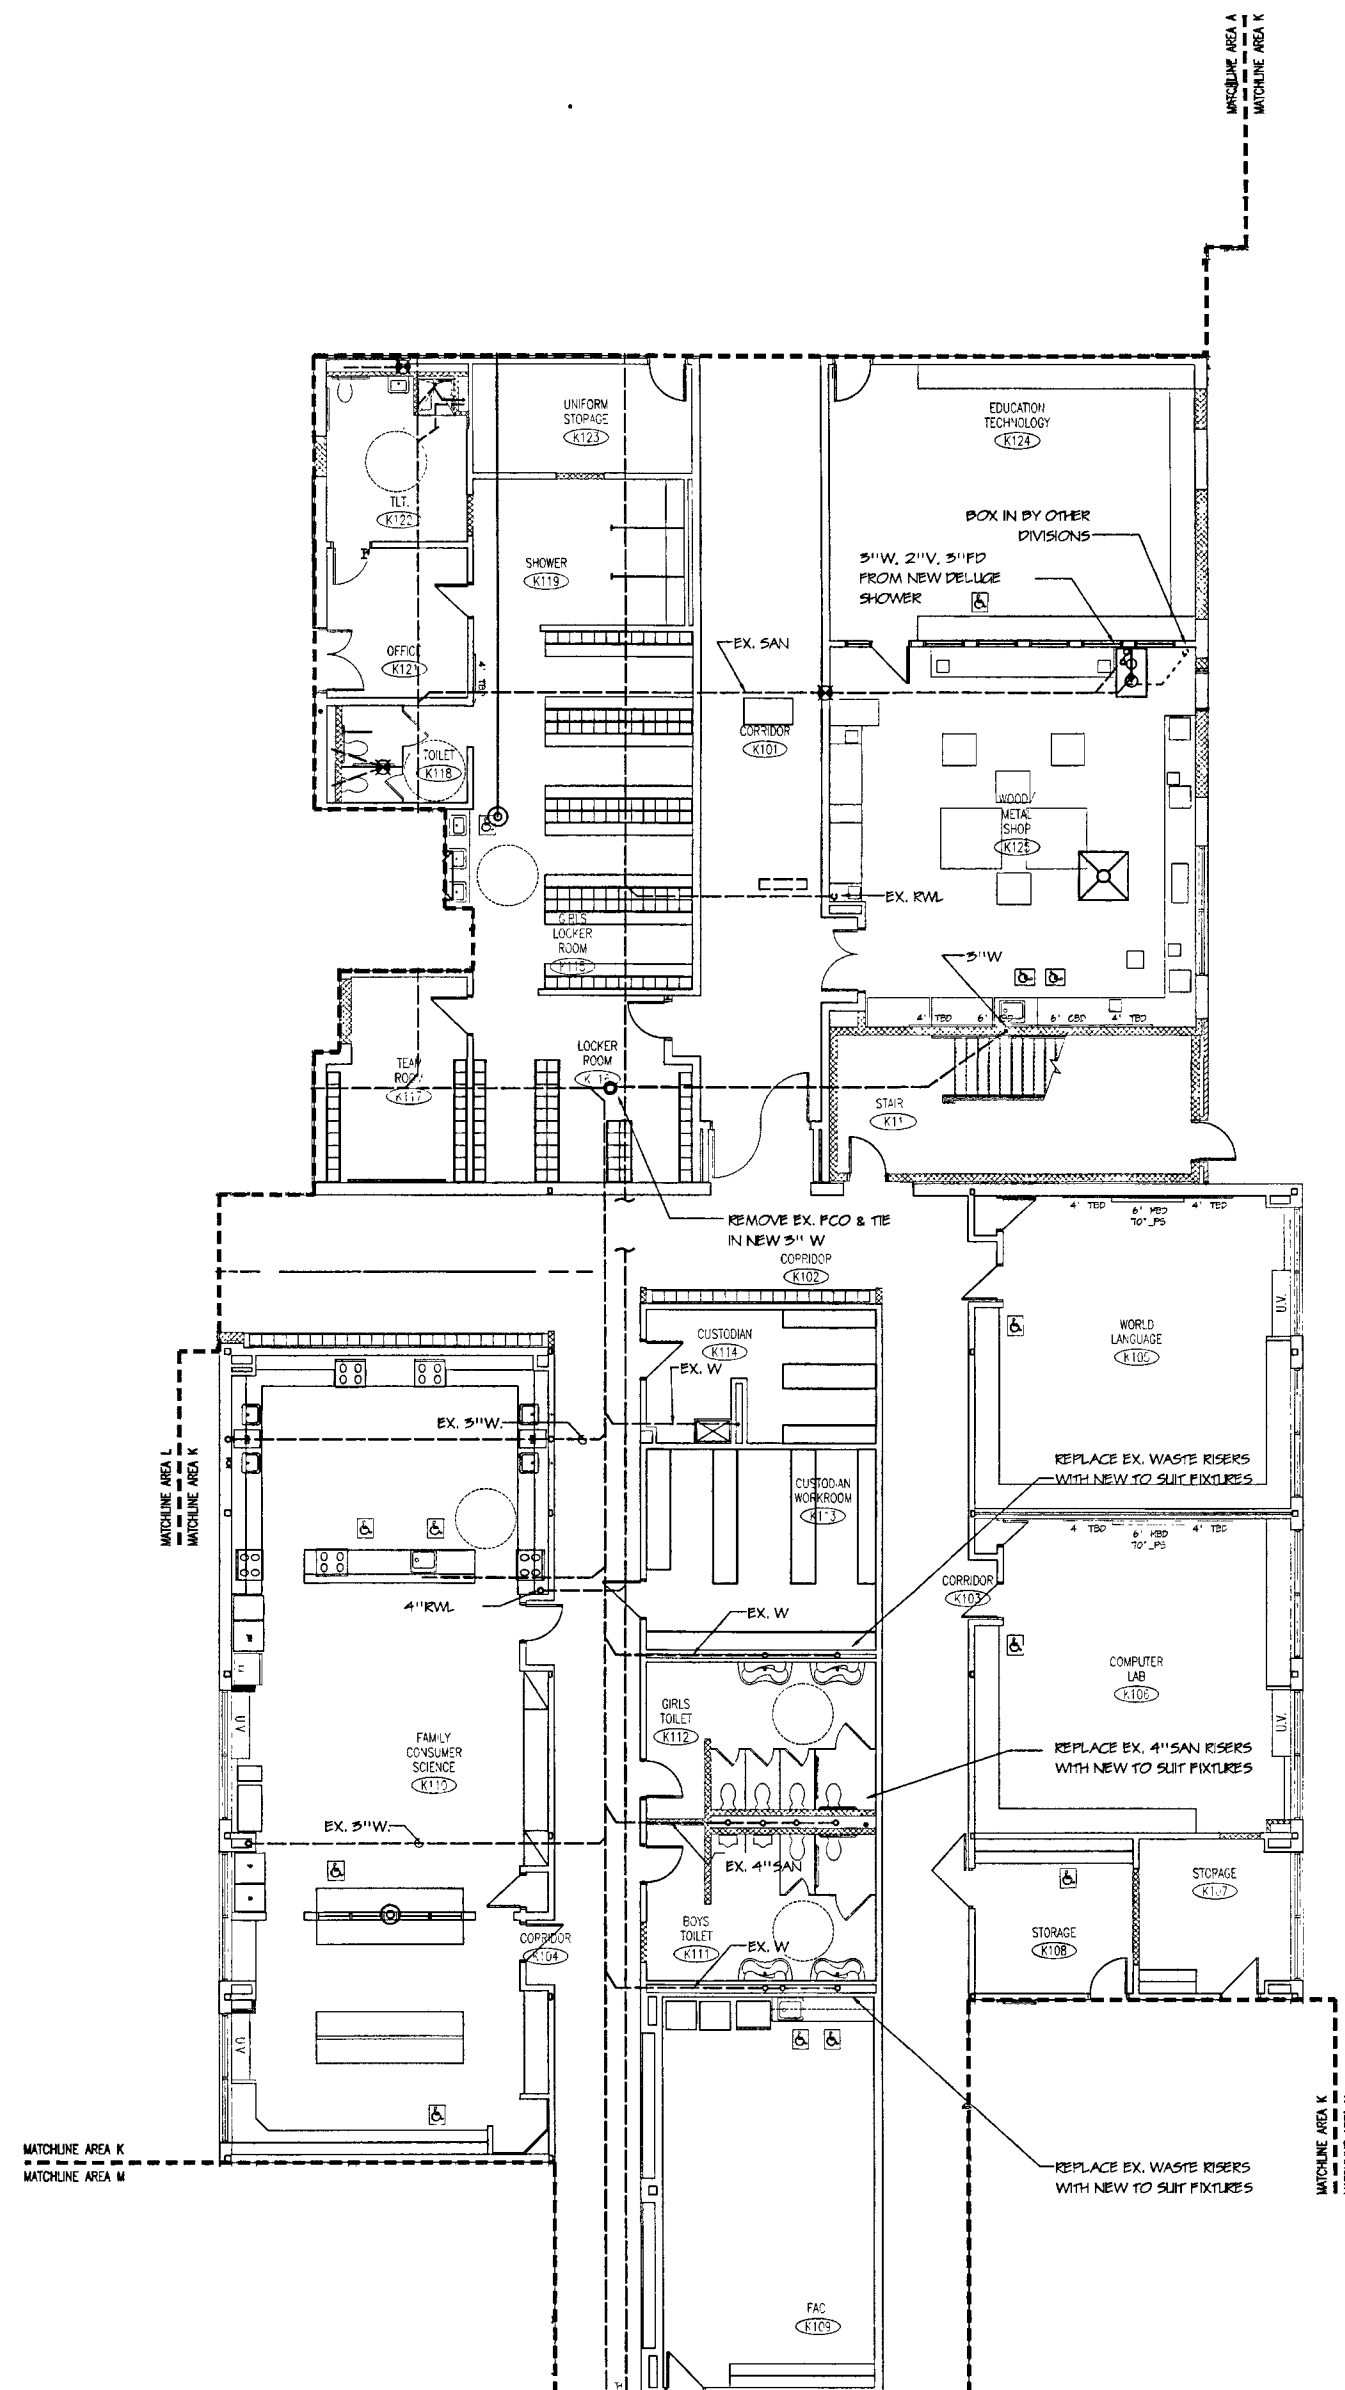

1 PLUMBING/FIRE PROTECTION MAIN LEVEL UNDERGROUND FLOOR PLAN- AREA K


SCALE: 1/8"=1'-0"

NOTES:

1. SEE SYMBOLS, SCHEDULES, NOTES AND DETAILS.


CONTRACTOR TO NOTE

DRAWING IS PROVIDED FOR SITE WORK ONLY.
ALL ROOFTOP EQUIPMENT TO BE PART OF PHASE 3.

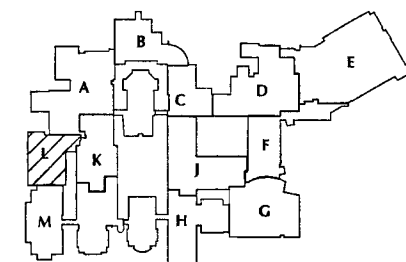

KEY PLAN MAIN LEVEL

REVISIONS		
DATE	MARK	DESCRIPTION
MARCH 1, 2005		ISSUED FOR BIDDING AND CONSTRUCTION PURPOSES (FOR REFERENCE ONLY AS PHASE I)

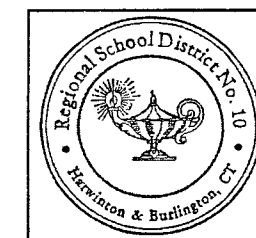

RENOVATIONS AND
ADDITIONS TO THE
REGIONAL
SCHOOL
DISTRICT 10
LEWIS S. MILLS
HAR-BUR
COMPLEX

24/26 LYON ROAD
BURLINGTON, CT 06013

STATE PROJECT NO. 210-0036

**WALTER MCILVEEN
ASSOCIATES, INC.**
CONSULTING ENGINEERS
195 WEST MAIN STREET
AVON, CT 06001-0516



**KAESTLE BOOS
ASSOCIATES, INC.**

416 SOUTH NO. NEW BRITAIN, CT 06050 (860) 259-0281

124 DRIVE ST. SUITE 215 FARMINGTON, CT 06030 (860) 325-9025

27 NEW HAMPSHIRE AVE. SUITE 125 PORTSMOUTH, NH 03801 (603) 766-1565


DRAWN BY: JML CHECKED BY: AMC SCALE: AS NOTED

PLUMBING/FIRE
PROTECTION
MAIN LEVEL
UNDERGROUND FLOOR
PLAN-AREA L

PROJECT NO.: 04000/48114

DRAWING NO.:


DATE: JANUARY 28, 2005 **PPF5.12**

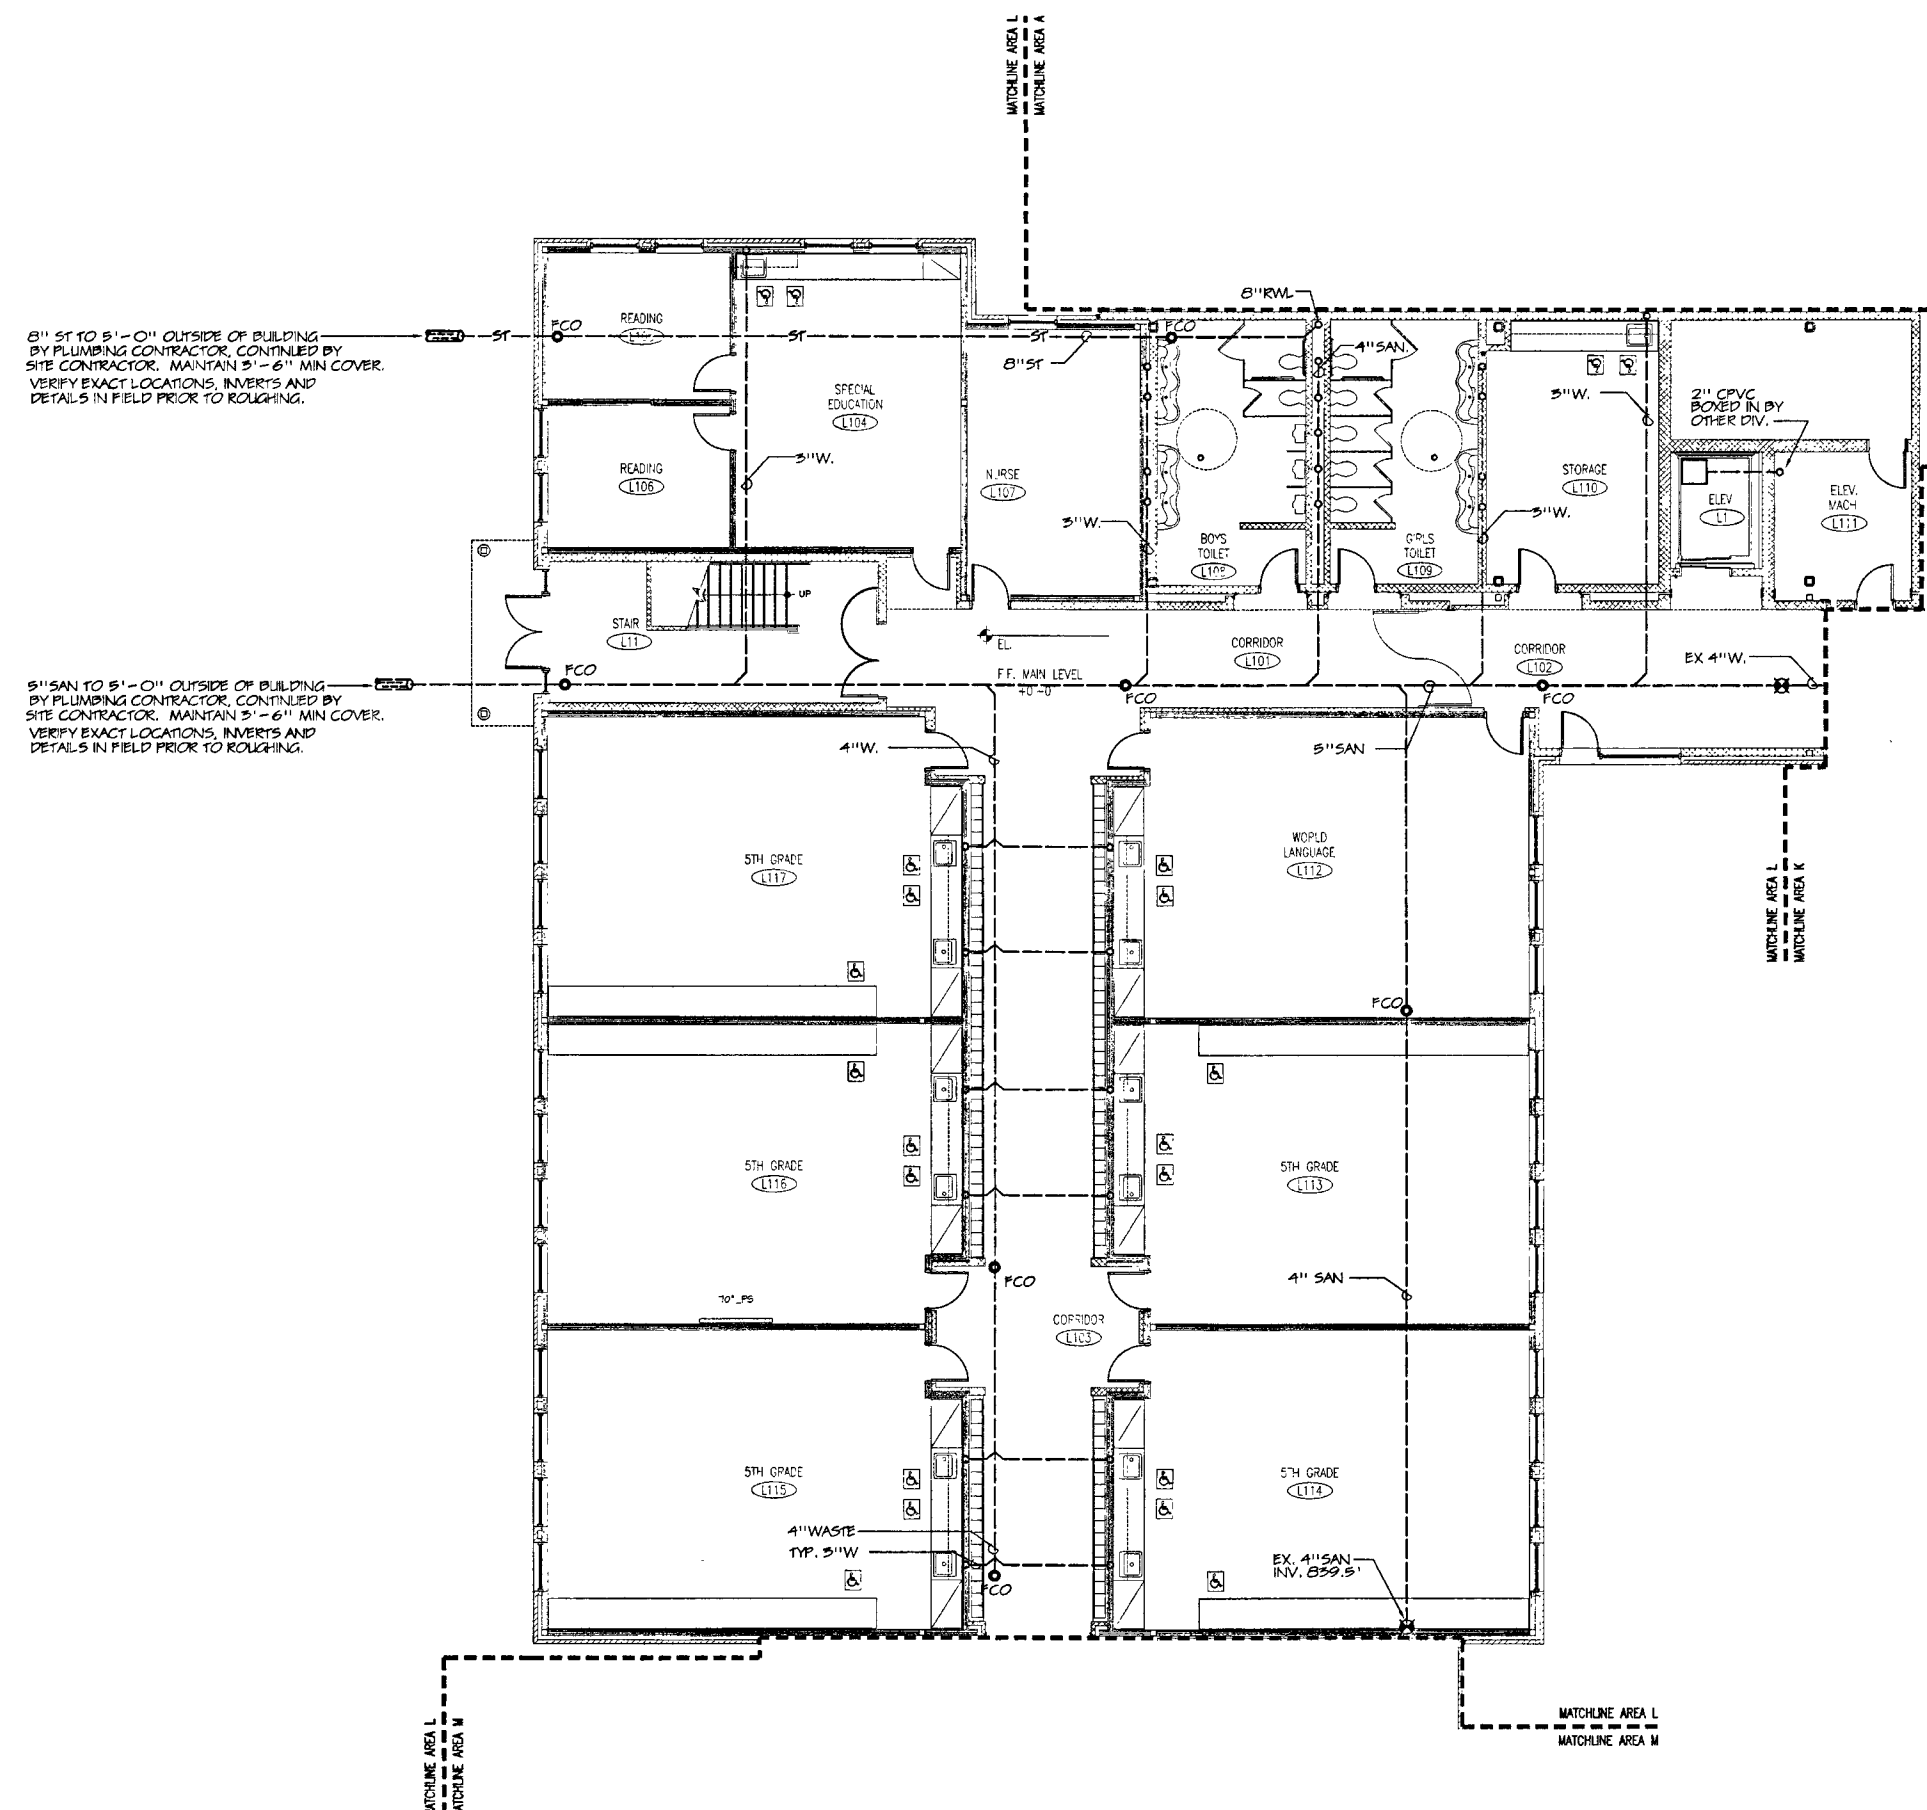

1 PLUMBING/FIRE PROTECTION MAIN LEVEL UNDERGROUND FLOOR PLAN- AREA L
SCALE: 1/8" = 1'-0"
NOTES:
1. SEE SYMBOLS, SCHEDULES, NOTES AND DETAILS.


CONTRACTOR TO NOTE

DRAWING IS PROVIDED FOR SITE WORK ONLY.
ALL ROOFTOP EQUIPMENT TO BE PART OF PHASE 3.

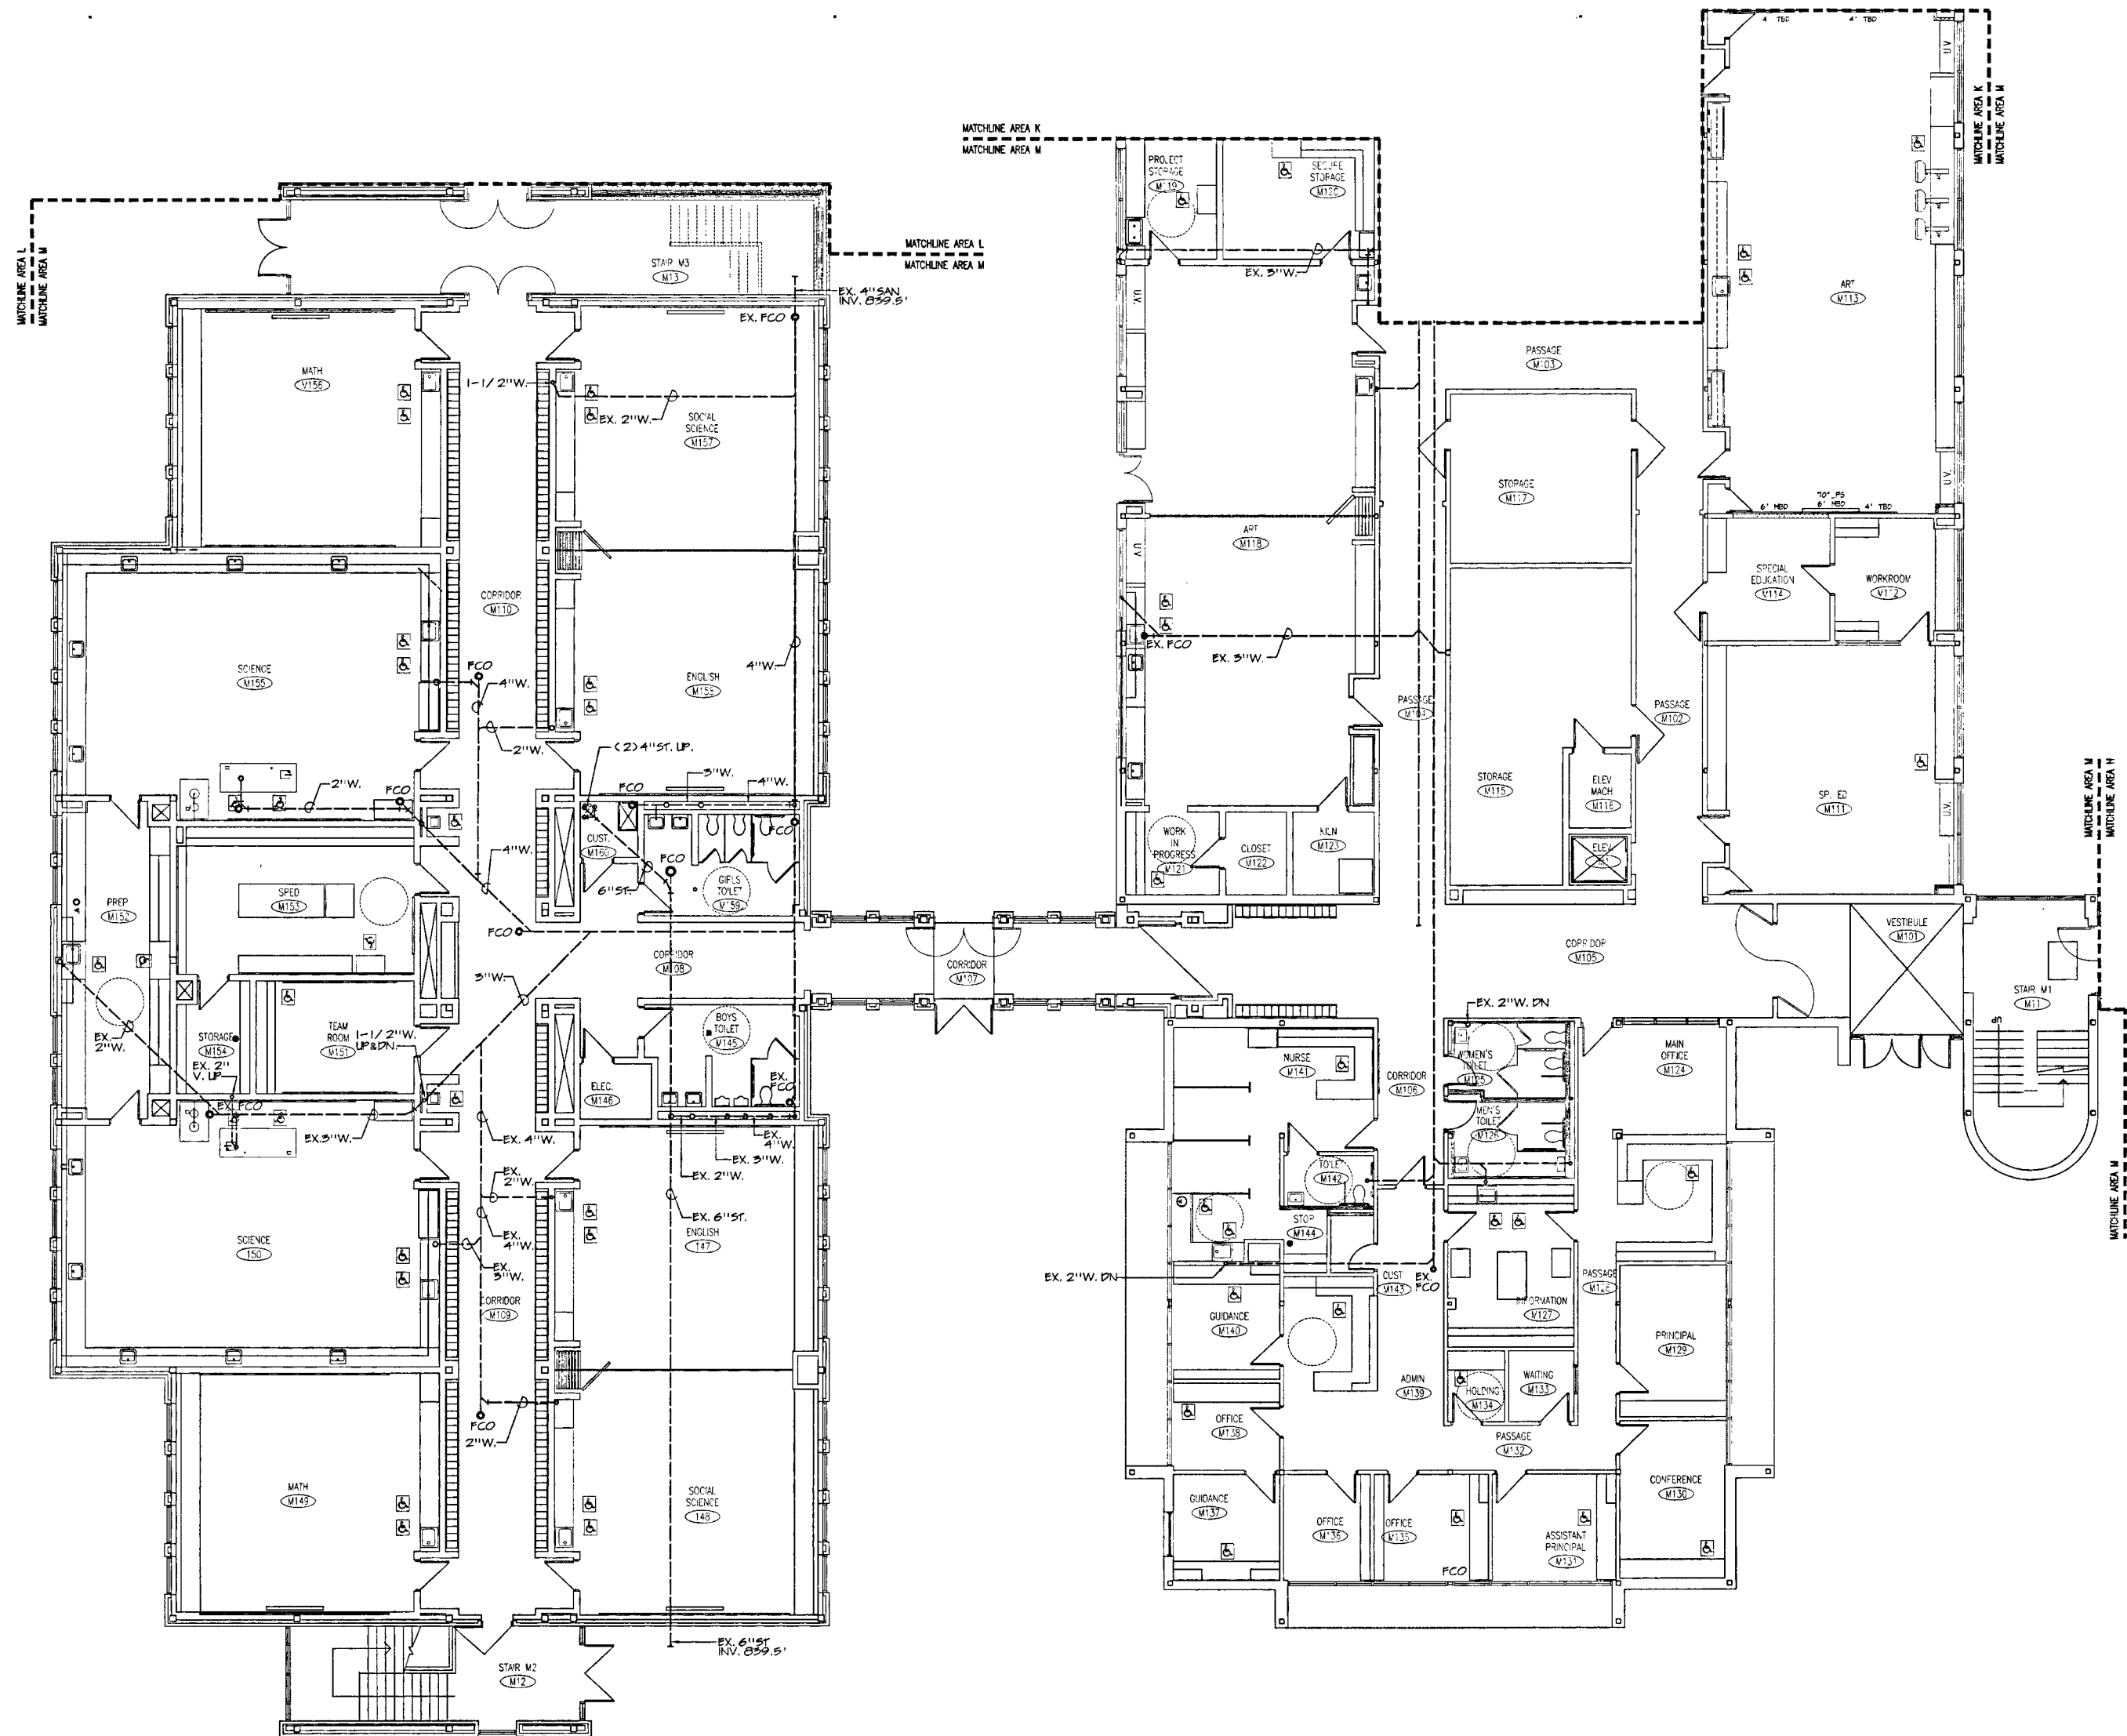


1 PLUMBING/FIRE PROTECTION MAIN LEVEL UNDERGROUND FLOOR PLAN- AREA M
 SCALE: 1/8"=1'-0"
 NOTES:
 1. SEE SYMBOLS, SCHEDULES, NOTES AND DETAILS.

CONTRACTOR TO NOTE
 DRAWING IS PROVIDED FOR SITE WORK ONLY.
 ALL ROOFTOP EQUIPMENT TO BE PART OF PHASE 3.

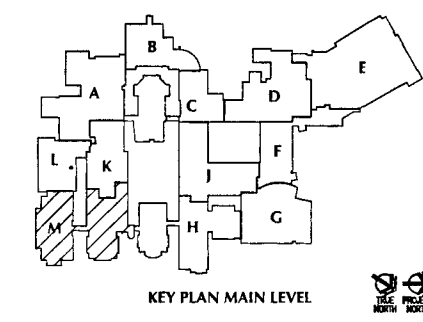

DATE	MARK	REVISIONS	DESCRIPTION
MARCH 1, 2005		ISSUED FOR BIDDING AND CONSTRUCTION PURPOSES (FOR REFERENCE ONLY AS PHASE 1)	

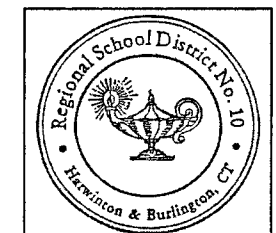

RENOVATIONS AND ADDITIONS TO THE REGIONAL SCHOOL DISTRICT 10 LEWIS S. MILLS HAR-BUR COMPLEX
 24/26 LYON ROAD
 BURLINGTON, CT 06013

STATE PROJECT NO. 210-0036
WALTER MCILVEEN ASSOCIATES, INC.
 CONSULTING ENGINEERS
 195 WEST MAIN STREET
 AVON, CT 06001-0516

KAESTLE BOOS ASSOCIATES, INC.

PLUMBING/FIRE PROTECTION MAIN LEVEL UNDERGROUND FLOOR PLAN-AREA M

