

ABBREVIATIONS

Table with 3 columns listing abbreviations and their corresponding full names, such as # 48" ABOVE FINISHED FLOOR, AC AMP, AC AIR COMPRESSOR, etc.

HVAC DEMOLITION GENERAL NOTES

- 1. BEFORE SUBMITTING BID, THE CONTRACTORS SHALL VISIT THE JOB SITE AND BECOME FULLY FAMILIAR WITH THE EXISTING CONDITIONS... 2. THE CONTRACTOR SHALL COORDINATE AND SCHEDULE ANY DAILY INTERRUPTIONS OR SHUTDOWNS... 3. DEMOLITION DRAWINGS ARE STRICTLY DIAGRAMMATIC AND SHOW GENERAL ARRANGEMENT AND APPROXIMATE LOCATION...

HVAC GENERAL NOTES

- 1. ALL WORK SHALL BE PERFORMED IN COMPLIANCE WITH CURRENT APPLICABLE CODES, ORDINANCES, REGULATORY AGENCIES HAVING JURISDICTION... 2. THE INTENT OF THESE DOCUMENTS IS FOR THE MEP TRADES TO FURNISH AND INSTALL COMPLETE MECHANICAL AND ELECTRICAL SYSTEMS... 3. THE TRADES SHALL OBTAIN AND REVIEW ALL CONTRACT DOCUMENTS BEFORE SUBMITTING THEIR BID...

GENERAL SYMBOLS

Table mapping line styles to descriptions: solid line for THICK, DARK SOLID LINES INDICATE NEW OR RELOCATED ITEMS; dashed line for THIN, LIGHT LINES INDICATE EXISTING ITEMS.

FITTINGS AND VALVES

Table mapping symbols to fitting/valve names: BACKFLOW PREVENTOR, STRAINER OR STRAINER WITH BLOW-DOWN, PIPE ELBOW UP OR PIPE TEE UP, etc.


HVAC SYMBOLS

Table mapping symbols to HVAC equipment and components: RECTANGULAR, FLAT OVAL OR ROUND AIR DUCT; AIR DUCT WITH ACOUSTICAL LINING; SUPPLY AIR DUCT UP; etc.

KAESTLE BOOS associates, inc

416 Slater Road, P.O. Box 2590, New Britain, CT 06500-2590
Phone: P: 860-229-5303 Fax: 860-229-0361
325 Foxborough Boulevard, Suite 100, Foxborough, MA 02035
Phone: A Fax: 508-549-9907 508-549-9906


Email: kba@kba-architects.com Website: www.kba-architects.com

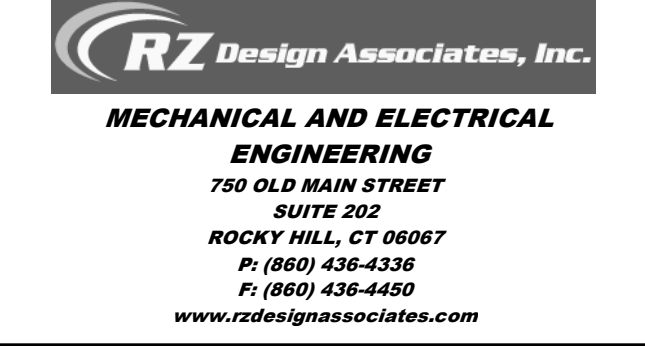

NOTE: THESE DOCUMENTS ARE NOT THE CONTRACT DOCUMENTS. THIS SET IS ISSUED SOLELY FOR THE CONVENIENCE OF THE CONSTRUCTION MANAGER... NOTE: THESE DOCUMENTS ARE NOT THE CONTRACT DOCUMENTS...

ISSUE DATE table with columns DATE and DESCRIPTION. Row: NOVEMBER 5, 2018 PHASE 2 CONFORMED

REVISIONS table with columns DATE and DESCRIPTION. Row: NOVEMBER 5, 2018 PHASE 2 CONFORMED

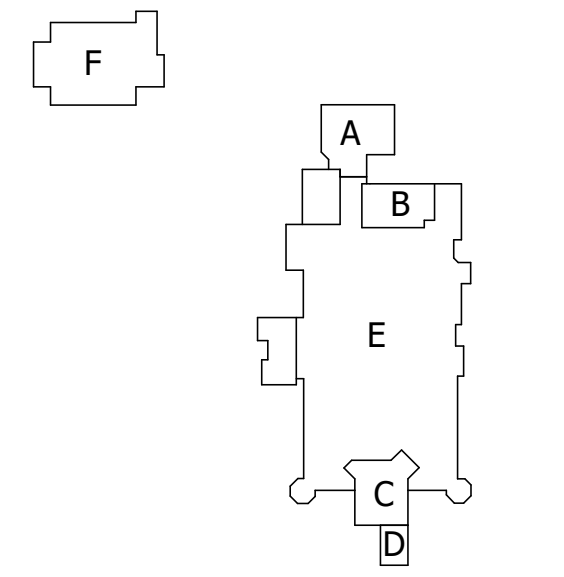

SCALE: AS NOTED PROJECT TRUE



NEW AGRISCIENCE STEM ACADEMY ADDITIONS & ASSOCIATED RENOVATIONS SHEPAUG VALLEY SCHOOL 159 SOUTH STREET WASHINGTON, CT 06794 SCIENCE SPN: 212-0025 A/EC VO-AG SPN: 212-0026 VA/N

PROJECT NO.: 15073.00 DRAWN BY: PA

MECHANICAL LEGENDS AND GENERAL NOTES

DRAWING NO.: M0.01

2016 © COPYRIGHT KAESTLE BOOS ASSOC., INC.