

Liberty School District – LED Lighting Upgrades
Addendum No: 001
Description Narrative
September 5, 2023

This Addendum is issued to all registered plan holders pursuant to the Instructions to Bidders and Conditions of the Contract. This Addendum serves to clarify, revise, and supersede information in the Project Manual, Drawings, and previously issued Addenda. Portions of the Addendum affecting the Contract Documents will be incorporated into the Contract by enumeration of the Addendum in the Owner/Contractor Agreement.

The Bidder shall acknowledge receipt of this Addendum in the appropriate space on the Bid Form.

A. CONSTRUCTION MANAGER'S FRONT END MANUAL

Bid Date has changed to September 11 1:00PM.

B. OTHER

NA

C. SPECIFICATIONS

NA

D. DRAWINGS

- 1. Please reference the attached Addendum No. 001 issued by Smith and Boucher dated September 05, 2023, for updates to Drawings.**

Please direct any questions regarding the information in this addenda and the project to Newkirk Novak Construction Partners.

**Liberty North High School Lighting Upgrades
Smith & Boucher Project No. 2314711**

09/05/2023

To Documents Titled:

Liberty North High School Lighting
Upgrades
08/11/2023

Architect-of-Record:

Hollis and Miller
1828 Walnut Street Suite 922
Kansas City, MO 64108

The Contract Documents for the above referenced project and the Work covered thereby are modified as described herein.

DRAWINGS

1. Sheet E100H- LOWER LEVEL – AREA H
 - a. Added entire sheet for missing lower levels rooms.
2. Sheet E101A-MAIN LEVEL – AREA A
 - a. Added in missing corridor lighting.
3. Sheet E101B-MAIN LEVEL – AREA B
 - a. Revised corridor troffers and troffers in small rooms to be RA-L indicating that the flat panel troffer to be set on the lowest output level.
4. Sheet E101C-MAIN LEVEL – AREA C
 - a. Revised corridor troffers and troffers in small rooms to be RA-L indicating that the flat panel troffer to be set on the lowest output level.
5. Sheet E101D-MAIN LEVEL – AREA D
 - a. Revised corridor troffers and troffers in small rooms to be RA-L indicating that the flat panel troffer to be set on the lowest output level.
 - b. Added in missing section of classrooms and corridor that was cut off by top of drawing, added it off to the side.
6. Sheet E101E-MAIN LEVEL – AREA E
 - a. Revised corridor troffers and troffers in small rooms to be RA-L indicating that the flat panel troffer to be set on the lowest output level.
7. Sheet E101F-MAIN LEVEL – AREA F
 - a. Revised corridor troffers and troffers in small rooms to be RA-L indicating that the flat panel troffer to be set on the lowest output level.
8. Sheet E101G-MAIN LEVEL – AREA G
 - a. Revised corridor troffers and troffers in small rooms to be RA-L indicating that the flat panel troffer to be set on the lowest output level.
 - b. Added in missing troffers in corridors and classroom and storage room.
9. Sheet E101H-MAIN LEVEL – AREA H
 - a. Revised corridor troffers and troffers in small rooms to be RA-L indicating that the flat panel troffer to be set on the lowest output level.
 - b. Added in missing troffers in corridors and classroom and restrooms.
 - c. Removed troffers from weight room area, this area to be existing to remain.
10. Sheet E102A-UPPER LEVEL – AREA A
 - a. Revised corridor troffers and troffers in small rooms to be RA-L indicating that the flat panel troffer to be set on the lowest output level.
 - b. Added in missing troffers in corridors.
 - c. Added in hatch for clarify of area with existing LED troffers.

11. Sheet E102B-UPPER LEVEL – AREA B
 - a. Revised corridor troffers and troffers in small rooms to be RA-L indicating that the flat panel troffer to be set on the lowest output level.
 - b. Added in missing troffers in corridor/upper lobby area and storage room.
12. Sheet E102D-UPPER LEVEL – AREA D
 - a. Revised corridor troffers and troffers in small rooms to be RA-L indicating that the flat panel troffer to be set on the lowest output level.
13. Sheet E102E-UPPER LEVEL – AREA E
 - a. Revised corridor troffers and troffers in small rooms to be RA-L indicating that the flat panel troffer to be set on the lowest output level.
- ~~14. Sheet E102H-UPPER LEVEL – AREA H~~
 - a. Sheet removed from plans since area does not exist.
15. Sheet E301-Schedules
 - a. Added Signify to approved manufactures.

Attachments

- See the drawing list above.

END OF MEP ITEMS FOR ADDENDUM NO. 1

**Liberty Discovery Middle School Lighting Upgrades
Smith & Boucher Project No. 2314702**

**Liberty South Valley Middle School Lighting Upgrades
Smith & Boucher Project No. 2314703**

**Liberty Epic Elementary School Lighting Upgrades
Smith & Boucher Project No. 2314704**

09/05/2023

To Documents Titled:
See titles above.
08/31/2023

Architect-of-Record:
Hollis and Miller
1828 Walnut Street Suite 922
Kansas City, MO 64108

The Contract Documents for the above referenced project and the Work covered thereby are modified as described herein.

 
DRAWINGS

1. Sheet E301-Schedules
 - a. Added Signify Fluxpanel to approved manufactures.

Attachments

- No attachments, just listed approved manufacturer above.

END OF MEP ITEMS FOR ADDENDUM NO. 1



CONTRACTOR TO ONE FOR ONE
REMOVE AND DISPOSE OF ALL
2'X2' AND 2'X4' FLOURESCENT
TROFFERS AND REPLACE AND
RECONNECT WITH NEW LED
TROFFERS AS SHOWN.

A1	Scale	LIGHTING PLAN - AREA A - LEVEL 1
	1/8" = 1'-0"	

hollis + miller[®] architects[®]

Holla + Miller Architects
Missouri State Certificate of Authority
Architecture # 0000151
Structure # 2006031333


N

Liberty North High School Lighting Upgrades

Liberty Public Schools
1000 NE 104th Street
Liberty, MO 64068

**100%
CONSTRUCTION
DOCUMENTS**

F

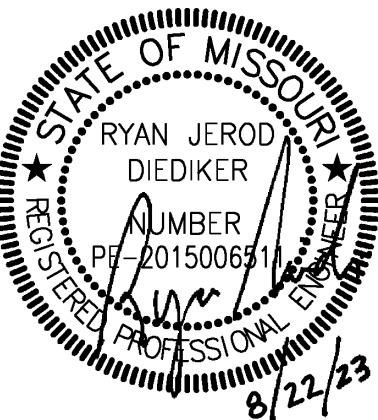


The Professional Architects seal affixed to this sheet applies only to the material and items shown on this sheet. All drawings, instruments or other documents not exhibiting this seal shall not be considered prepared by this architect, and this architect expressly disclaims any and all responsibility for such plan, drawings, or documents not exhibiting


B

A

KEY PLAN

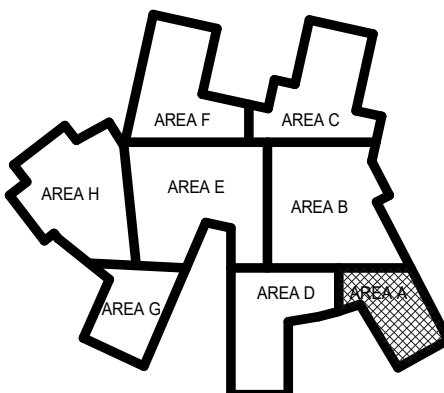

LIGHTING PLAN - AREA A - LEVEL 1

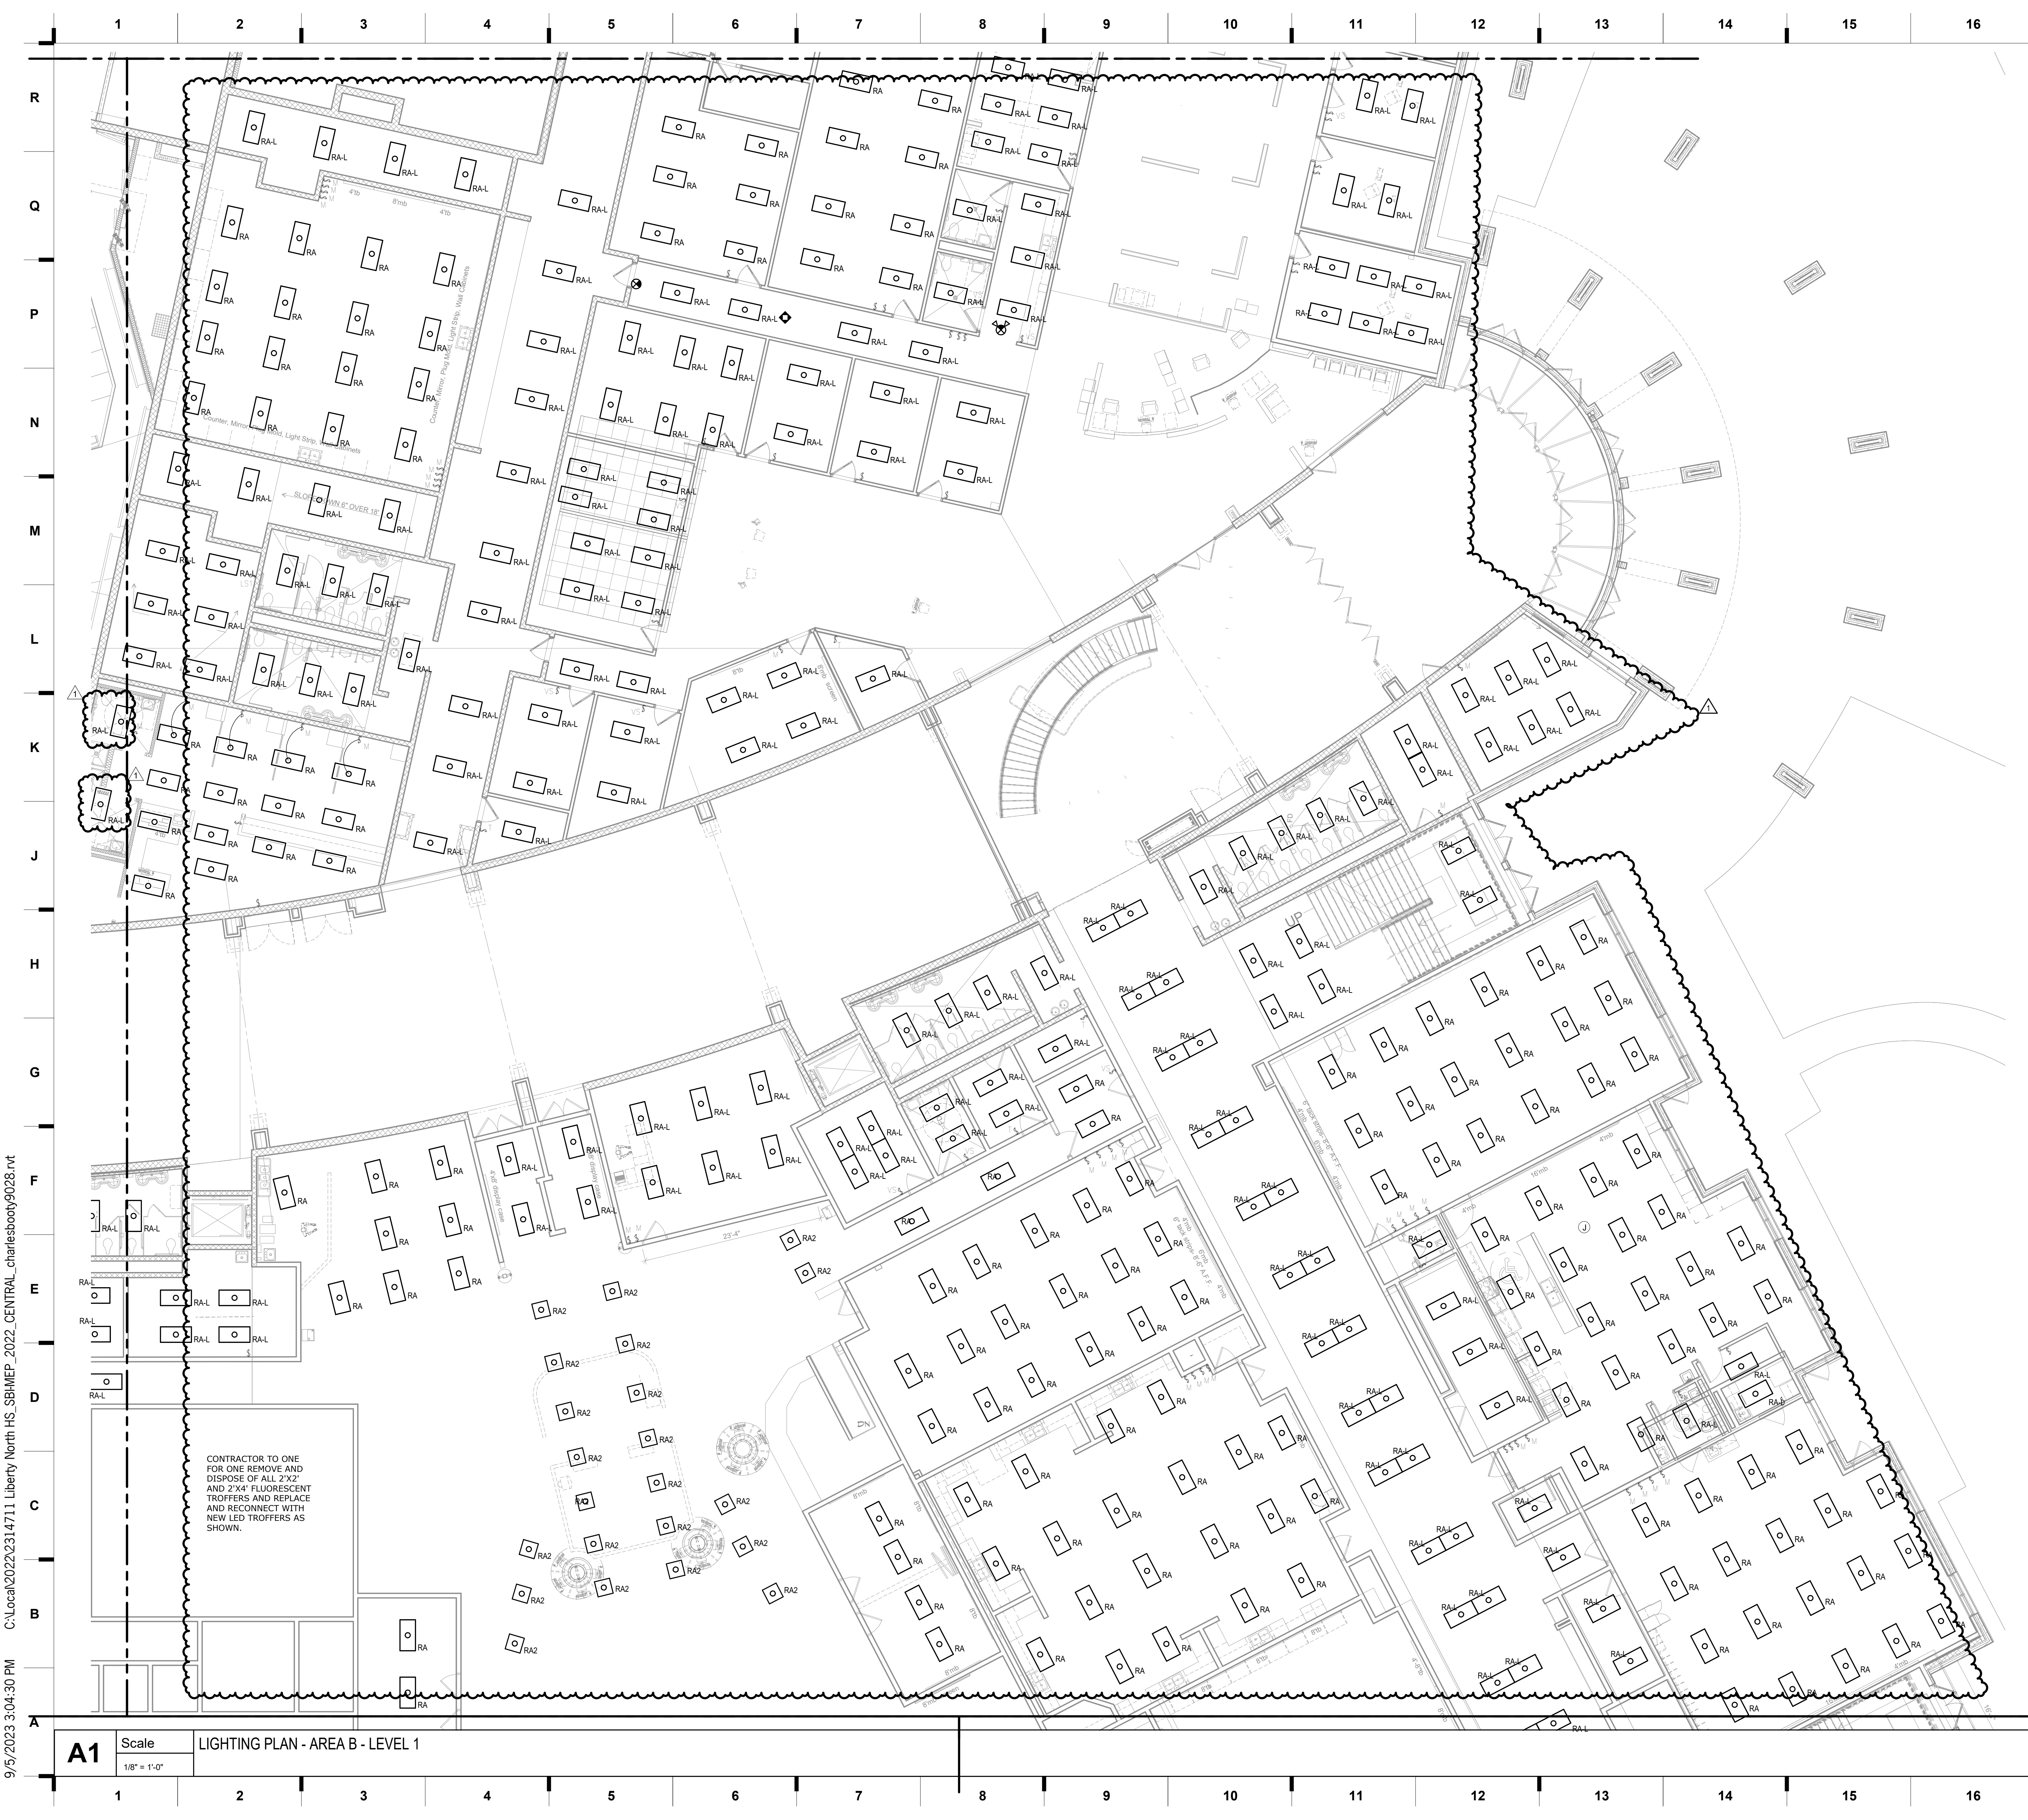


C:\Local\2022\2314711 Liberty North HS_SBI MEP_2022_CENTRAL_charlesboot\9028.rvt

9/5/2023 3:04:30 PM

A1 Scale LIGHTING PLAN - AREA B - LEVEL 1
1/8" = 1'-0"

SHEET KEYNOTE LEGEND

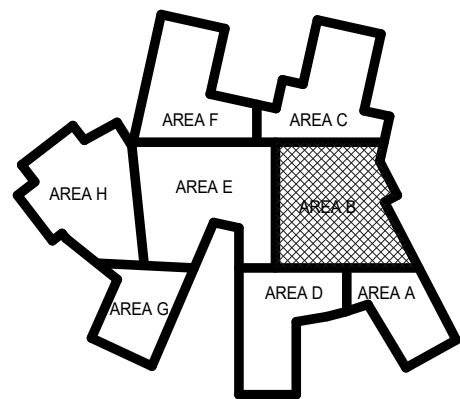


KEY PLAN

smith & boucher
engineers
25618 west 103rd St. olathe, ks 66061
phone 913.345.2127 fax 913.345.0617
project number 2314711

REVISIONS:		
#	Description	Date
1	Addendum #1	09/05/2023

Liberty North High School Lighting Upgrades
Liberty Public Schools
1000 NE 104th Street
Liberty, MO 64068

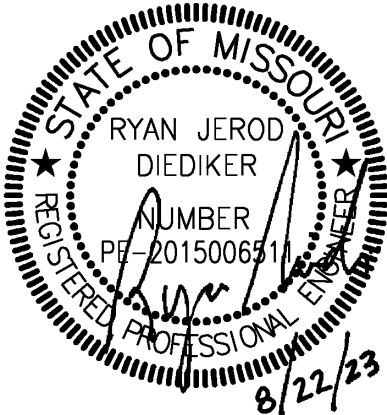

JOB NO: 21121.00
DRAWN BY: SBI
CHECKED BY: RJD
DATE: 08-22-2023

E101B

we design the future®
1828 Walnut Street Suite 922
Kansas City, MO 64108
t 816.442.7700

115 Wilcox Street Suite 210
Castle Rock, CO 80104
t 720.949.1689

HOLLISANDMILLER.COM

Hollis + Miller Architects
Maine State Certificate of Authority
Architecture # 0001311
Structural # 00001101

Smith & Boucher
Mechanic, Electric, Plumbing
State Certificate of Authority #ECC000178
25618 W 103rd Street
Olathe, KS 66061
913.345.2127 phone

100%
CONSTRUCTION
DOCUMENTS



hollis + miller architects®

9/5/2023 3:04:37 PM C:\local20222314711 Liberty North HS_SBI MEP_2022_CENTRAL_charlesboot9028.rvt




A1 Scale LIGHTING PLAN - AREA C - LEVEL 1
1/8" = 1'-0"

SHEET KEYNOTE LEGEND

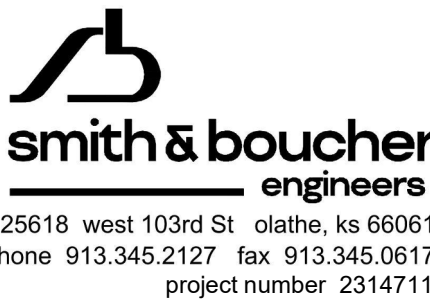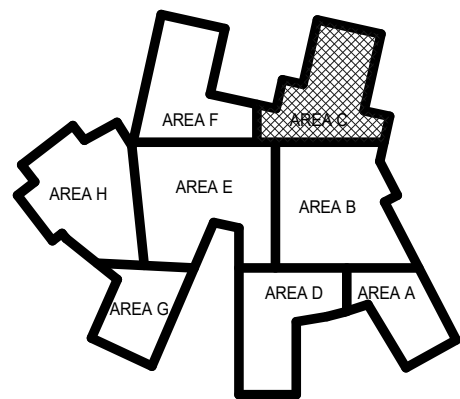

KEY PLAN

REVISIONS:		
#	Description	Date
1	Addendum #1	09/05/2023

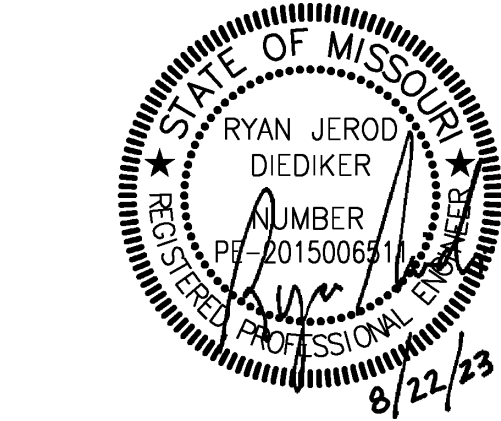

JOB NO: 21121.00
DRAWN BY: SBI
CHECKED BY: RJD
DATE: 08-22-2023

E101C

LIGHTING PLAN - AREA C - LEVEL 1

Liberty North High School Lighting Upgrades

Liberty Public Schools
1000 NE 104th Street
Liberty, MO 64068

100%
CONSTRUCTION
DOCUMENTS


we design the future®
1828 Walnut Street Suite 922
Kansas City, MO 64108
t 816.442.7700
115 Wilcox Street Suite 210
Castle Rock, CO 80104
t 720.949.1689
HOLLISANDMILLER.COM

Hollis + Miller Architects
Maine State Certificate of Authority
Architecture # 0001311
Structural # 00001103

Smith & Boucher
Mechanic, Electric, Plumbing
State Certificate of Authority #EGC000178
25618 W 103rd Street
Olathe, KS 66061
913.345.2127 phone

hollis + miller architects®

9/5/2023 3:04:46 PM C:\Local\2022\2314711 Liberty North HS_SBI-MEP_2022_CENTRAL_charlesboot\9028.rvt

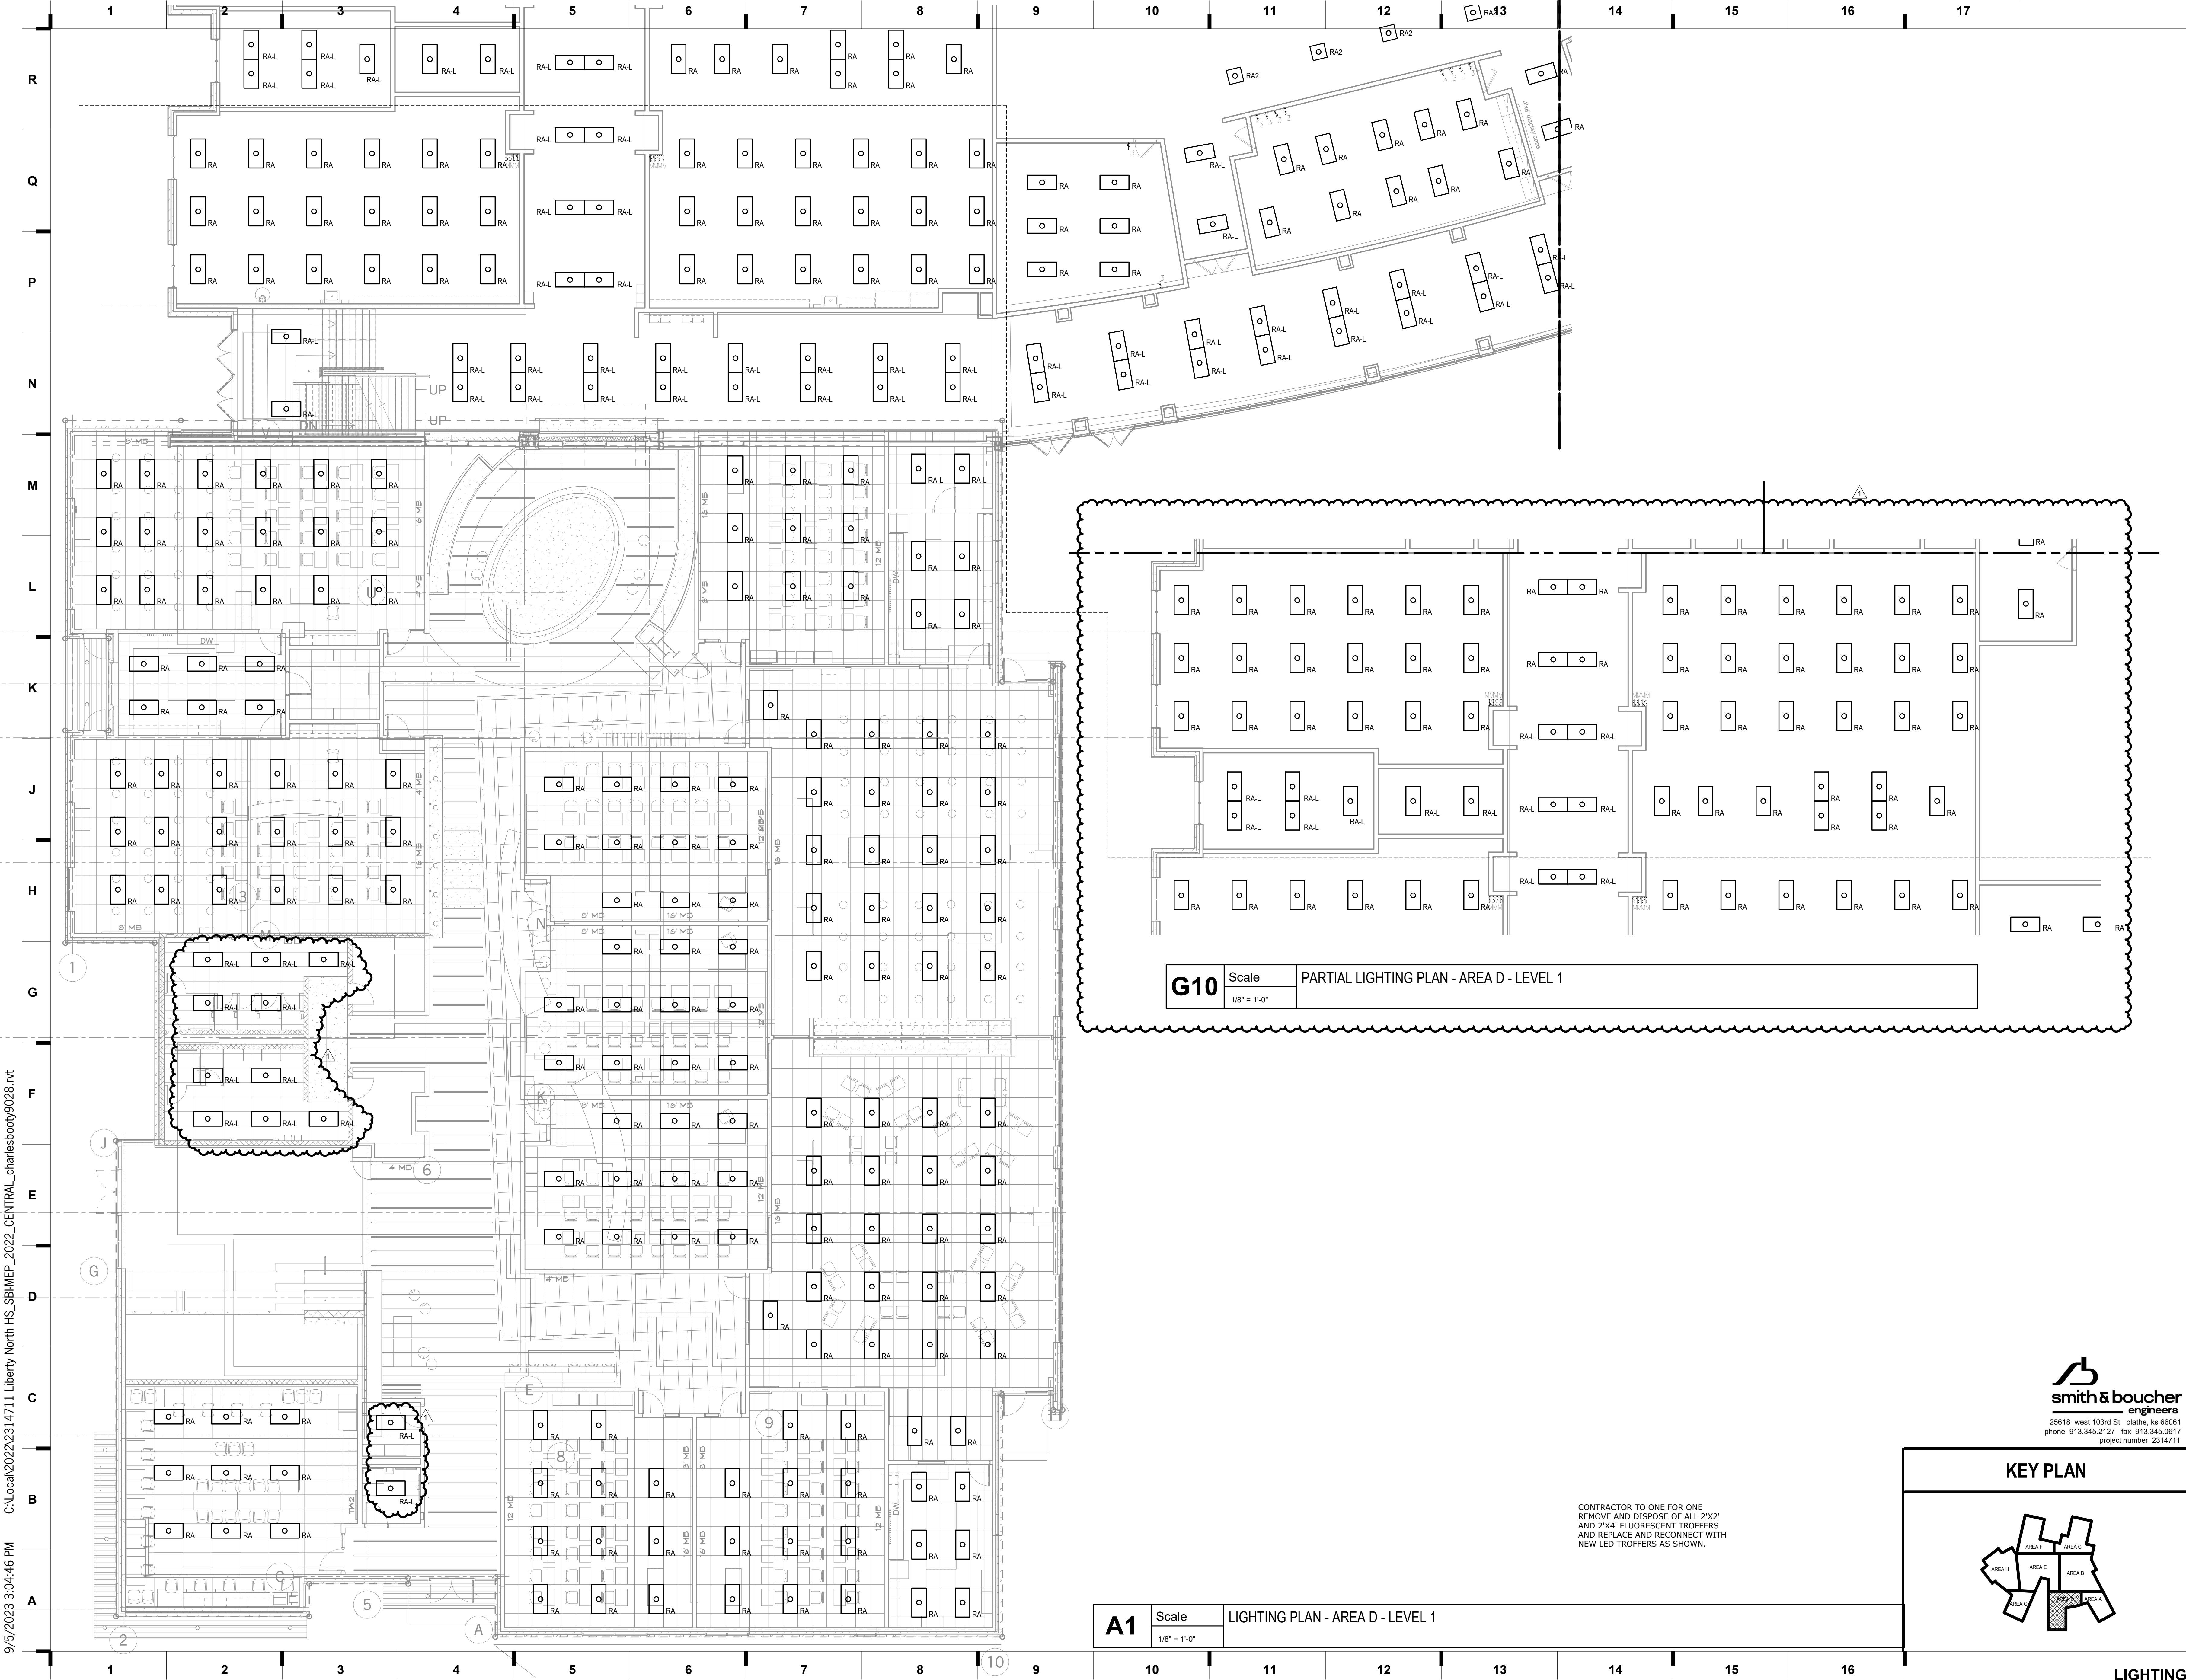

we design the future®

1828 Walnut Street Suite 922
Kansas City, MO 64108
t 816.442.7700

115 Wilcox Street Suite 210
Castle Rock, CO 80104
t 720.949.1689

HOLLISANDMILLER.COM

Hollis + Miller Architects
Maine State Certificate of Authority
Architecture # 0000151
Structure # 000015101

Smith & Boucher
Mechanic, Electric, Plumbing
State Certificate of Authority #ECC000178
25618 W 103rd Street
Olathe, KS 66061
913.345.2127 phone

**100%
CONSTRUCTION
DOCUMENTS**

LIBERTY NORTH HIGH SCHOOL LIGHTING UPGRADES
LIBERTY PUBLIC SCHOOLS
1000 NE 104th Street
Liberty, MO 64068

STATE OF MISSOURI
RYAN JEROME DIEDERIK
NUMBER 20150061
PROFESSIONAL
8/22/23


This Professional Certificate was issued to the above-named person by the Board of Professional Engineers, Architects, and Surveyors of the State of Missouri. It is valid only for the purpose for which it was issued and for the term of years shown on the certificate. It is not valid for any other purpose and its use for any other purpose is prohibited. The holder of this certificate shall be responsible for maintaining the certificate in good standing and for complying with all applicable laws and regulations governing the practice of the profession.

JOB NO: 21121.00
DRAWN BY: SBI
CHECKED BY: RJD
DATE: 08-22-2023

E101D

LIBERTY NORTH HIGH SCHOOL LIGHTING UPGRADES

9/5/2023 3:04:55 PM C:\local\2022\2314711 Liberty North HS_SBI-MEP_2022_CENTRAL_charlesboot\9028.rvt

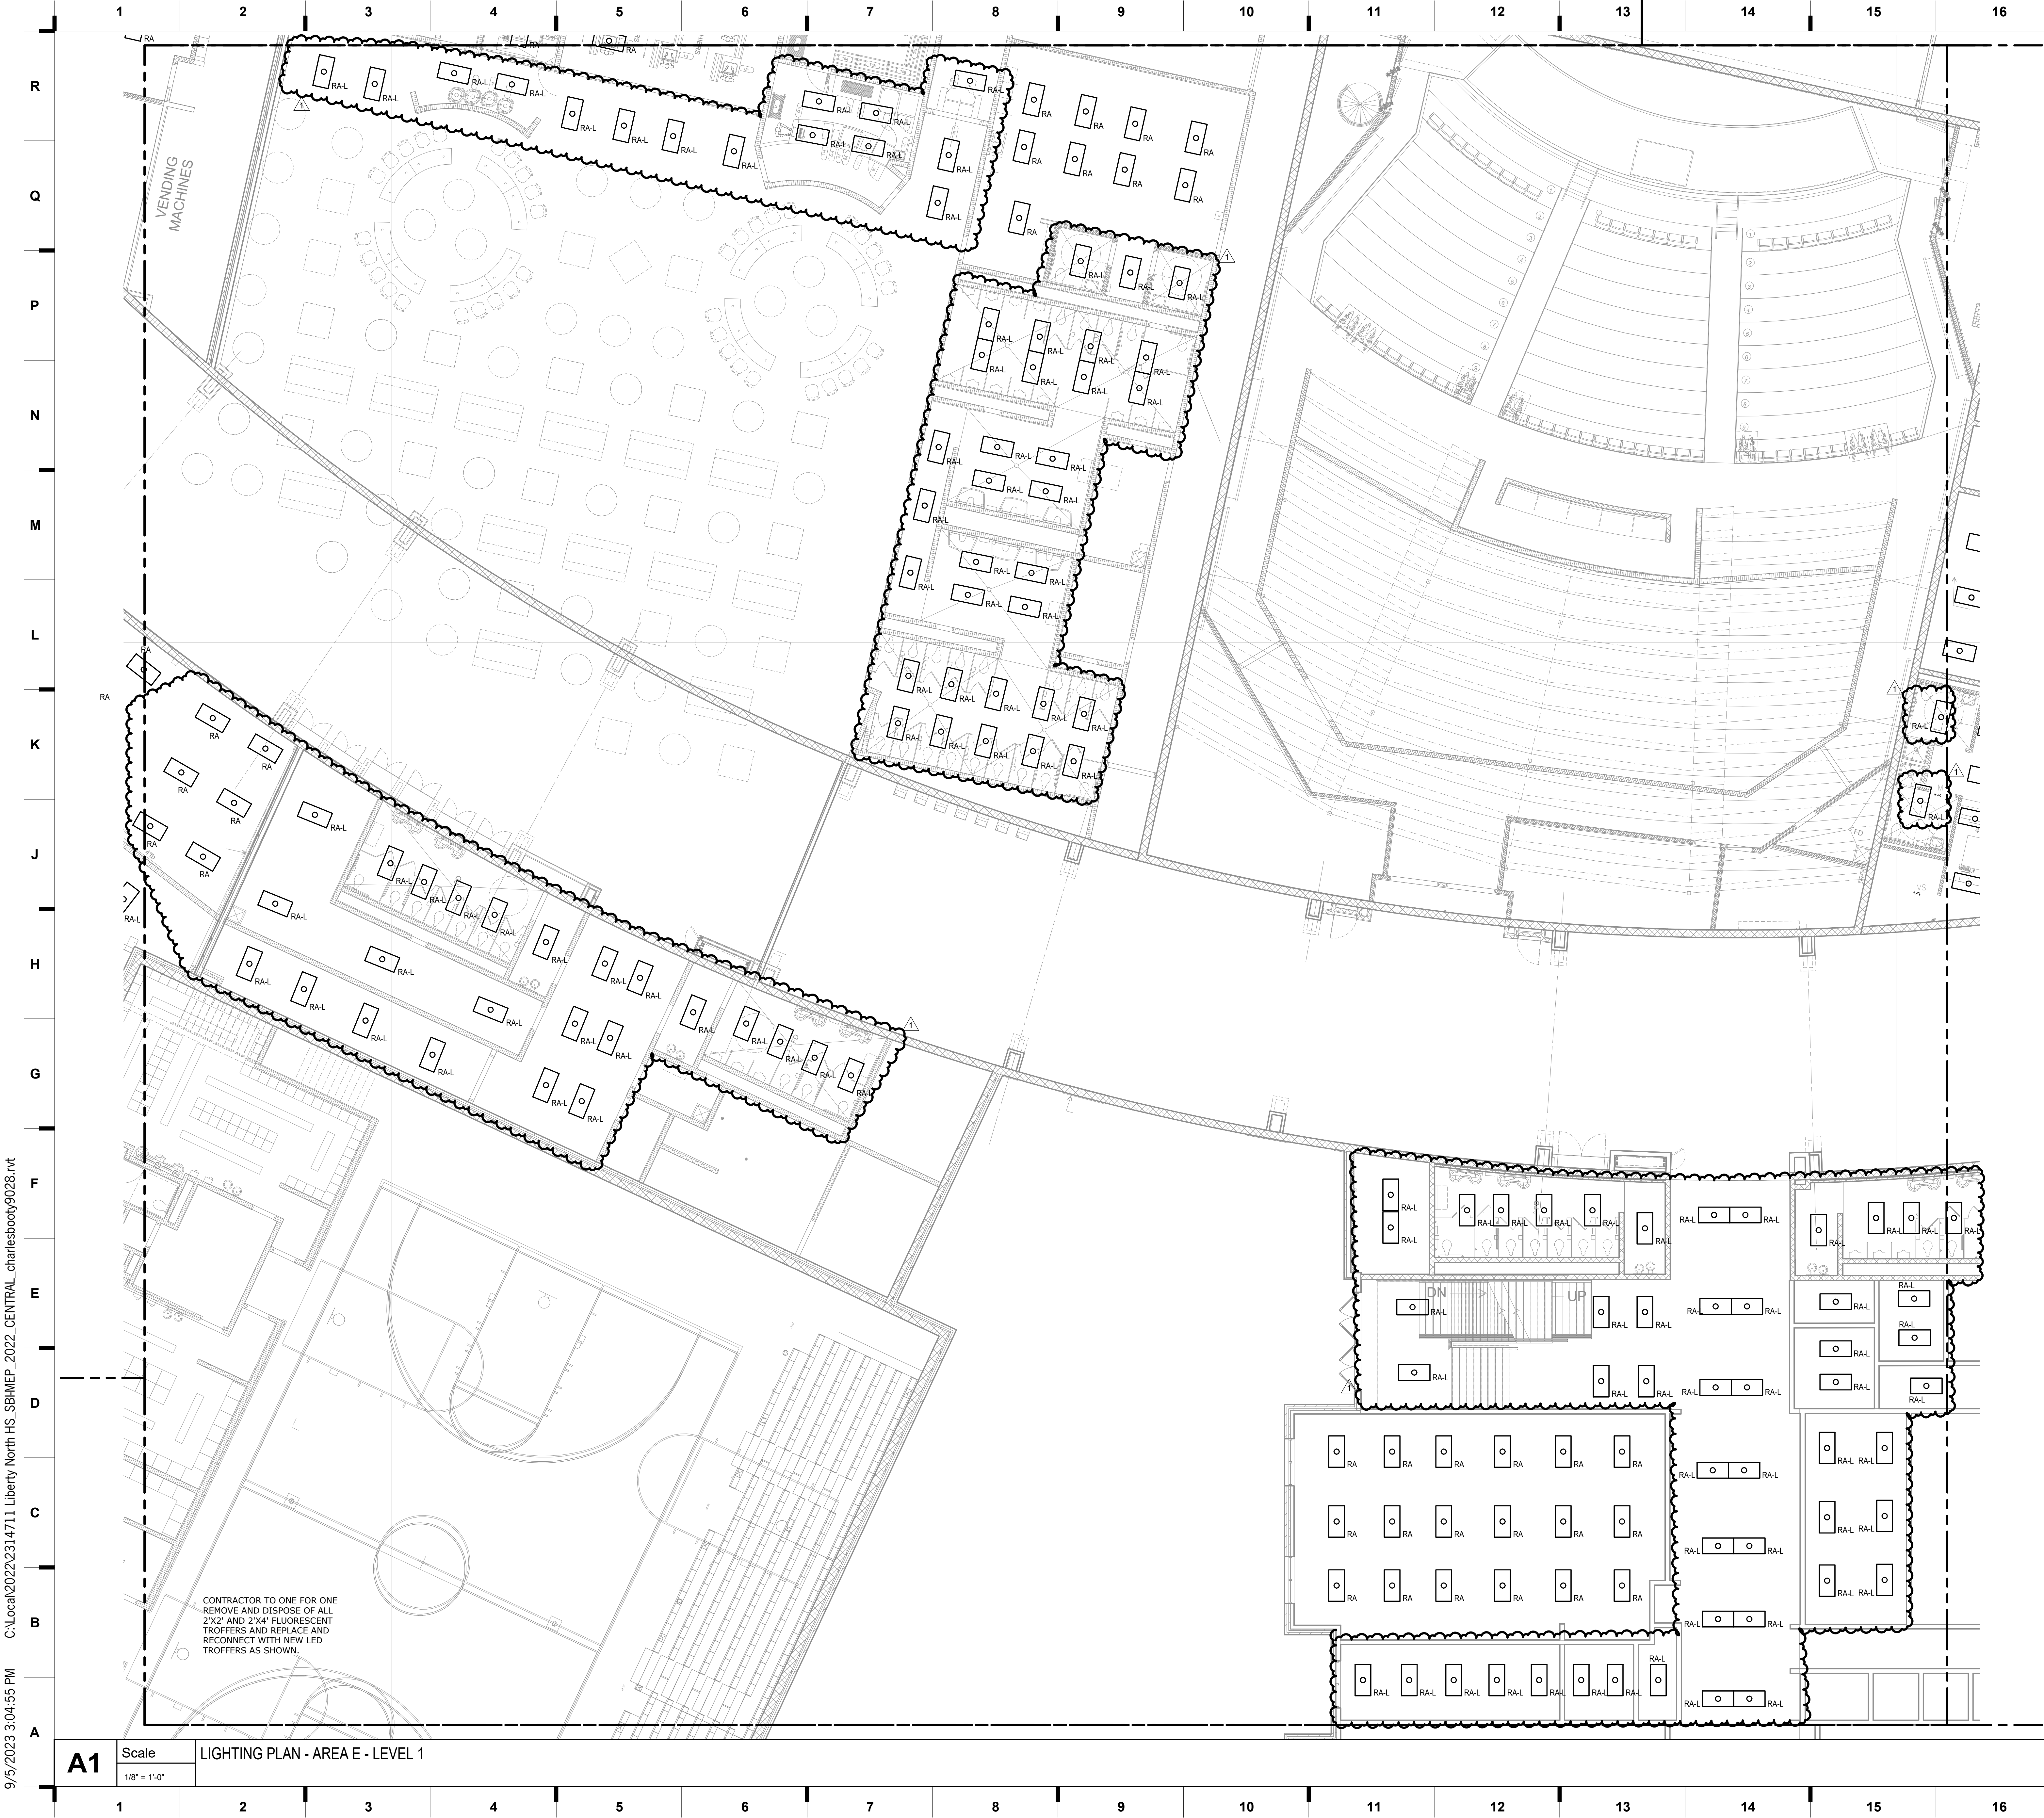

SHEET KEYNOTE LEGEND

we design the future®
1828 Walnut Street Suite 922
Kansas City, MO 64108
1 816.442.7700
115 Wilcox Street Suite 210
Castle Rock, CO 80104
1 720.949.1689
HOLLISANDMILLER.COM

Holla + Miller Architects
Maine State Certificate of Authority
Architecture # 0000151
Structural # 000015101


Smith & Boucher
Mechanic, Electric, Plumbing
State Certificate of Authority #EGC000178
25618 W 103rd Street
Olathe, KS 66061
913.345.2127 phone

Liberty North High School Lighting Upgrades

Liberty Public Schools
1000 NE 104th Street
Liberty, MO 64068

REVISIONS:		
#	Description	Date
1	Amendment #1	09/05/2023


smith & boucher
engineers
25618 west 103rd St. olathe, ks 66061
phone 913.345.2127 fax 913.345.0617
project number 2314711

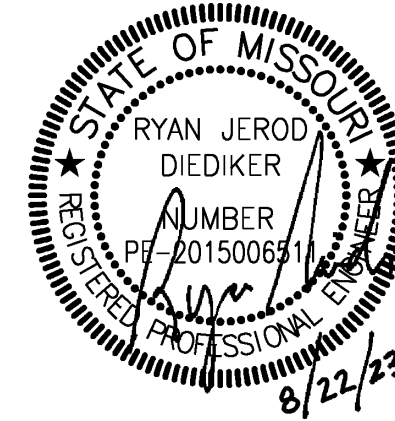

JOB NO: 21121.00
DRAWN BY: SBI
CHECKED BY: RJD
DATE: 08-22-2023

E101E

KEY PLAN

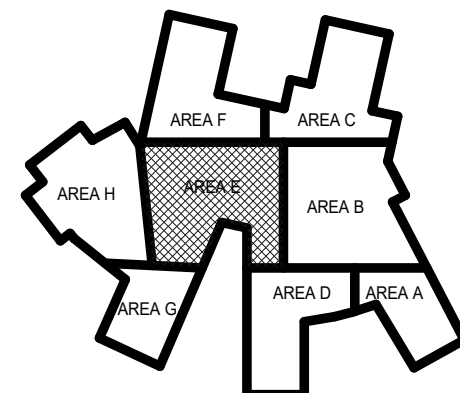

LIGHTING PLAN - AREA E - LEVEL 1


Please consider the environment before printing this.

9/5/2023 3:05:03 PM C:\Local\2022\2314711 Liberty North HS_SBI MEP_2022_CENTRAL_charlesboot\9028.rvt




A1 Scale LIGHTING PLAN - AREA F - LEVEL 1
1/8" = 1'-0"

SHEET KEYNOTE LEGEND

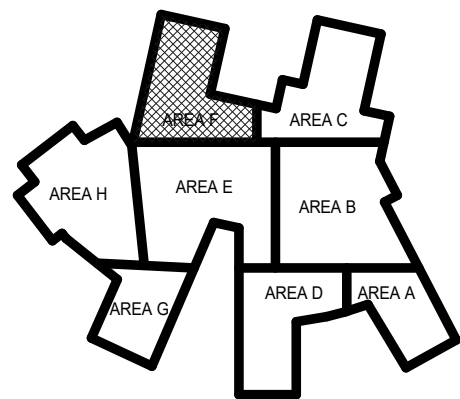

KEY PLAN

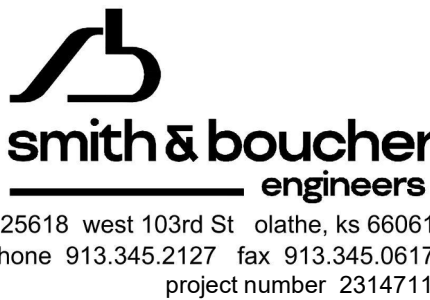

JOB NO: 21121.00
DRAWN BY: SBI
CHECKED BY: RJD
DATE: 08-22-2023

E101F

REVISIONS:		
#	Description	Date
1	Amendment #1	09/05/2023

Liberty North High School Lighting Upgrades
Liberty Public Schools
1000 NE 104th Street
Liberty, MO 64068


we design the future®
1828 Walnut Street Suite 922
Kansas City, MO 64108
t 816.442.7700

115 Wilcox Street Suite 210
Castle Rock, CO 80104
t 720.949.1689

HOLLISANDMILLER.COM

Holla + Miller Architects
Maine State Certificate of Authority
Architecture # 0001311
Structural # 000031303

Smith & Boucher
Mechanic, Electric, Plumbing
State Certificate of Authority # EGC000178
25618 W 103rd Street
Olathe, KS 66061
913.345.2127 phone

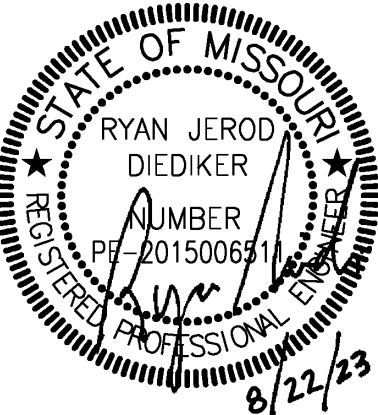


This Professional Seal/Seals are placed on this sheet as evidence of the engineer and their approval of the work. All drawings, calculations and other documents are subject to the seal and the professional judgment of the engineer. The seal and the professional judgment are not a guarantee of the quality of the work. The seal and the professional judgment are not a guarantee of the quality of the work.

100%
CONSTRUCTION
DOCUMENTS


hollis + miller architects®

9/5/2023 3:05:07 PM C:\Local\2022\2314711 Liberty North HS_SBI-MEP_2022_CENTRAL_charlesboot\9028.rvt

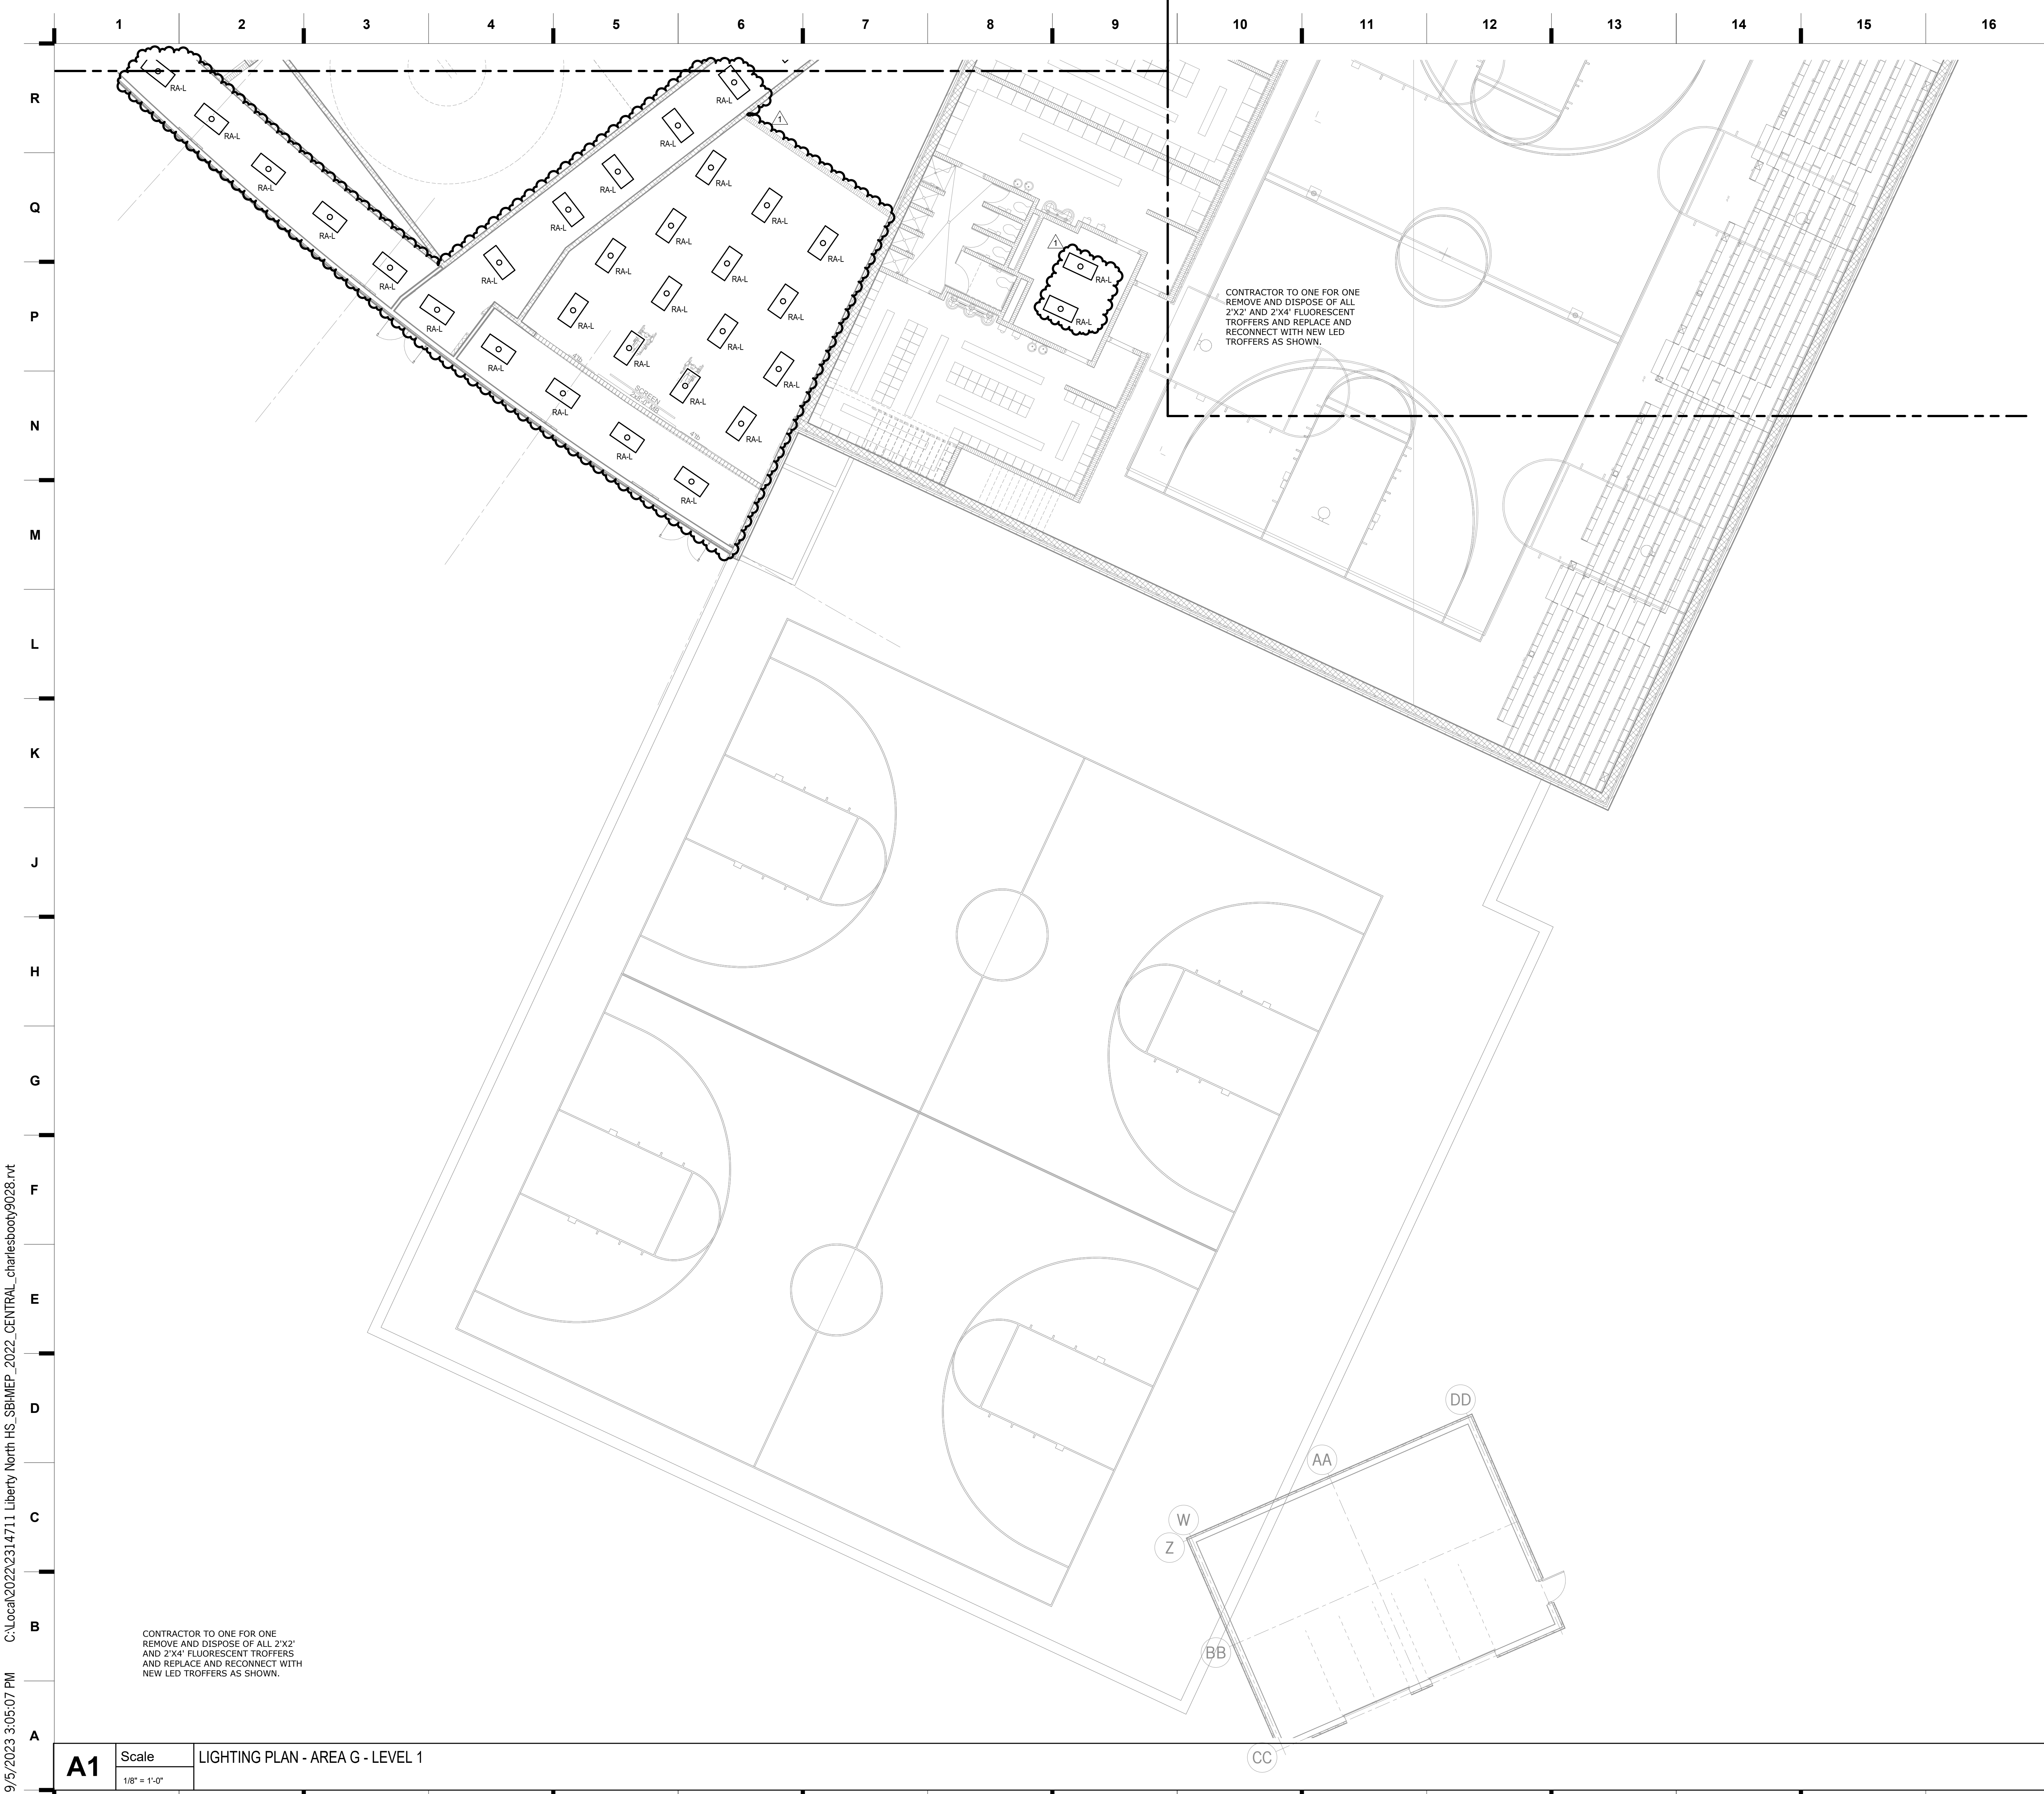


A1	Scale	LIGHTING PLAN - AREA G - LEVEL 1
	1/8" = 1'-0"	

SHEET KEYNOTE LEGEND

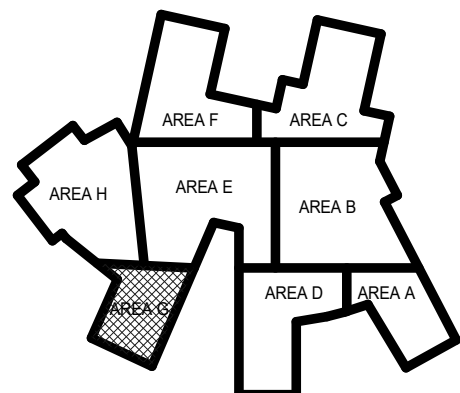

KEY PLAN

REVISIONS:		
#	Description	Date
1	Addendum #1	09/05/2023

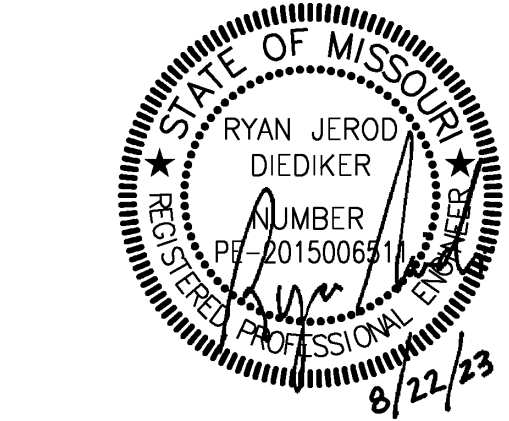

JOB NO: 21121.00
DRAWN BY: SBI
CHECKED BY: RJD
DATE: 08-22-2023

E101G

LIGHTING PLAN - AREA G - LEVEL 1

Liberty North High School Lighting Upgrades

Liberty Public Schools
1000 NE 104th Street
Liberty, MO 64068

100%
CONSTRUCTION
DOCUMENTS

we design the future™
1828 Walnut Street Suite 922
Kansas City, MO 64108
t 816.442.7700

115 Wilcox Street Suite 210
Castle Rock, CO 80104
t 720.949.1689

HOLLISANDMILLER.COM

Holls + Miller Architects
Missouri State Certificate of Authority
Architecture # 0001151
Structural # 00001103

Smith & Boucher
Mechanic, Electric, Plumbing
State Certificate of Authority #EGC000178
25618 W 103rd Street
Olathe, KS 66061
913.345.2127 phone


hollis + miller architects®




CONTRACTOR TO ONE FOR ONE
REMOVE AND DISPOSE OF ALL 2'X2'
AND 2'X4' FLUORESCENT TROFFERS
AND REPLACE AND RECONNECT WITH
NEW LED TROFFERS AS SHOWN.

A1 Scale LIGHTING PLAN - AREA H - LEVEL 1
1/8" = 1'-0"

SHEET KEYNOTE LEGEND

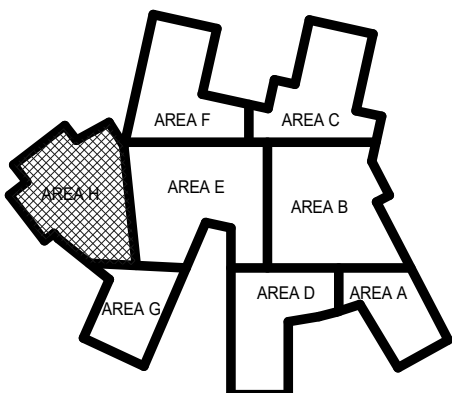

smith & boucher
engineers
25618 west 103rd St. olathe, ks 66061
phone 913.345.2127 fax 913.345.0617
project number 2314711

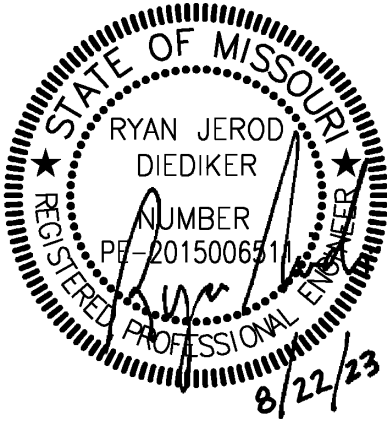

REVISIONS:		
#	Description	Date
1	Amendment #1	09/05/2023

Liberty North High School
Liberty Public Schools
1000 NE 104th Street
Liberty, MO 64068

100%
CONSTRUCTION
DOCUMENTS

Liberty North High School Lighting Upgrades

we design the future®
1828 Walnut Street Suite 922
Kansas City, MO 64108
T 816.442.7700
115 Wilcox Street Suite 210
Castle Rock, CO 80104
T 720.949.1689
HOLLISANDMILLER.COM

Holla + Miller Architects
Maine State Certificate of Authority
Architecture # 0001311
Structural # 000031303

Smith & Boucher
Mechanic, Electric, Plumbing
State Certificate of Authority #EGC000178
25618 W 103rd Street
Olathe, KS 66061
913.345.2127 phone

hollis + miller architects®

E101H

JOB NO: 21121.00
DRAWN BY: SBI
CHECKED BY: RJD
DATE: 08-22-2023

LIGHTING PLAN - AREA H - LEVEL 1



CONTRACTOR TO ONE FOR ONE
REMOVE AND DISPOSE OF ALL 2'X2'
AND 2'X4' FLUORESCENT TROFFERS
AND REPLACE AND RECONNECT
WITH NEW LED TROFFERS AS
SHOWN.

Scale

LIGHTING PLAN - AREA A - LEVEL 2

$$1/8^* = 1'-0$$

we design the future®

1828 Walnut Street Suite 922
Kansas City, MO 64108
T 816.442.7700

115 Wilcox Street Suite 210
Castle Rock, CO 80104
T 720.949.1689

HOLLISANDMILLER.COM

Holla + Miller Architects
Missouri State Certificate of Authority
Architecture # 0000161
Structure # 2006031333

Smith & Boucher
Mechanic, Electric, Plumbing
State Certificate of Authority #EGC000178
25618 W 103rd Street
Olathe, KS 66061
913.345.2127 phone

Liberty North High School Lighting Upgrades



Liberty Public Schools

1000 NE 104th Street

**100%
CONSTRUCTION
DOCUMENTS**

REVISIONS:


#	Description	Date
1	Addendum #1	09/05/2023

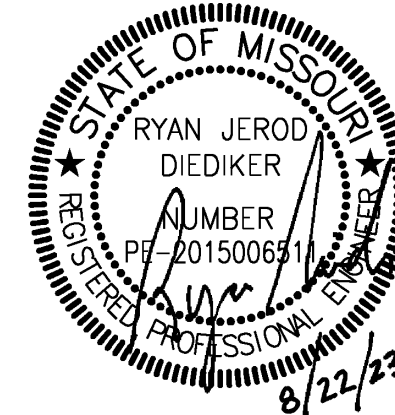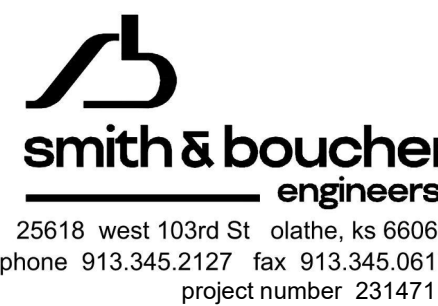

The Professional Architects seal affixed to this sheet applies only to the material and items shown on this sheet. All drawings, instruments or other documents not exhibiting this seal shall not be considered prepared by this architect, and this architect expressly disclaims any and all responsibility for such plan, drawings, or documents not exhibiting


JOB NO: 21121.00
DRAWN BY: SB
CHECKED BY: RJ
DATE: 08-22-2023

E102A

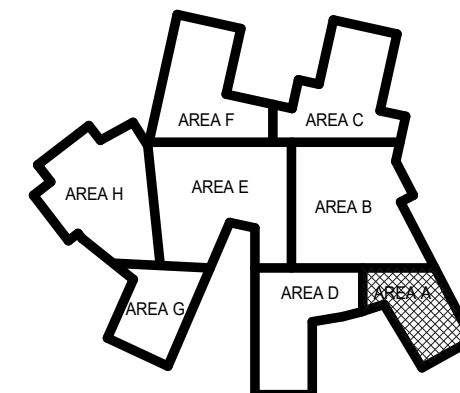


LIGHTING PLAN - AREA A - LEVEL 2

 Please consider the environment before printing this document.

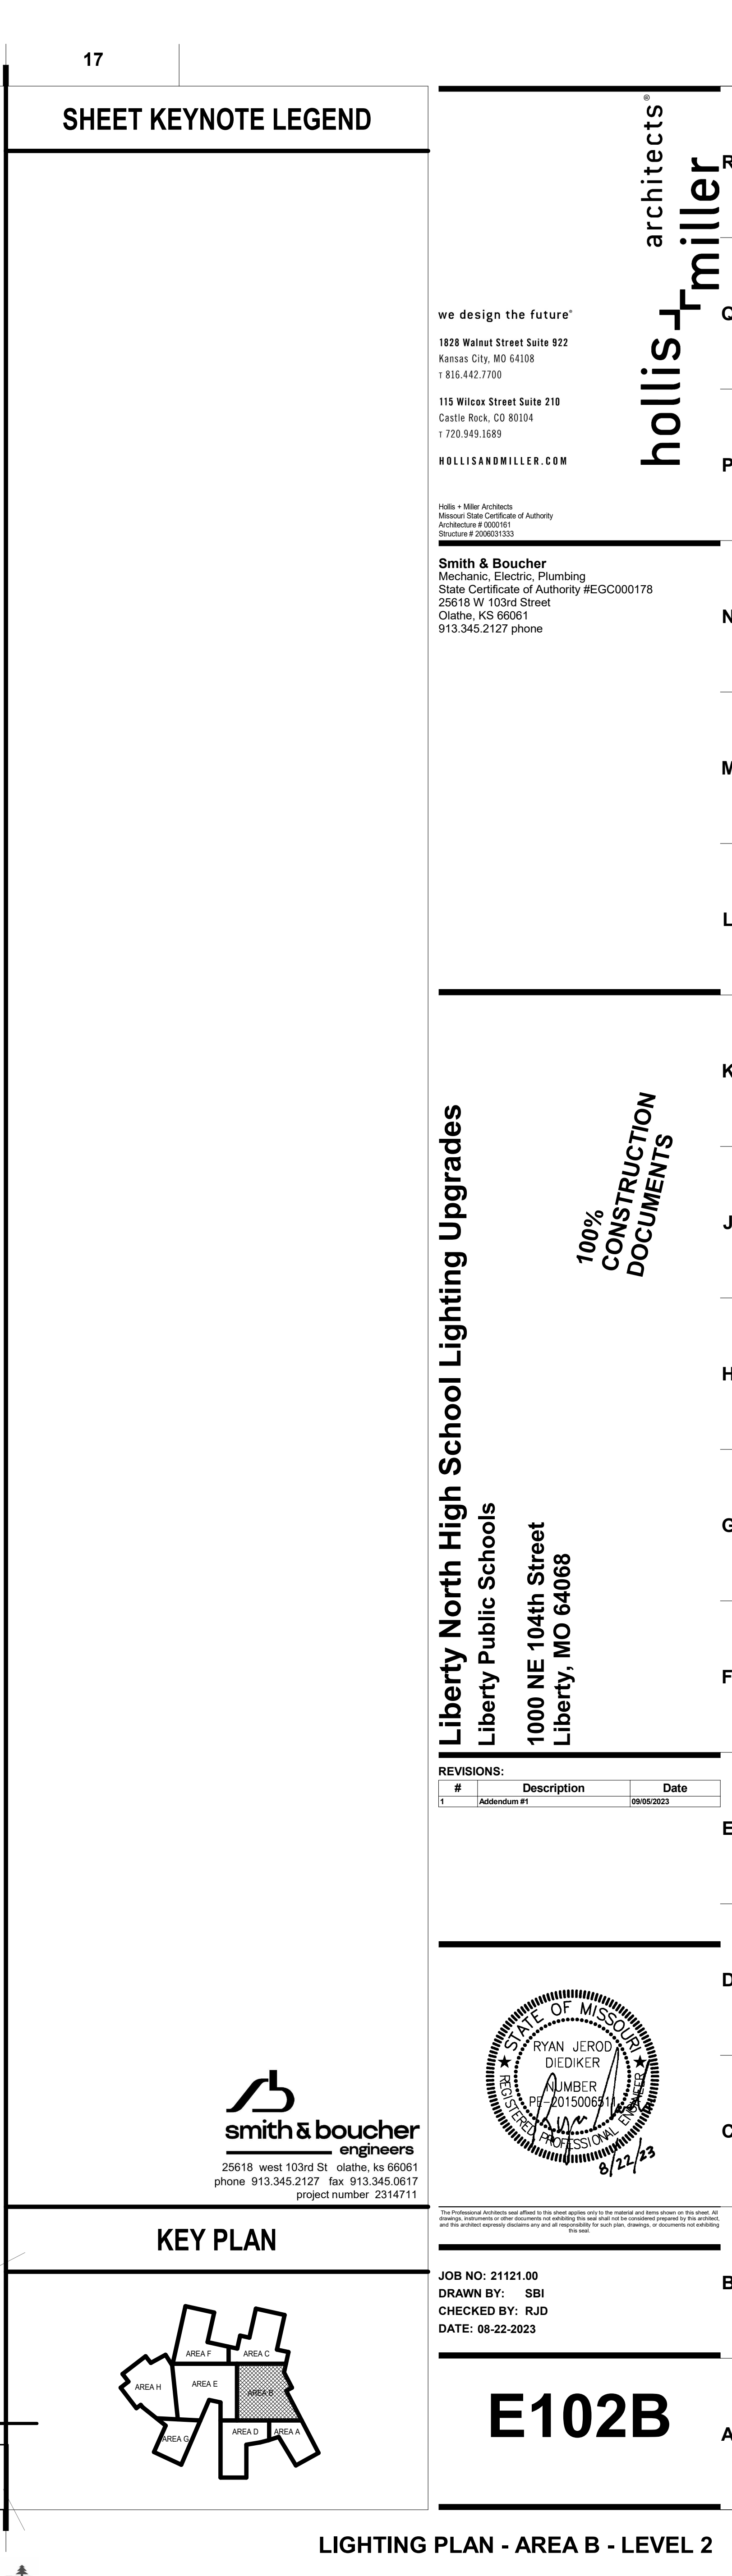

9/5/2023 3:05:41 PM C:\Local\2022\2314711 Liberty North HS_SBI-MEP_2022_CENTRAL_charlesboot\9028.rvt

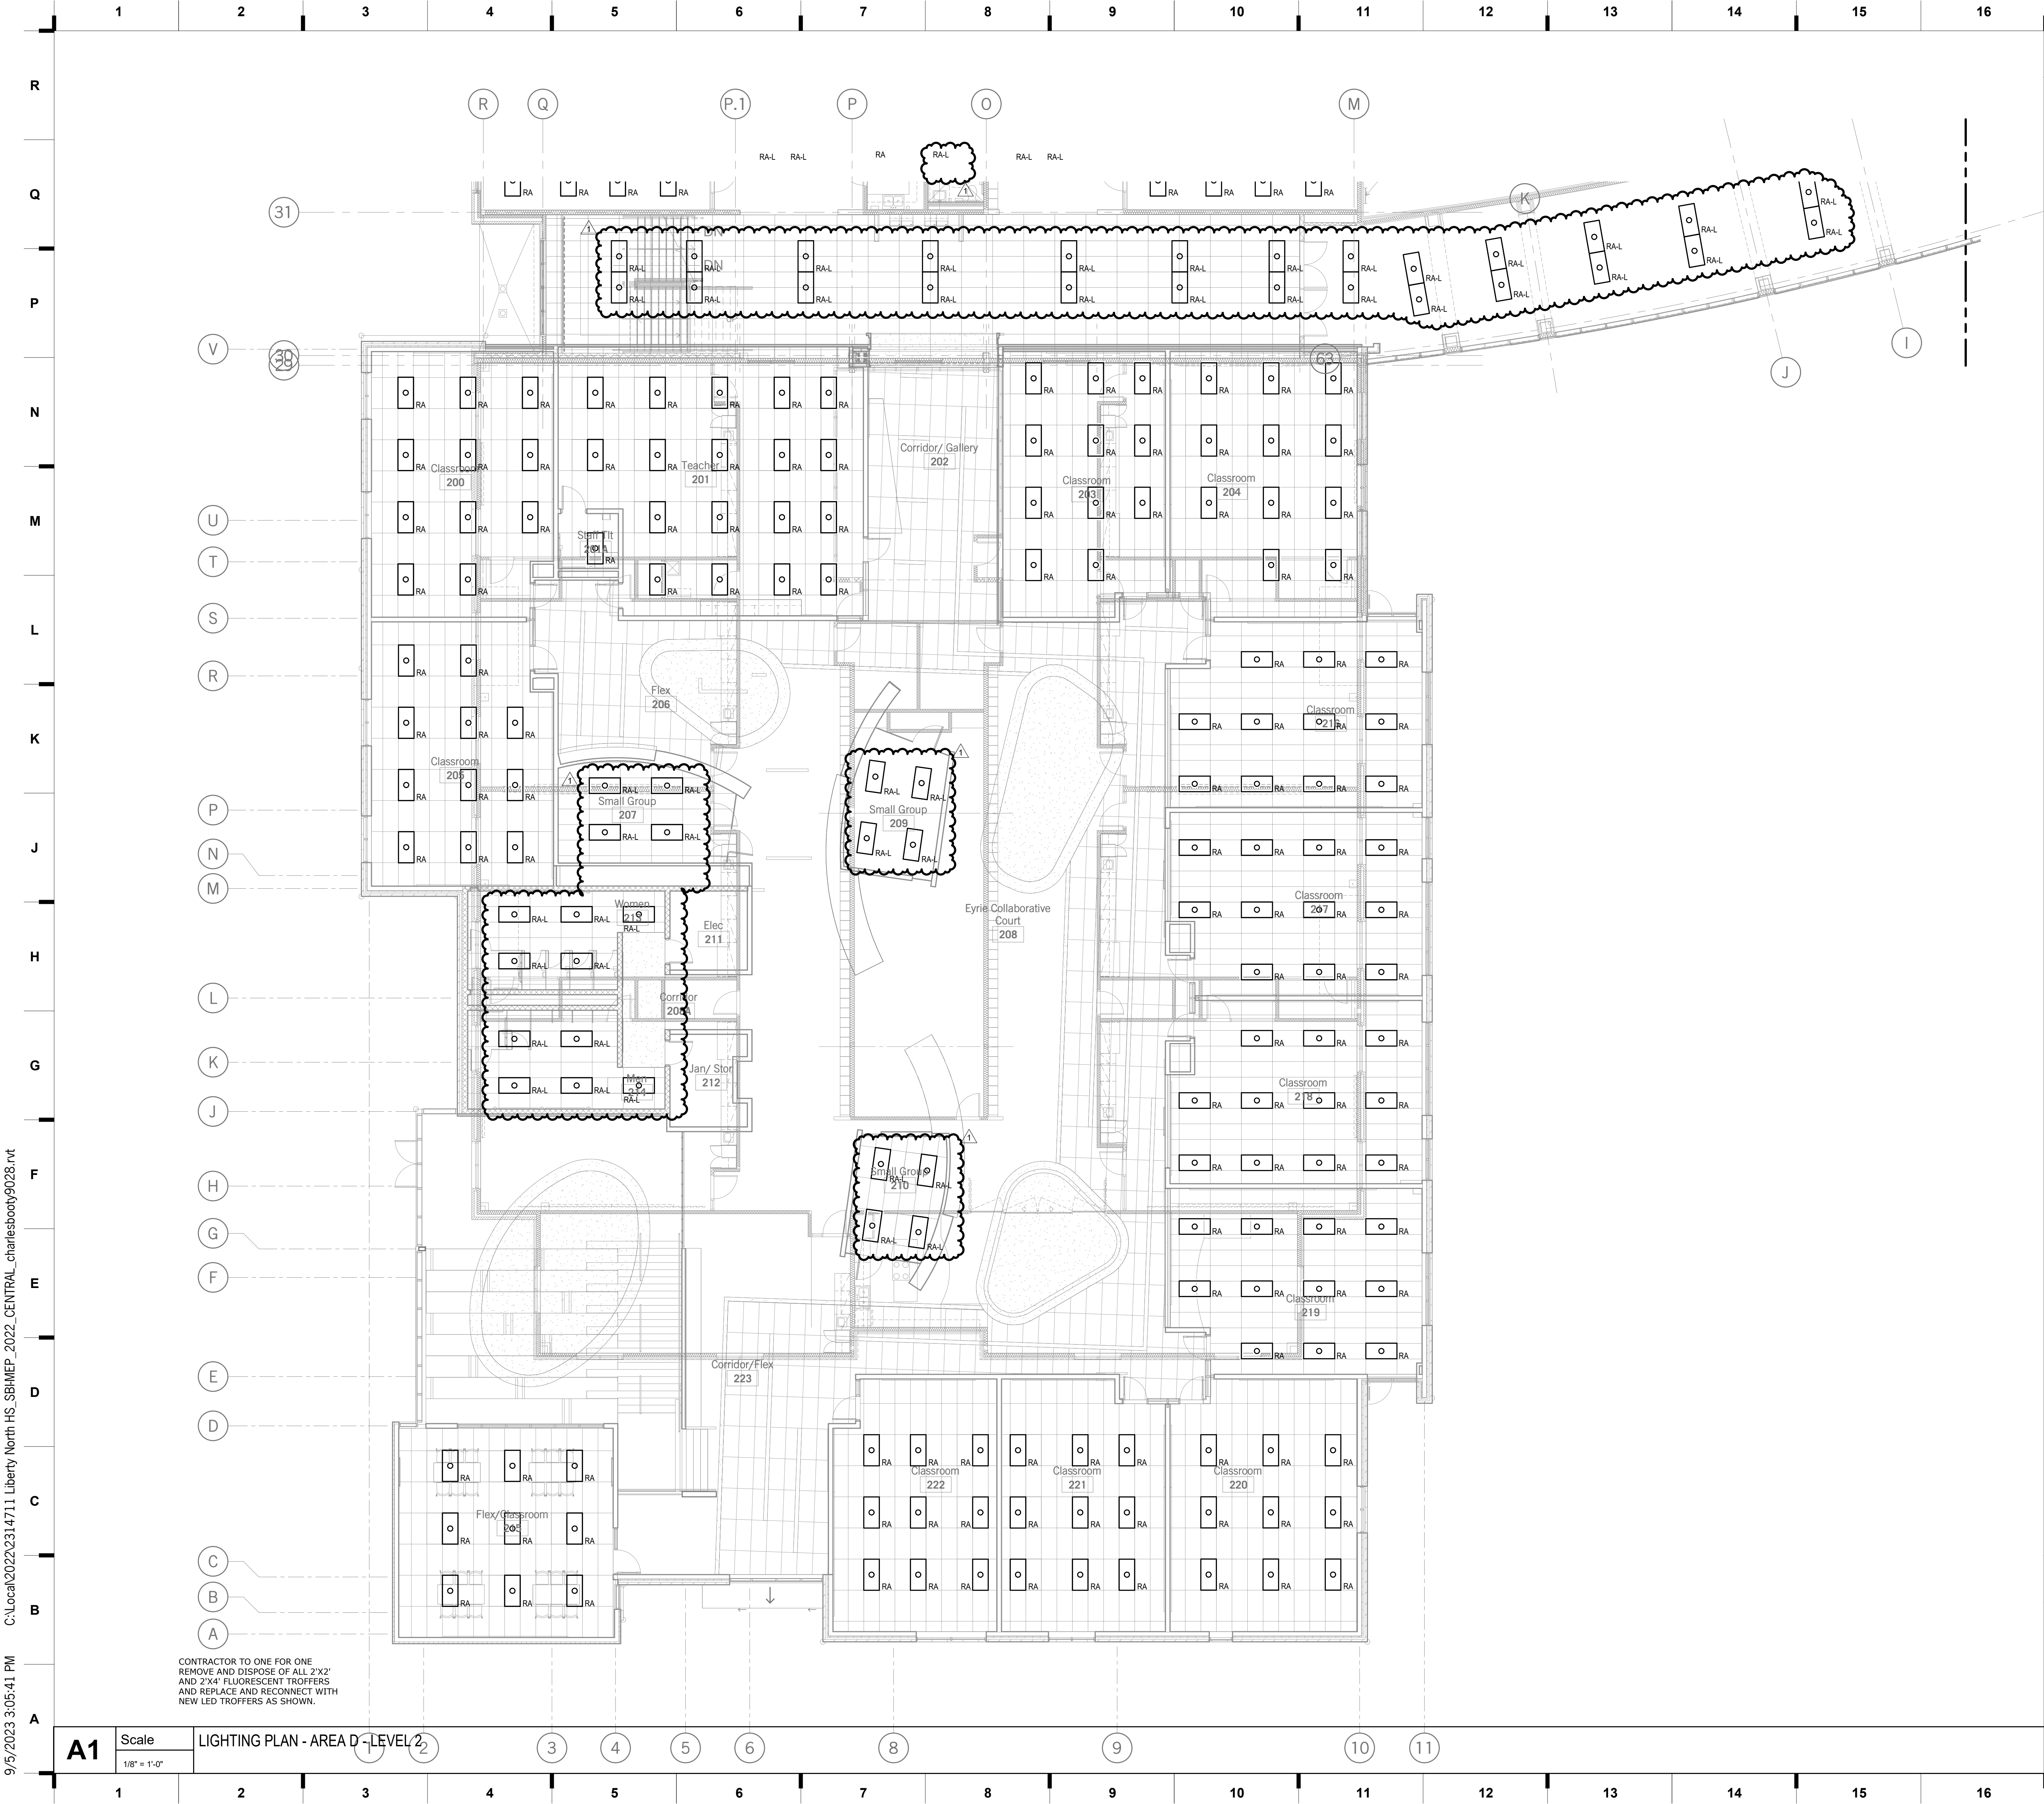

SHEET KEYNOTE LEGEND

we design the future®
1828 Walnut Street Suite 922
Kansas City, MO 64108
1 816.442.7700
115 Wilcox Street Suite 210
Castle Rock, CO 80104
1 720.949.1689
HOLLISANDMILLER.COM

Holla + Miller Architects
Maine State Certificate of Authority
Architecture # 0001311
Structure # 00001101


Smith & Boucher
Mechanic, Electric, Plumbing
State Certificate of Authority #ECC000178
25618 W 103rd Street
Olathe, KS 66061
913.345.2127 phone

Liberty North High School Lighting Upgrades

Liberty Public Schools
1000 NE 104th Street
Liberty, MO 64068

REVISIONS:		
#	Description	Date
1	Amendment #1	09/05/2023

smith & boucher
engineers
25618 west 103rd St. olathe, ks 66061
phone 913.345.2127 fax 913.345.0617
project number 2314711

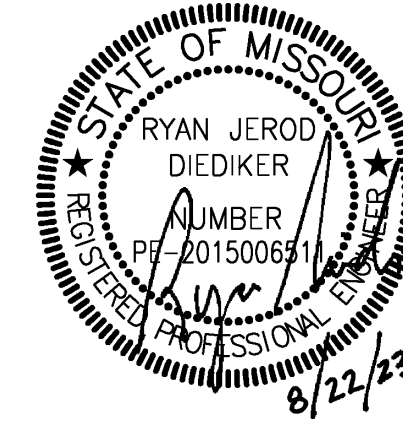


This Professional Seal and the seal of the State of Missouri are the property of the State of Missouri and are not to be used for any other purpose without the express written consent of the State of Missouri.

JOB NO: 21121.00
DRAWN BY: SBI
CHECKED BY: RJD
DATE: 08-22-2023

E102D


KEY PLAN

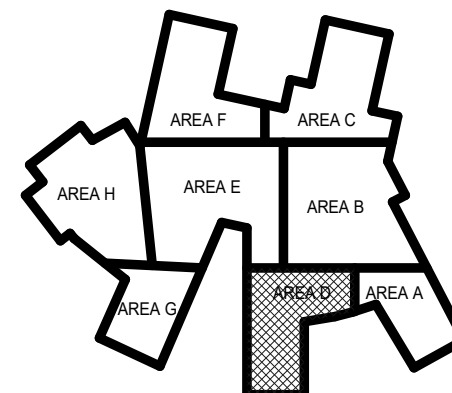

LIGHTING PLAN - AREA D - LEVEL 2


Please consider the environment before printing this.

C:\Local\2022\2314711 Liberty North HS_SBI-MEP_2022_CENTRAL_charlesboot\9028.rvt 9/5/2023 3:05:48 PM

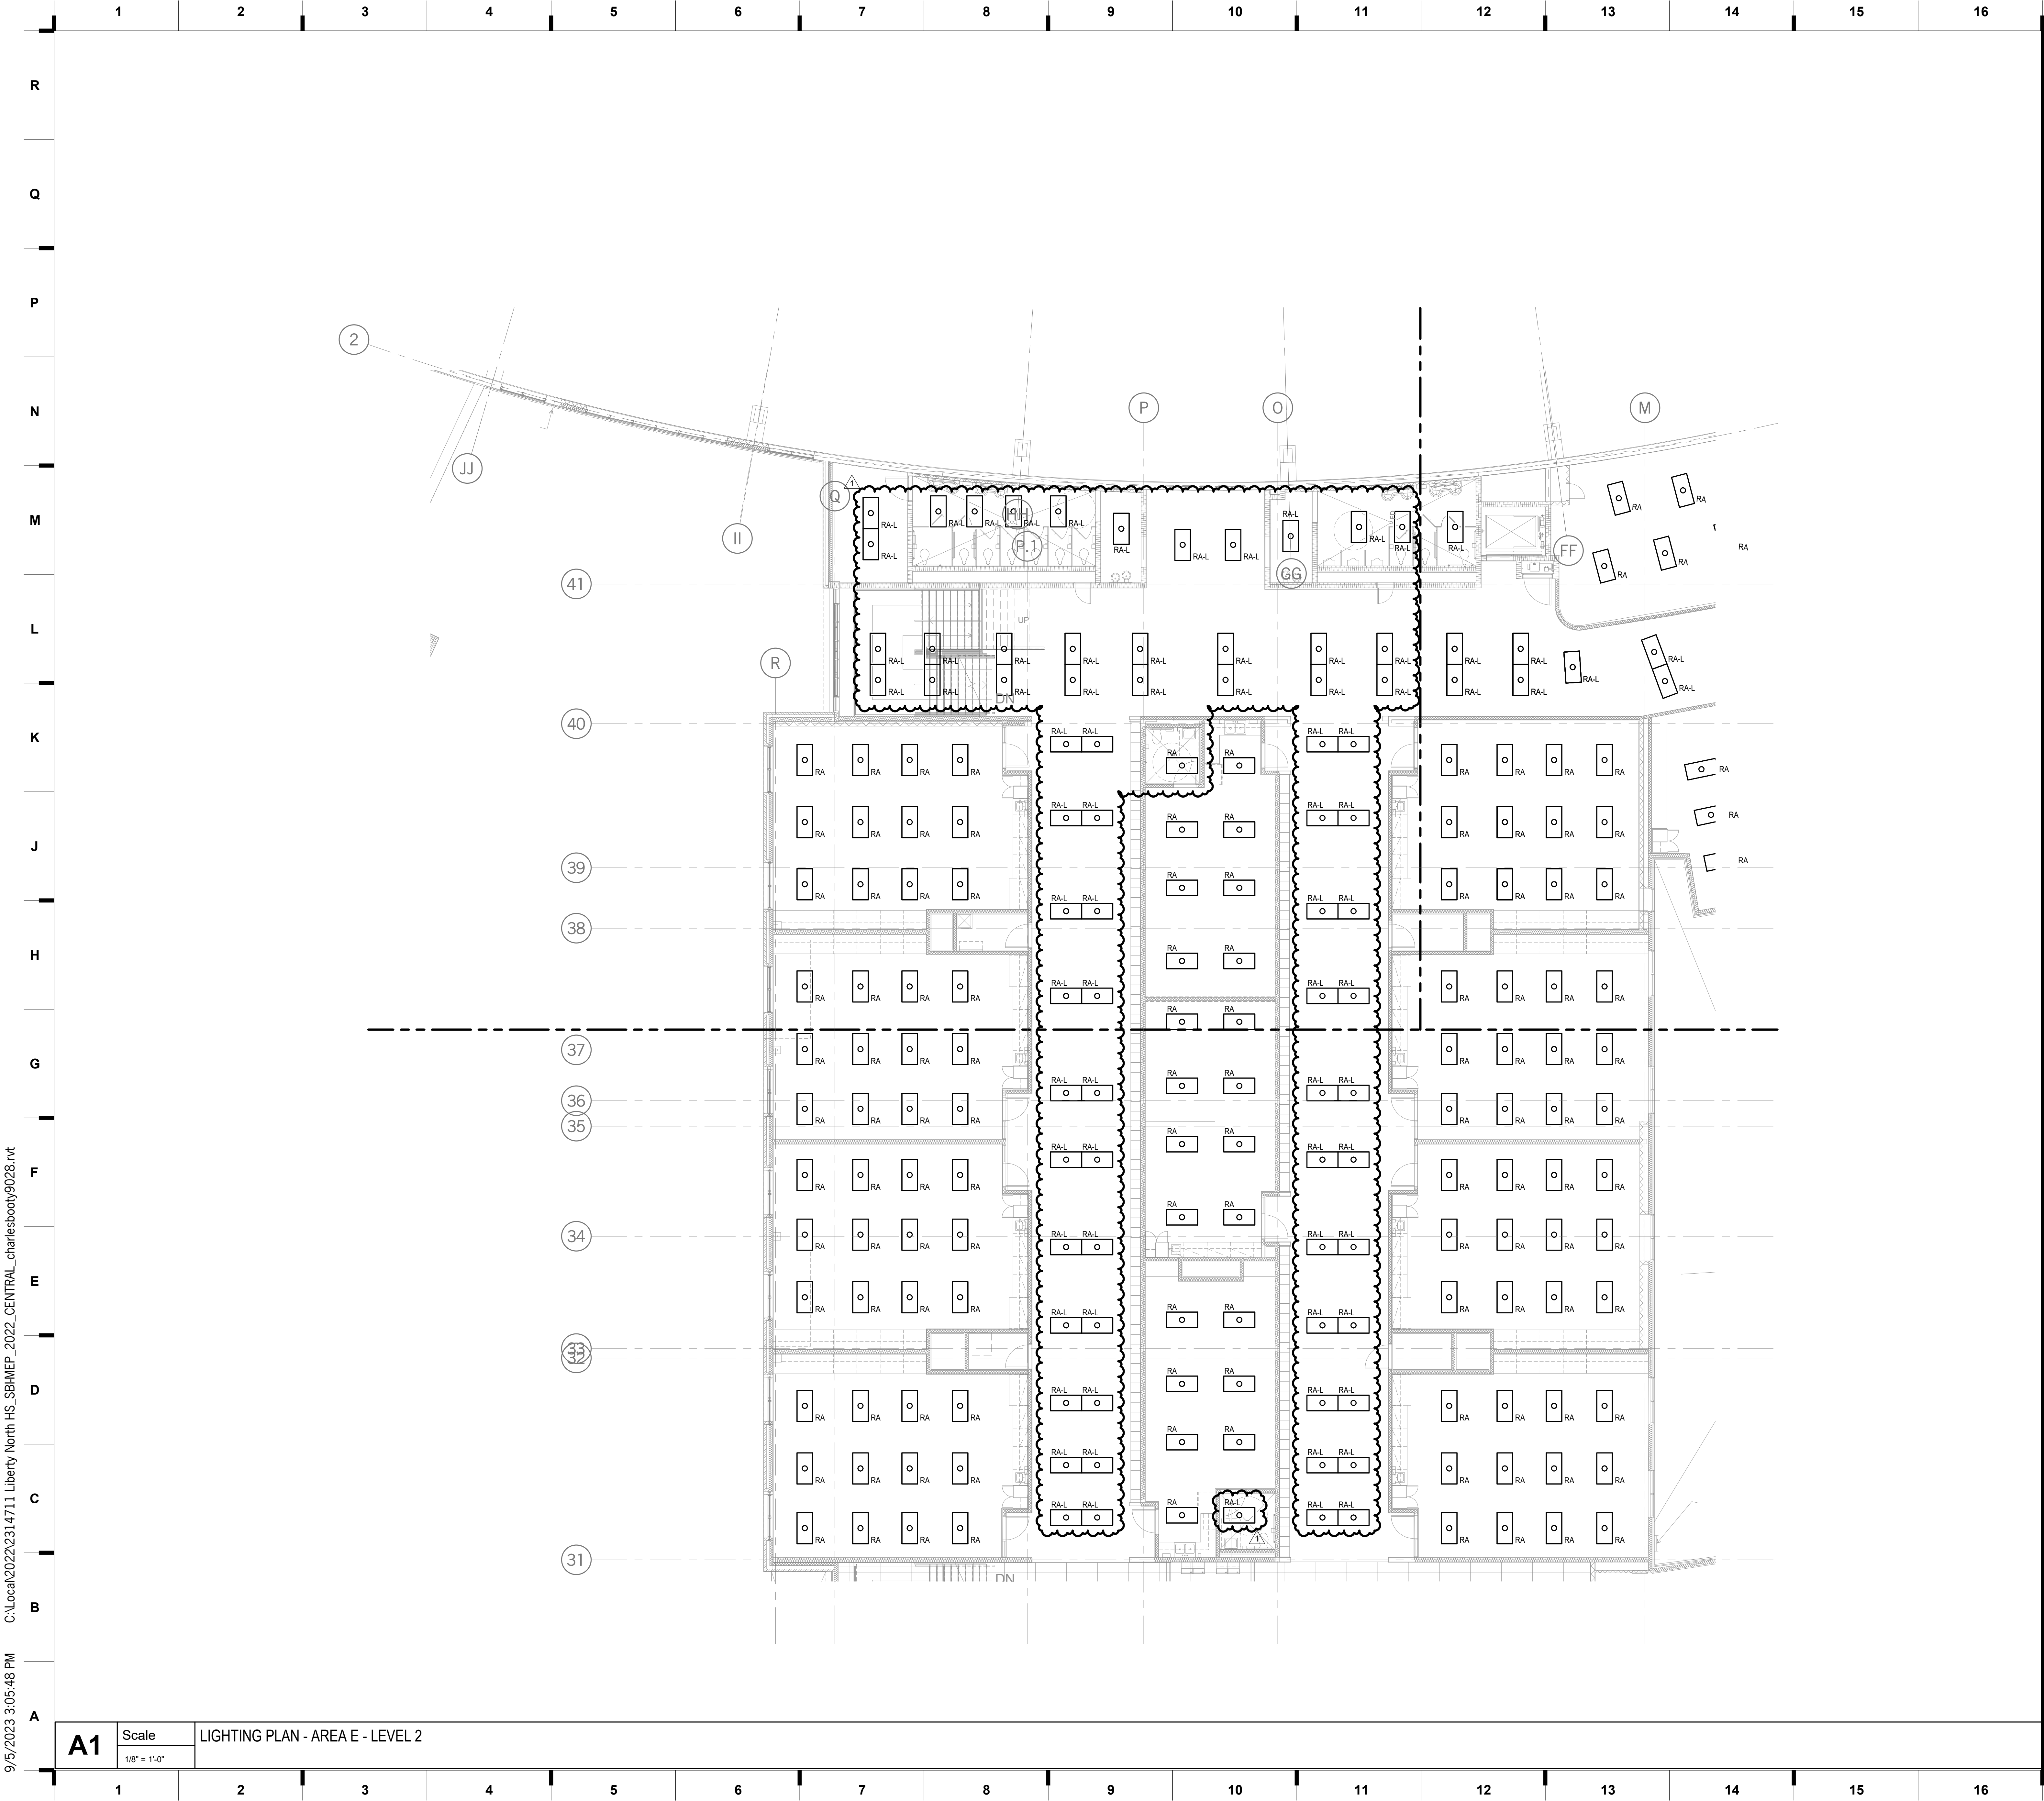

A1 Scale LIGHTING PLAN - AREA E - LEVEL 2
1/8" = 1'-0"


SHEET KEYNOTE LEGEND

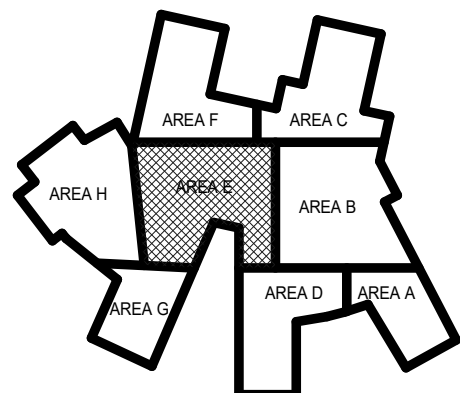

KEY PLAN

smith & boucher
engineers
25618 west 103rd St. olathe, ks 66061
phone 913.345.2127 fax 913.345.0617
project number 2314711

REVISIONS:		
#	Description	Date
1	Amendment #1	09/05/2023

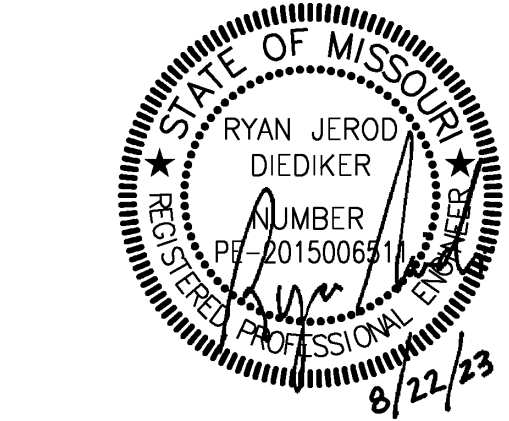

JOB NO: 21121.00
DRAWN BY: SBI
CHECKED BY: RJD
DATE: 08-22-2023

E102E

Liberty North High School Lighting Upgrades

Liberty Public Schools
1000 NE 104th Street
Liberty, MO 64068

100%
CONSTRUCTION
DOCUMENTS

we design the future®
1828 Walnut Street Suite 922
Kansas City, MO 64108
t 816.442.7700
115 Wilcox Street Suite 210
Castle Rock, CO 80104
t 720.949.1689
HOLLISANDMILLER.COM

Holla + Miller Architects
Maine State Certificate of Authority
Architecture # 0001311
Structural # 000031303

Smith & Boucher
Mechanic, Electric, Plumbing
State Certificate of Authority #EGC000178
25618 W 103rd Street
Olathe, KS 66061
913.345.2127 phone

hollis + miller
architects®

