


LEGEND	
	TRANSLUCENT SKYLIGHT UNIT

SKYLIGHTS		
SKYLIGHT #	PHOTOS	HAIL DAMAGE
#1	2 - 9	OLD / NEW
#2	10 - 14	OLD / NEW
#3	15 - 22	OLD / NEW
#4	23 - 30	OLD / NEW
#5	31 - 34	OLD / NEW
#6	35 - 39	OLD / NEW
#7	40 - 44	OLD / NEW
#8	45 - 49	OLD / NEW
#9	50 - 53	OLD / NEW
#10	54 - 56	OLD / NEW
#11	57 - 59	OLD / NEW
#12	60 - 63	NEW
#13	64 - 68	NEW

WALL PANELS		
PANEL #	PHOTOS	HAIL DAMAGE
#14	69 - 71	NO DAMAGE
#15	72	NO DAMAGE
#16	73	NO DAMAGE
#17	74 - 75	NEW
#18	76	NO DAMAGE
#19	77 - 78	NO DAMAGE
#20	79	NO DAMAGE
#21	80	NO DAMAGE
#22	81	NO DAMAGE
#23	82	NO DAMAGE
#24	83	NO DAMAGE
FRONT	84 - 85	NO DAMAGE

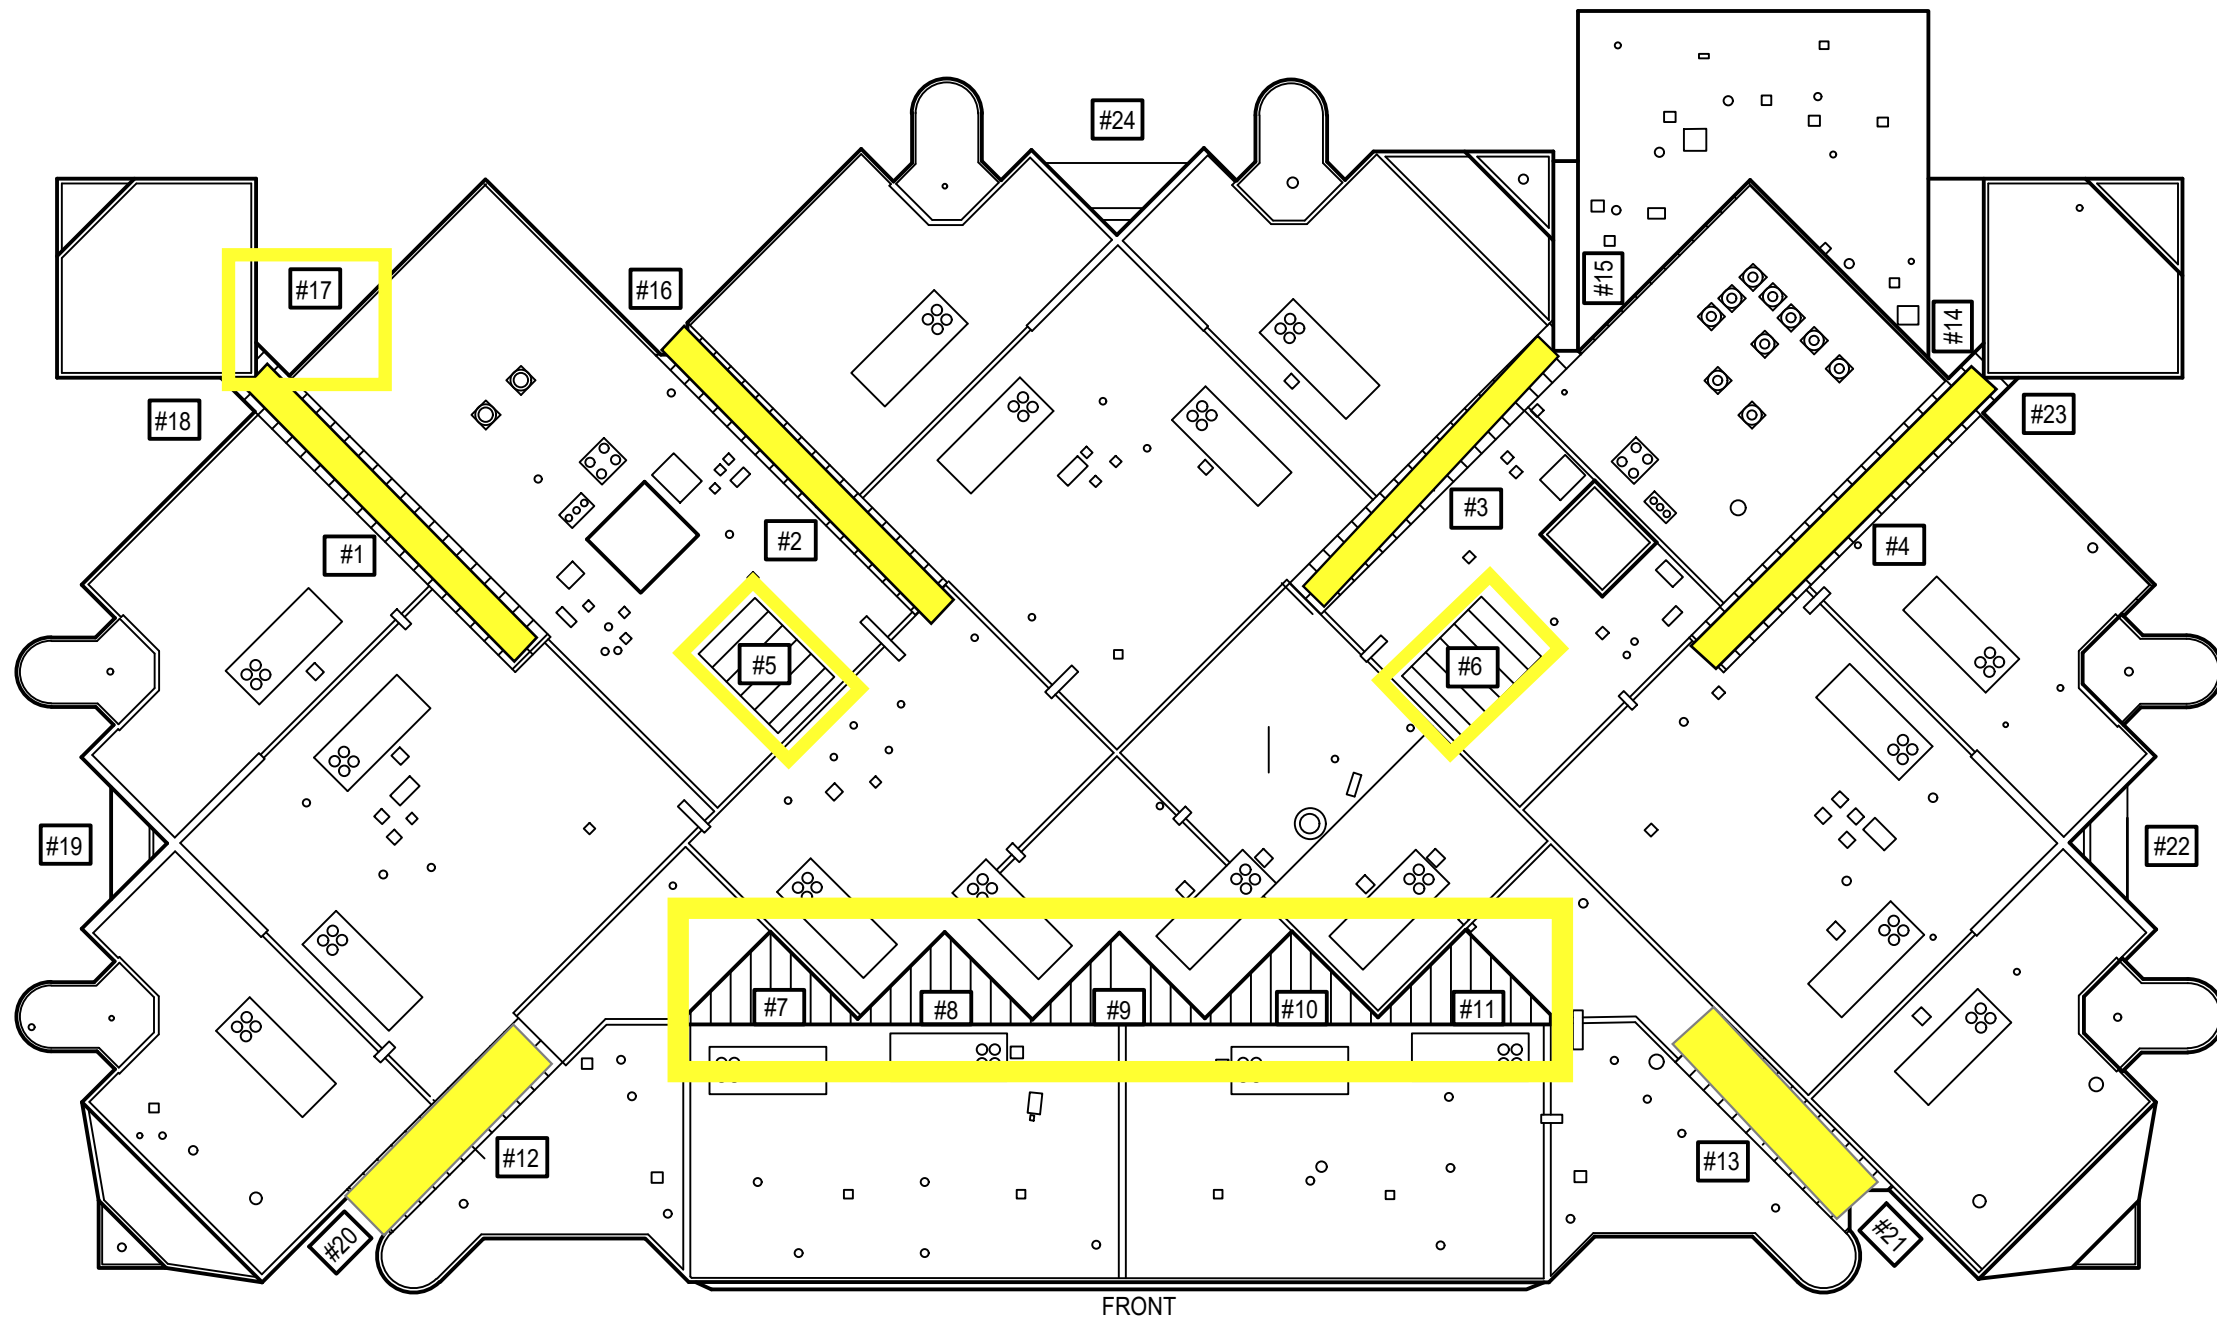

Roofing Consultants, Ltd.
 Engineers, Architects & Building Envelope Specialists
 1 (800) 549-0802
 www.rcleng.com

ROOF PLAN
 PREPARED FOR: FM GLOBAL
 MINNEAPOLIS PUBLIC SCHOOLS (ANDERSON UNITED MIDDLE SCHOOL)
 1098 ANDERSON LANE
 MINNEAPOLIS, MN 55407

PROJECT NUM:
N/A
 SHEET SIZE:
11 x 17 (B)
 DWN BY: MP
 CHK BY: JW
 DATE: 1/5/2024
 SCALE: 1" = 50'-0"

SHEET NO.
A1

DISCLAIMER: THIS DRAWING CONTAINS INFORMATION WHICH IS CONFIDENTIAL AND PROPRIETARY AND MUST BE KEPT CONFIDENTIAL AND NOT BE DISCLOSED, IN WHOLE, OR IN PART, TO ANYONE WITHOUT PRIOR WRITTEN AUTHORIZATION OF RCL ENGINEERING GROUP. BY ACCESSING THIS DOCUMENT YOU AGREE TO KEEP CONFIDENTIAL ALL THE INFORMATION DISCLOSED IN THE FILE AND RELATED MATERIALS.