



FILE: F:\886-F-1\CS2\886F1 ED1.1.DWG - SWED BY: DBDYER DATE: 6/24/2024 TIME: 11:07 AM

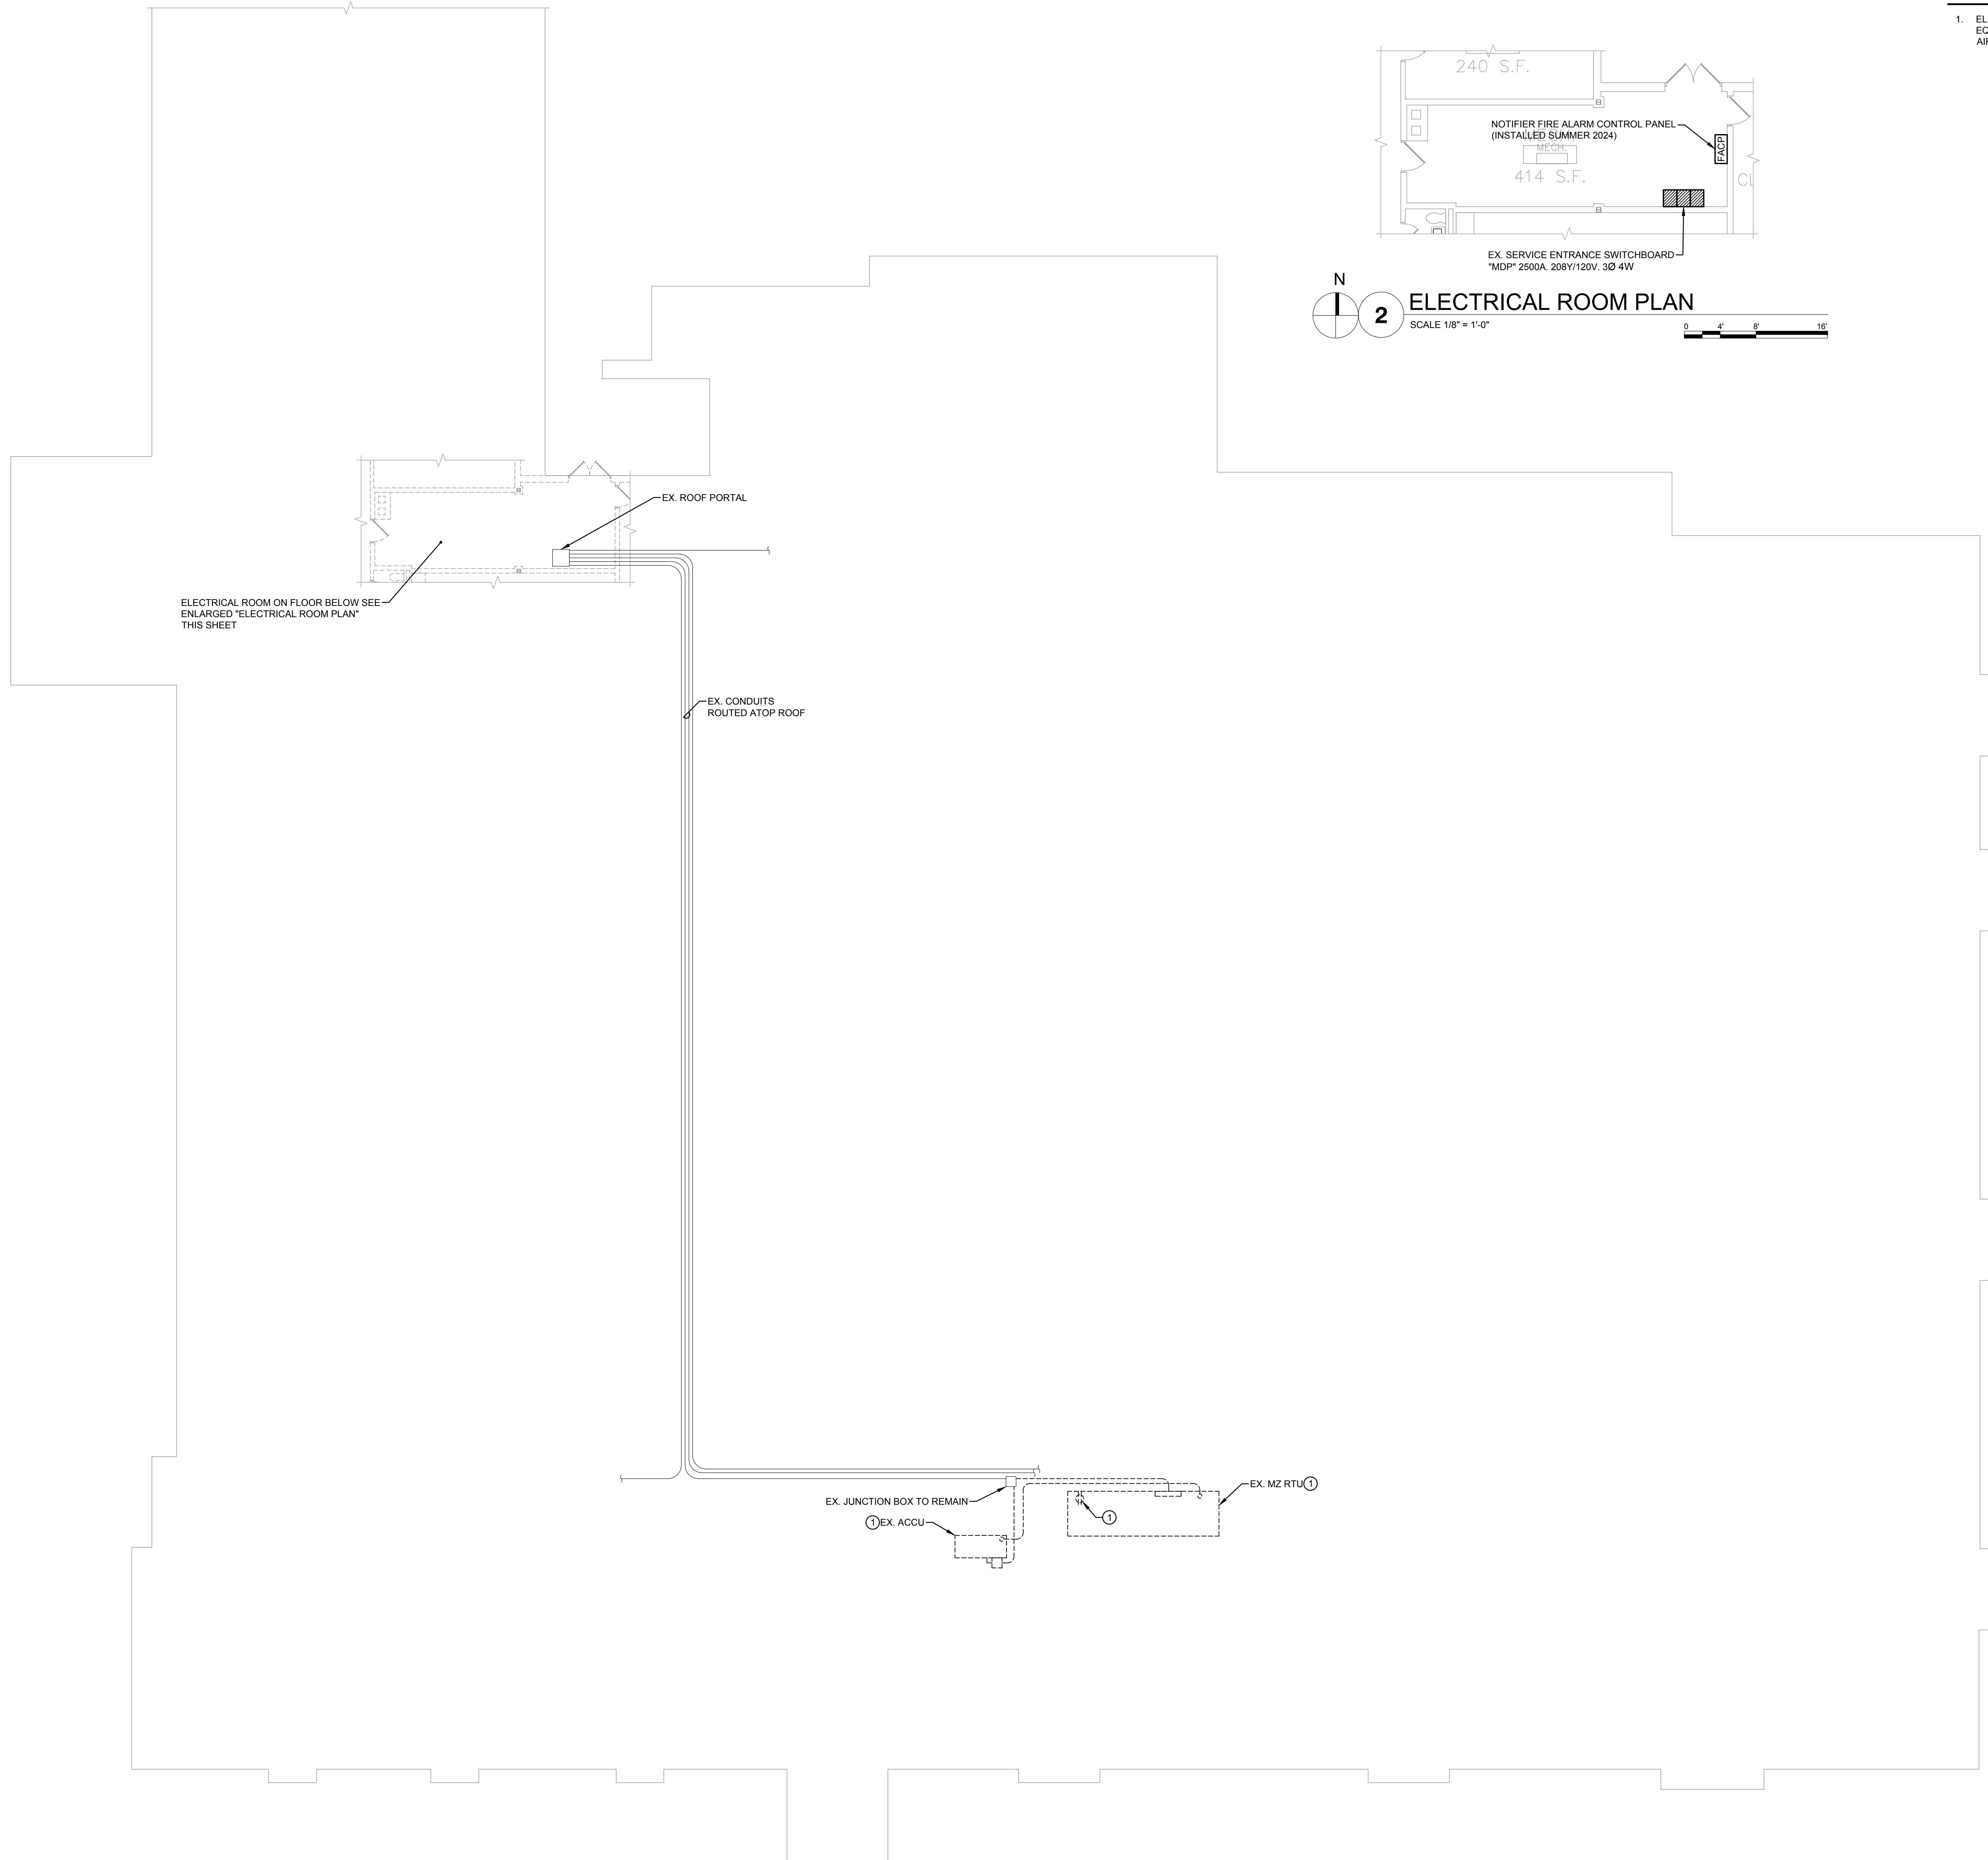

1 ROOF PLAN - ELECTRICAL DEMOLITION
 SCALE 3/32" = 1'-0"
 0 5 10 20

2 ELECTRICAL ROOM PLAN
 SCALE 1/8" = 1'-0"
 0 4 8 16

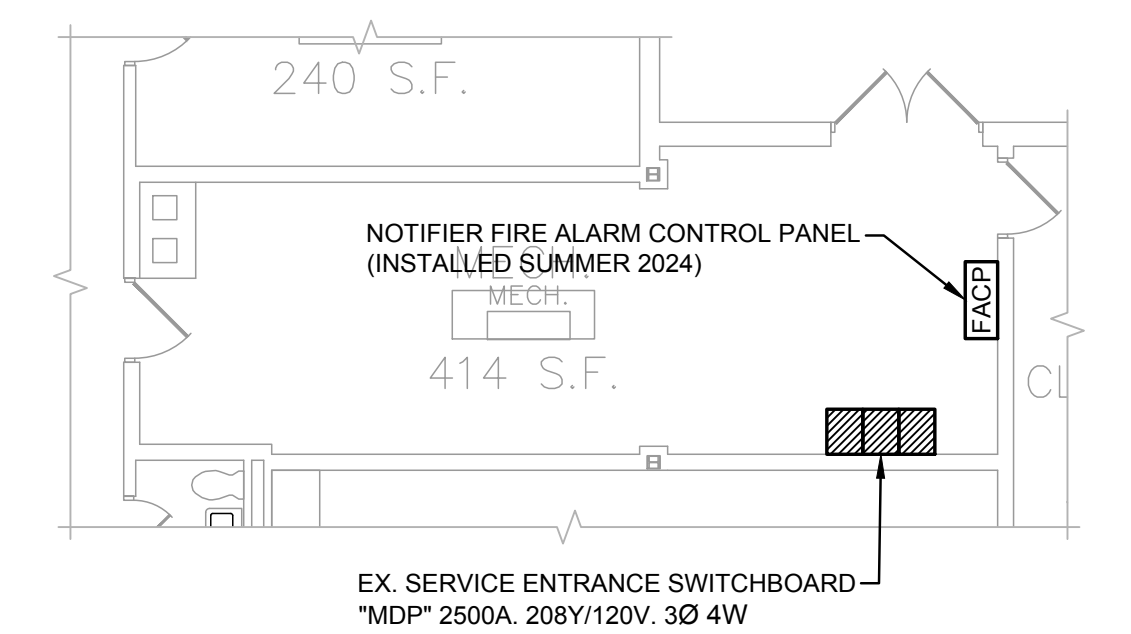

DRAWING NOTES:
 1. ELECTRONICALLY DISCONNECT AND REMOVE ALL ELECTRICAL EQUIPMENT CONDUIT AND WIRING SERVING ROOF TOP UNIT AND AIR COOLED CONDENSING UNIT BACK TO JUNCTION BOX ON ROOF.

Revisions:

ISSUED FOR BID 10/14/2024

CS2 DESIGN GROUP
 LLC

837 Oakton Street
 Elk Grove, IL 60007
 Tel: 847-981-1880
 Fax: 847-981-1885
 www.cs2designgroup.com

**ROOF PLAN - ELECTRICAL
 - DEMOLITION**

ROOFTOP UNIT REPLACEMENT
 RAYMOND ELLIS ELEMENTARY SCHOOL
 720 CENTRAL PARK DR, ROUND LAKE, IL 60073
 ROUND LAKE CUSD 116
 884 W NIPPERSINK RD
 ROUND LAKE, IL 60073

Issue Date:
 24 JUNE 2024

Drawn By:
 CS2

Job Number:
 886-F-1

ED1.1

COPYRIGHT © 2024
 CS2 Design Group, LLC