

Measure C Bond Office

March 4, 2025

To: All Bidders

From: Sandra Lovaas, Measure C Bond Manager
Pleasant Valley School District

Subject: Addendum 2, Bid FB-25-02, Camarillo Heights STEM Academy, Campus
Fire Alarm Upgrades

This addendum is hereby made a part of the Contract Documents for **Bid FB-25-02, Camarillo Heights STEM Academy, Campus Fire Alarm Upgrades** to the same extent as though it was originally included therein and takes precedence over the original documents.

Receipt of this addendum should be acknowledged on the Bid Form.

- 1) Provides a copy of CCD-001, dated 3/3/25, drawings and narrative.



Date: March 3, 2025

To: **Todd Jespersion**
KBZ Architects

From: Kenneth Lucci P.E. 
Lucci & Associates

Project: PVSD Camarillo Heights Elementary School 03-124308
Subject: Narrative for CCD-001 delta 1 regarding electrical changes to Contract Documents

The following list contains the sheet number and CCD revision (dated 3-3-25) for each item which is clouded on the attached documents:

E600

- Added note that Kitchen modular FA is already being completed in 02-122807 and is not included in this set
- Added site FA feeders from FACP to all RPS units and to building FATC for site interconnection.
- Added key notes denoted conduit sizes (cabling is shown on E700 & E701)
- Added general notes specific to the installation of the conduits on the site.

E680

- Added note changing home run to be Building 1000 Kindergarten RPS

E700

- Added key note 7 to all FSD devices
- Moved the SLC, SAC, & NAC loops for Building 800 to be connected to Building 1000 'Kindergarten' RPS

E701

- Removed Building 1200 RPS from Riser Diagram and noted the RPS for Kitchen Modular is existing.
- Modified the FA connection to Building 800 to be RPS1000 (Building 1000 - Kindergarten) and not to the FACP directly.
- Noted that the main FACP is already installed as a part of the Kitchen Modular project

E770

- Moved Building 800 S3 and V3 calculations from Building 700 to Building 1000 RPS Calculations.

E791

 
- Moved Building 800 S3 and V3 calculations from Building 700 to Building 1000 RPS Calculations.
- Revised battery calculations to 28 AH

E793

- Noted the Kitchen Modular was already completed and the FACP installed in Administration

E610, E620, E630, E640, E650, E660, E670, E680, E690, & E691

- Changed smoke detectors so only one CO (Carbon Monoxide) detector is needed in each room, the remaining detectors will be the Silent Knight IDF-PHOTO-W.




- KEY NOTES:**
- 1 1.5" C WITH FA CABLING PER E701.
 - 2 2" C WITH FA CABLING PER E701.
 - 3 1.25" C WITH FA CABLING PER E701.
 - 4 NEW PULLBOX NEMA 3R - 18" x 18" x 6", (LABEL 'FIRE ALARM').

LUCCI & ASSOCIATES INC.
CONSULTING ELECTRICAL ENGINEERS
3251 CORTE MALPASO, #511
CAMARILLO, CA 93012-8094
(805) 389-6520 FAX (805) 389-6519

LUCCI & ASSOCIATES, INC. reserve their commonlaw copyright and other property rights in these plans. These plans and drawings are not to be reproduced, changed, or copied in any form or manner whatsoever without first obtaining the expressed written permission and consent of LUCCI & ASSOC. INC nor are they to be assigned to any third party without obtaining said written permission and consent.




FIRE ALARM SITE PLAN - NEW WORK

PROJECT:
CAMARILLO HEIGHTS
ELEMENTARY SCHOOL
35 CATALINA DRIVE
CAMARILLO, CA 93010
CAMPUS FIRE ALARM UPGRADE

REV	DATE	REVISIONS	
	3-3-2025	CCD-01	
CHECKED: K. LUCCI		DRAWN: LK/DS	
JOB NO. 19753-01		SCALE: AS NOTED	DATE: 01-18-202


E600

OF: SHEETS:

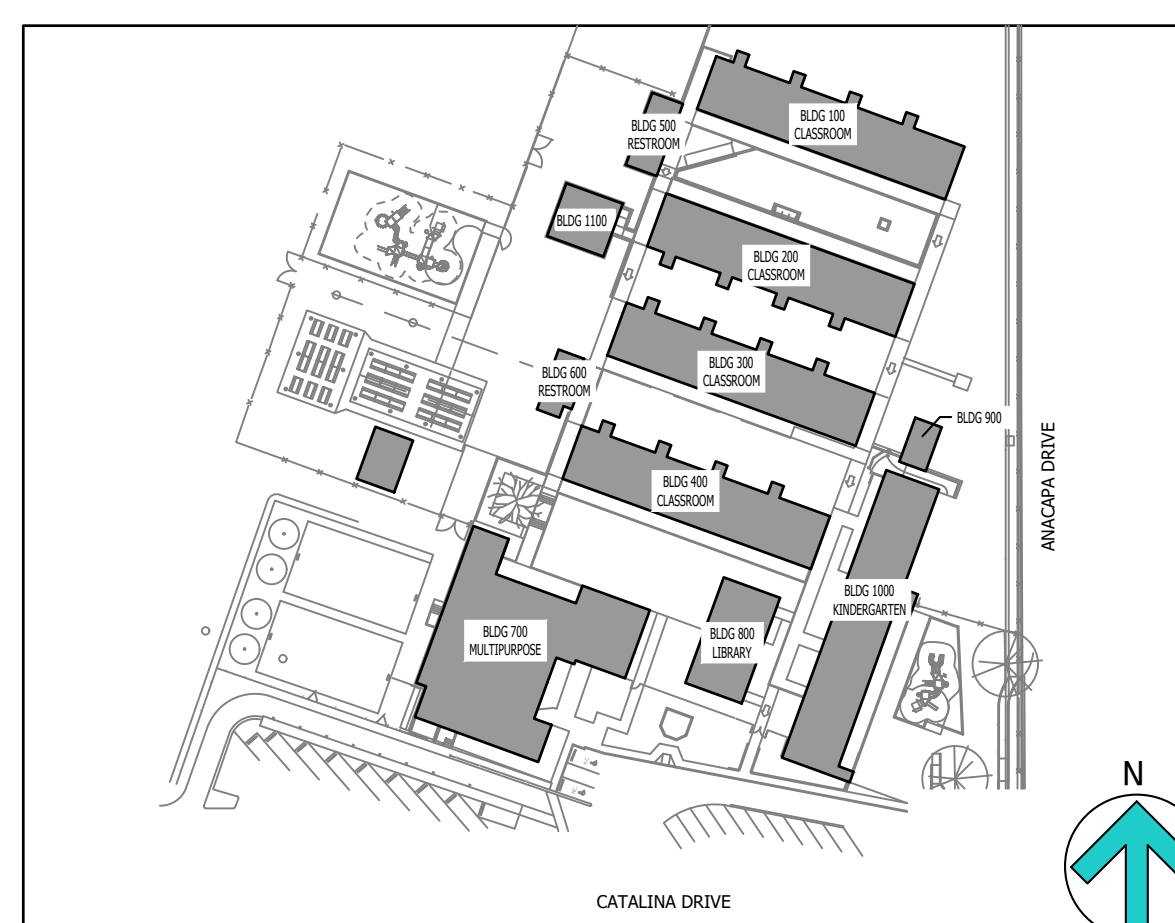

KEY MAP

DATE: 3 March 2025
TIME: 3:34 pm
PLOT DATE: 3/3/2025 3:34:39 PM
PLOT BY: CM02
SAVE DATE: 3/3/2025 2:33:24 PM
PATHNAME: G:\19\753\EL\Sheets\01-Camarillo Heights ES
DRAWING FILENAME: 19753-01-E610
DRAFTER: CM02
PROJECT TITLE: CAMARILLO HEIGHTS ELEMENTARY SCHOOL
35 CATALINA DRIVE
CAMARILLO, CA 93010
CAMPUS FIRE ALARM UPGRADE

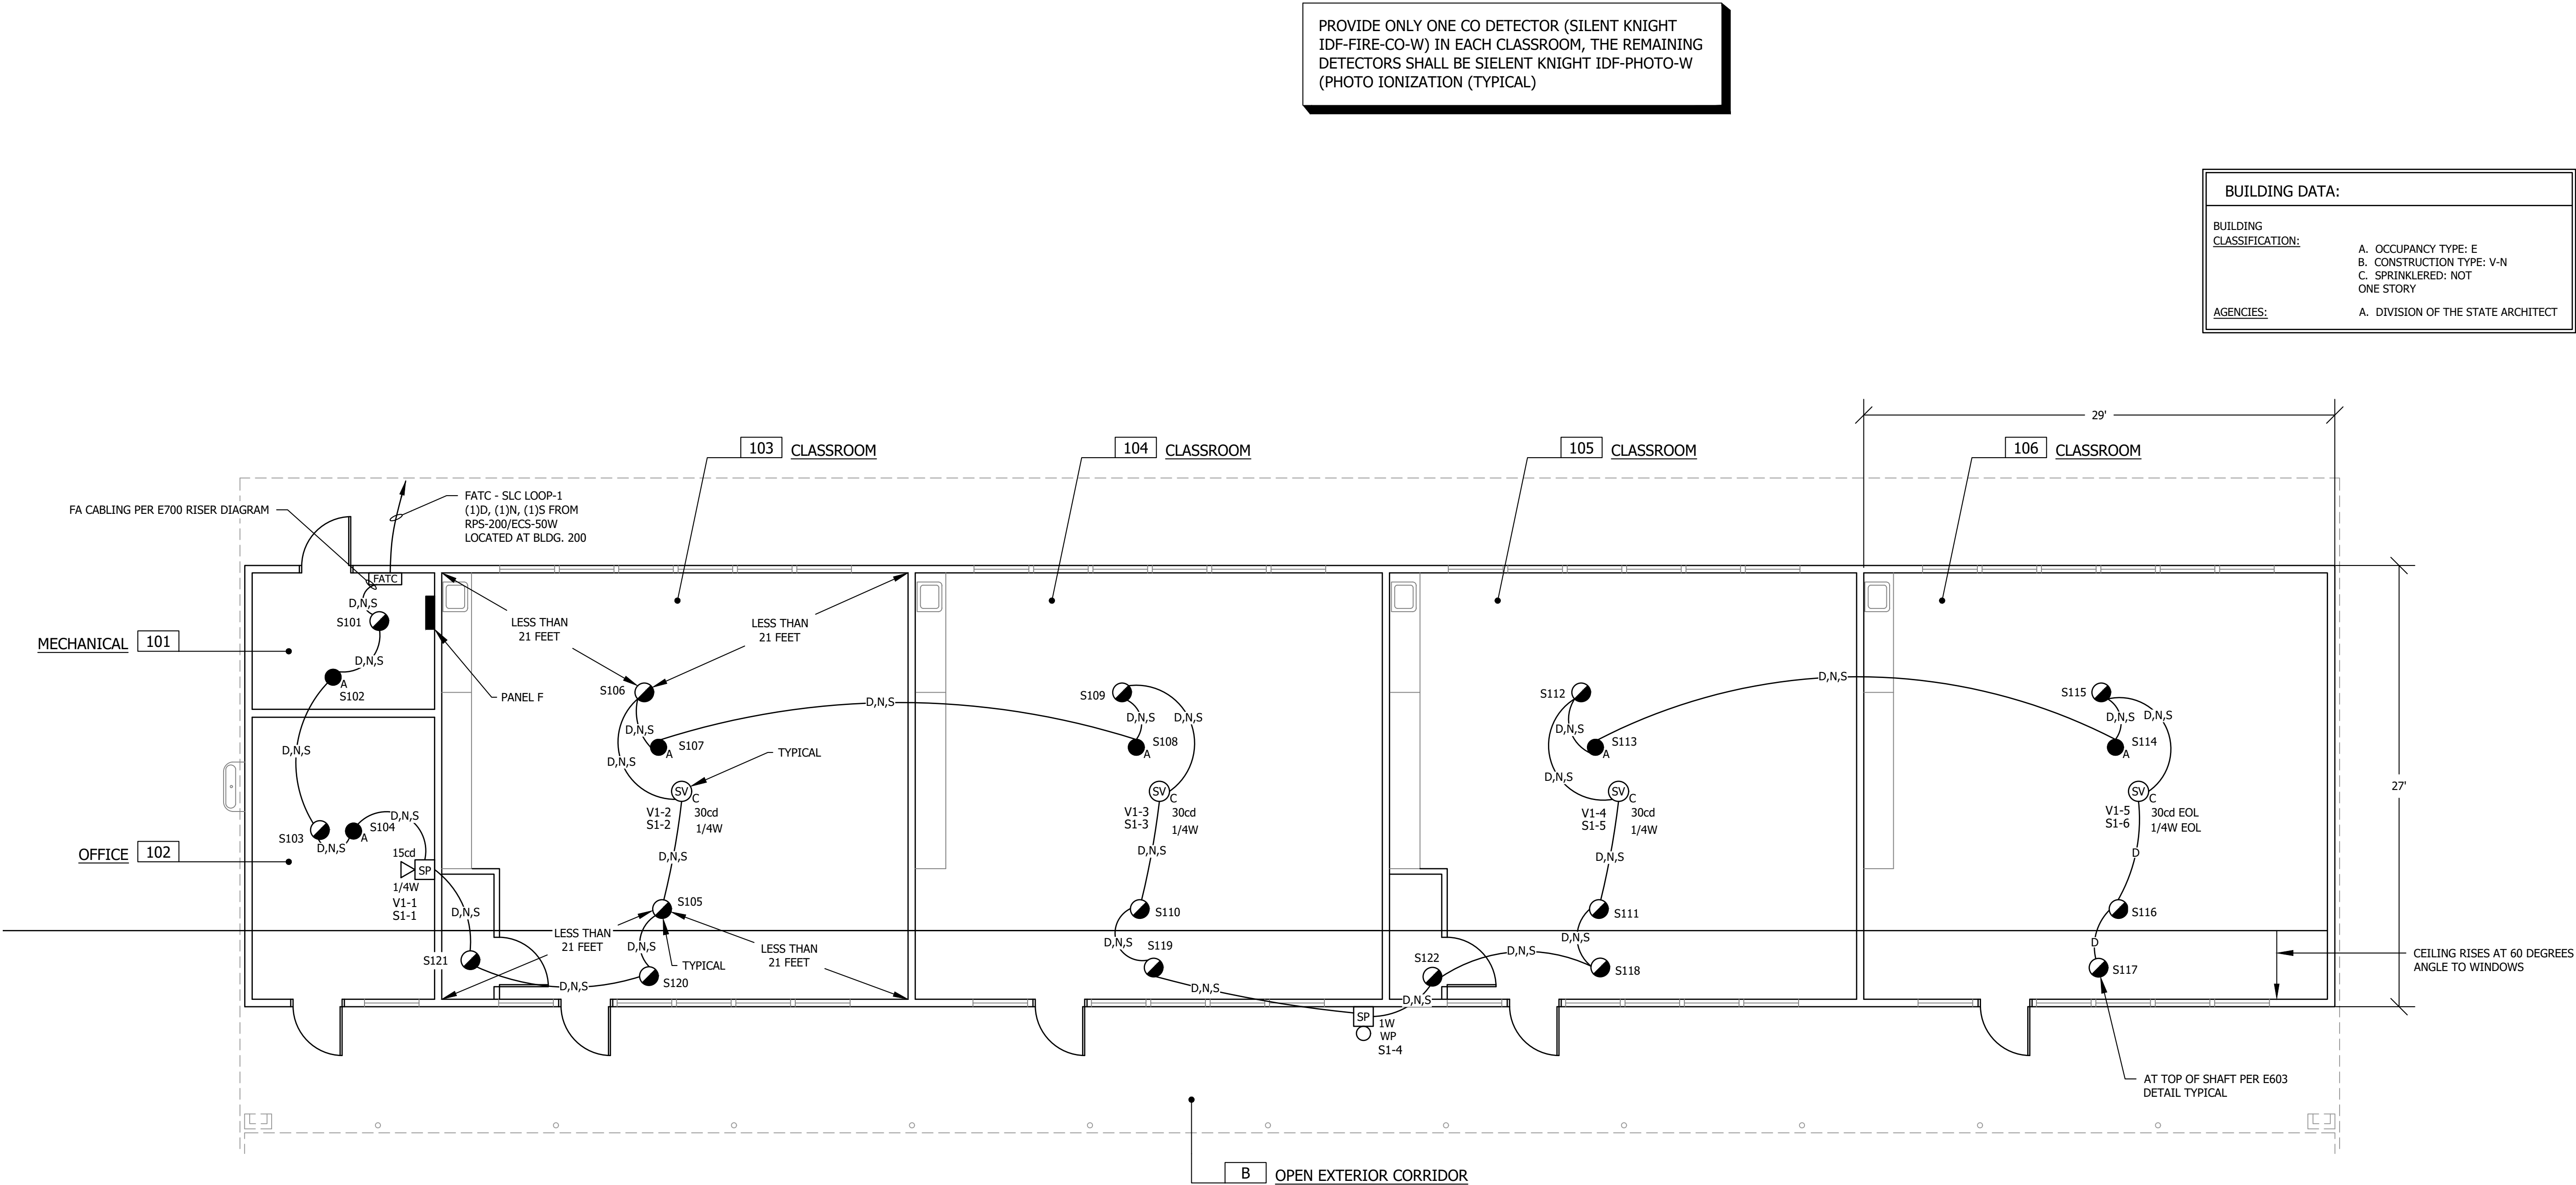

- SHEET NOTES:
- FIELD VERIFY LOCATION OF ALL DEVICES.
 - 3/4" CONDUIT MINIMUM UNLESS OTHERWISE NOTED.
 - CONTRACTOR SHALL FURNISH AND INSTALL PULL BOXES AS REQUIRED TO INSTALL CABLING PER CABLE MANUFACTURERS RECOMMENDATIONS.
 - UNIQUELY LABEL BOTH ENDS OF ALL CABLING.

BUILDING DATA:	
BUILDING CLASSIFICATION:	A. OCCUPANCY TYPE: E B. CONSTRUCTION TYPE: V-N C. SPRINKLERED TYPE: NOT ONE STORY
AGENCIES:	A. DIVISION OF THE STATE ARCHITECT

LUCCI & ASSOCIATES INC.
CONSULTING ELECTRICAL ENGINEERS
3251 CORTE MALPASO, #511
CAMARILLO, CA 93012-8094
(805) 389-6520 FAX (805) 389-6519
LUCCI & ASSOCIATES, INC. reserve their commonlaw copyright and other property rights in these plans. These plans and drawings are not to be reproduced, changed, or copied in any form or manner whatsoever without first obtaining the expressed written permission and consent of LUCCI & ASSOC. INC nor are they to be assigned to any third party without obtaining said written permission and consent.

STAMP



CLASSROOM BUILDING 100
FIRE ALARM PLAN - NEW WORK


SHEET TITLE:

PROJECT:

REV	DATE	REVISIONS
1		
CHECKED: K. LUCCI	DRAWN: LK/DS	DATE: 01-18-2024
JOB NO. 19753-01	SCALE: AS NOTED	
SHEET:		

E610

OF: SHEETS:

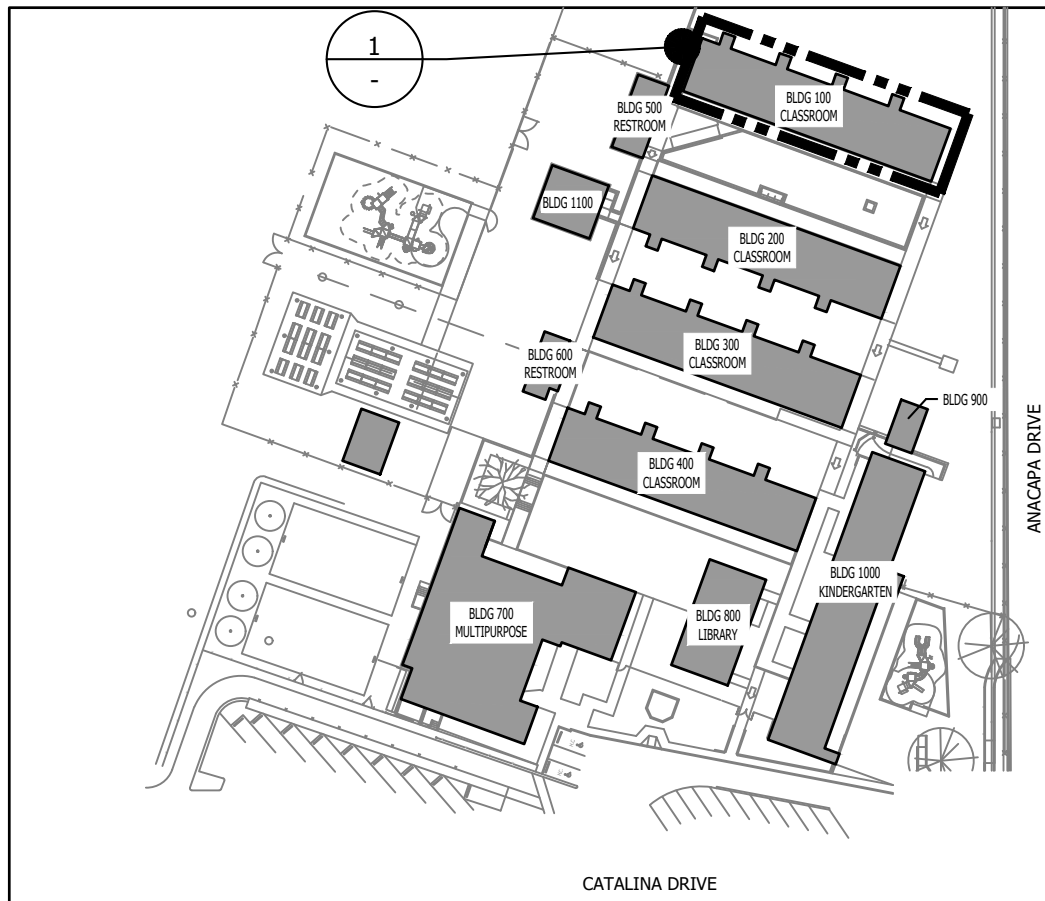

KEY MAP

SHEET NOTES:

1. FIELD VERIFY LOCATION OF ALL DEVICES.
2. 3/4" CONDUIT MINIMUM UNLESS OTHERWISE NOTED.
3. CONTRACTOR SHALL FURNISH AND INSTALL PULL BOXES AS REQUIRED TO INSTALL CABLING PER CABLE MANUFACTURERS RECOMMENDATIONS.
4. UNIQUELY LABEL BOTH ENDS OF ALL CABLING.

STAMP



BUILDING DATA:	
<u>BUILDING</u>	
<u>CLASSIFICATION:</u>	A. OCCUPANCY TYPE: E B. CONSTRUCTION TYPE: V-N C. SPRINKLERED: NOT ONE STORY
<u>AGENCIES:</u>	A. DIVISION OF THE STATE ARCHITECT

HEET TITLE:

RESTROOM BUILDING 500


FIRE ALARM PLAN - NEW WORK

PROJECT: CAMARILLO HEIGHTS
ELEMENTARY SCHOOL
35 CATALINA DRIVE
CAMARILLO, CA 93010
CAMPUS FIRE ALARM UPGRADE

REV	DATE	REVISIONS
1		
CHECKED: K. LUCCI		DRAWN: LK/DS
JOB NO. 19753-01		SCALE: AS NOTED
		DATE: 01-18-2024

E650

OF: SHEETS:

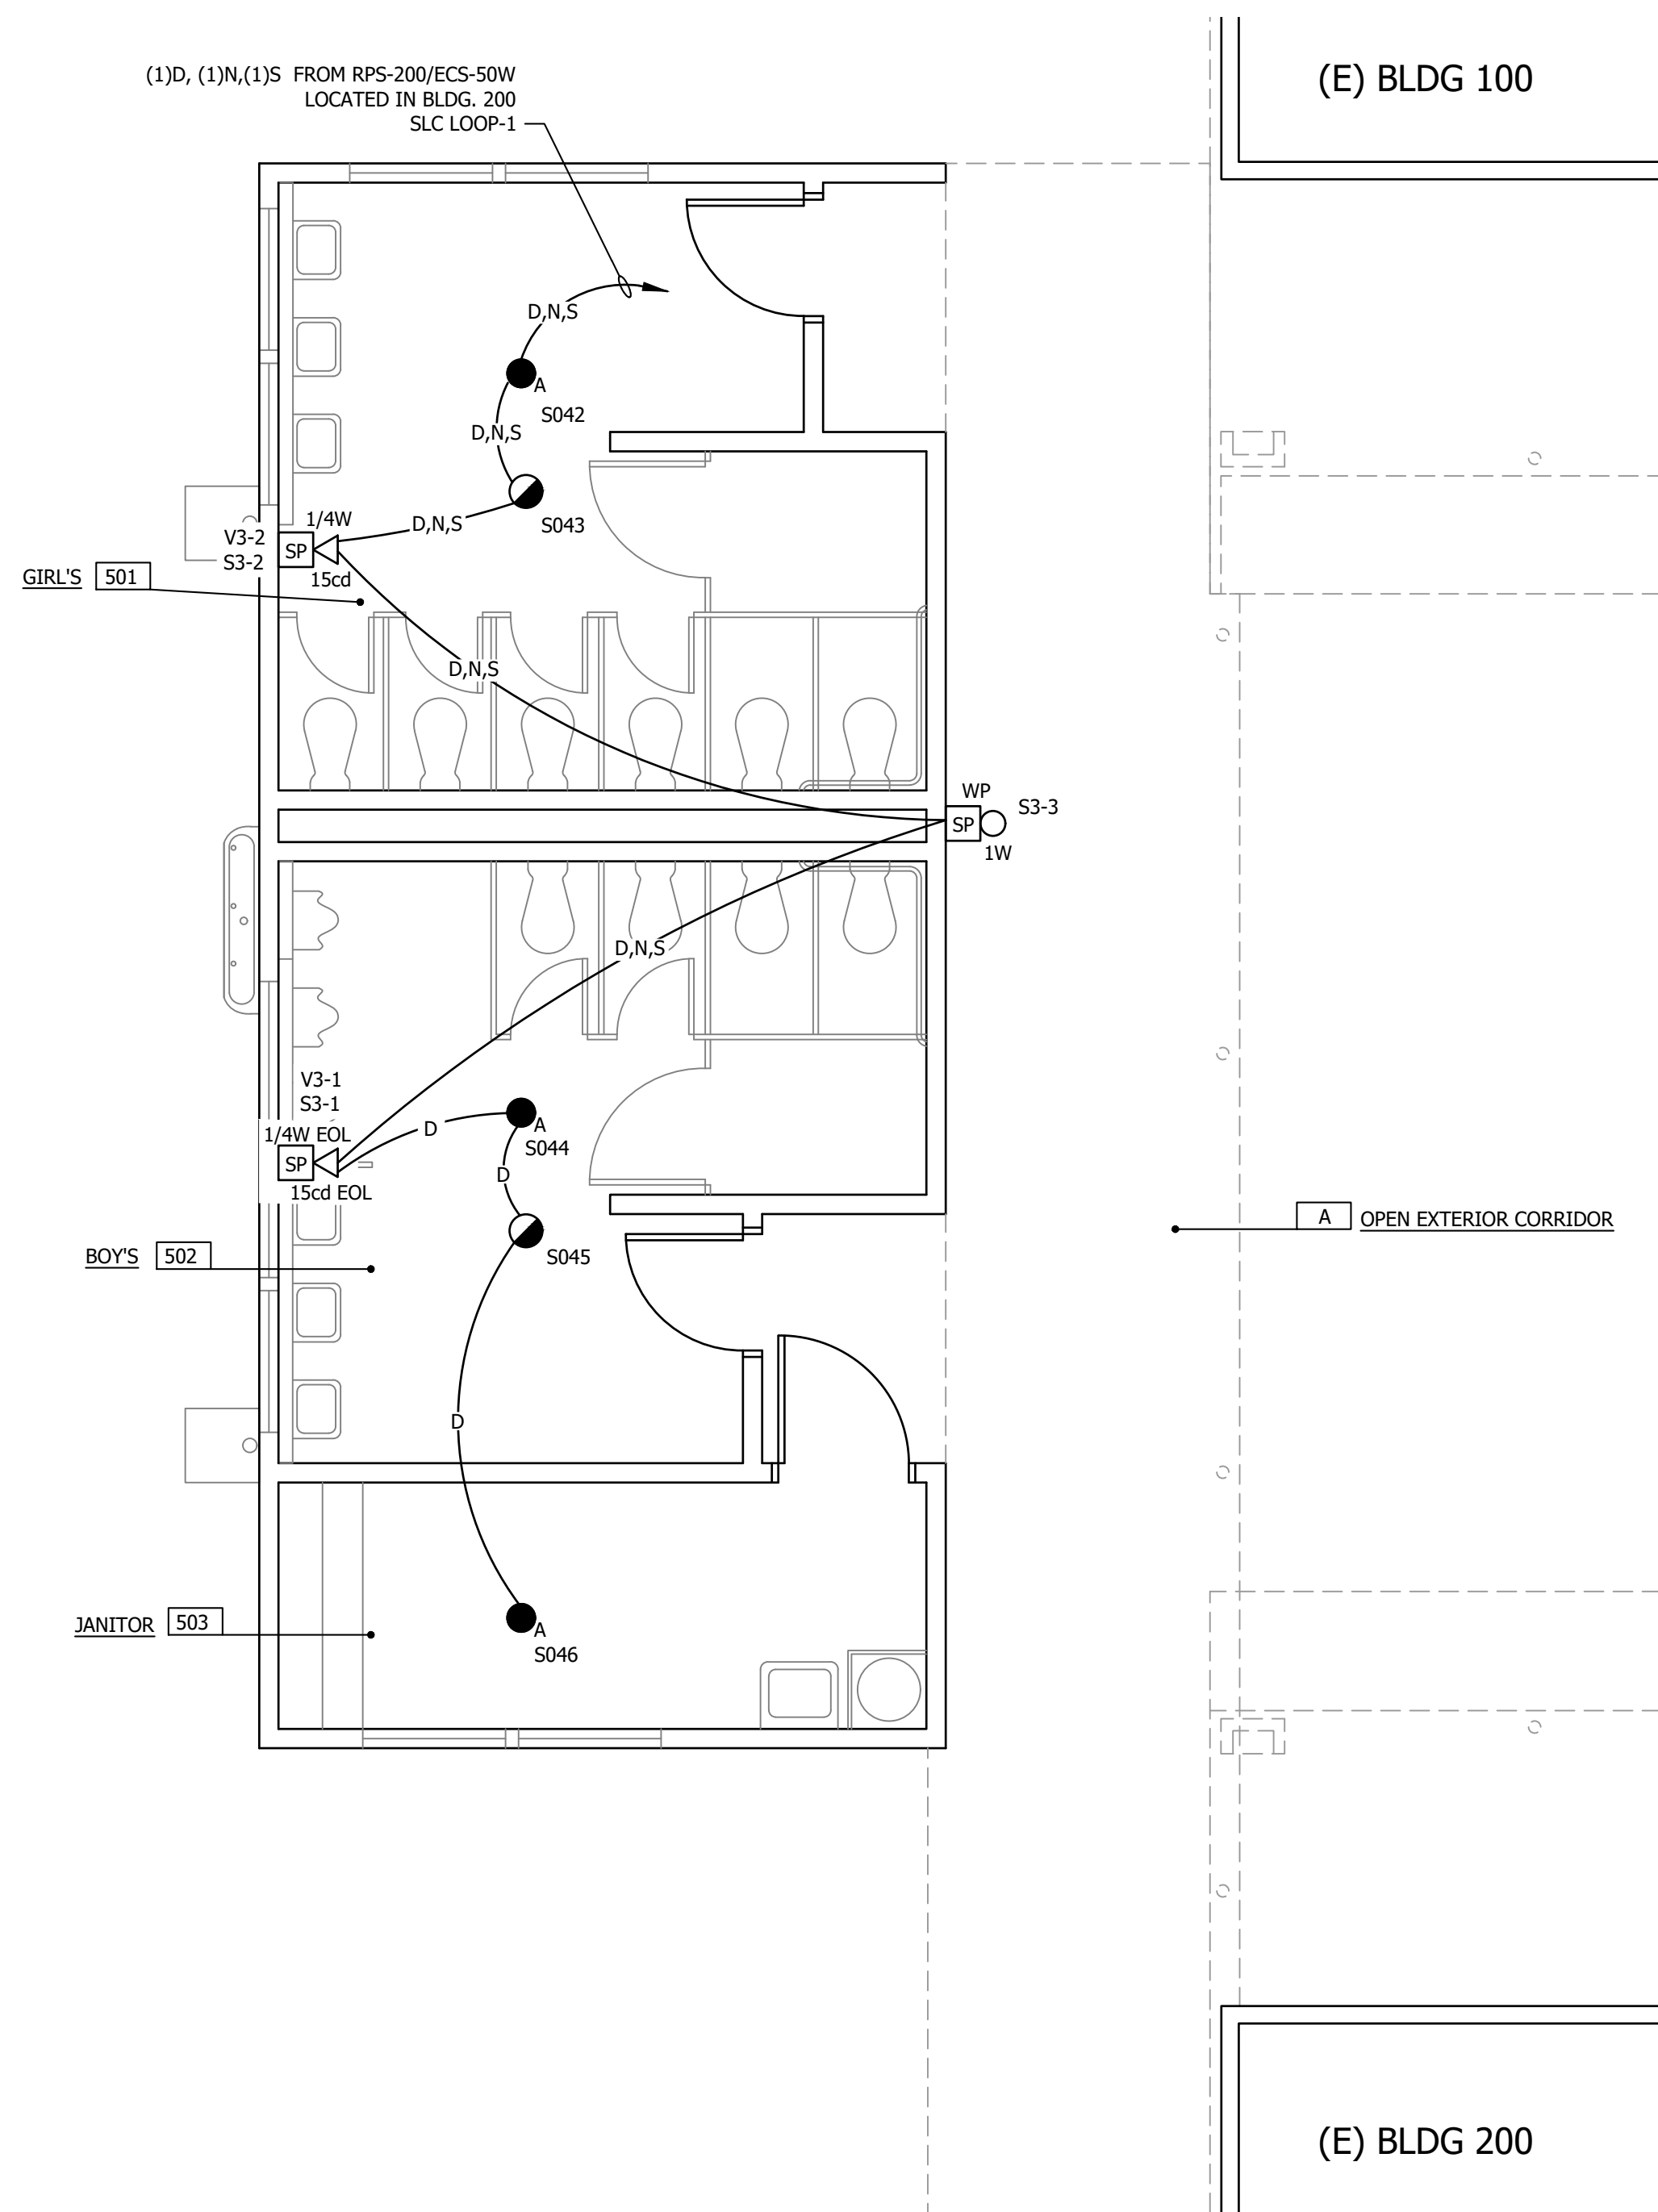


SCALE: $1/4" = 1'-0"$


RESTROOM BUILDING 500 FIRE ALARM PLAN - NEW WORK
SCALE: 1/4"=1'-0"



KEY MAP

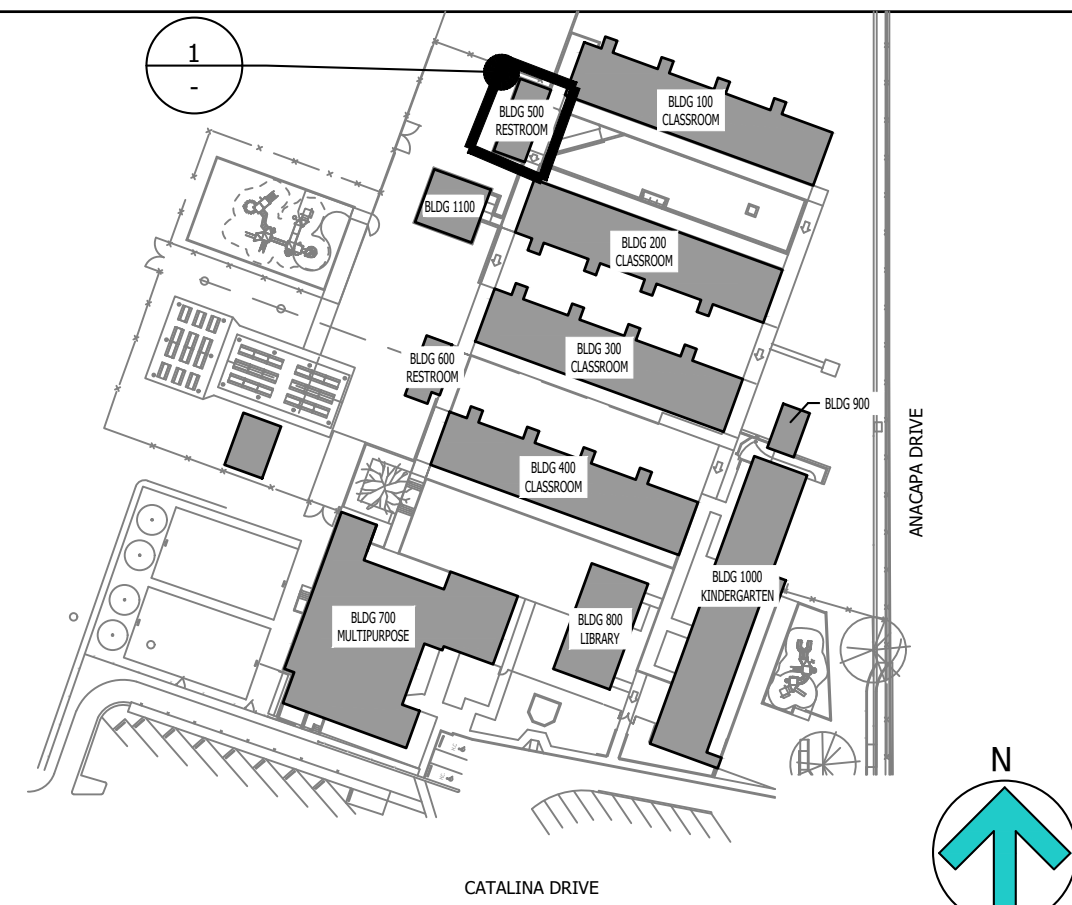


 Copyright Lucci and Associates Consulting Electrical Engineers. Deviations from this drawing will not be made without their expressed written permission. L.A.I.# 19753-01 PAPER SIZE 36"x24"




RESTROOM BUILDING 600 FIRE ALARM PLAN - NEW WORK

SCALE: 1/4"=1'-0"

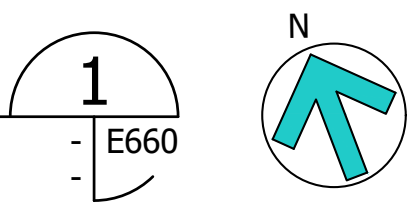


PROVIDE ONLY ONE CO DETECTOR (SILENT KNIGHT IDF-FIRE-CO-W) IN EACH CLASSROOM, THE REMAINING DETECTORS SHALL BE SILENT KNIGHT IDF-PHOTO-W (PHOTO IONIZATION (TYPICAL))

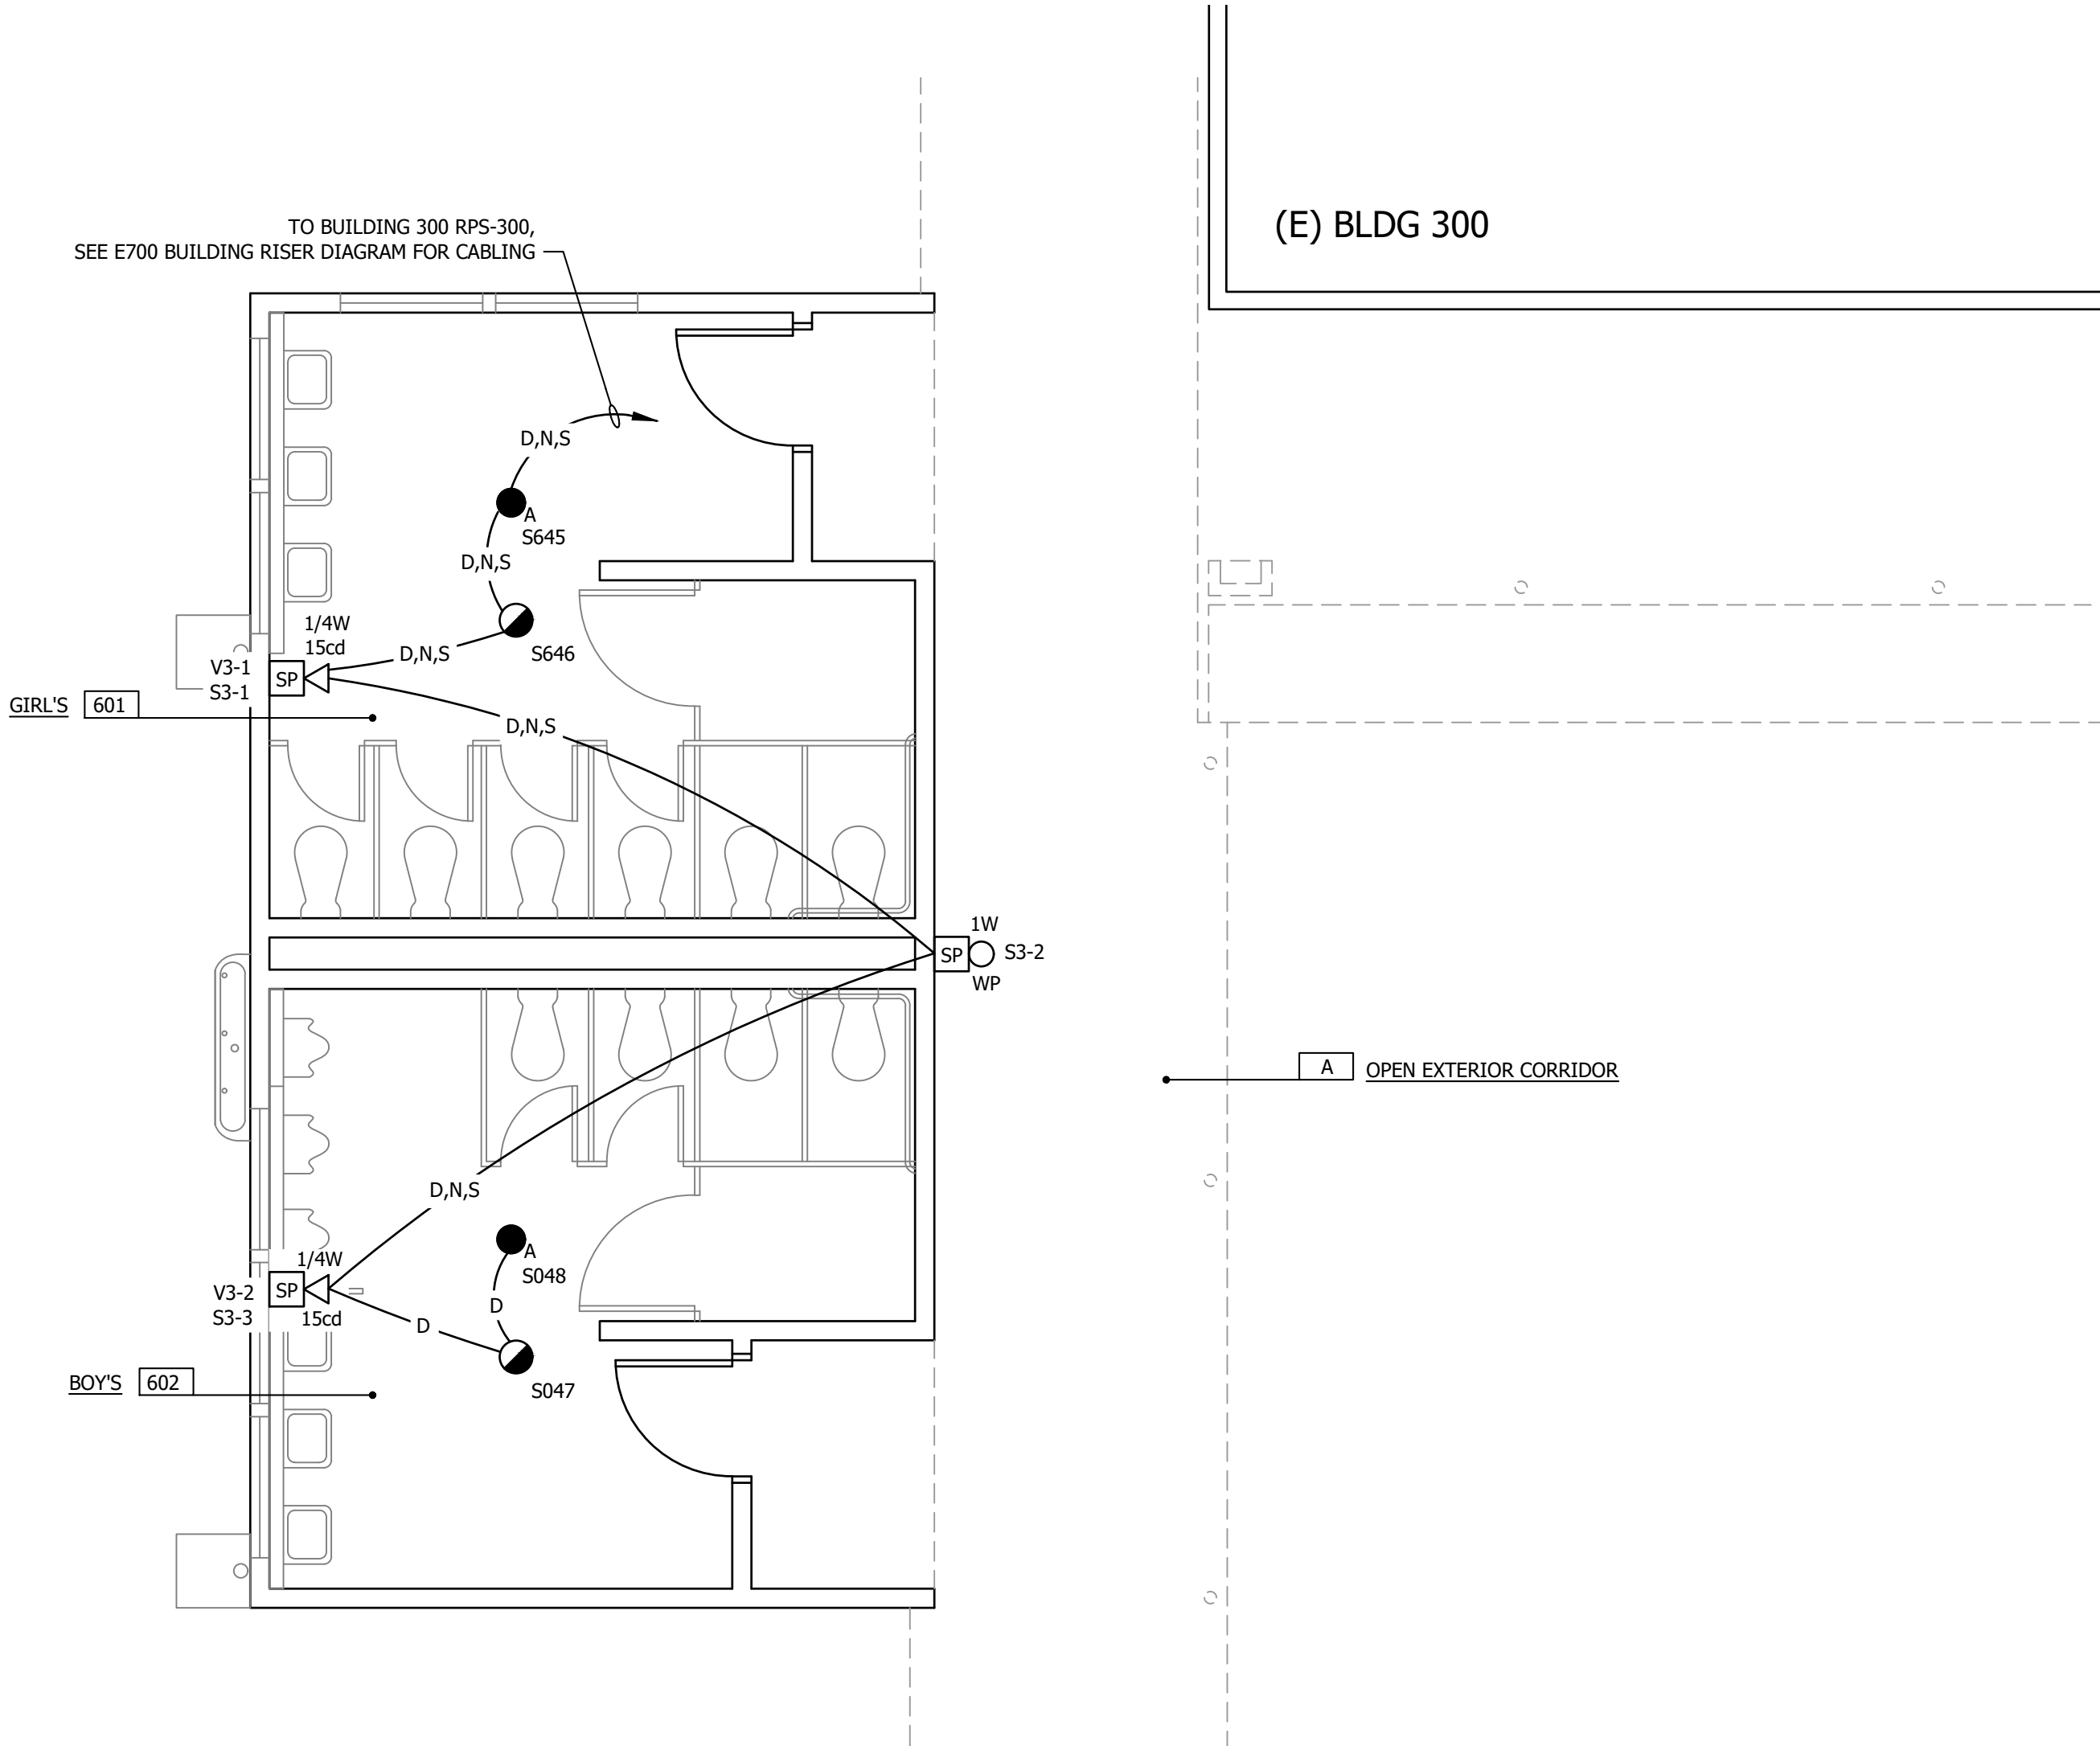

- SHEET NOTES:**
- FIELD VERIFY LOCATION OF ALL DEVICES.
 - 3/4" CONDUIT MINIMUM UNLESS OTHERWISE NOTED.
 - CONTRACTOR SHALL FURNISH AND INSTALL PULL BOXES AS REQUIRED TO INSTALL CABLING PER CABLE MANUFACTURERS RECOMMENDATIONS.
 - UNIQUELY LABEL BOTH ENDS OF ALL CABLING.

CONTRACTOR TO PROVIDE ACCESS PANELS FOR ALL HEAT DETECTORS ABOVE CEILING

BUILDING DATA:	
BUILDING CLASSIFICATION:	A. OCCUPANCY TYPE: E B. CONSTRUCTION TYPE: V-N C. SPRINKLERED: NOT ONE STORY
AGENCIES:	A. DIVISION OF THE STATE ARCHITECT

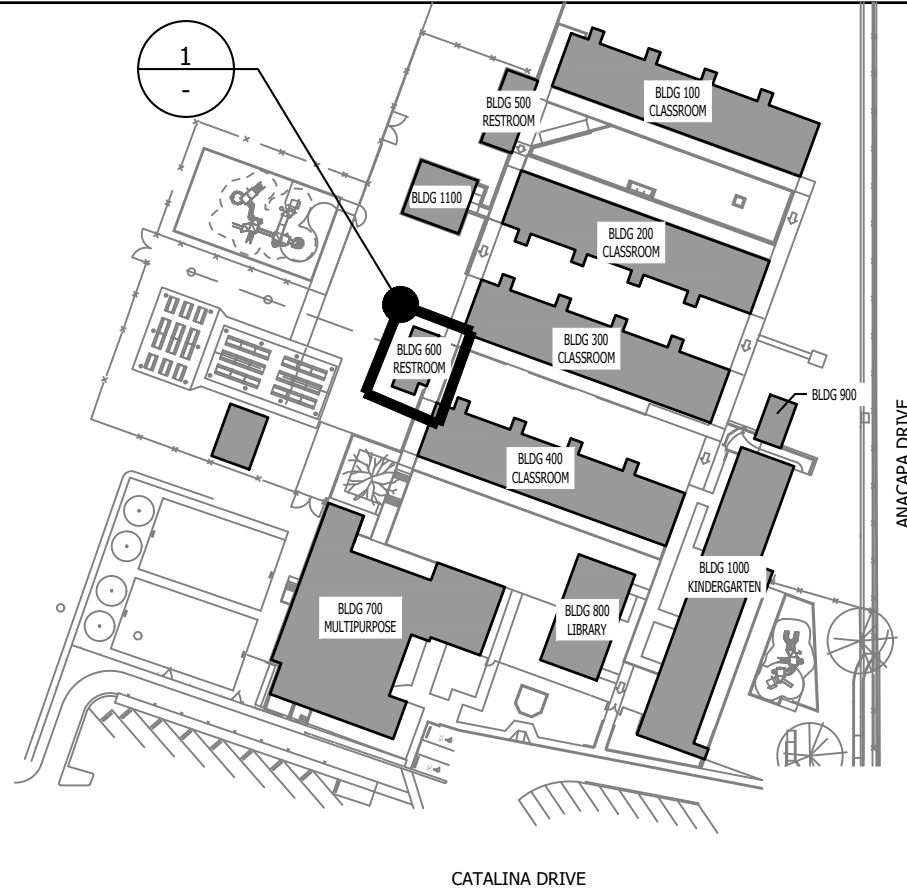

KEY MAP

LUCCI & ASSOCIATES INC.
CONSULTING ELECTRICAL ENGINEERS
3251 CORTE MALPASO, #511
CAMARILLO, CA 93012-8094
(805) 389-6520 FAX (805) 389-6519
LUCCI & ASSOCIATES, INC. reserve their commonlaw copyright and other property rights in these plans. These plans and drawings are not to be reproduced, changed, or copied in any form or manner whatsoever without first obtaining the expressed written permission and consent of LUCCI & ASSOC. INC nor are they to be assigned to any third party without obtaining said written permission and consent.



PROJECT: CAMARILLO HEIGHTS ELEMENTARY SCHOOL
35 CATALINA DRIVE
CAMARILLO, CA 93010
CAMPUS FIRE ALARM UPGRADE


SHEET TITLE: RESTROOM BUILDING 600
FIRE ALARM PLAN - NEW WORK

PROJECT: CAMARILLO HEIGHTS
ELEMENTARY SCHOOL
35 CATALINA DRIVE
CAMARILLO, CA 93010
CAMPUS FIRE ALARM UPGRADE

REV	DATE	REVISIONS
1		
CHECKED: K. LUCCI		DRAWN: LK/DS
JOB NO. 19753-01		SCALE: AS NOTED
		DATE: 01-18-2024


E660

OF: SHEETS:

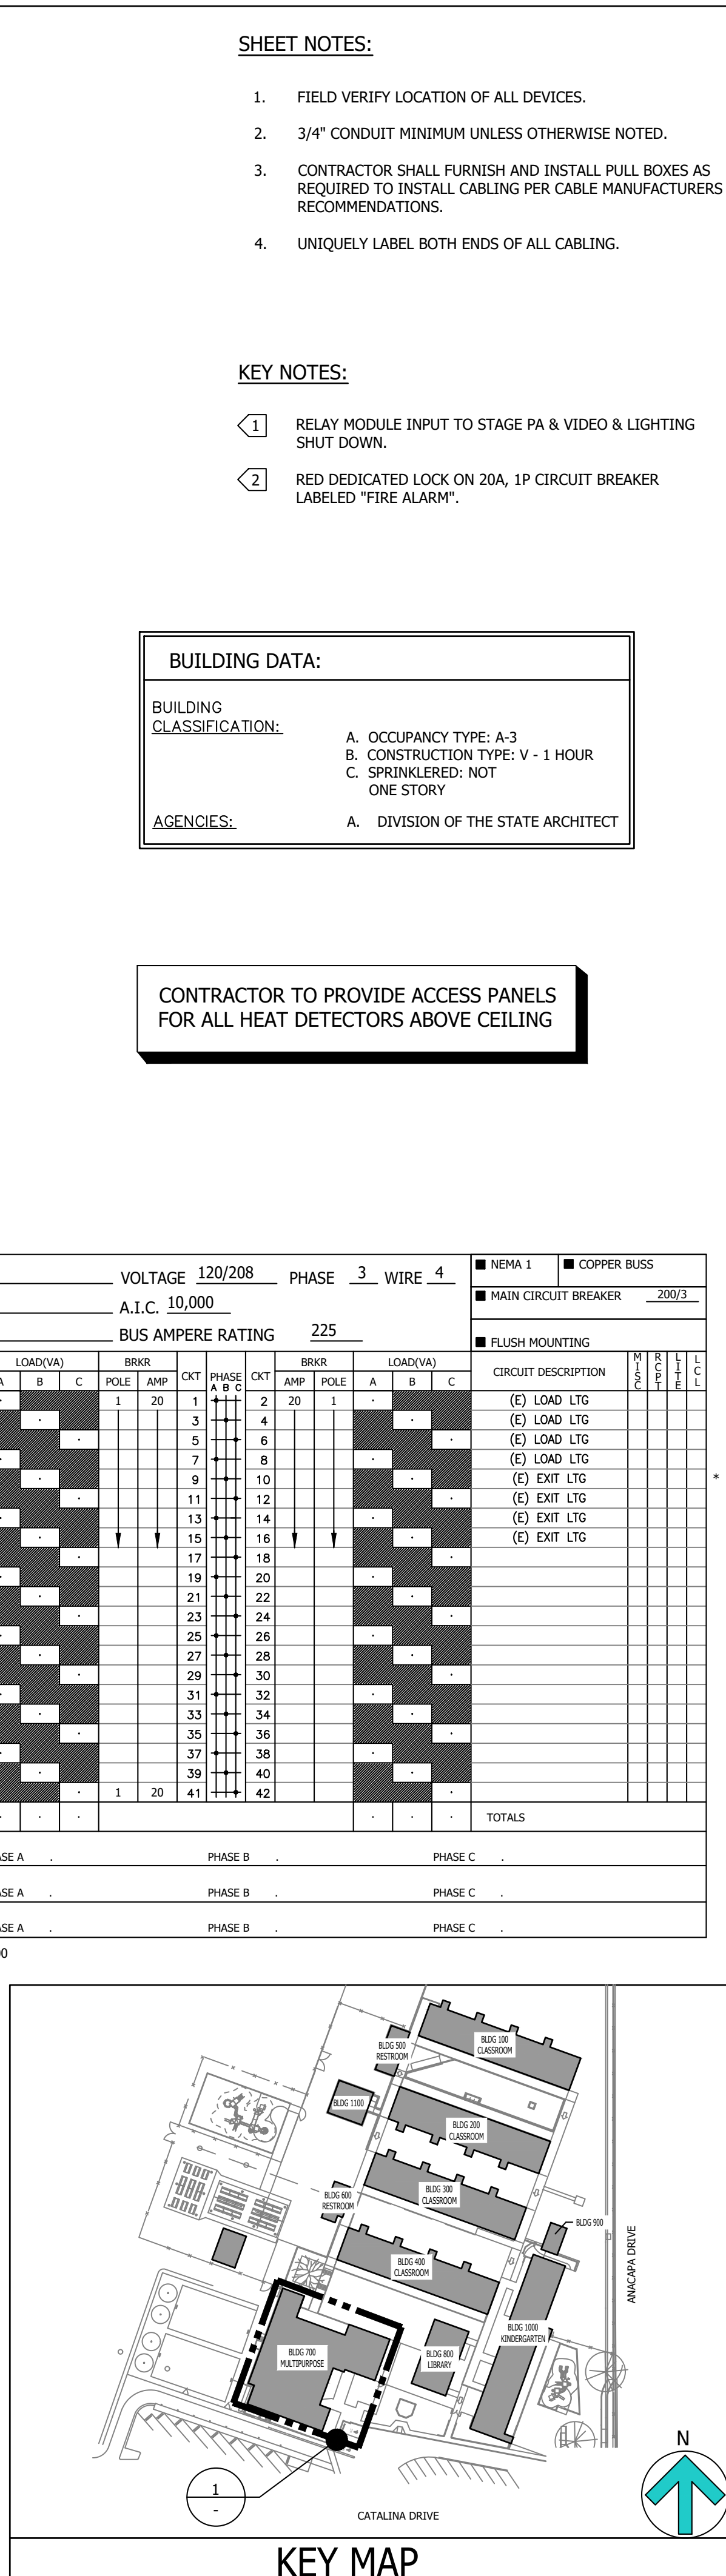

LUCCHI & ASSOCIATES INC. CONSULTING ELECTRICAL ENGINEERS 3251 CORTE MALPASO, #511 CAMARILLO, CA 93012-8094 (805) 389-6520 FAX (805) 389-6519					
LUCCHI & ASSOCIATES, INC. reserve their commonlaw copyright and other property rights in these plans. These plans and drawings are not to be reproduced, changed, or copied in any form or manner whatsoever without first obtaining the expressed written permission and consent of LUCCHI & ASSOC. INC nor are they to be assigned to any third party without obtaining said written permission and consent.					
STAMP					
					
SHEET TITLE: MULTIPURPOSE BUILDING 700 FIRE ALARM PLAN - NEW WORK					
PROJECT: CAMARILLO HEIGHTS ELEMENTARY SCHOOL 35 CATALINA DRIVE CAMARILLO, CA 93010 CAMPUS FIRE ALARM UPGRADE					
REV	DATE	REVISIONS			
A					
CHECKED:	JOB NO.		DRAWN:	DATE:	
K. LUCCI	19753-01		LK/DS	AS NOTED 01-18-2024	
SHEET:					
E670					
OF: SHEETS:					

DATE: 3 March 2025
TIME: 3:35 pm
PLOT DATE: 3/3/2025 3:35:02 PM
PATHNAME: G:\19\753\EL\Sheets\01-Camarillo Heights ES
DRAWING FILENAME: 19753-01-E680
DRAFTER: CM02
PLOT BY: CM02
SAVE DATE: 3/3/2025 2:34:41 PM
DRAFTING: LUCI & ASSOCIATES, INC.
PROJECT: CAMARILLO HEIGHTS ELEMENTARY SCHOOL
35 CATALINA DRIVE
CAMARILLO, CA 93010
CAMPUS FIRE ALARM UPGRADE

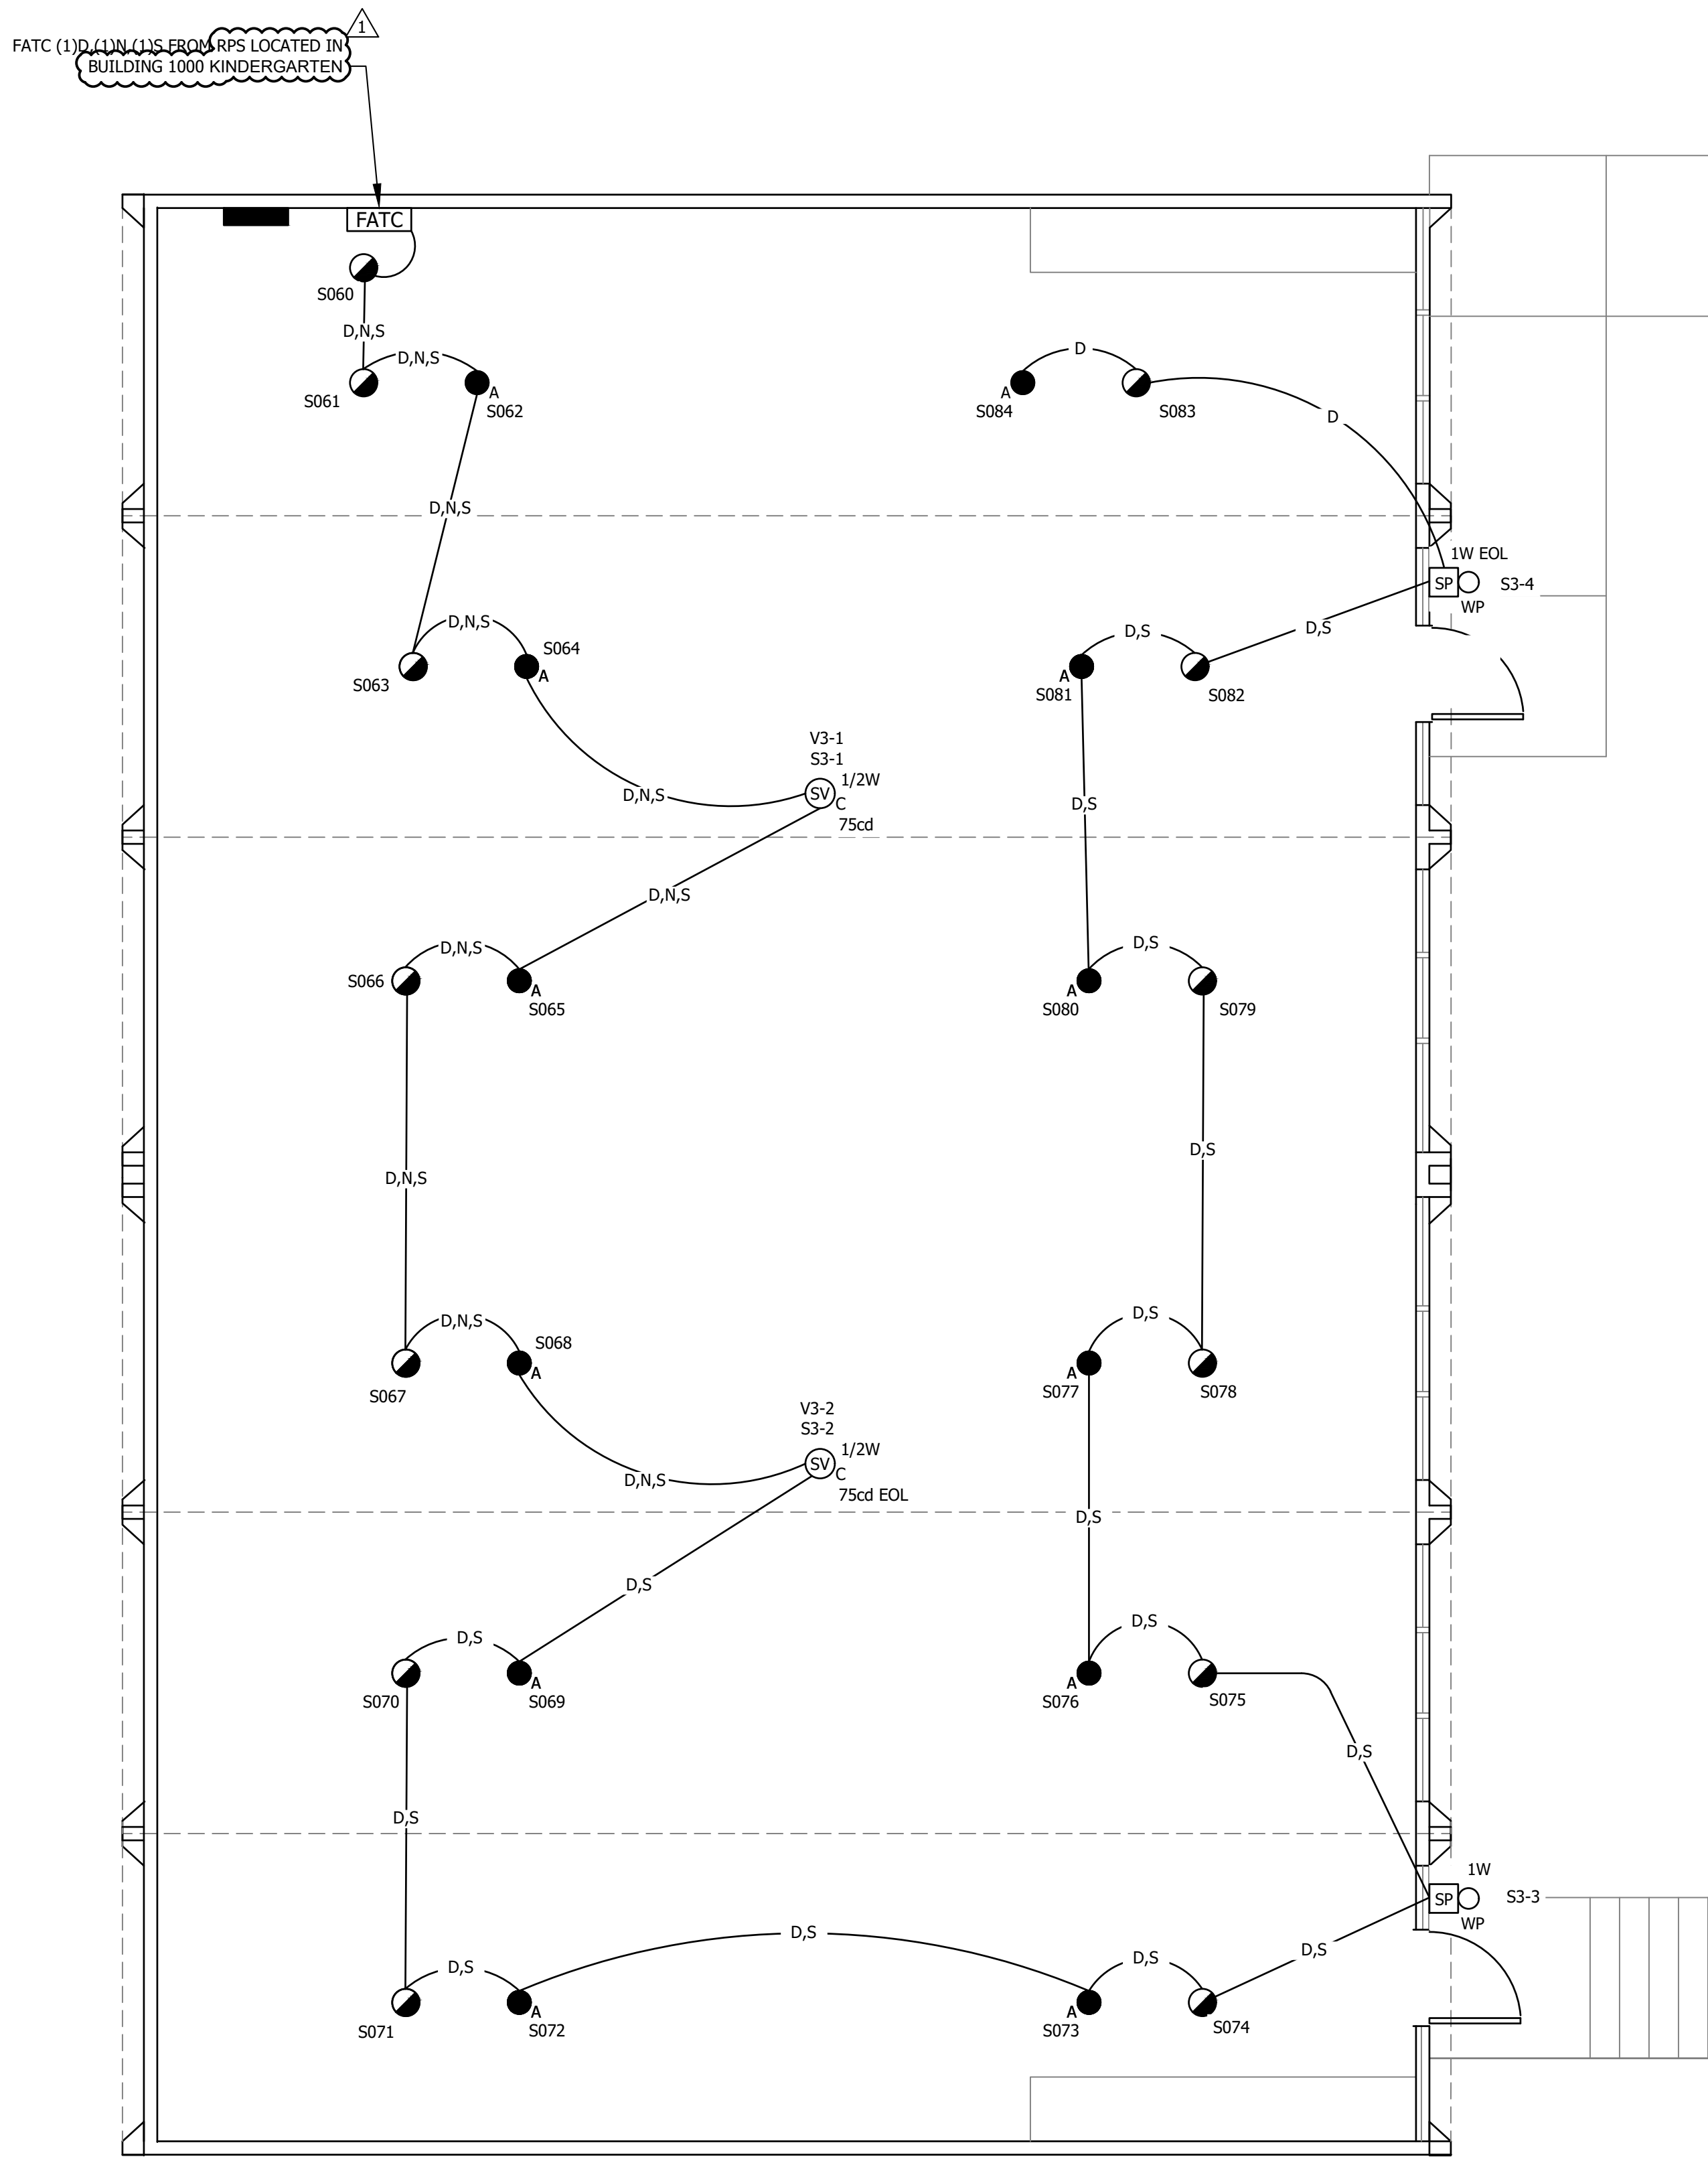

PROVIDE ONLY ONE CO DETECTOR (SILENT KNIGHT IDF-FIRE-CO-W) IN EACH CLASSROOM, THE REMAINING DETECTORS SHALL BE SILENT KNIGHT IDF-PHOTO-W (PHOTO IONIZATION (TYPICAL))

SHEET NOTES:

1. FIELD VERIFY LOCATION OF ALL DEVICES.
2. 3/4" CONDUIT MINIMUM UNLESS OTHERWISE NOTED.
3. CONTRACTOR SHALL FURNISH AND INSTALL PULL BOXES AS REQUIRED TO INSTALL CABLING PER CABLE MANUFACTURERS RECOMMENDATIONS.
4. UNIQUELY LABEL BOTH ENDS OF ALL CABLING.

LUCI & ASSOCIATES, INC.
CONSULTING ELECTRICAL ENGINEERS

3251 CORTE MALPASO, #511
CAMARILLO, CA 93012-8094
(805) 389-6520 FAX (805) 389-6519

LUCI & ASSOCIATES, INC. reserve their commonlaw copyright and other property rights in these plans. These plans and drawings are not to be reproduced, changed, or copied in any form or manner whatsoever without first obtaining the expressed written permission and consent of LUCI & ASSOC. INC. nor are they to be assigned to any third party without obtaining said written permission and consent.

STAMP



SHEET TITLE:

LIBRARY BUILDING 800
FIRE ALARM PLAN - NEW WORK


BUILDING DATA:

BUILDING CLASSIFICATION:

- A. OCCUPANCY TYPE: E
B. CONSTRUCTION TYPE: V-N
C. SPRINKLERED: NOT ONE STORY

AGENCIES:

A. DIVISION OF THE STATE ARCHITECT

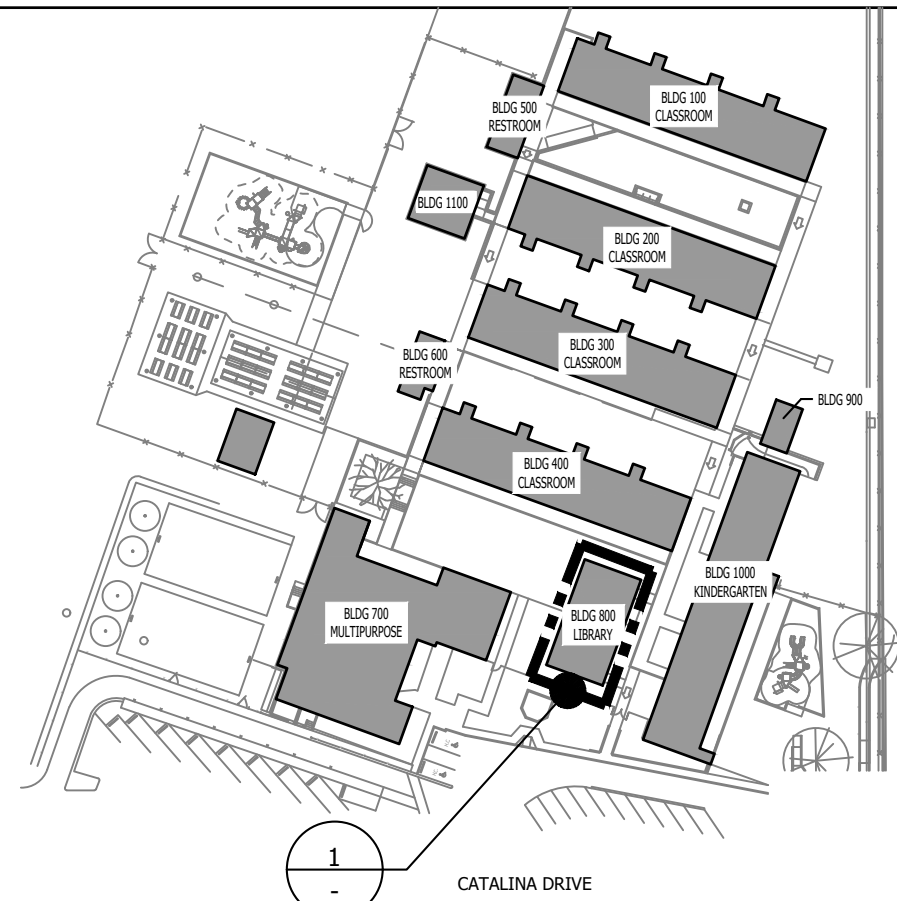

KEY MAP

REV	DATE	REVISIONS
1	3-3-2025	CCD-01



CHECKED: K. LUCI	DRAWN: LK/DS
JOB NO. 19753-01	SCALE: AS NOTED
	DATE: 01-18-2024

SHEET:

E680



OF: SHEETS:

 PATHNAME: G:\19\753\EL\Sheets\01-Camarillo Heights ES\19753-01-E690.dwg
DRAWING FILENAME: 19753-01-E690
DRAFTER: CM02
DATE: 3 March 2025
TIME: 3:35 pm
PLOT DATE: 3/3/2025 3:35:05 PM
PLOT BY: CM02
SAVE DATE: 3/3/2025 2:34:50 PM

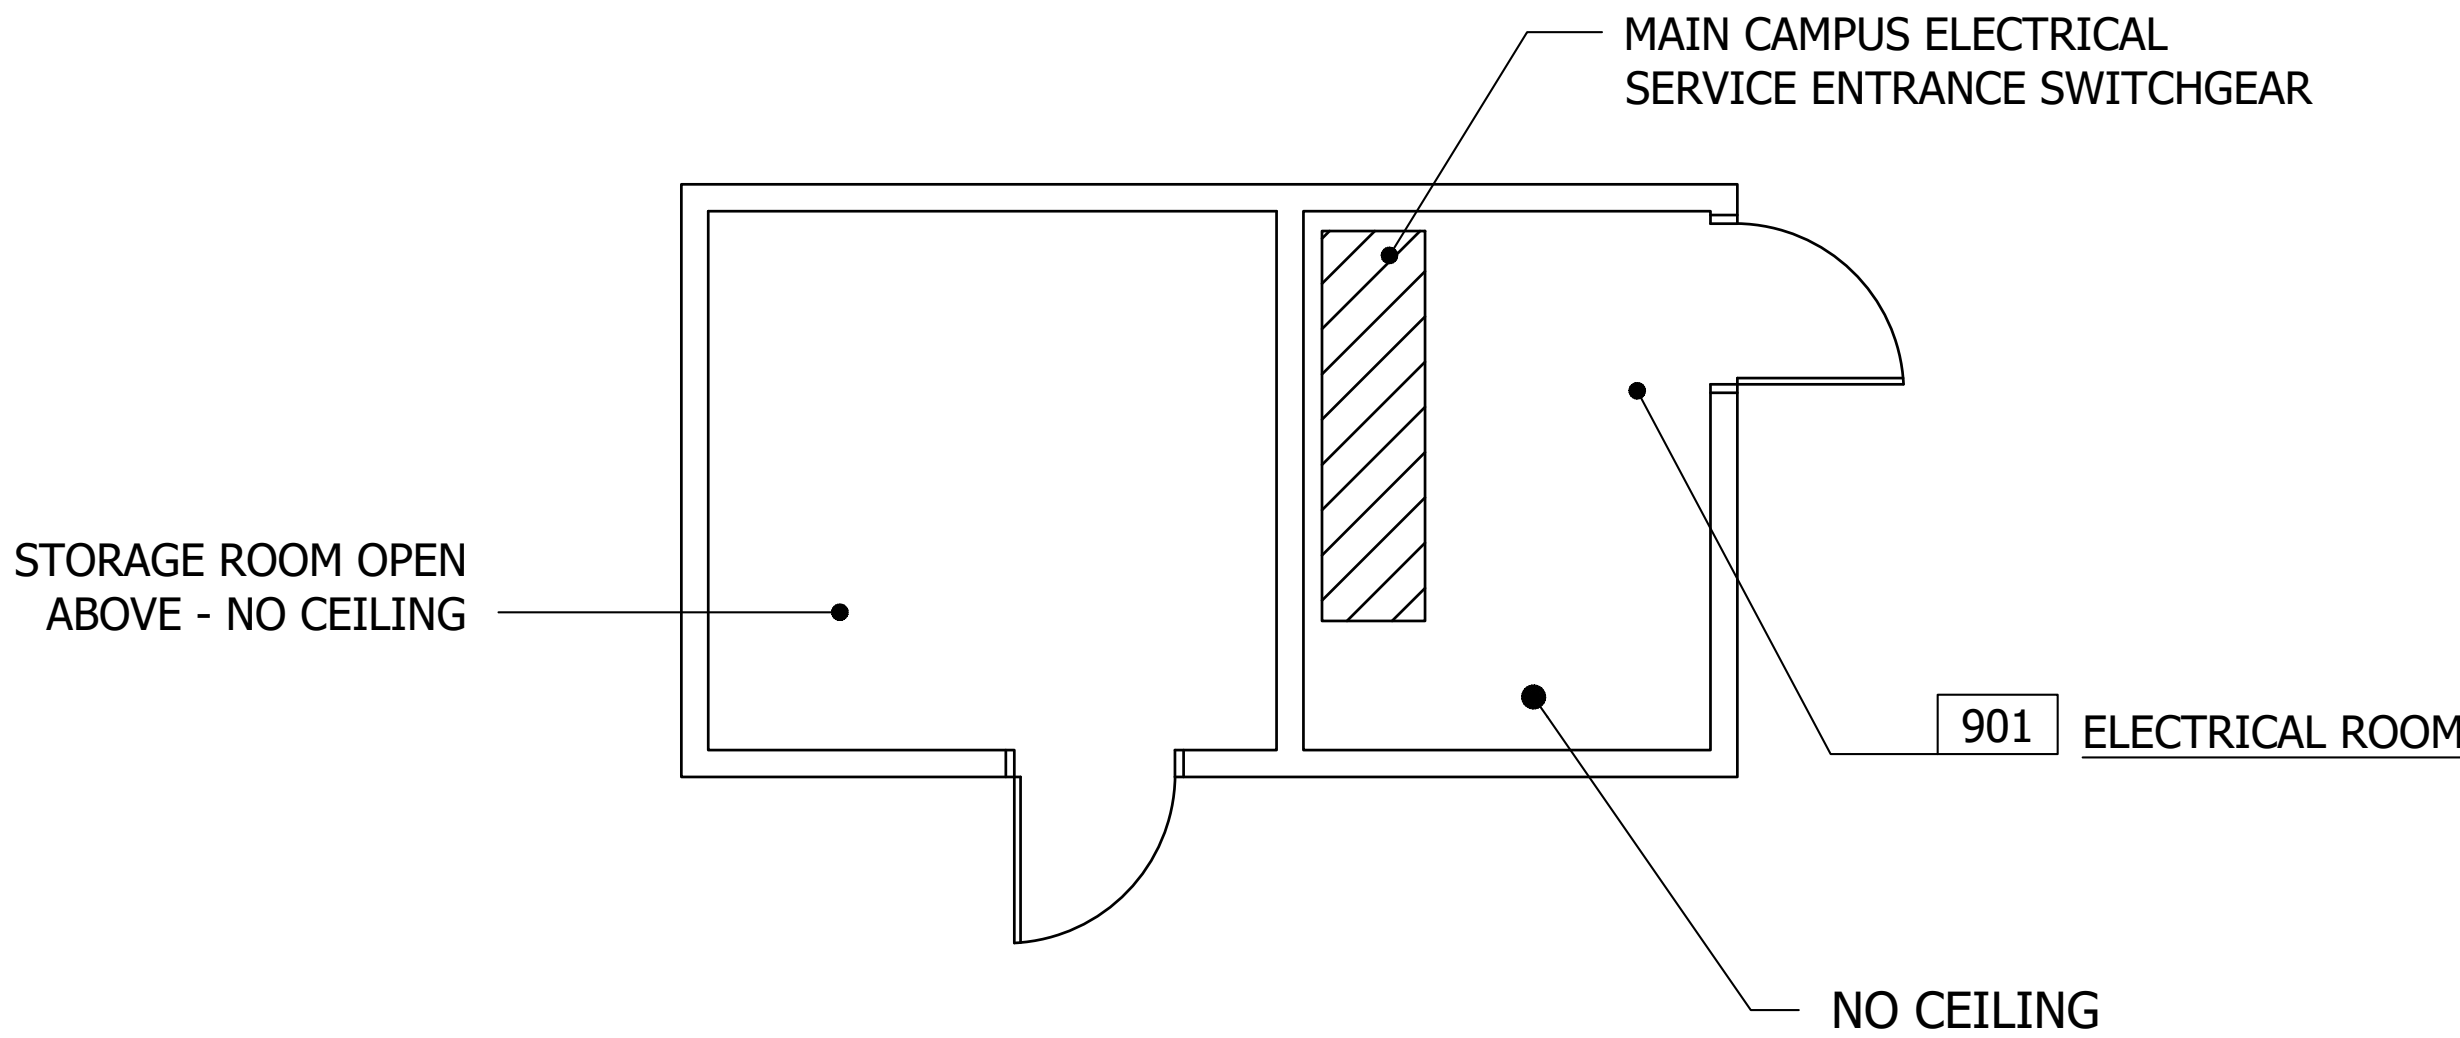

BUILDING 900 ELECTRICAL & STORAGE - NO FIRE ALARM PLAN
SCALE: 1/4"=1'-0"

1
- E690

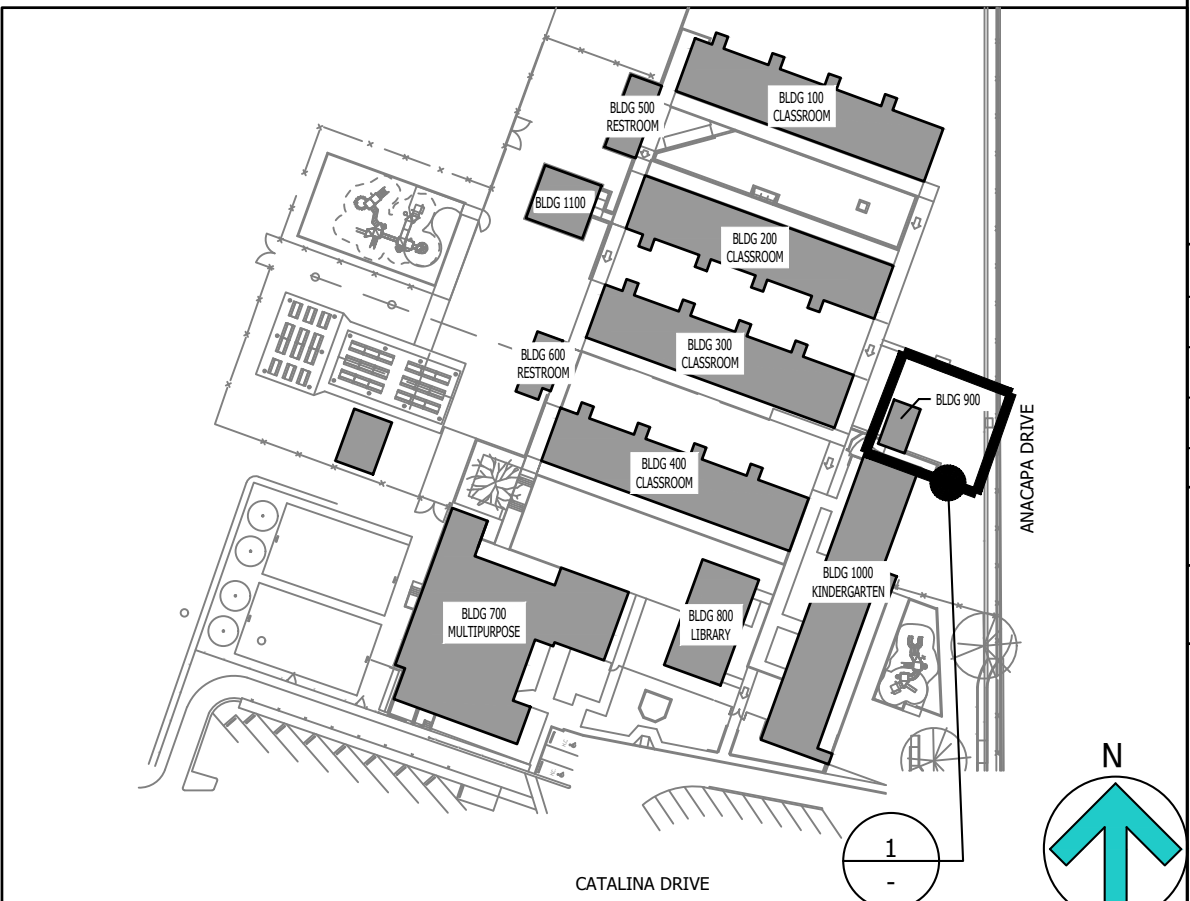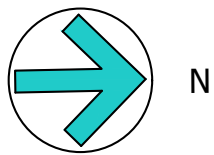

KEY MAP

PROVIDE ONLY ONE CO DETECTOR (SILENT KNIGHT IDF-FIRE-CO-W) IN EACH CLASSROOM, THE REMAINING DETECTORS SHALL BE SIELENT KNIGHT IDF-PHOTO-W (PHOTO IONIZATION (TYPICAL)

LUCCI & ASSOCIATES INC.
CONSULTING ELECTRICAL ENGINEERS
3251 CORTE MALPASO, #511
CAMARILLO, CA 93012-8094
(805) 389-6520 FAX (805) 389-6519
LUCCI & ASSOCIATES, INC. reserve their commonlaw copyright and other property rights in these plans. These plans and drawings are not to be reproduced, changed, or copied in any form or manner whatsoever without first obtaining the expressed written permission and consent of LUCCI & ASSOC. INC nor are they to be assigned to any third party without obtaining said written permission and consent.

STAMP



SHEET TITLE:

**BUILDING 900 ELECTRICAL & STORAGE
- NO FIRE ALARM PLAN**

PROJECT:
**CAMARILLO HEIGHTS
ELEMENTARY SCHOOL
35 CATALINA DRIVE
CAMARILLO, CA 93010
CAMPUS FIRE ALARM UPGRADE**

REV	DATE	REVISIONS
1		
CHECKED: K. LUCCI		DRAWN: LK/DS
JOB NO. 19753-01	SCALE: AS NOTED	DATE: 01-18-2024

SHEET:

E690

OF: SHEETS:

BUILDING DATA:	
BUILDING <u>CLASSIFICATION:</u>	A. OCCUPANCY TYPE: E B. CONSTRUCTION TYPE: V-N C. SPRINKLERED: NOT ONE STORY
<u>AGENCIES:</u>	A. DIVISION OF THE STATE ARCHITECT

PROVIDE ONLY ONE CO DETECTOR (SILENT KNIGHT
IDF-FIRE-CO-W) IN EACH CLASSROOM, THE REMAINING
DETECTORS SHALL BE SILENT KNIGHT IDF-PHOTO-W
(PHOTO IONIZATION (TYPICAL))

[illegible]

- SHEET NOTES:**
1. FIELD VERIFY LOCATION OF ALL DEVICES.
 2. 3/4" CONDUIT MINIMUM UNLESS OTHERWISE NOTED.
 3. CONTRACTOR SHALL FURNISH AND INSTALL PULL BOXES AS REQUIRED TO INSTALL CABLING PER CABLE MANUFACTURERS RECOMMENDATIONS.
 4. UNIQUELY LABEL BOTH ENDS OF ALL CABLING.

- KEY NOTES:**
- 1 RED DEDICATED LOCK ON 20A, 1P CIRCUIT BREAKER LABELED "FIRE ALARM".

CONTRACTOR TO PROVIDE ACCESS PANELS
FOR ALL HEAT DETECTORS ABOVE CEILING

LUCCI & ASSOCIATES INC.
CONSULTING ELECTRICAL ENGINEERS

3251 CORTE MALPASO, #511
CAMARILLO, CA 93012-8094
(805) 389-6520 FAX (805) 389-6519

LUCCI & ASSOCIATES, INC. reserve their commonlaw copyright and other property rights in these plans. These plans and drawings are not to be reproduced, changed, or copied in any form or manner whatsoever without first obtaining the expressed written permission and consent of LUCCI & ASSOC. INC nor are they to be assigned to any third party without obtaining said written permission and consent.



HEET TITLE:



KINDERGARTEN BUILDING
1000 FIRE ALARM PLAN
- NEW WORK

PROJECT:
CAMARILLO HEIGHTS
ELEMENTARY SCHOOL
35 CATALINA DRIVE
CAMARILLO, CA 93010
CAMPUS FIRE ALARM UPGRADE

REV	DATE	REVISIONS	
1			
CHECKED:		DRAWN:	
K. LUCCI		LK/DS	
JOB NO.		SCALE:	DATE:
19753-01		AS NOTED	01-18-2024
SHEET:			

E691


OF: SHEETS:

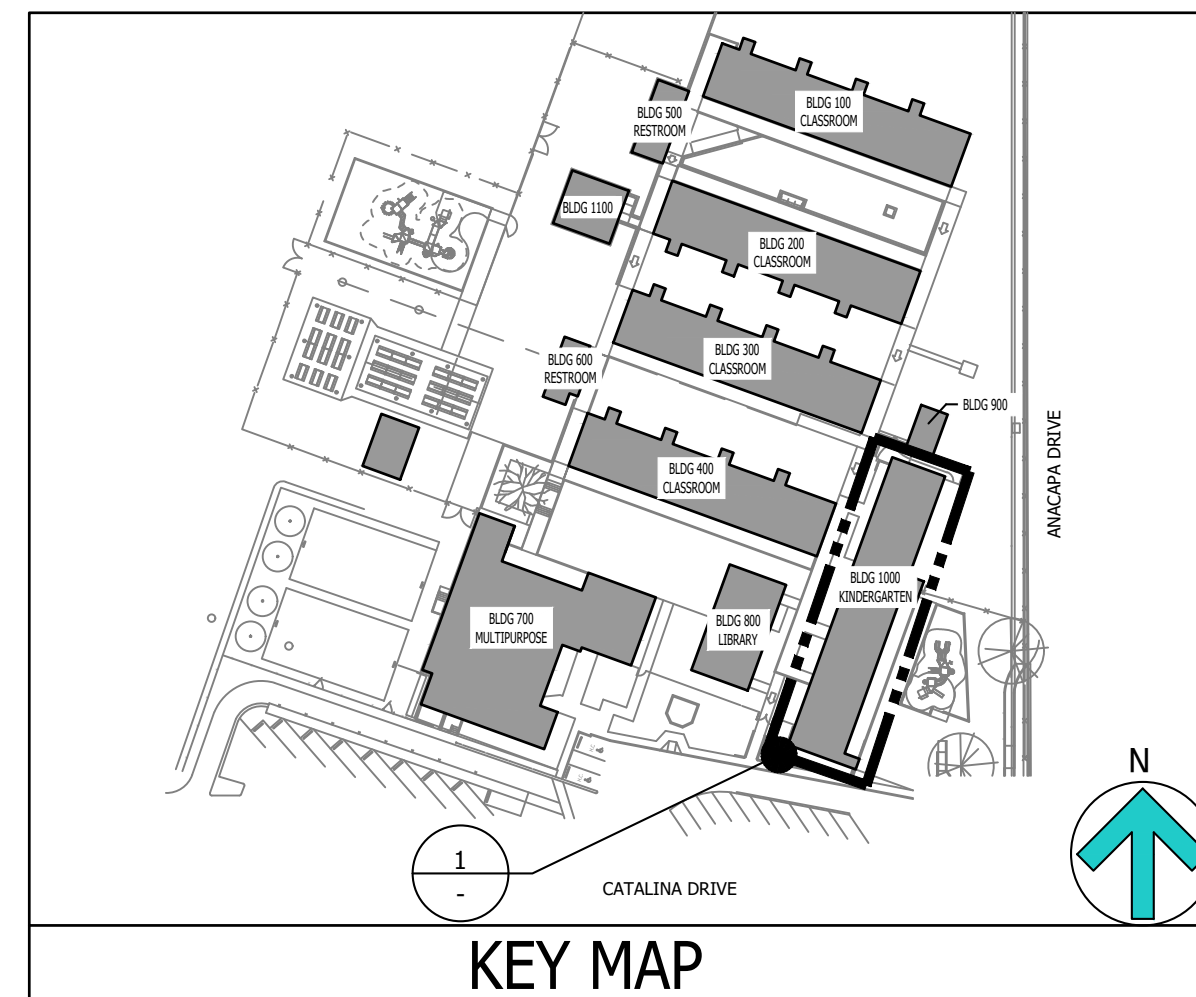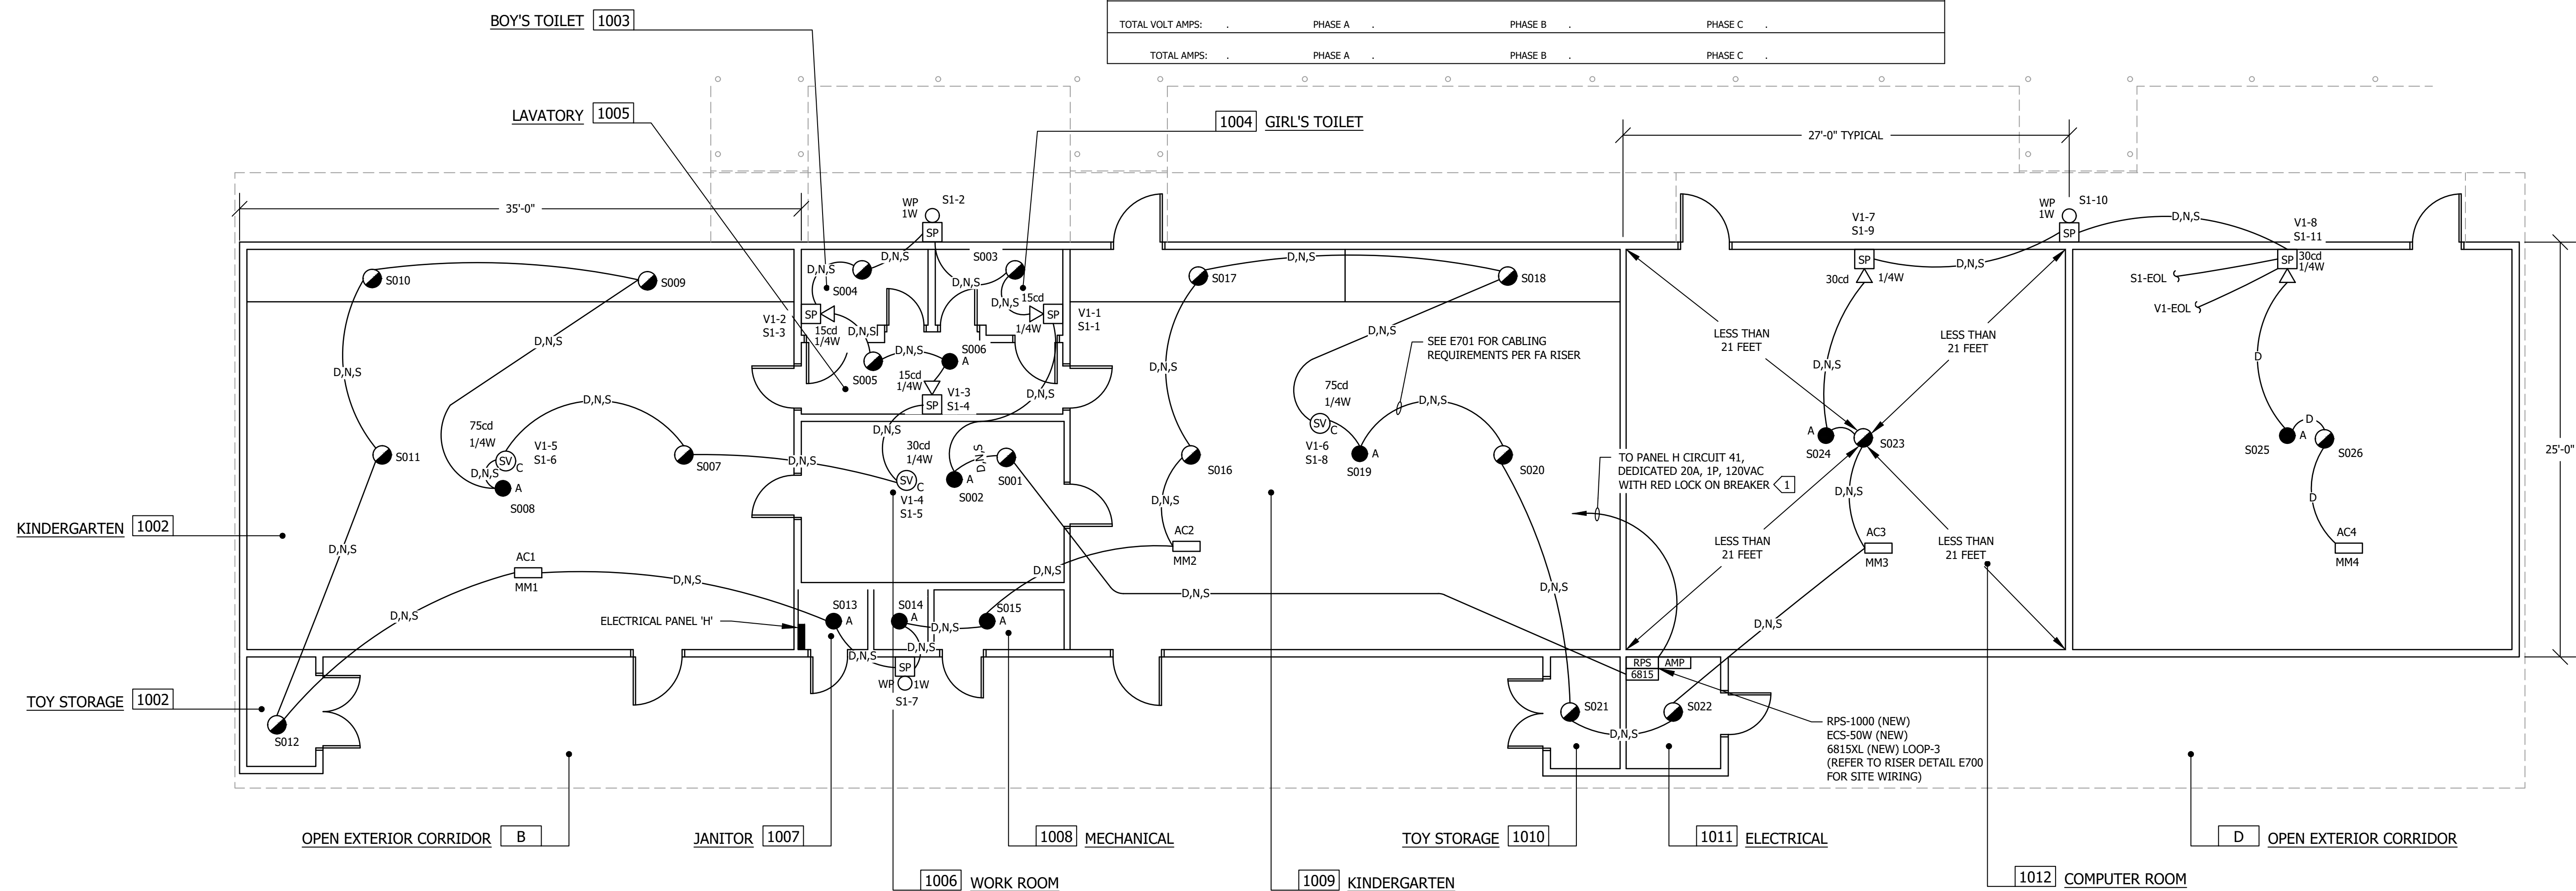

KINDERGARTEN BUILDING 1000 FIRE ALARM PLAN - NEW WORK

1
- E691
-

 
Copyright Lucci and Associates Consulting Electrical Engineers. Deviations from this drawing will not be made without their expressed written permission. L.A.I.# 19753-01 PAPER SIZE 36"x24"



SCALE: 1/4"=1'-0"

MODULAR CLASSROOM

-	E692
---	------

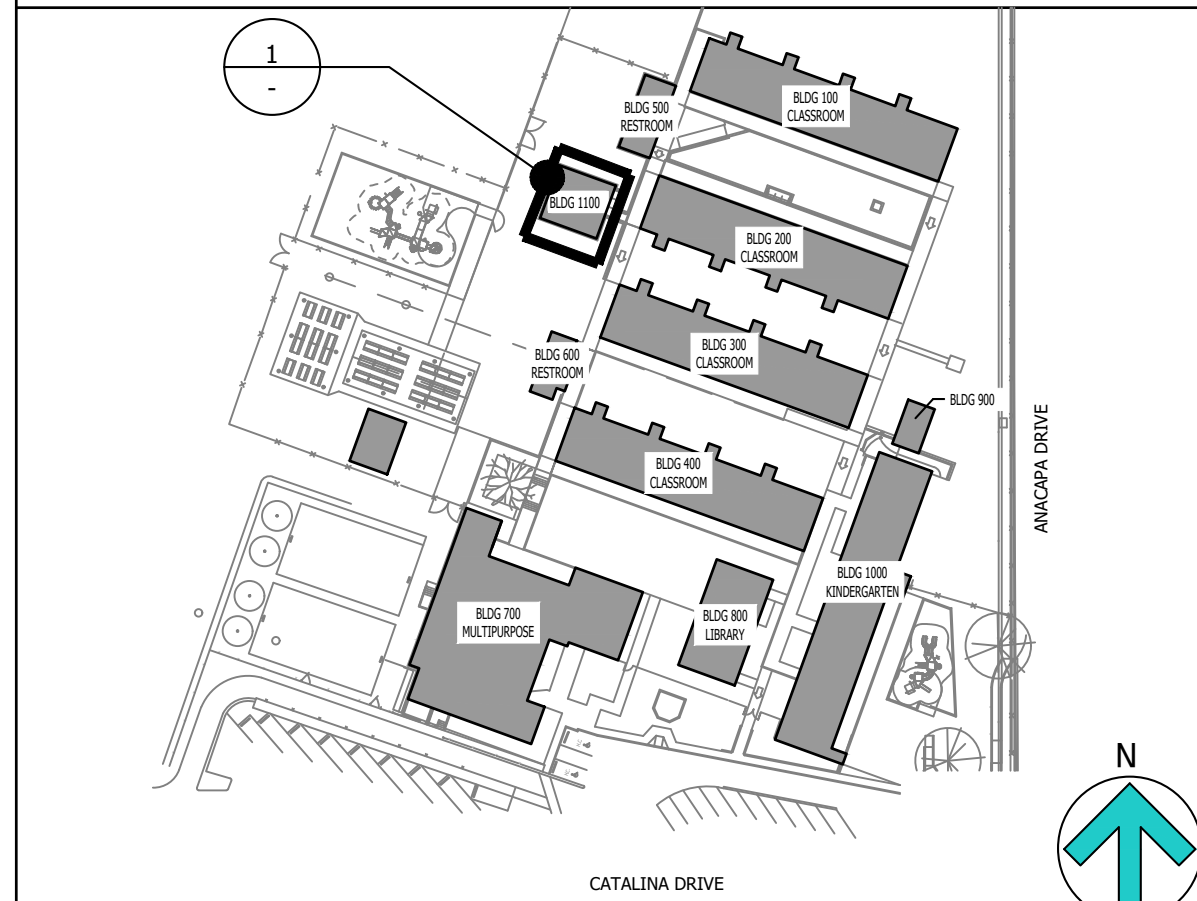

1. FIELD VERIFY LOCATION OF ALL DEVICES.
2. 3/4" CONDUIT MINIMUM UNLESS OTHERWISE NOTED.
3. CONTRACTOR SHALL FURNISH AND INSTALL PULL BOXES AS REQUIRED TO INSTALL CABLING PER CABLE MANUFACTURERS RECOMMENDATIONS.
4. UNIQUELY LABEL BOTH ENDS OF ALL CABLING.

3251 CORTE MALPASO, #511
CAMARILLO, CA 93012-8094
(805) 389-6520 FAX (805) 389-6519

LUCCI & ASSOCIATES, INC. reserve their commonlaw copyright and other property rights in these plans. These plans and drawings are not to be reproduced, changed, or copied in any form or manner whatsoever without first obtaining the expressed written permission and consent of LUCCI & ASSOC. INC nor are they to be assigned to any third party without obtaining said written permission and consent.

STAMP



SHEET TITLE:

BUILDING 1100 FIRE ALARM PLAN
- NEW WORK

PROJ


CAMARILLO HEIGHTS
ELEMENTARY SCHOOL
35 CATALINA DRIVE
CAMARILLO, CA 93010
CAMPUS FIRE ALARM U

REV	DATE	REVISIONS	
1			
CHECKED: K. LUCCI		DRAWN: LK/DS	
JOB NO. 19753-01		SCALE: AS NOTED	DATE: 01-18-2024


SHEET:

E692

 OF: SHEETS:



1
- E693
- 

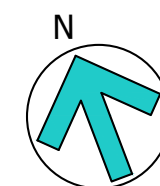

1. FIELD VERIFY LOCATION OF ALL DEVICES.
2. 3/4" CONDUIT MINIMUM UNLESS OTHERWISE NOTED.
3. CONTRACTOR SHALL FURNISH AND INSTALL PULL BOXES AS REQUIRED TO INSTALL CABLING PER CABLE MANUFACTURERS RECOMMENDATIONS.
4. UNIQUELY LABEL BOTH ENDS OF ALL CABLING.


- 1 EXISTING 1/2" - 2#12, 1#12 GROUND THWN COPPER TO RED LOCK ON 20A-1P CIRCUIT BREAKER PANEL A-21.
- 2 NOT USED.
- 3 SEE THE FIRE ALARM RISER DIAGRAM FOR WIRING INFORMATION (TYPICAL FOR EACH PORTION OF CIRCUIT).
- 4 +MULTI CRITERIA DETECTOR ON UNDERSIDE OF LAY-IN.
- 5 HEAT DETECTOR ABOVE LAY-IN CEILING IN ATTIC PLENUM SPACE.
- 6 +MULTI CRITERIA DETECTOR ON CEILING NEAR PANEL "FACP" (36" HORIZONTALLY).
- 7 EXISTING 4" SQUARE DEEP FLUSH BACK BOX FOR SPEAKER AND/OR SPEAKER/STROBE (WP WHEN OUTDOOR).

RED WITH LOCK ON DEVICE-

LOCK ON DEVICE
LOCK ON DEVICE
LOCK ON DEVICE

THIS BUILDING IS PRESENTLY IN
CONSTRUCTION UNDER DSA #03-122807
AND IS NOT A PORTION OF THE PERMIT.

BUILDING CLASSIFICATION:	A. OCCUPANCY TYPE: E B. CONSTRUCTION TYPE: V-N C. SPRINKLERED: NOT ONE STORY
AGENCIES:	A. DIVISION OF THE STATE ARCHITECT

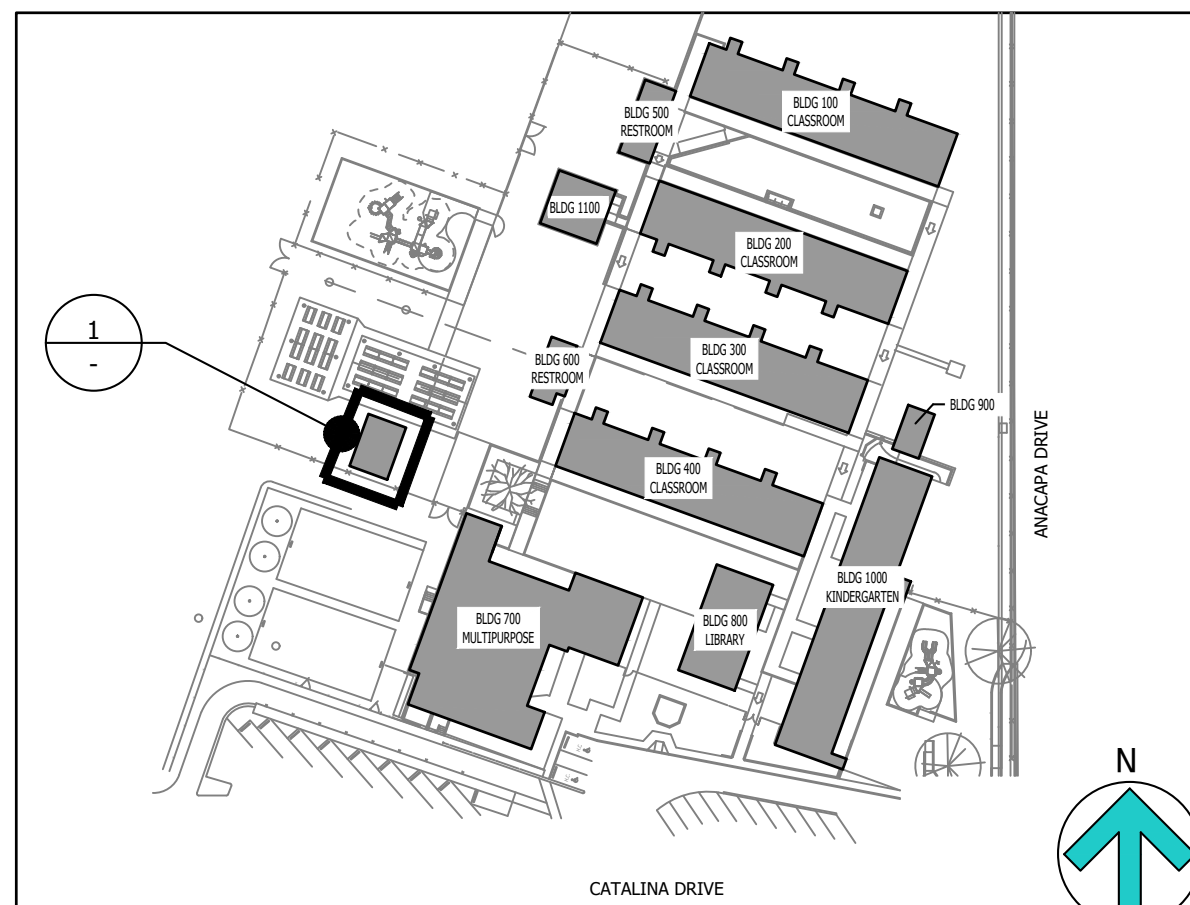

KEY MAP

STAMP



SHEET TITLE:

BUILDING 1200 KITCHEN
FIRE ALARM PLAN -
EXISTING (IN CONSTRUCTION)

PROJECT:



CAMARILLO HEIGHTS
ELEMENTARY SCHOOL
35 CATALINA DRIVE
CAMARILLO, CA 93010
CAMPUS FIRE ALARM U

REV	DATE	REVISIONS	
△			
CHECKED: K. LUCCI		DRAWN: LK/DS	
JOB NO. 19753-01		SCALE: AS NOTED	DATE: 01-18-2021
SHEET:			

E693

OF: SHEETS:

TIME: 3:35 pm
DATE: 3 March 2025
PLOT DATE: 3/3/2025 3:35:23 PM
PATHNAME: G:\19\753\EL\Sheets\01-Camarillo Heights ES
DRAWING FILENAME: 19753-01-E700
DRAFTER: CM02
DATE: 3/3/2025 2:28:15 PM
PLOT BY: CM02
DRAWING: G:\19\753\EL\Sheets\01-Camarillo Heights ES\19753-01-E700.dwg
DRAFT: G:\19\753\EL\Sheets\01-Camarillo Heights ES\19753-01-E700.dwg
DATE: 3/3/2025 2:28:15 PM
PLOT BY: CM02
DRAWING: G:\19\753\EL\Sheets\01-Camarillo Heights ES\19753-01-E700.dwg
DRAFT: G:\19\753\EL\Sheets\01-Camarillo Heights ES\19753-01-E700.dwg

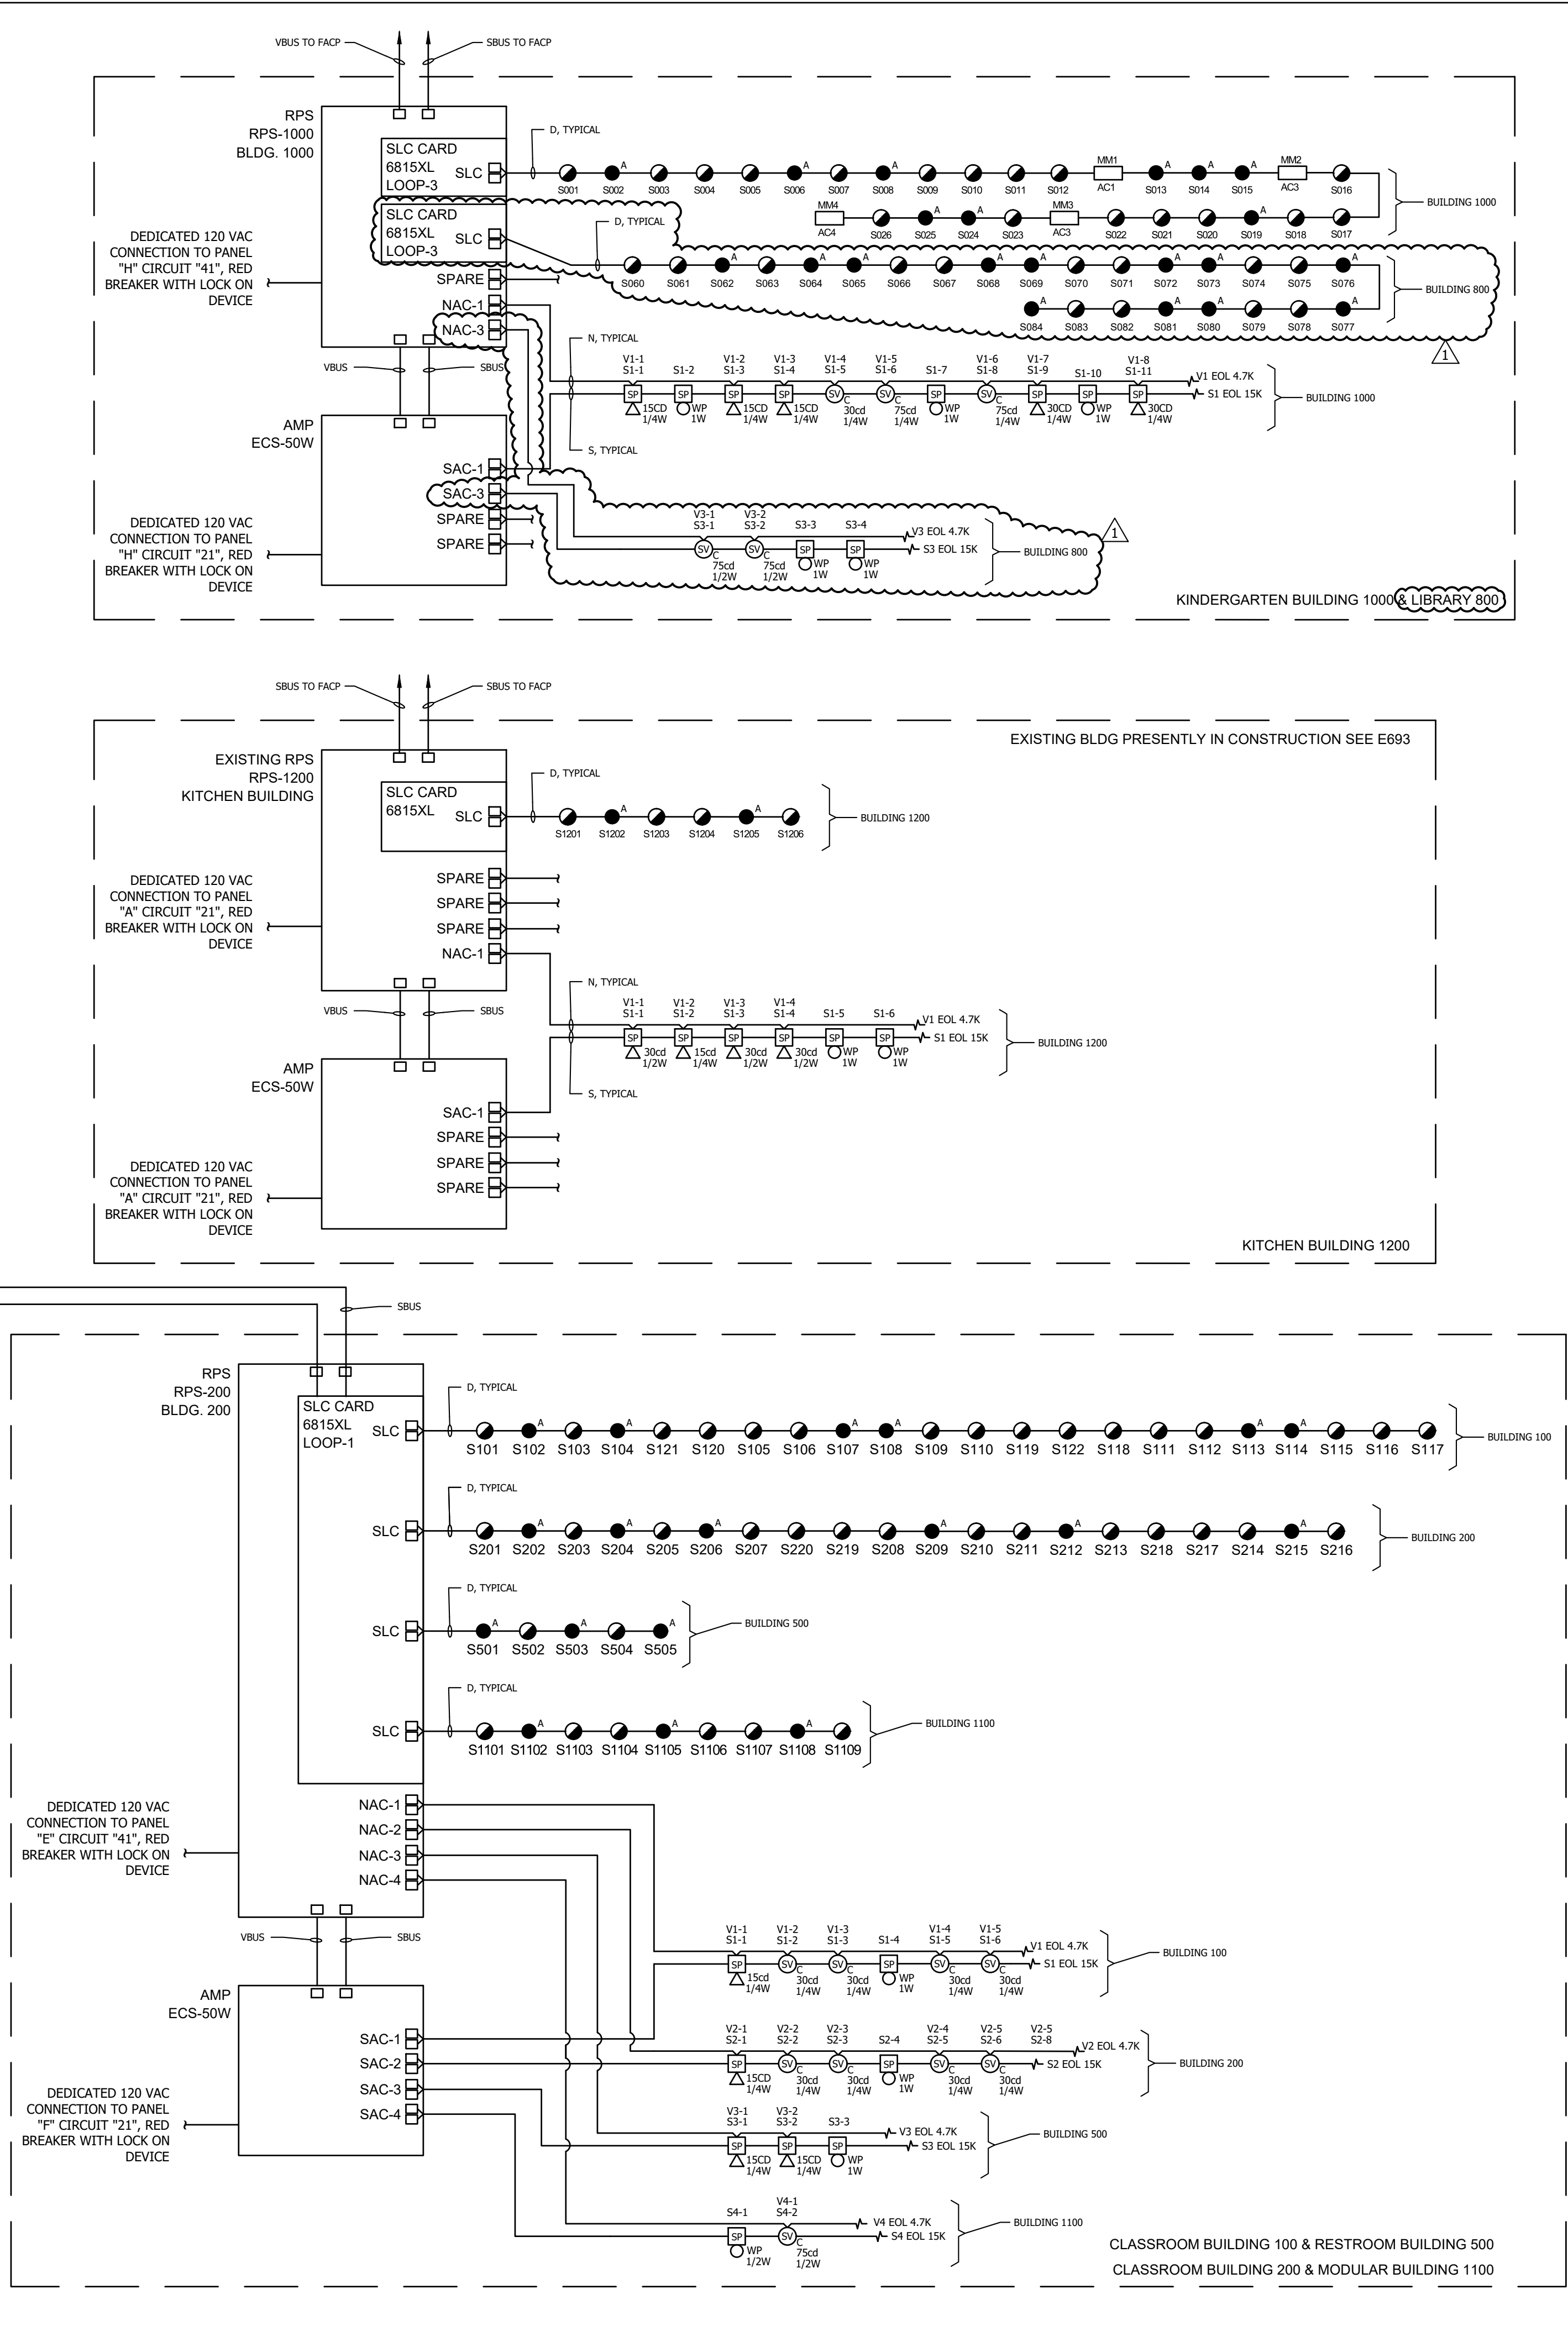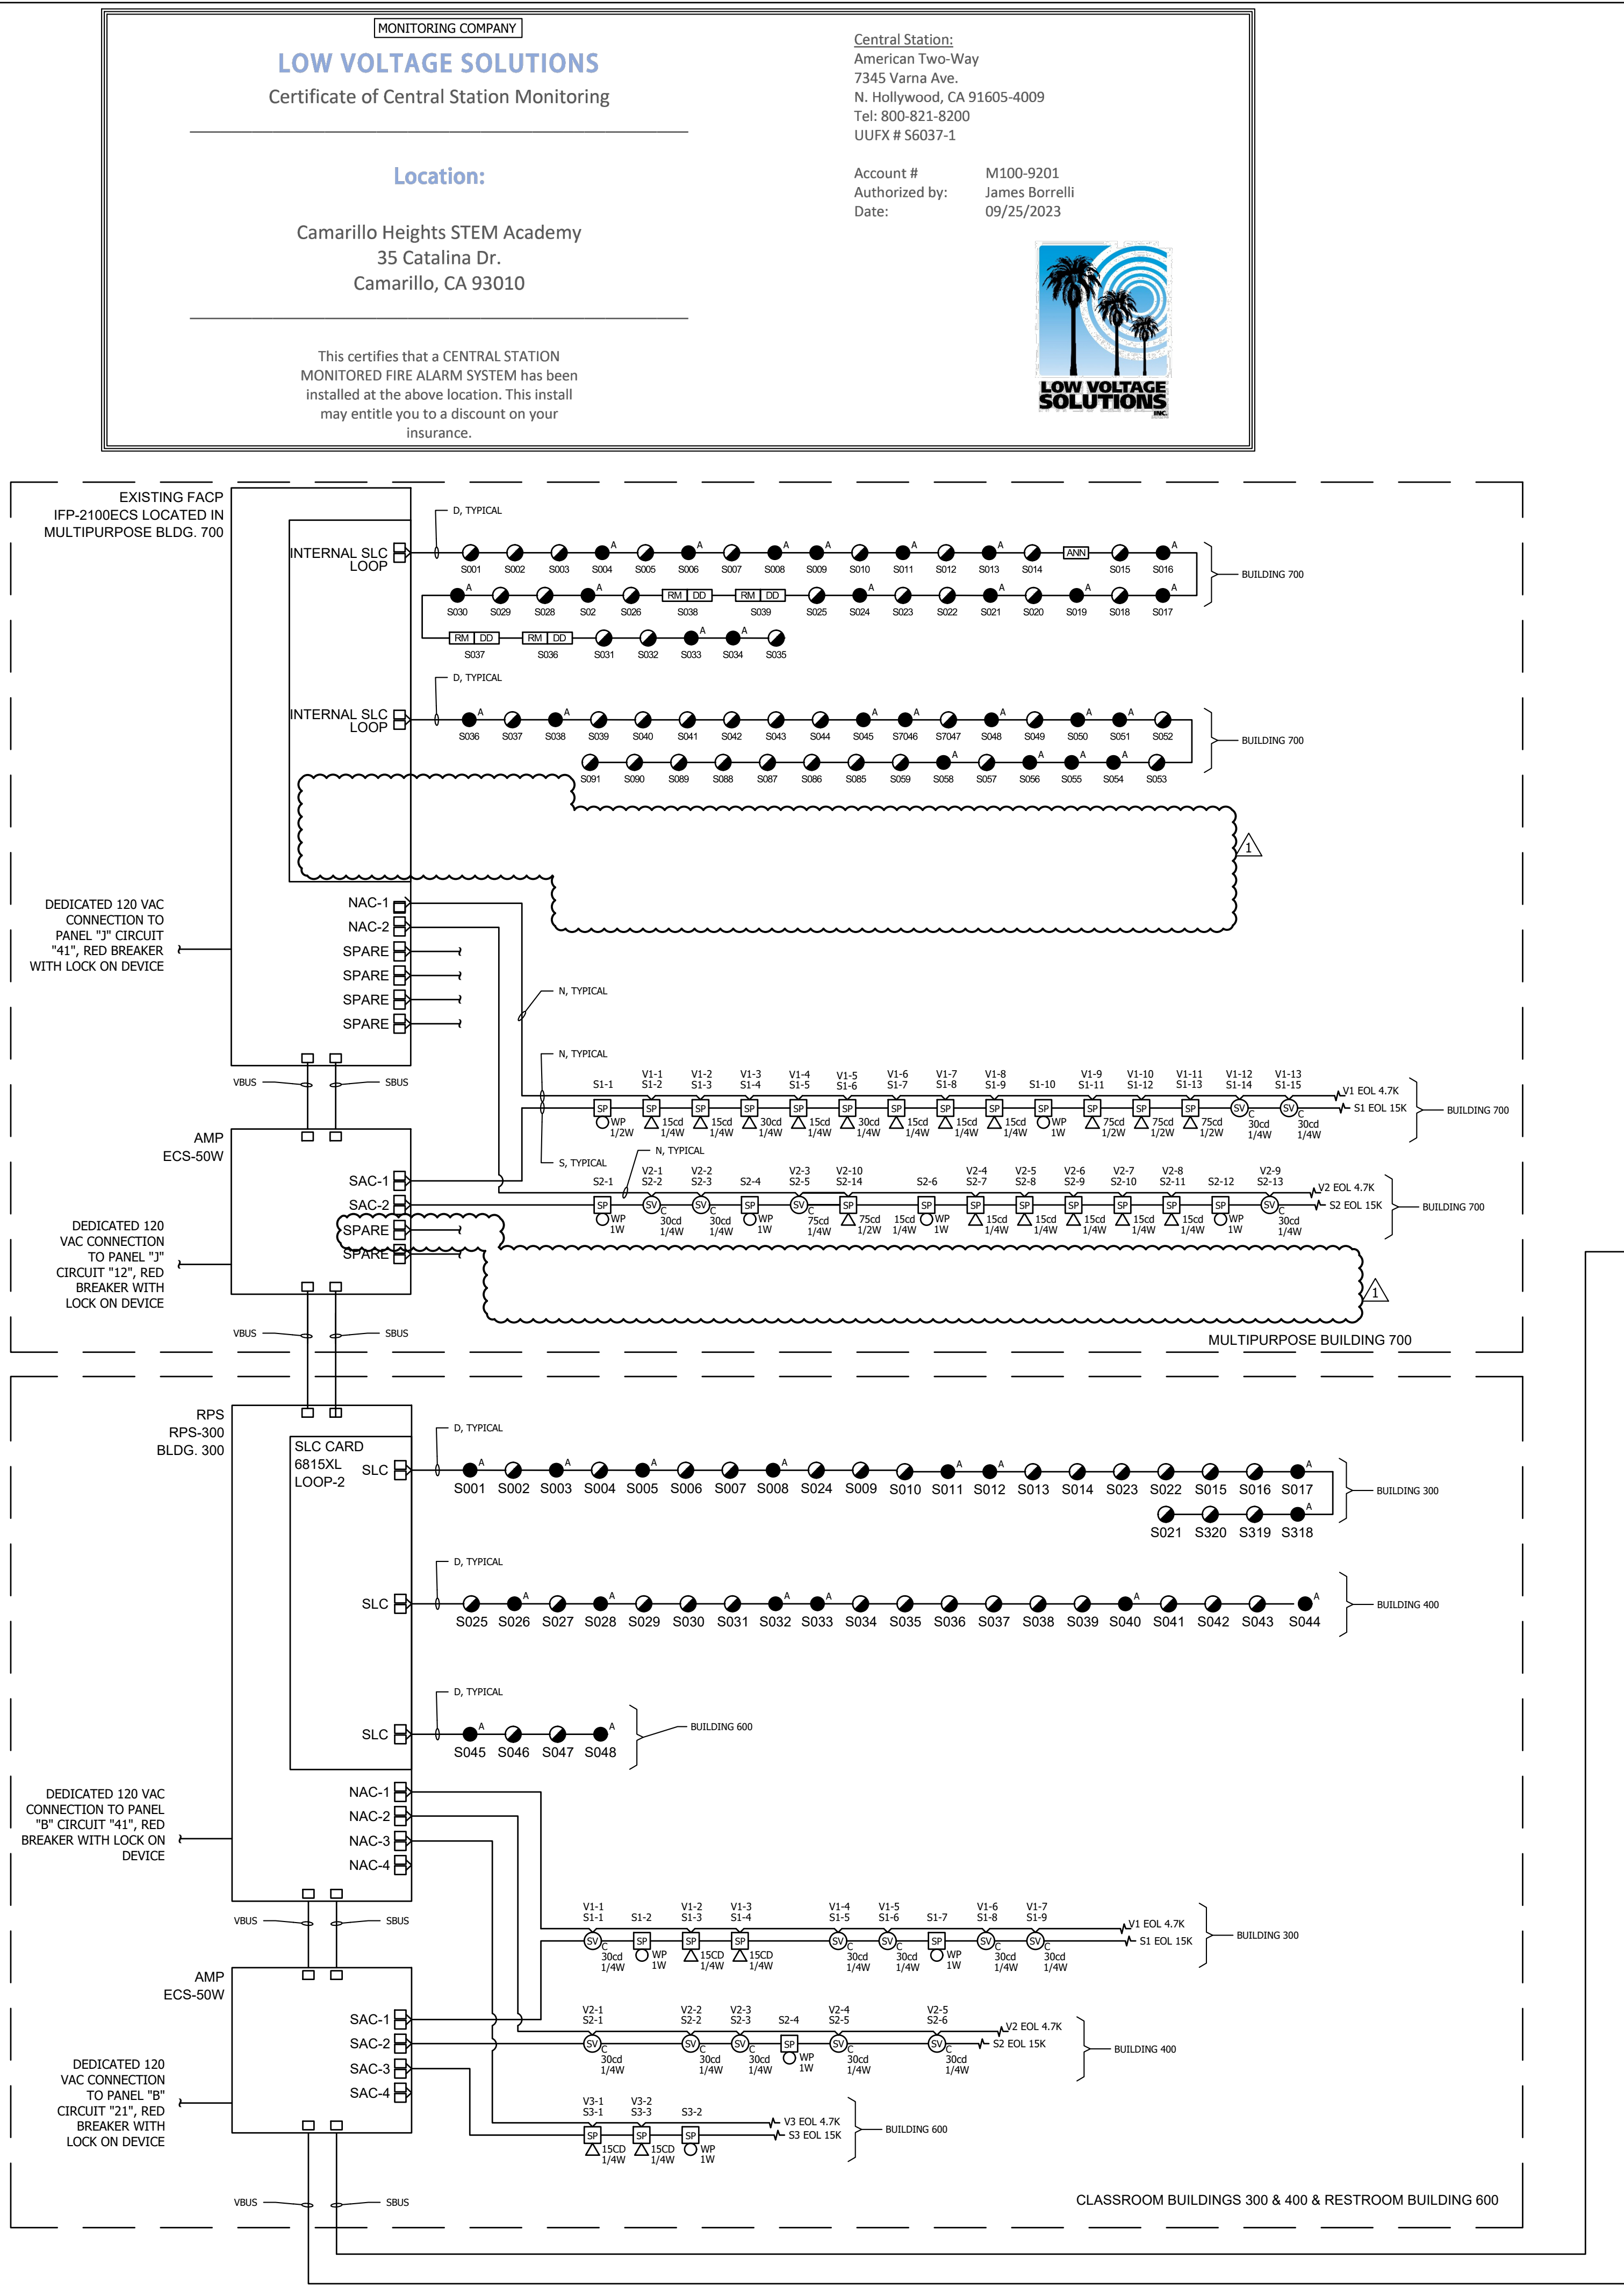

LUCCI & ASSOCIATES INC.
CONSULTING ELECTRICAL ENGINEERS

3251 CORTE MALPASO, #511
CAMARILLO, CA 93012-8094
(805) 389-6520 FAX (805) 389-6519

LUCCI & ASSOCIATES, INC. reserve their commonlaw copyright and other property rights in these plans. These plans and drawings are not to be reproduced, changed, or copied in any form or manner whatsoever without first obtaining the expressed written permission and consent of LUCCI & ASSOC. INC nor are they to be assigned to any third party without obtaining said written permission and consent.

STAMP

REGISTERED PROFESSIONAL ENGINEER
No. 78940
Exp. 09/30/2026
ELECTRICAL
STATE OF CALIFORNIA

SHEET TITLE:

FIRE RISER DIAGRAM

PROJECT:

**CAMARILLO HEIGHTS
ELEMENTARY SCHOOL
35 CATALINA DRIVE
CAMARILLO, CA 93010
CAMPUS FIRE ALARM UPGRADE**

REV	DATE	REVISIONS
1	3-3-2025	CCD-01

CHECKED:	DRAWN:
K. LUCCI	LK/DS

JOB NO.	SCALE:	DATE:
19753-01	AS NOTED	01-18-2024

SHEET:

E700

OF: SHEETS:

1
- E701
-

OF: SHEETS:

