



Optima Engineering is an instrument of service. The drawings and the information hereon are the property of Optima Engineering, P.A. and are to be used only for the project and purpose for which they were prepared. No part of these drawings may be reproduced or transmitted in any form or by any means electronic or mechanical, including photocopying, recording, or by any information storage or retrieval system, without the written consent of Optima Engineering, P.A. ANY REPRODUCTION, ALTERATION, OR USE FOR OTHER THAN THE INTENDED PURPOSE WITHOUT THE WRITTEN CONSENT OF OPTIMA ENGINEERING, P.A. IS EXPRESSLY FORBIDDEN. COPYRIGHT © 2013 OPTIMA ENGINEERING, P.A.

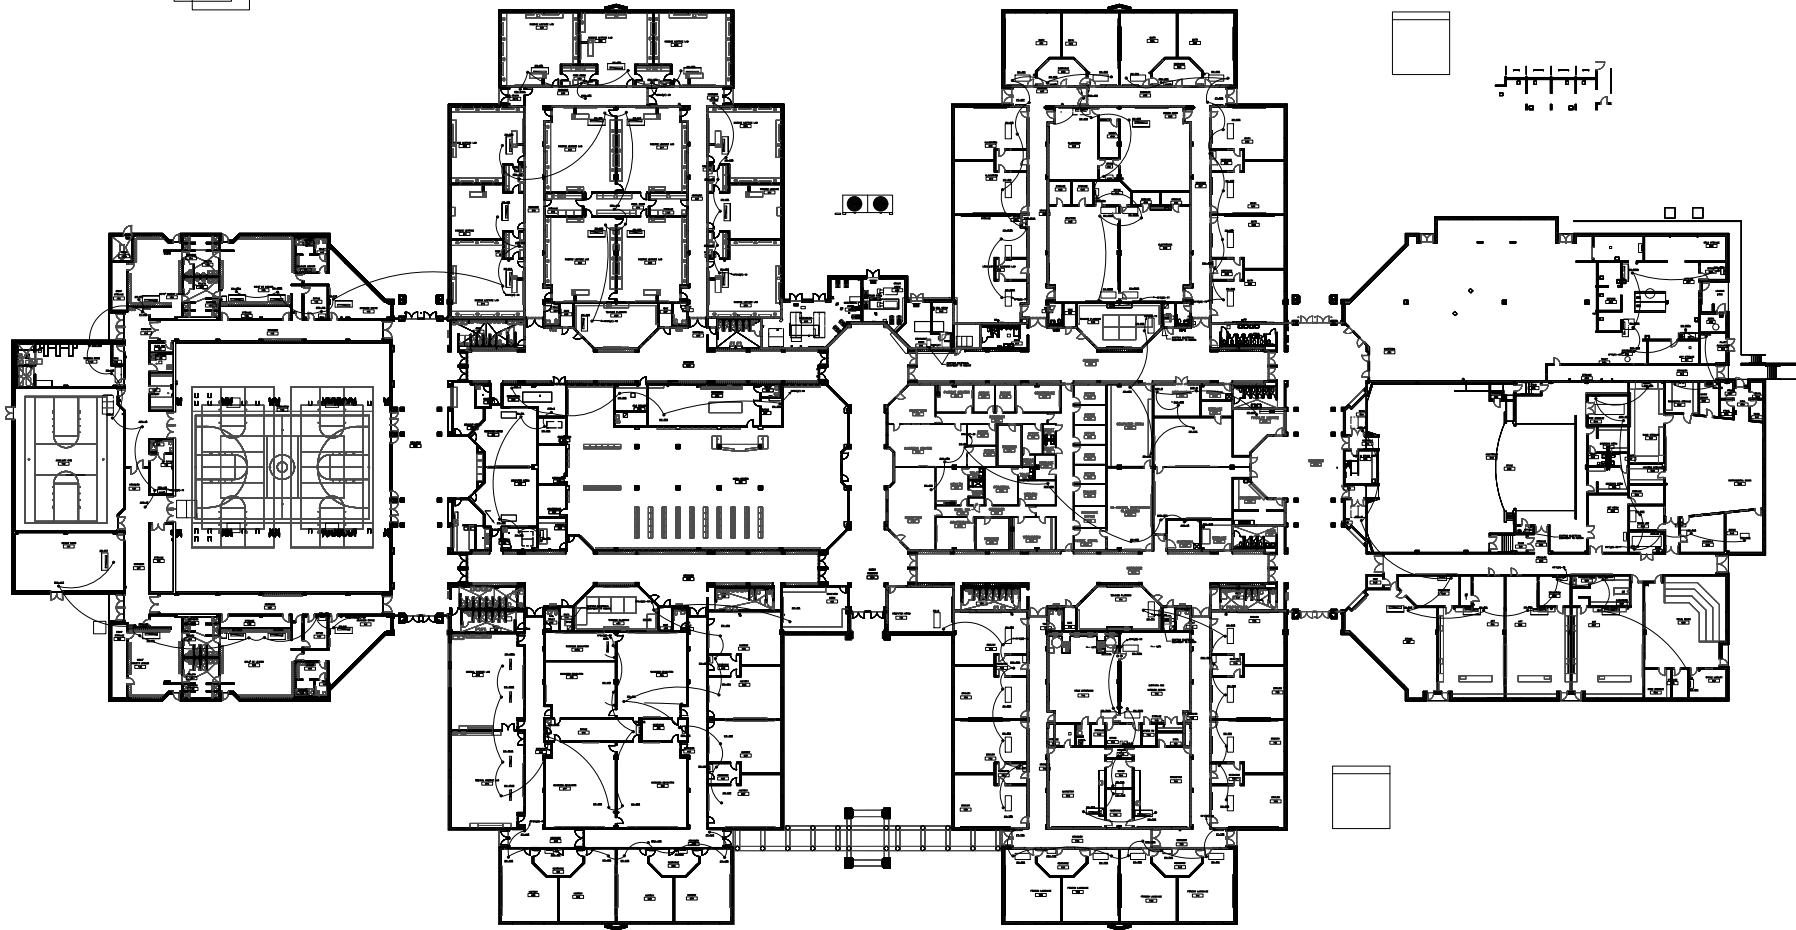

1 ELECTRICAL FLOOR PLAN - MAIN BUILDING OVERALL ELECTRICAL PLAN
1/8" = 1'-0"

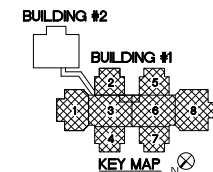

Optima Engineering
Mechanical • Electrical • Plumbing
Fire Protection • Lighting Design

1827 S. Iron St., Suite 200, Charlotte, NC 28203
704.366.1111
North Carolina License Number: C00147

SEAL:

Professional Engineer
David Butler
State of North Carolina
9/29/2022

butler high school
HVAC CONTROLS UPGRADE

761 david butler high school
1810 matthews-mint road
matthews, nc 28105


REV #	DATE	DESCRIPTION

DATE: 09-29-2022
PROJECT #: 22-0151
DRAWN BY: SMT
DESIGNED BY: SMT
CHECKED BY: MAM


SHEET TITLE:
MAIN BUILDING
ELECTRICAL
FLOOR PLAN

DWG #:
E200

SHEET NO.: 2 of 16

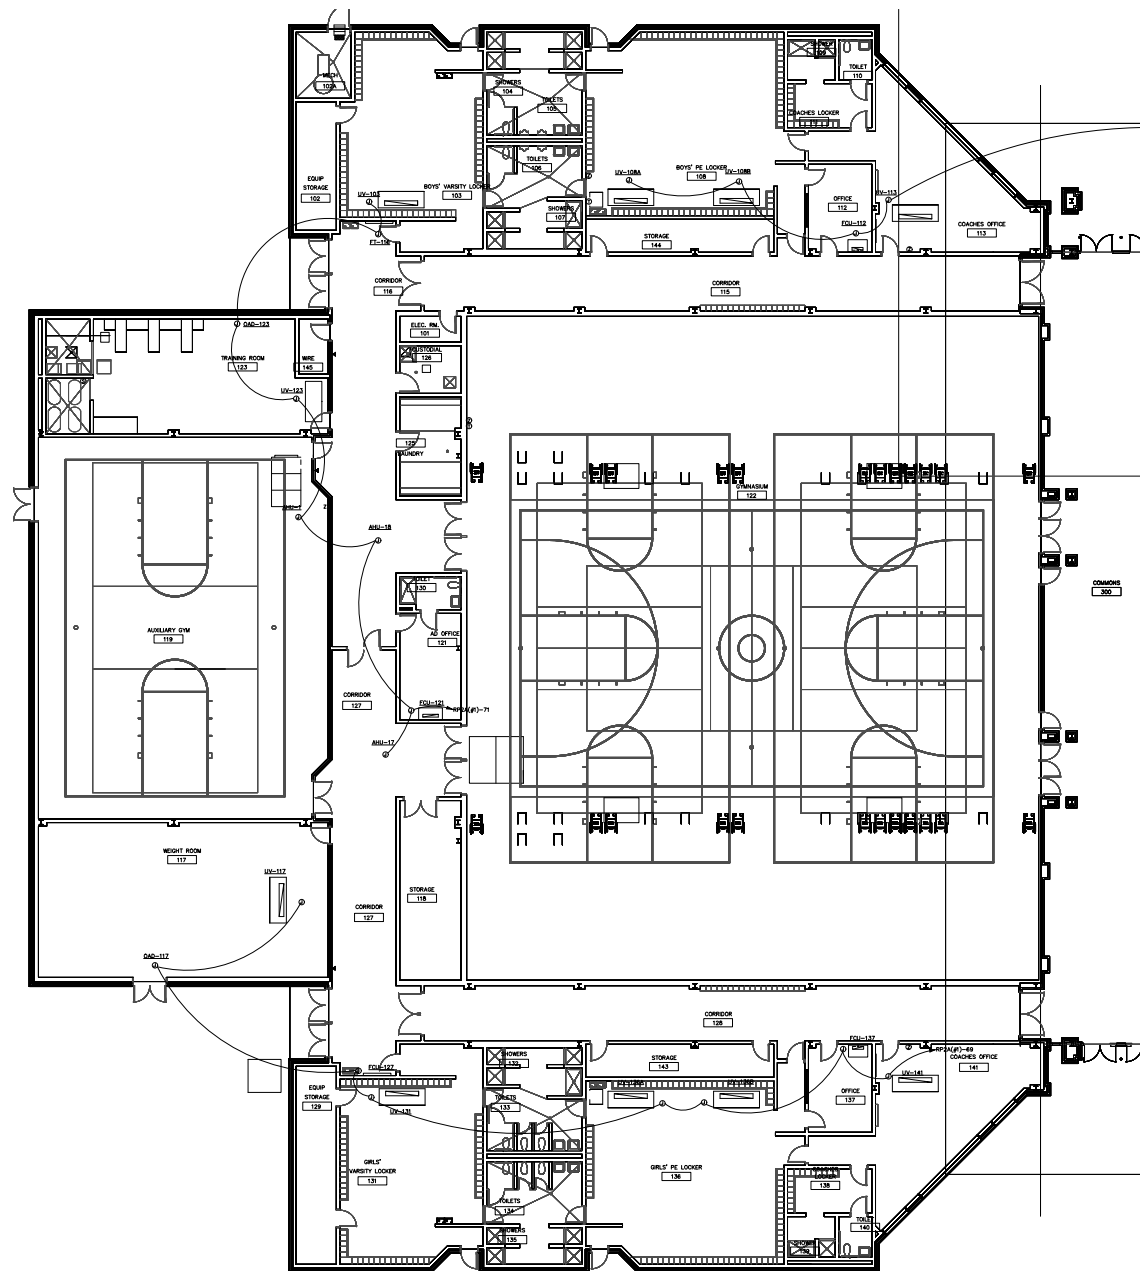

1 ELECTRICAL FLOOR PLAN - AREA 1 RENOVATION
1/8" = 1'-0"

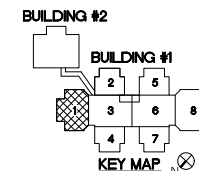


REV #	DATE	DESCRIPTION

DATE:	09-29-2022
PROJECT #:	22-0151
DRAWN BY:	SMT
DESIGNED BY:	SMT
CHECKED BY:	MAM


SHEET TITLE:
AREA 1
ELECTRICAL
FLOOR PLAN

DWG #:
E201
SHEET NO.: 3 of 16


THIS DRAWING IS AN INSTRUMENT OF SERVICE. THE OWNERS AND THE REGISTRAR HEREBY CERTIFY THAT THE INSTRUMENT OF SERVICE IS THE PROPERTY OF OPTIMA ENGINEERING, P.A. ANY REPRODUCTION, ALTERATION, OR USE FOR OTHER THAN THE INTENDED PROJECT WITHOUT THE WRITTEN CONSENT OF OPTIMA ENGINEERING, P.A. IS EXPRESSLY FORBIDDEN. COPYRIGHT © 2013 OPTIMA ENGINEERING, P.A.

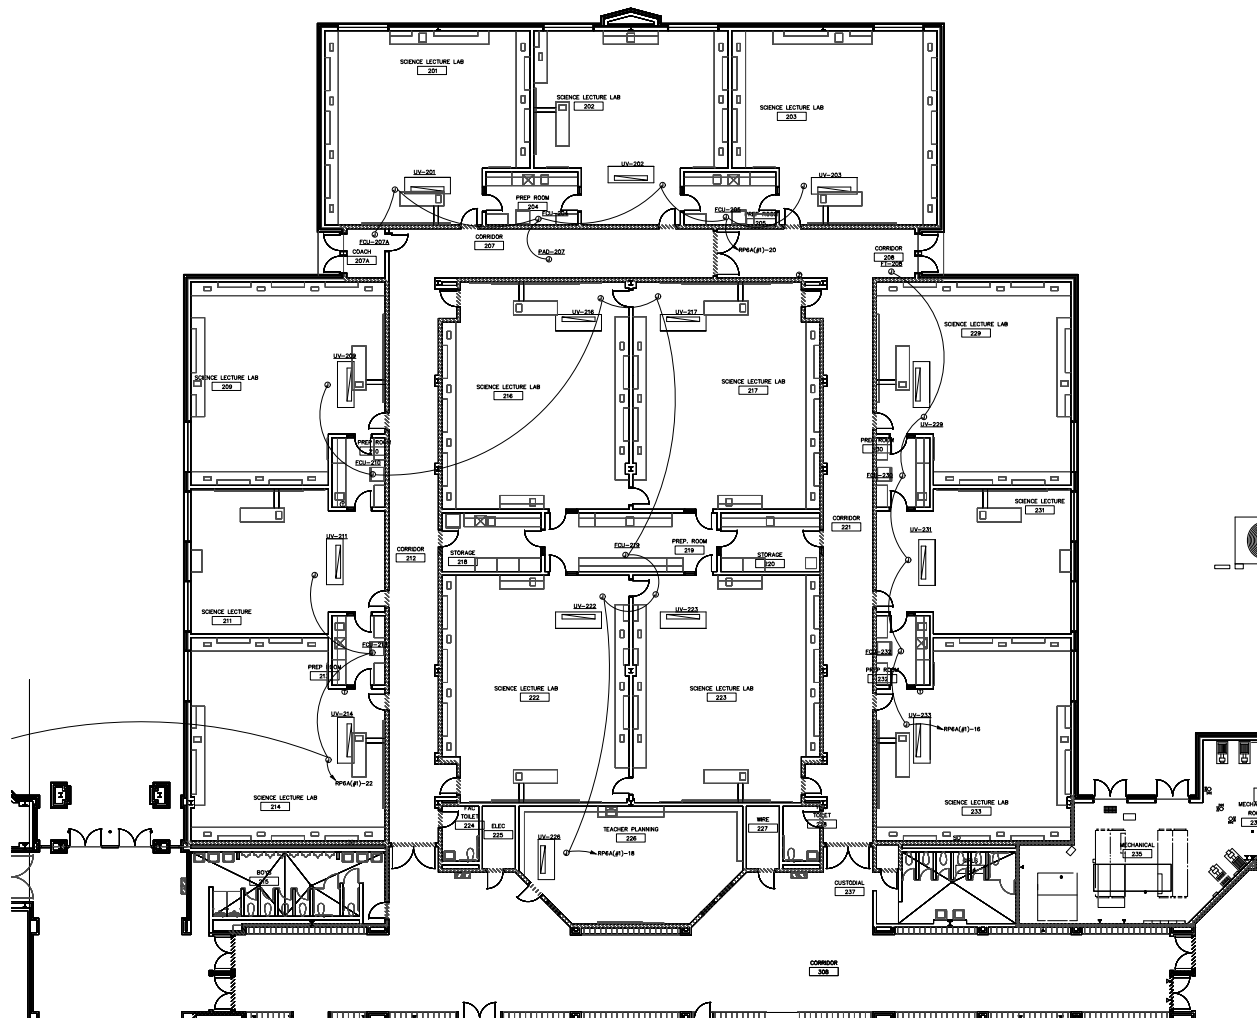


1 ELECTRICAL FLOOR PLAN - AREA 2 RENOVATION
1/8" = 1'-0"

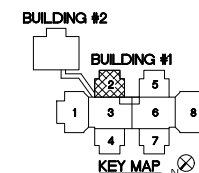


THIS DRAWING IS AN INSTRUMENT OF SERVICE. THE OWNERS AND THE ENGINEERING FIRM AGREE TO HOLD EACH OTHER HARMLESS FROM AND AGAINST ALL INTERESTS, DAMAGES, LOSSES, AND EXPENSES, INCLUDING REASONABLE ATTORNEY'S FEES, IN CONNECTION WITH THIS INSTRUMENT OF SERVICE. THE ENGINEERING FIRM SHALL BE RESPONSIBLE FOR THE DESIGN OF THE PROJECT WITHOUT THE INTERFERENCE OF THE ENGINEERING FIRM. ANY INTERFERENCE, ALTERATION, OR USE OF THIS DRAWING FOR ANY OTHER PROJECT WITHOUT THE WRITTEN CONSENT OF OPTIMA ENGINEERING, P.A. IS EXPRESSLY FORBIDDEN. COPYRIGHT © 2013 OPTIMA ENGINEERING, P.A.

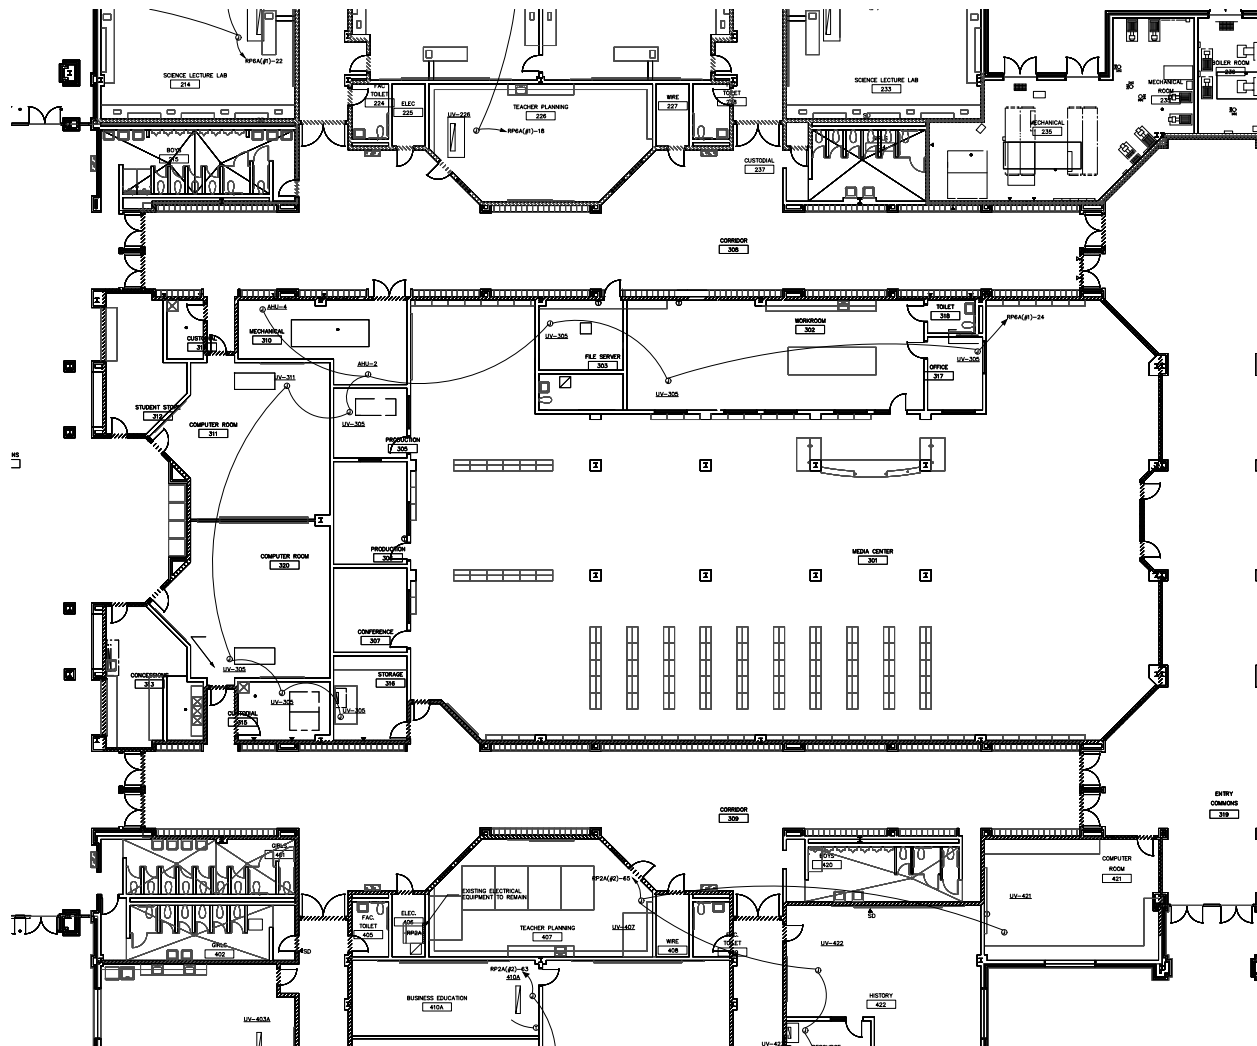

THIS DRAWING IS AN INSTRUMENT OF SERVICE. THE OWNERS AND THE REGISTRARS HEREBY ACKNOWLEDGE THE INSTRUMENT OF SERVICE. ANY REPRODUCTION, ALTERATION, OR USE FOR OTHER THAN THE INTENDED PROJECT WITHOUT THE WRITTEN CONSENT OF OPTIMA ENGINEERING, P.A. IS EXPRESSLY FORBIDDEN. COPYRIGHT © 2013 OPTIMA ENGINEERING, P.A.

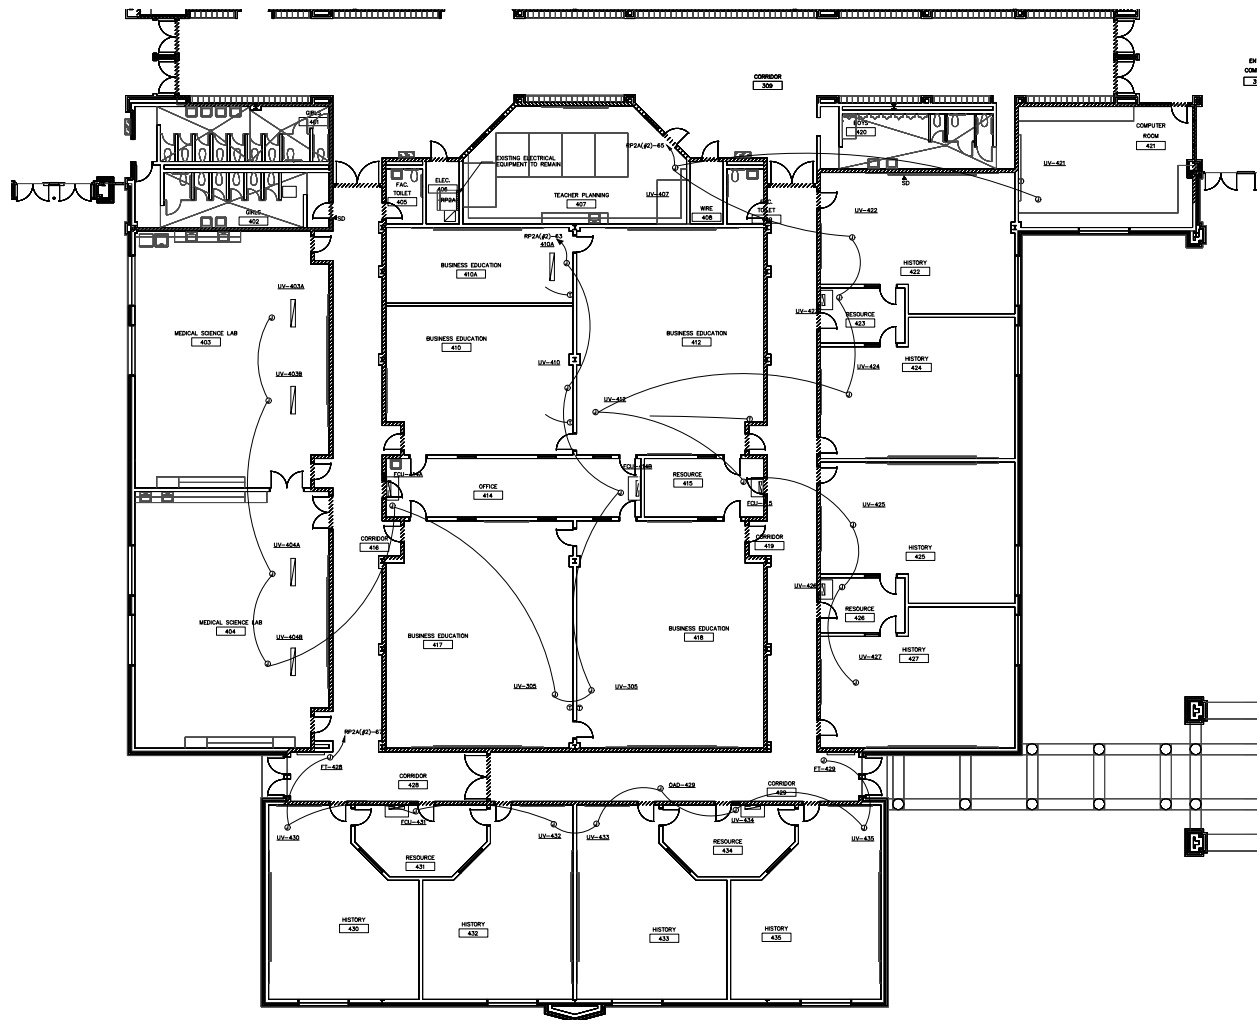

1 ELECTRICAL FLOOR PLAN - AREA 4 RENOVATION
1/8" = 1'-0"

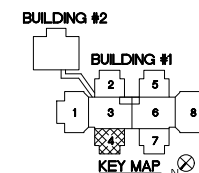

Mechanical • Electrical • Plumbing
Fire Protection • Lighting Design

1827 S. Iron St., Suite 200, Charlotte, NC 28203
704.366.1111 • Fax: 704.366.1112 • Email: info@optimaeng.com
North Carolina License Number: C00114

optima

SEAL:

REGISTERED PROFESSIONAL ENGINEER
STATE OF NORTH CAROLINA
EXPIRATION DATE: 6/30/2022

butler high school
HVAC CONTROLS UPGRADE

361 david butler high school
1810 matthews mint road
matthews, nc 28105


REV #	DATE	DESCRIPTION

DATE: 09-29-2022
PROJECT #: 22-0151
DRAWN BY: SMT
DESIGNED BY: SMT
CHECKED BY: MAM


SHEET TITLE:
AREA "4"
ELECTRICAL FLOOR PLAN

DWG #: E204
SHEET NO: 6 OF 16

Optima Engineering is an instrument of service. The drawings and the information hereon are the property of Optima Engineering, P.A. and are not to be reproduced, stored in a retrieval system, or transmitted in any form or by any means, electronic, mechanical, photocopying, recording, or by any information storage and retrieval system, without the prior written permission of Optima Engineering, P.A. ANY REPRODUCTION, ALTERATION, OR USE FOR ANY OTHER PROJECT WITHOUT THE WRITTEN CONSENT OF OPTIMA ENGINEERING, P.A. IS EXPRESSLY FORBIDDEN. COPYRIGHT © 2013 OPTIMA ENGINEERING, P.A.

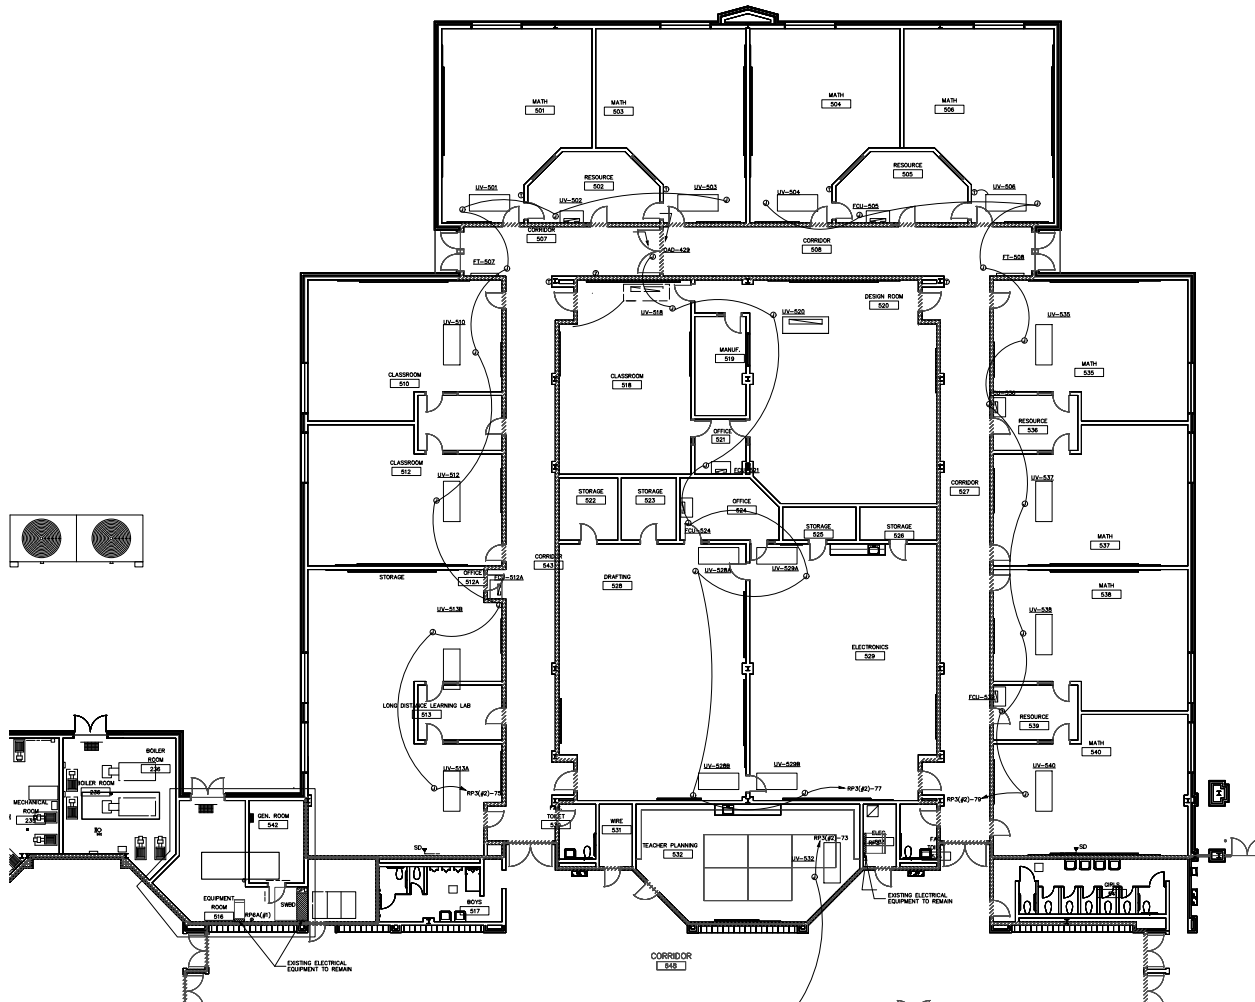

1 ELECTRICAL FLOOR PLAN - AREA 5 RENOVATION
1/8" = 1'-0"

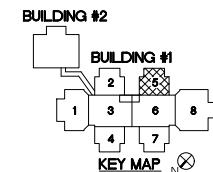

Optima Engineering
Mechanical • Electrical • Plumbing
Fire Protection • Lighting Design
1827 S. Tryon St., Suite 200, Charlotte, NC 28203
704.375.1111
North Carolina License Number: C00114

SEAL:
Professional Engineer
State of North Carolina
License Number: 10000
Date: 6/29/2022


butler high school
HVAC CONTROLS UPGRADE
361 david butler high school
1810 matthews-mint road
matthews, nc 28105

REV #	DATE	DESCRIPTION

DATE: 09-29-2022
PROJECT #: 22-0151
DRAWN BY: SMT
DESIGNED BY: SMT
CHECKED BY: MAM


SHEET TITLE:
AREA "5"
ELECTRICAL
FLOOR PLAN

DWG #: E205
SHEET NO: 7 of 16

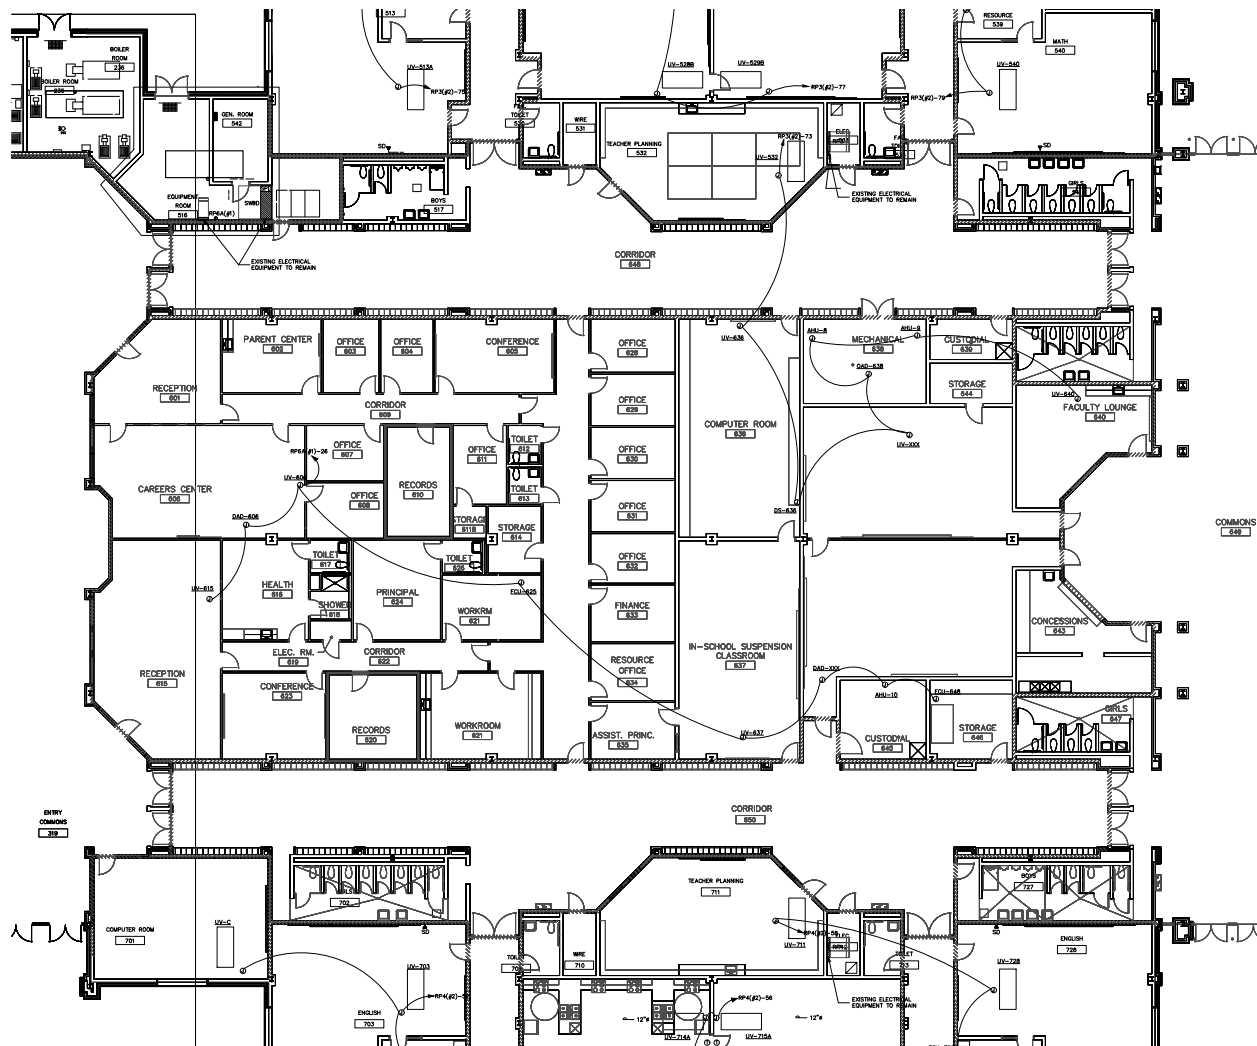

1 ELECTRICAL FLOOR PLAN - AREA 6 RENOVATION
1/8" = 1'-0"

BUILDING #2

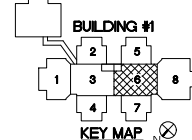

KEY MAP

Mechanical • Electrical • Plumbing
Fire Protection • Lighting Design
1827 S. Tryon St., Suite 200, Charlotte, NC 28203
704.375.1111
www.optimaengineering.com
North Carolina License Number: C00114



SEAL:



6/29/2022

butler high school
HVAC CONTROLS UPGRADE
361 david butler high school
1810 matthews mint road
matthews, nc 28105

REV # DATE DESCRIPTION


DATE:	09-29-2022
PROJECT #:	22-0151
DRAWN BY:	SMT
DESIGNED BY:	SMT
CHECKED BY:	MAM

SHEET TITLE:
AREA "6"
ELECTRICAL
FLOOR PLAN


DWG #
E206

SHEET NO: 8 of 16

THIS DRAWING IS AN INSTRUMENT OF SERVICE. THE DRAWING AND THE INFORMATION HEREON IS THE PROPERTY OF OPTIMA ENGINEERING, P.A. ANY REPRODUCTION, ALTERATION, OR USE FOR OTHER THAN THE INTENDED PROJECT WITHOUT THE WRITTEN CONSENT OF OPTIMA ENGINEERING, P.A. IS EXPRESSLY FORBIDDEN. COPYRIGHT © 2012 OPTIMA ENGINEERING, P.A.

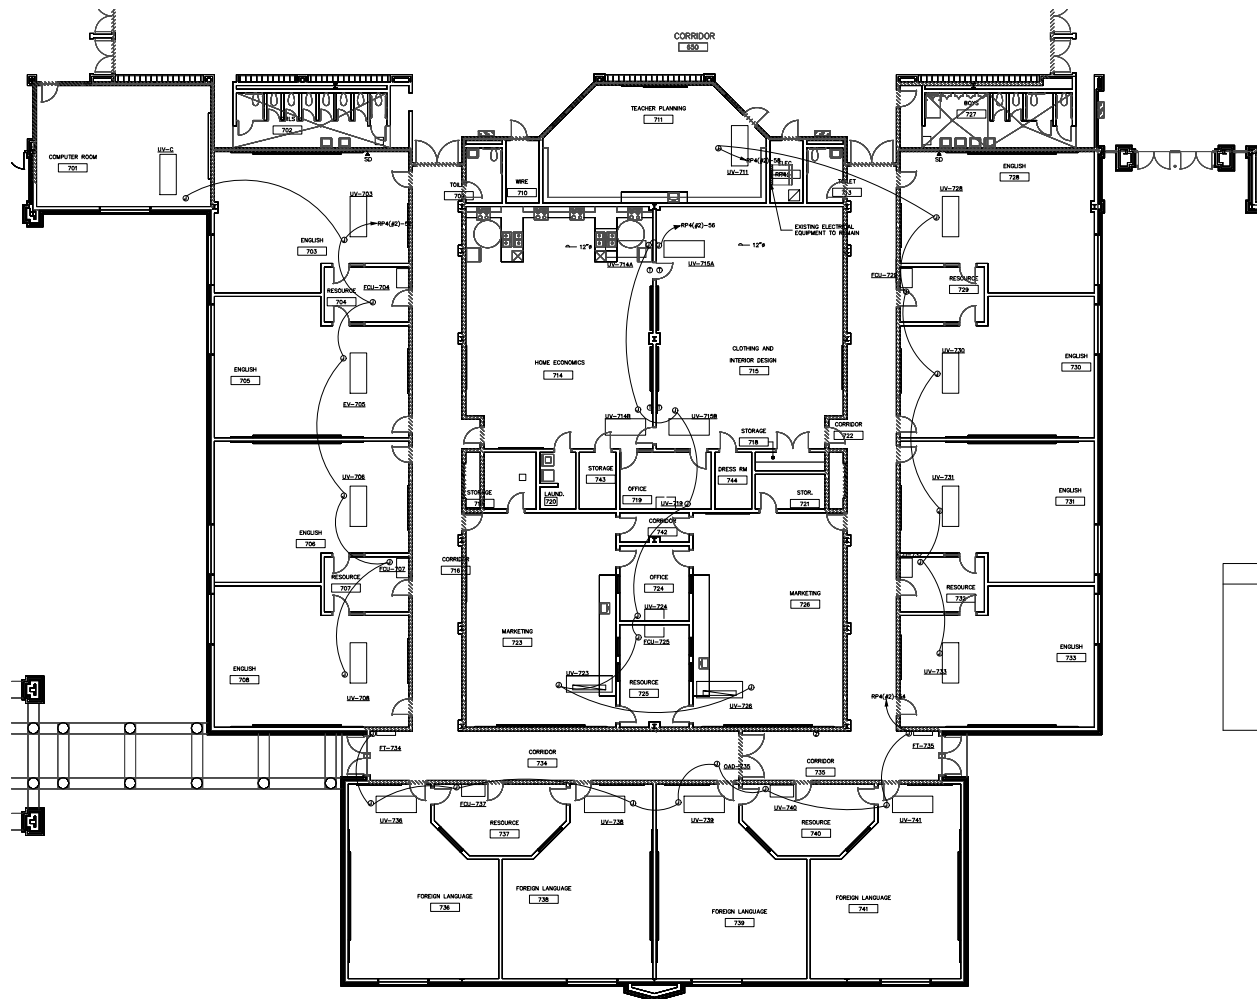

1 ELECTRICAL FLOOR PLAN - AREA 7 RENOVATION
1/8" = 1'-0"

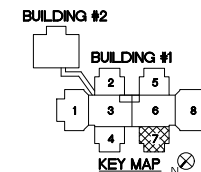

Mechanical • Electrical • Plumbing
Fire Protection • Lighting Design

optima

1827 S. Tryon St., Suite 200, Charlotte, NC 28203
704.375.1111 • Fax: 704.375.1112 • Email: info@optimaeng.com
North Carolina License Number: C00114

SEAL:

6/29/2022

butler high school
HVAC CONTROLS UPGRADE

361 David Butler High School
1810 Matthews-Mint Road
Matthews, NC 28105

REV #	DATE	DESCRIPTION


DATE: 09-29-2022
PROJECT #: 22-0151
DRAWN BY: SMT
DESIGNED BY: SMT
CHECKED BY: MAM

SHEET TITLE:
AREA 7
ELECTRICAL
FLOOR PLAN


DWG #:
E207

SHEET NO: 9 of 16

Optima Engineering is an instrument of service. The drawings and the information hereon is the property of Optima Engineering, P.A. and introduction, alteration, reuse or other use without the written consent of Optima Engineering, P.A. is expressly forbidden. Copyright © 2013 Optima Engineering, P.A.

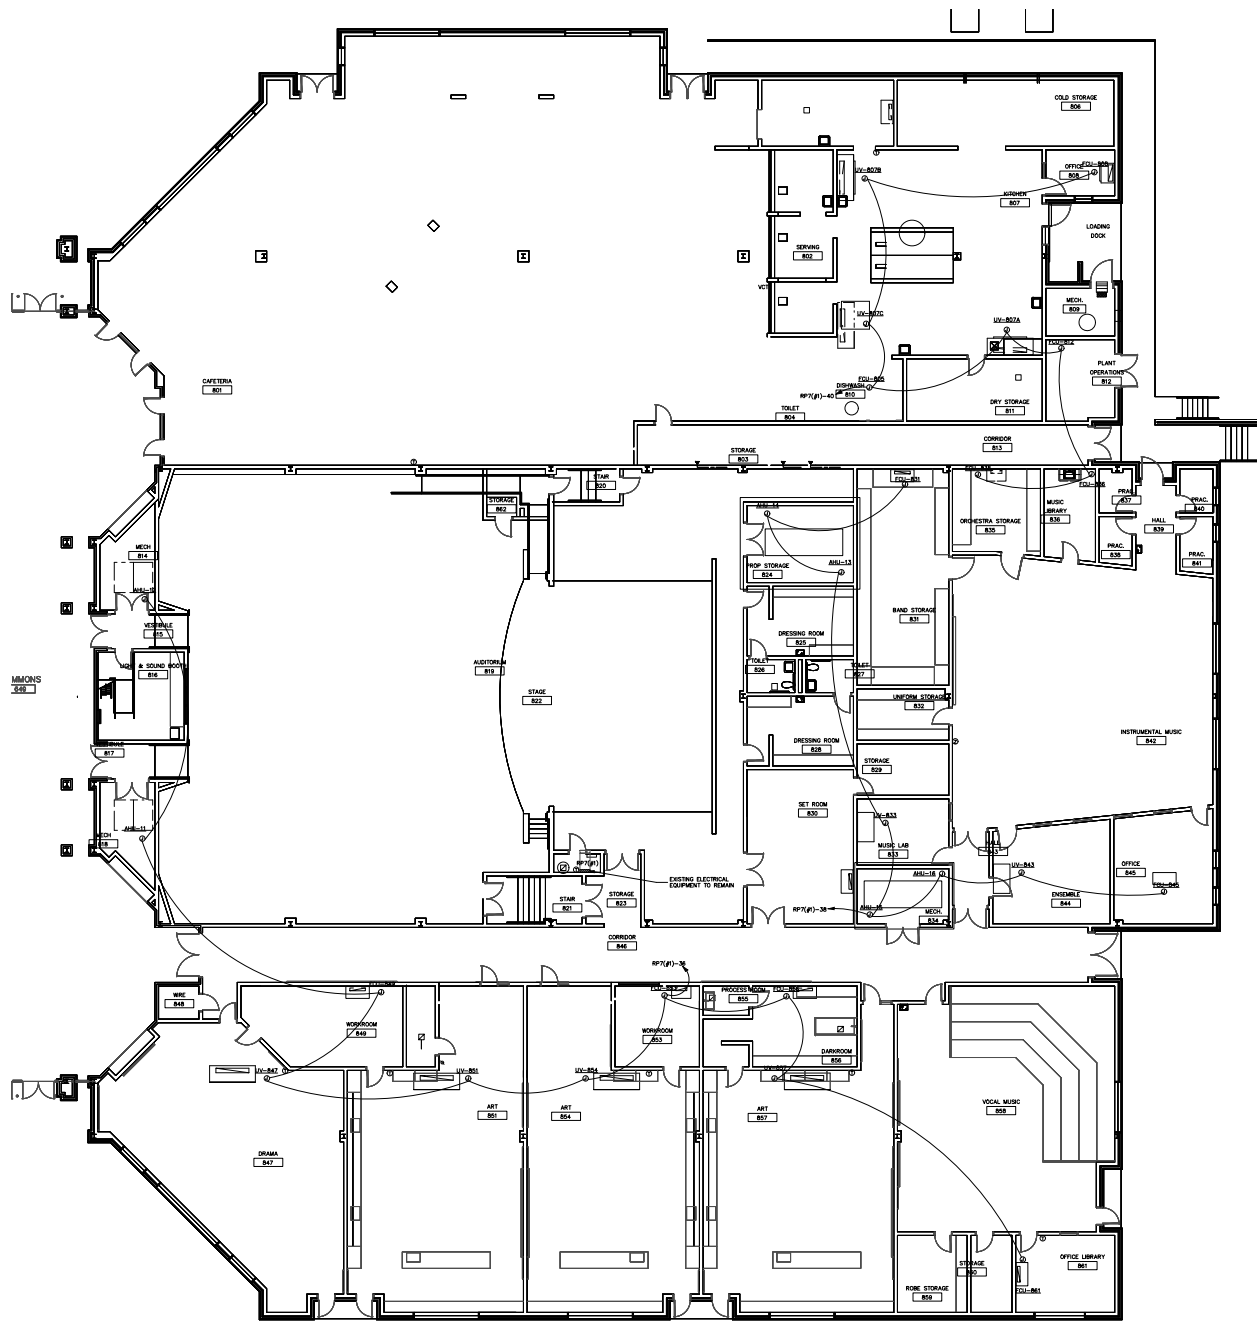

1 ELECTRICAL FLOOR PLAN - AREA 8 RENOVATION
1/8" = 1'-0"

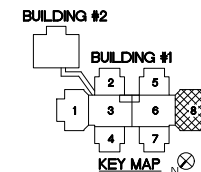

Mechanical • Electrical • Plumbing
Fire Protection • Lighting Design
1827 S. Tryon St., Suite 200, Charlotte, NC 28203
704.375.1111
North Carolina License Number: C00114




butler high school
HVAC CONTROLS UPGRADE
1810 matthews-mint road
matthews, nc 28105

REV #	DATE	DESCRIPTION


DATE: 09-29-2022
PROJECT #: 22-0151
DRAWN BY: SMT
DESIGNED BY: SMT
CHECKED BY: MAM

SHEET TITLE:
AREA "8"
ELECTRICAL
FLOOR PLAN

DWG #:
E208
SHEET NO: 10 of 16

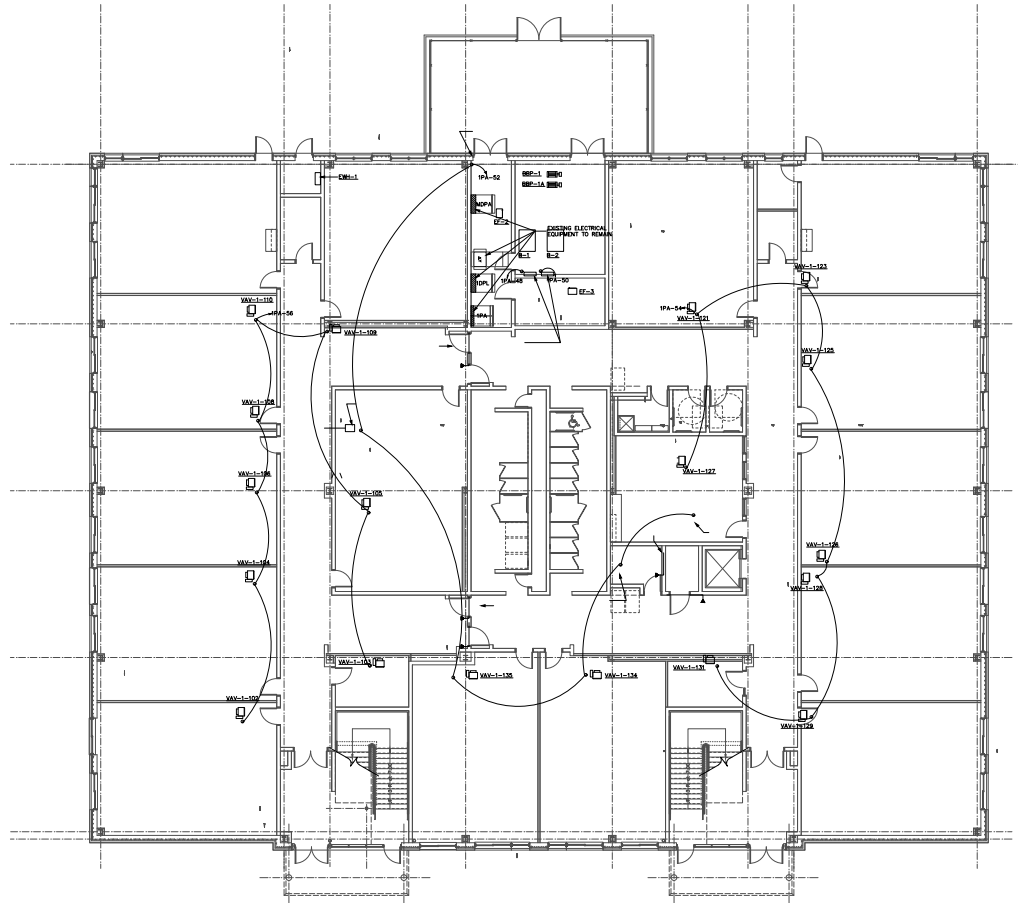

1 ELECTRICAL FLOOR PLAN - BUILDING #2 FIRST FLOOR ELECTRICAL PLAN
1/8" = 1'-0"

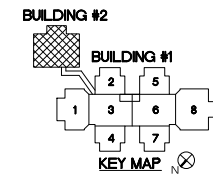


REV #	DATE	DESCRIPTION

DATE:	09-29-2022
PROJECT #:	22-0151
DRAWN BY:	SMT
DESIGNED BY:	SMT
CHECKED BY:	MAM


SHEET TITLE:
BUILDING #2
FLOOR 1
ELECTRICAL
FLOOR PLAN

DWG #:
E209
SHEET NO: 11 of 16

THIS DRAWING IS AN INSTRUMENT OF SERVICE. THE DRAWING AND THE INFORMATION HEREON IS THE PROPERTY OF OPTIMA ENGINEERING, P.A. ANY REPRODUCTION, ALTERATION, OR USE FOR OTHER THAN THE INTENDED PROJECT WITHOUT THE WRITTEN CONSENT OF OPTIMA ENGINEERING, P.A. IS EXPRESSLY FORBIDDEN. COPYRIGHT © 2013 OPTIMA ENGINEERING, P.A.

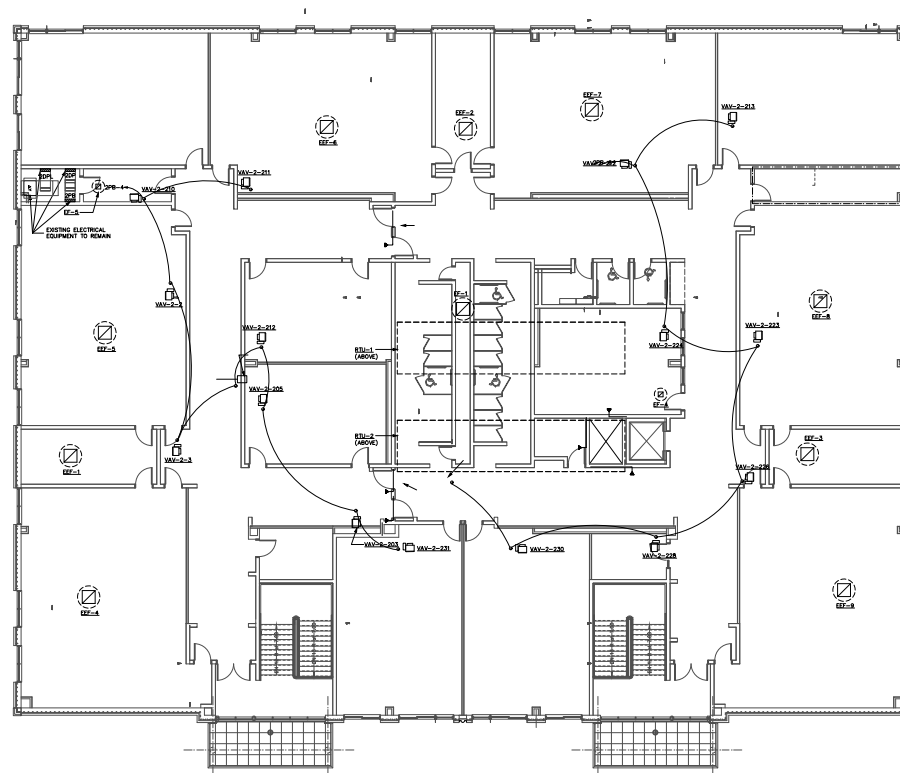

1 ELECTRICAL FLOOR PLAN - BUILDING #2 SECOND FLOOR ELECTRICAL PLAN
1/8" = 1'-0"

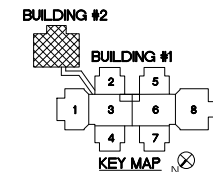


REV #	DATE	DESCRIPTION

DATE:	09-29-2022
PROJECT #:	22-0151
DRAWN BY:	SMT
DESIGNED BY:	SMT
CHECKED BY:	MAM

SHEET TITLE:	BUILDING #2 FLOOR 2 ELECTRICAL FLOOR PLAN
--------------	--


DWG #:	E210
SHEET NO:	13 of 16

OPTIMA ENGINEERING, P.A. IS AN INSTRUMENT OF SERVICE. THE DRAWING AND THE INFORMATION HEREON IS THE PROPERTY OF OPTIMA ENGINEERING, P.A. ANY REPRODUCTION, ALTERATION, OR USE FOR ANY OTHER PROJECT WITHOUT THE WRITTEN CONSENT OF OPTIMA ENGINEERING, P.A. IS EXPRESSLY FORBIDDEN. COPYRIGHT © 2013 OPTIMA ENGINEERING, P.A.

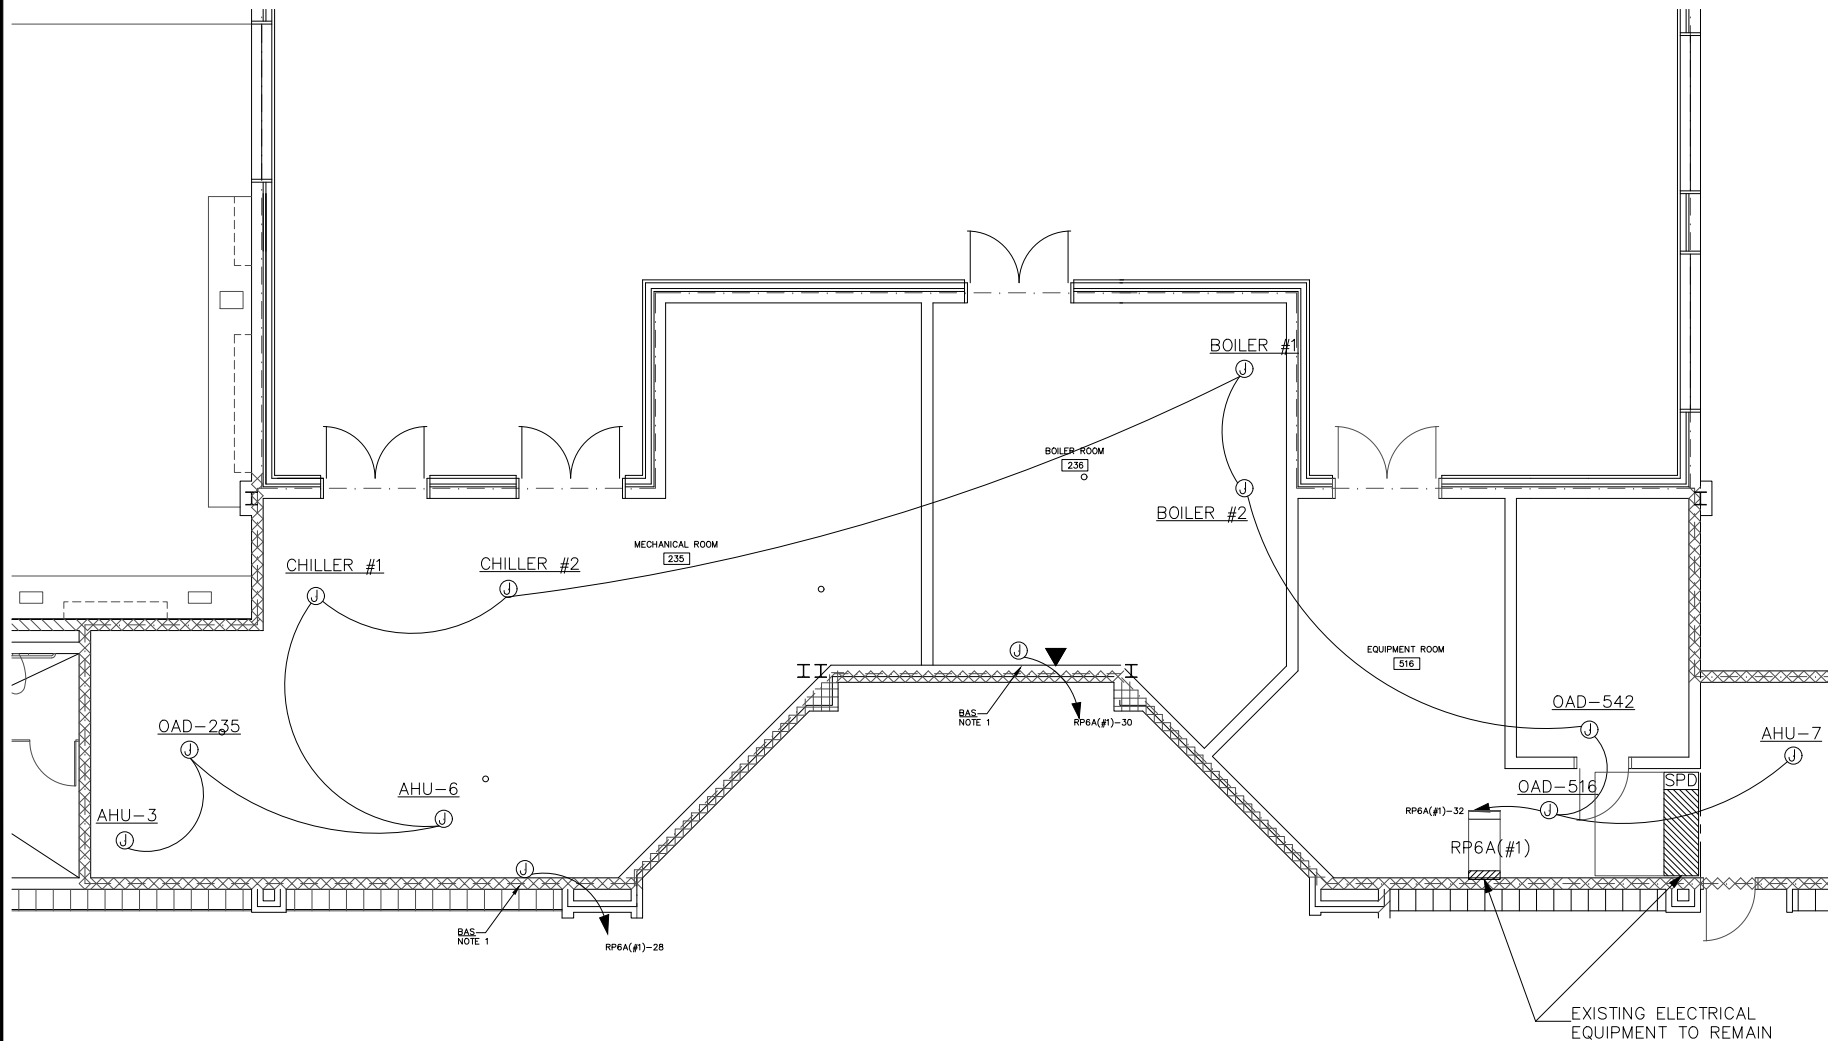

NOTES:
 EXISTING PANEL WILL BE REMOVED, BAS PANEL WILL BE INSTALLED. EXISTING PANEL POWER AND DATA WILL BE USED FOR THE BAS PANEL.

1 ELECTRICAL FLOOR PLAN - BOILER/CHILLER ROOM
 1/16" = 1'-0"

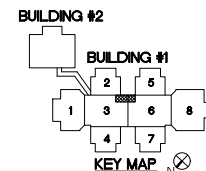

REV #	DATE	DESCRIPTION

DATE:	09-29-2022
PROJECT #:	22-0151
DRAWN BY:	SMT
DESIGNED BY:	SMT
CHECKED BY:	MAM

SHEET TITLE:
 ELECTRICAL
 ENLARGED
 BOILER/MECH
 ROOM PLANS

DWG #:
E262
 SHEET NO: 13 of 16

[illegible]

PANEL: RPA(1/1)														PANEL: RP7(1/1)													
VOLTAGE				120 / 208				3 PHASE		4 WIRE		EXTRA MISC		VOLTAGE				120 / 208				3 PHASE		4 WIRE		EXTRA MISC	
MOUNTING SURFACE				SURFACE				NO		HINT		CHUCK BREAKER		MOUNTING SURFACE				SURFACE				NO		HINT		CHUCK BREAKER	
LOAD	NO	TYPE	WIRE	TERMINAL	WIRE	TERMINAL	WIRE	TERMINAL	WIRE	TERMINAL	WIRE	TERMINAL	WIRE	TERMINAL	LOAD	NO	TYPE	WIRE	TERMINAL	WIRE	TERMINAL	WIRE	TERMINAL	WIRE	TERMINAL	WIRE	TERMINAL
LOAD BEARER														LOAD BEARER													
REC COMPUTER ROOM(1) 1.21	20	EX-1	N/A	N/A	20	EX-1	N/A	N/A	20	EX-1	N/A	N/A	20	EX-1	REC ROOM(1) 1.21	20	EX-1	N/A	N/A	20	EX-1	N/A	N/A	20	EX-1	N/A	N/A
REC COMPUTER ROOM(1) 1.22	20	EX-1	N/A	N/A	20	EX-1	N/A	N/A	20	EX-1	N/A	N/A	20	EX-1	REC ROOM(1) 1.22	20	EX-1	N/A	N/A	20	EX-1	N/A	N/A	20	EX-1	N/A	N/A
REC COMPUTER ROOM(1) 1.23	20	EX-1	N/A	N/A	20	EX-1	N/A	N/A	20	EX-1	N/A	N/A	20	EX-1	REC ROOM(1) 1.23	20	EX-1	N/A	N/A	20	EX-1	N/A	N/A	20	EX-1	N/A	N/A
REC COMPUTER ROOM(1) 1.76	20	EX-1	N/A	N/A	20	EX-1	N/A	N/A	20	EX-1	N/A	N/A	20	EX-1	REC ROOM(1) 1.76	20	EX-1	N/A	N/A	20	EX-1	N/A	N/A	20	EX-1	N/A	N/A

**Mechanical • Electrical • Plumbing
Fire Protection • Lighting Design**

optima
INCORPORATED

1927 S. Truitt St., Suite 301, Raleigh, NC 27603
3333 W. Hargett St., Suite 311, Raleigh, NC 27607
Phone: 919-876-1000 Fax: 919-876-1001
www.optima-inc.com License Number: C0913

butler high school
HVAC CONTROLS UPGRADE

361 david butler high school
1810 matthews-mint road
matthews, nc 28105

REV #	DATE	DESCRIPTK
-------	------	-----------

DATE: 09-29-202
PROJECT #: 22-015
DRAWN BY: SM
DESIGNED BY: SM
CHECKED BY: MA

SHEET TITLE:

YAG #:

SHEET NO: 15 of 1

[illegible][illegible]

1 POWER RISER DIAGRAM

PANEL DESIGNATION	MDPA
VOLTAGE	277/480V
AMPERAGE	800A
DESIGNED LOAD CAP (KVA)	532
EXISTING LOAD (KVA)	418
INCREASING LOAD (KVA)	19

PANEL DESIGNATION	2CP
VOLTAGE	277/480V
AMPERAGE	600A
DESIGNED LOAD CAP (KVA)	399
EXISTING LOAD (KVA)	329
INCREASING LOAD (KVA)	19

g
Mechanical • Electrical • Plumbing
Fire Protection • Lighting Design

1927 S. Tryon St., Suite 300, Charlotte NC 28203
333 Fayetteville St., Suite 311, Raleigh NC 27601
Phone: 704-338-1292 www.optimesengineering.com
North Carolina License Number C-09114



SEAL:



1/29/2022

butler high school
HVAC CONTROLS UPGRADE

REV #	DATE	DESCRIPTION
-------	------	-------------

DATE: 09-29-2022
PROJECT #: 22-0151
DRAWN BY: SMT
DESIGNED BY: SMT
CHECKED BY: MAM

SHEET TITLE:
2ND BUILDING
POWER RISER
DIAGRAM &
SCHEDULES

DIANE A.

E702

SHEET NO: 16 of 16